


NOTES

SYMBOL	DESCRIPTION
	Drainage Pipe
	Storm Pipe
	Soil Vent Pipe
	Waste Vent Pipe
	In Floor Slab
	Chased in Wall
	Roding Eye
	From Above
	To Below
	Floor Trap
	Gully trap
	Manhole

revisions:

Client **MINISTRY OF HEALTH / ENABEL**

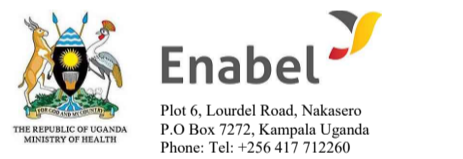

Job Title
PUBLIC SERVICES CONTRACT FOR CONSULTANCY SERVICES FOR DESIGN AND SUPERVISION OF WORKS FOR CALL & DISPATCH CENTRE IN ARUA REGIONAL

STUDIONE DESIGN GROUP Ltd

P.O. Box 24733, AGIP HOUSE, ROOM 33, JINJA ROAD
KAMPALA, UGANDA
TEL: +256 079 211 711
E-mail: info@studionedg.com
Web: www.studionedg.com


ARCHITECTURE * PROJECT MANAGEMENT * ENGINEERING

Drawing Name
**MECHANICAL INSTALLATION DESIGN
FOUL WATER DRAINAGE LAYOUT: FLOOR PLANS**

Drawn by NI	Checked by ES
Date MARCH 2023	Scale 1:100 @A1
Revision	Drawing No. M01


Arch. Ssinabulya Emmanuel

ARC Reg No. 223 PC No. 2925

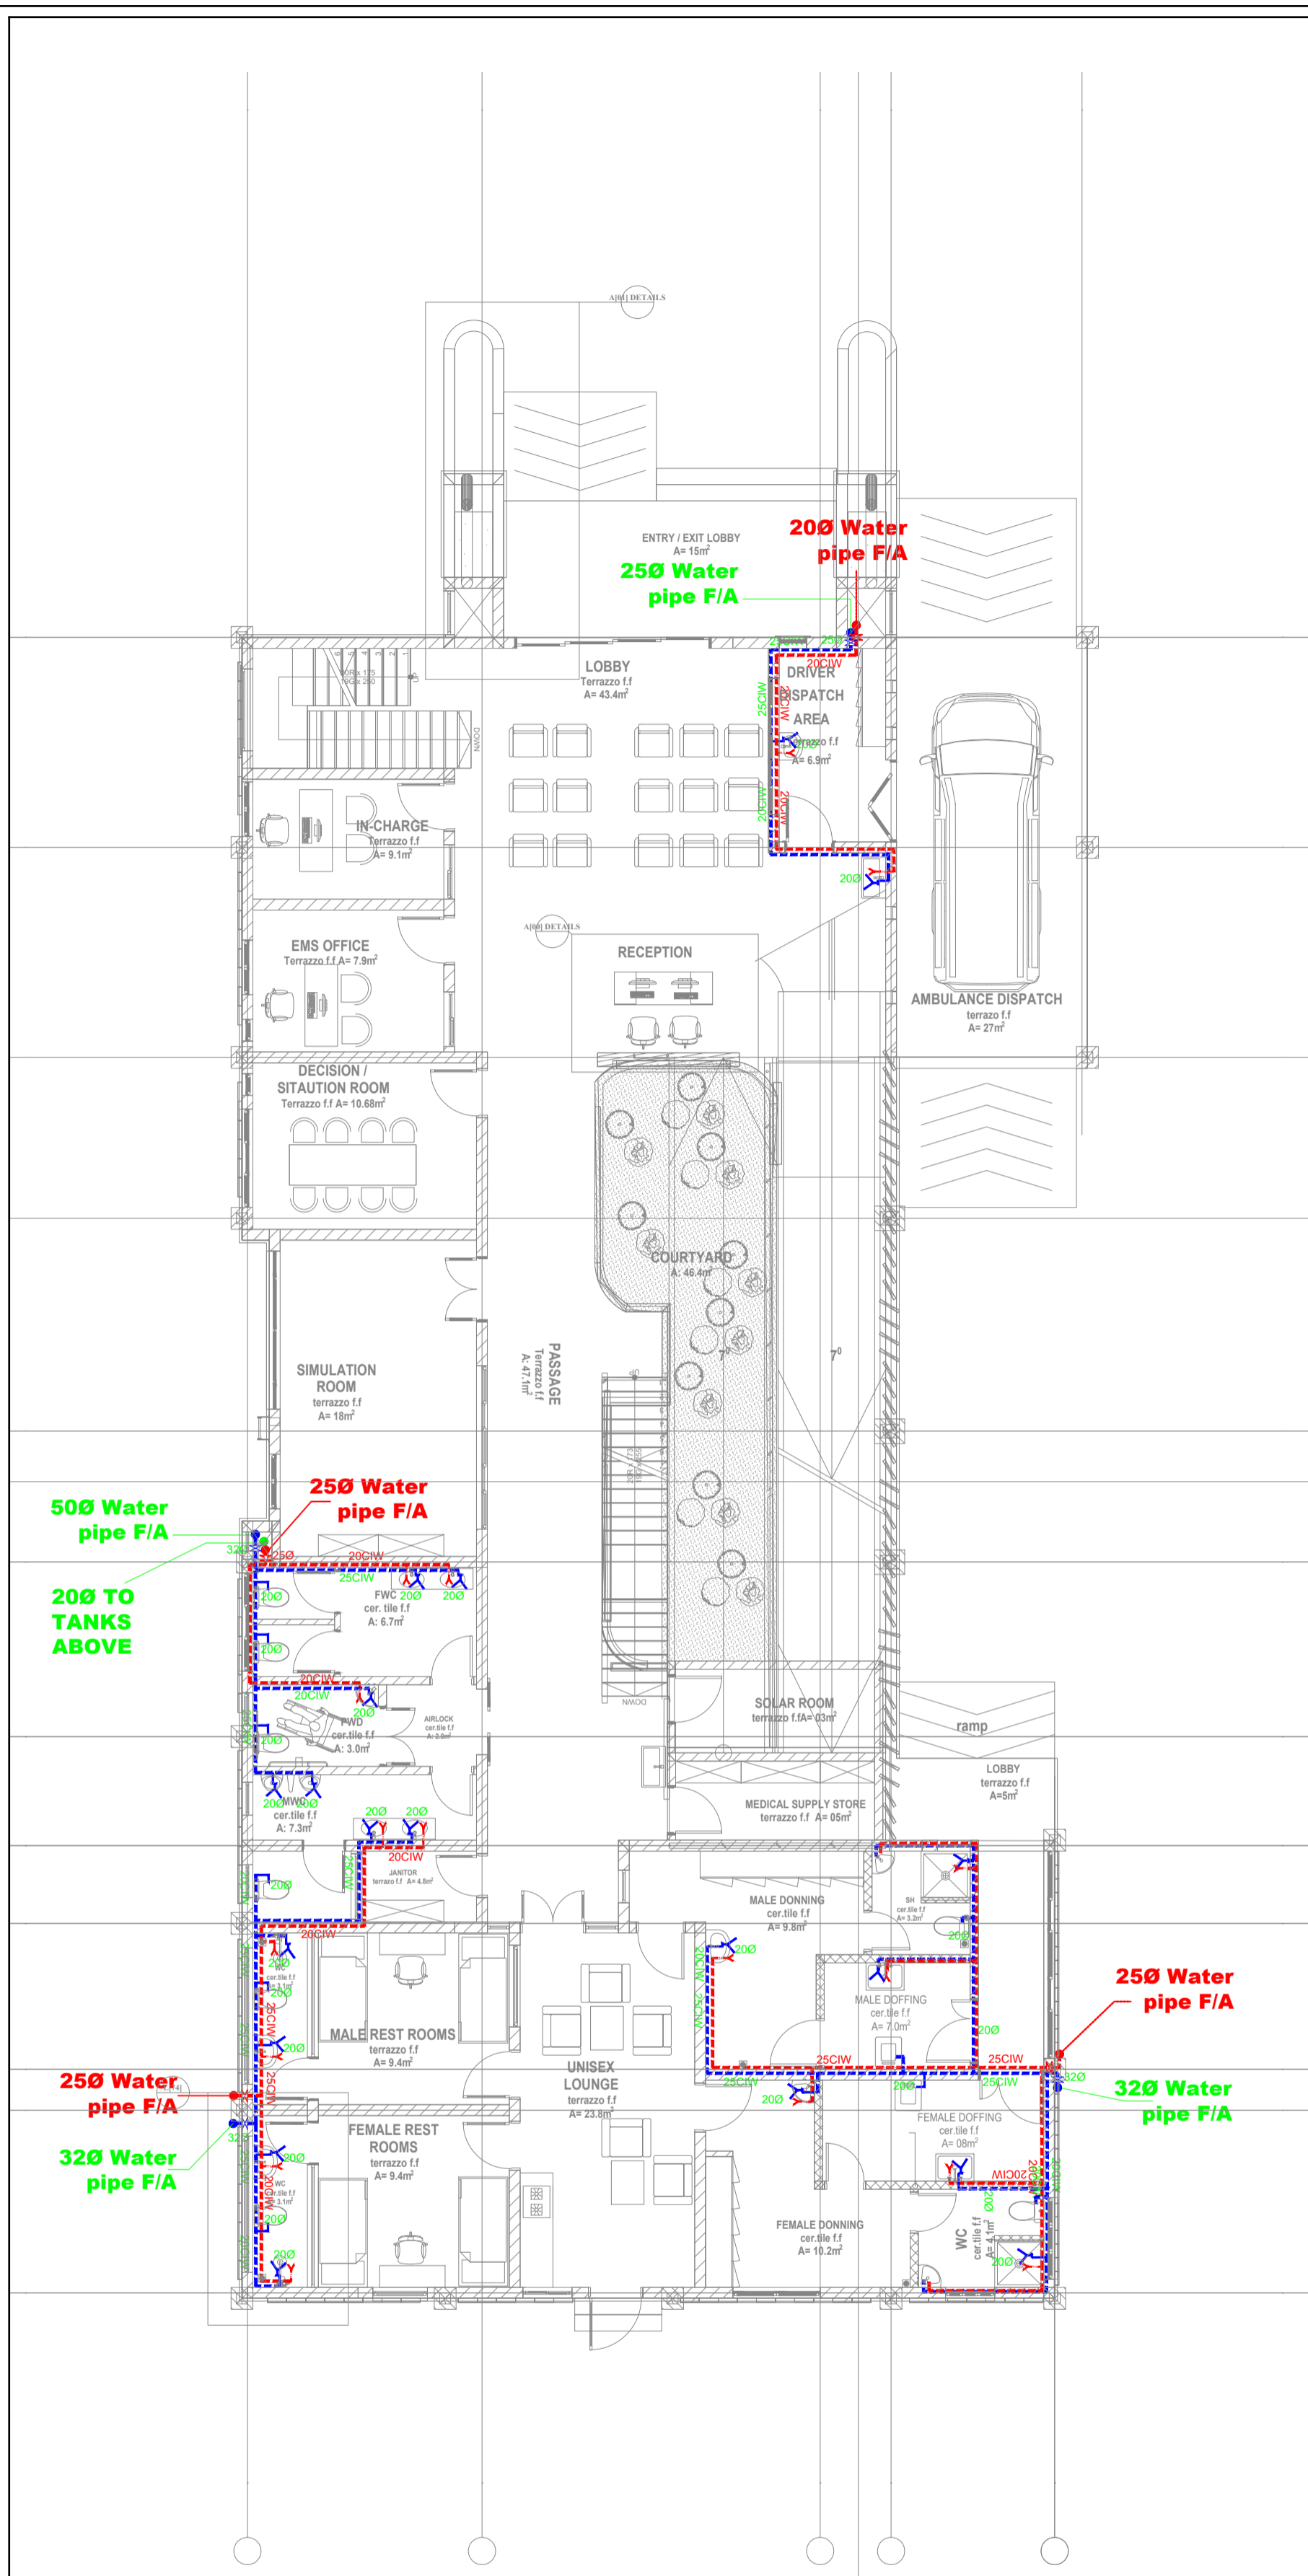


[--] 100 GROUND FLOOR PLAN

Scale 1:100

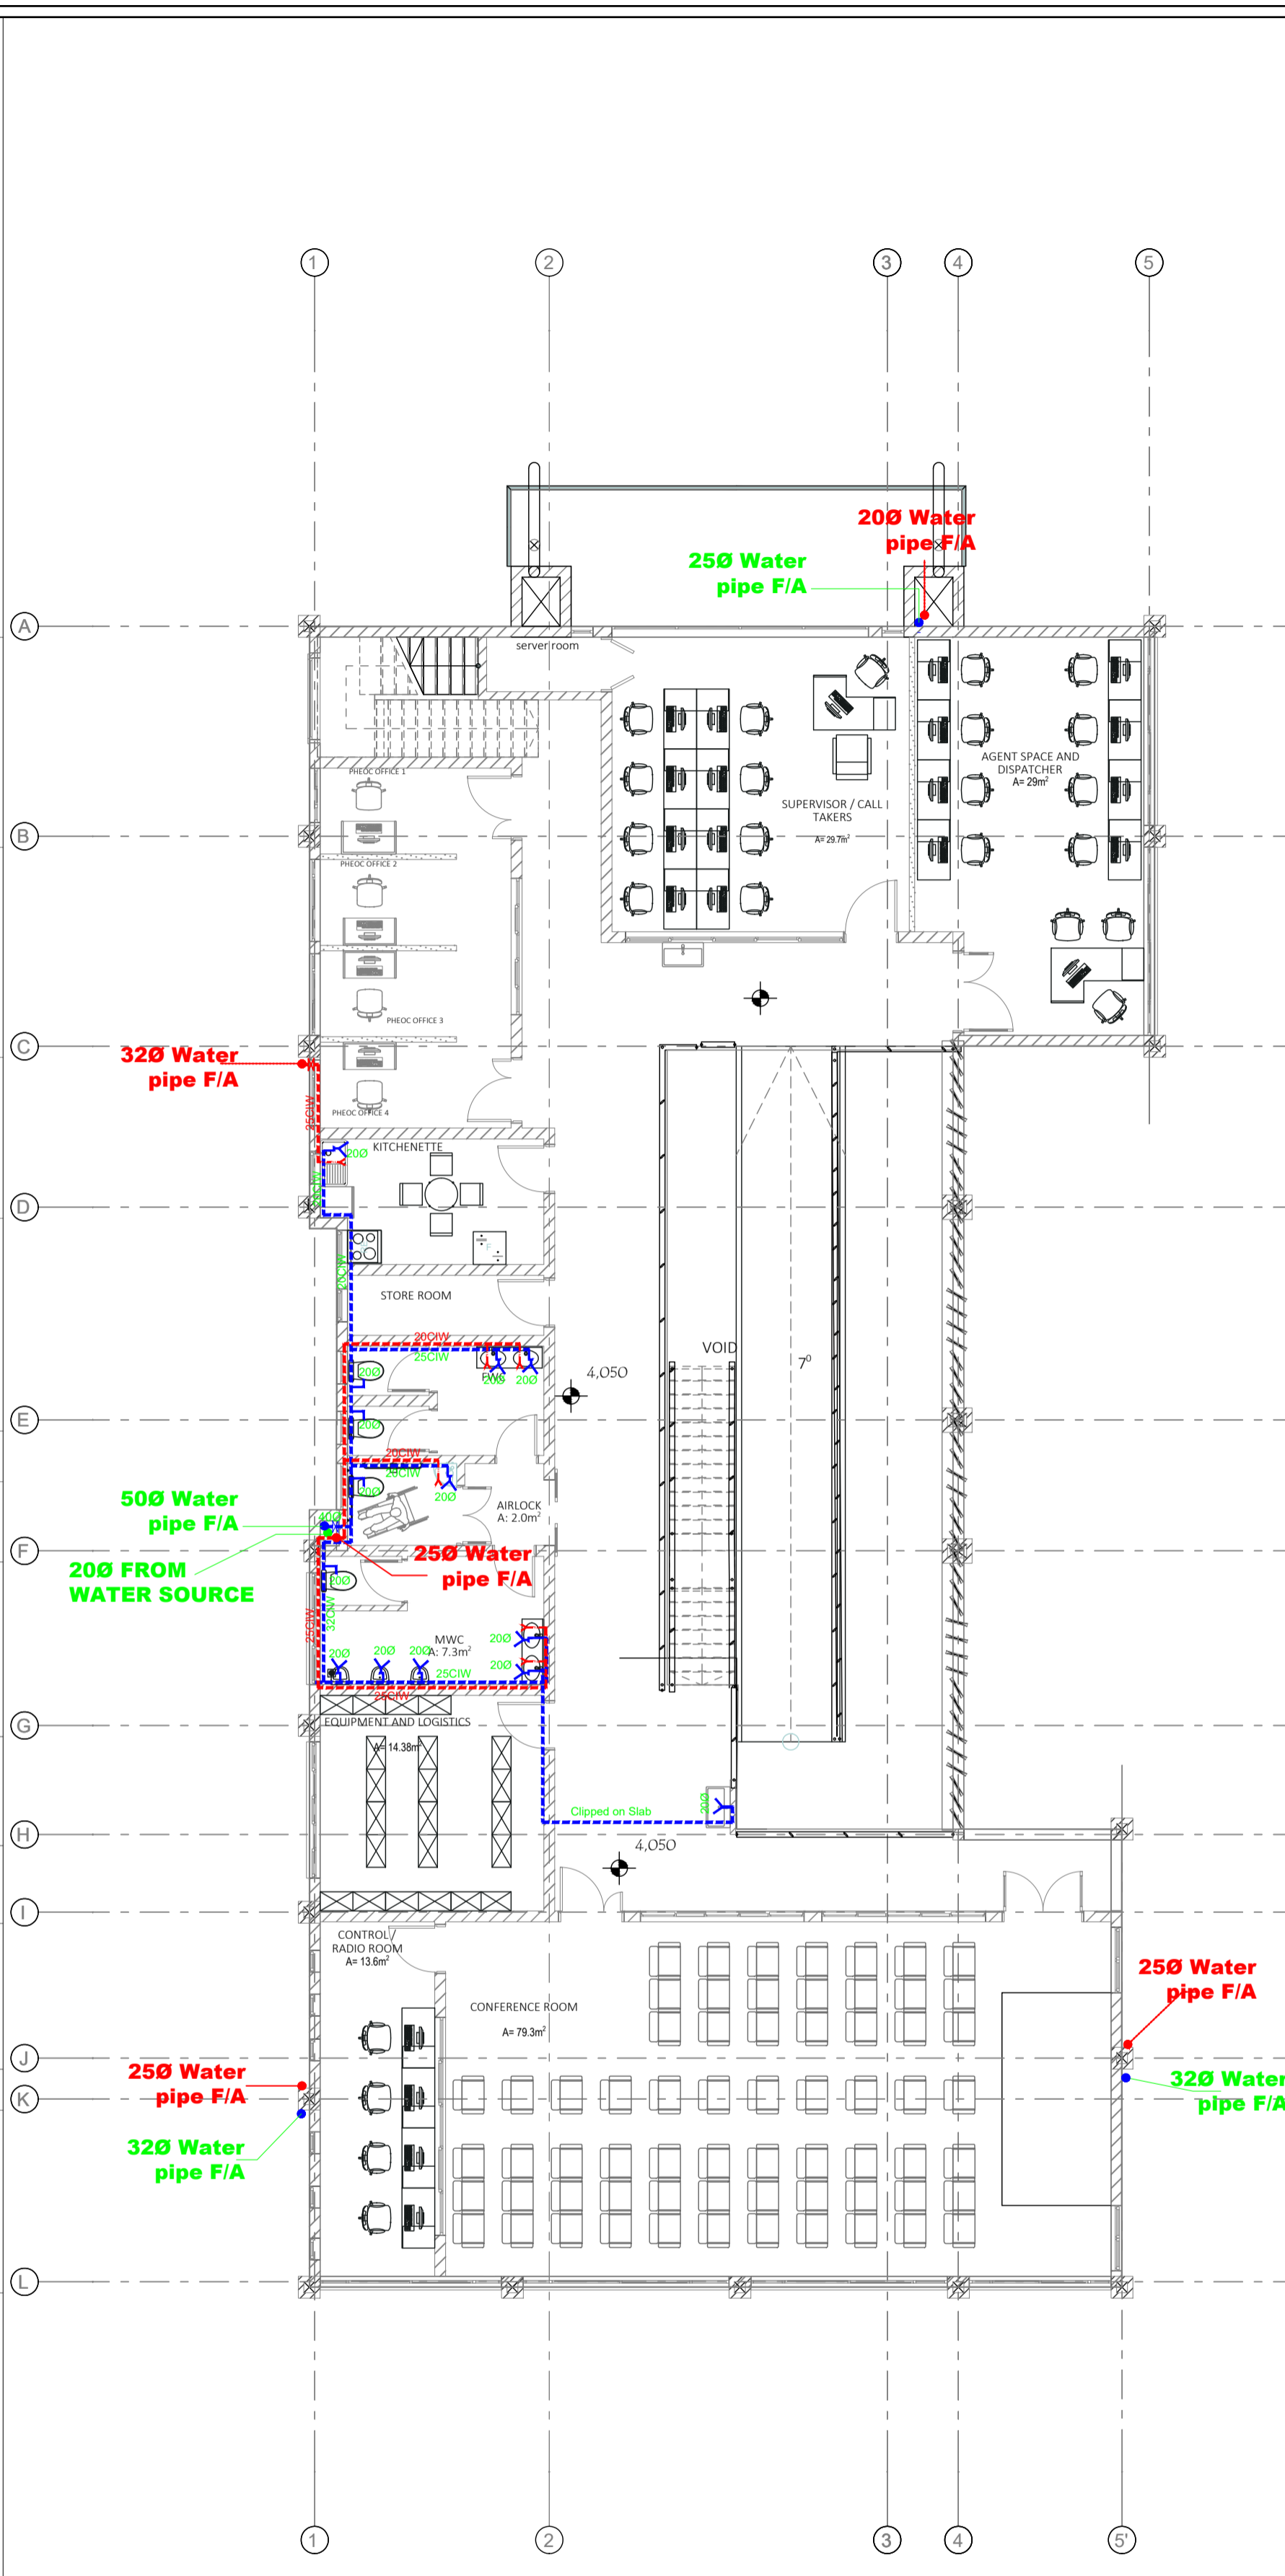

FIRST FLOOR PLAN

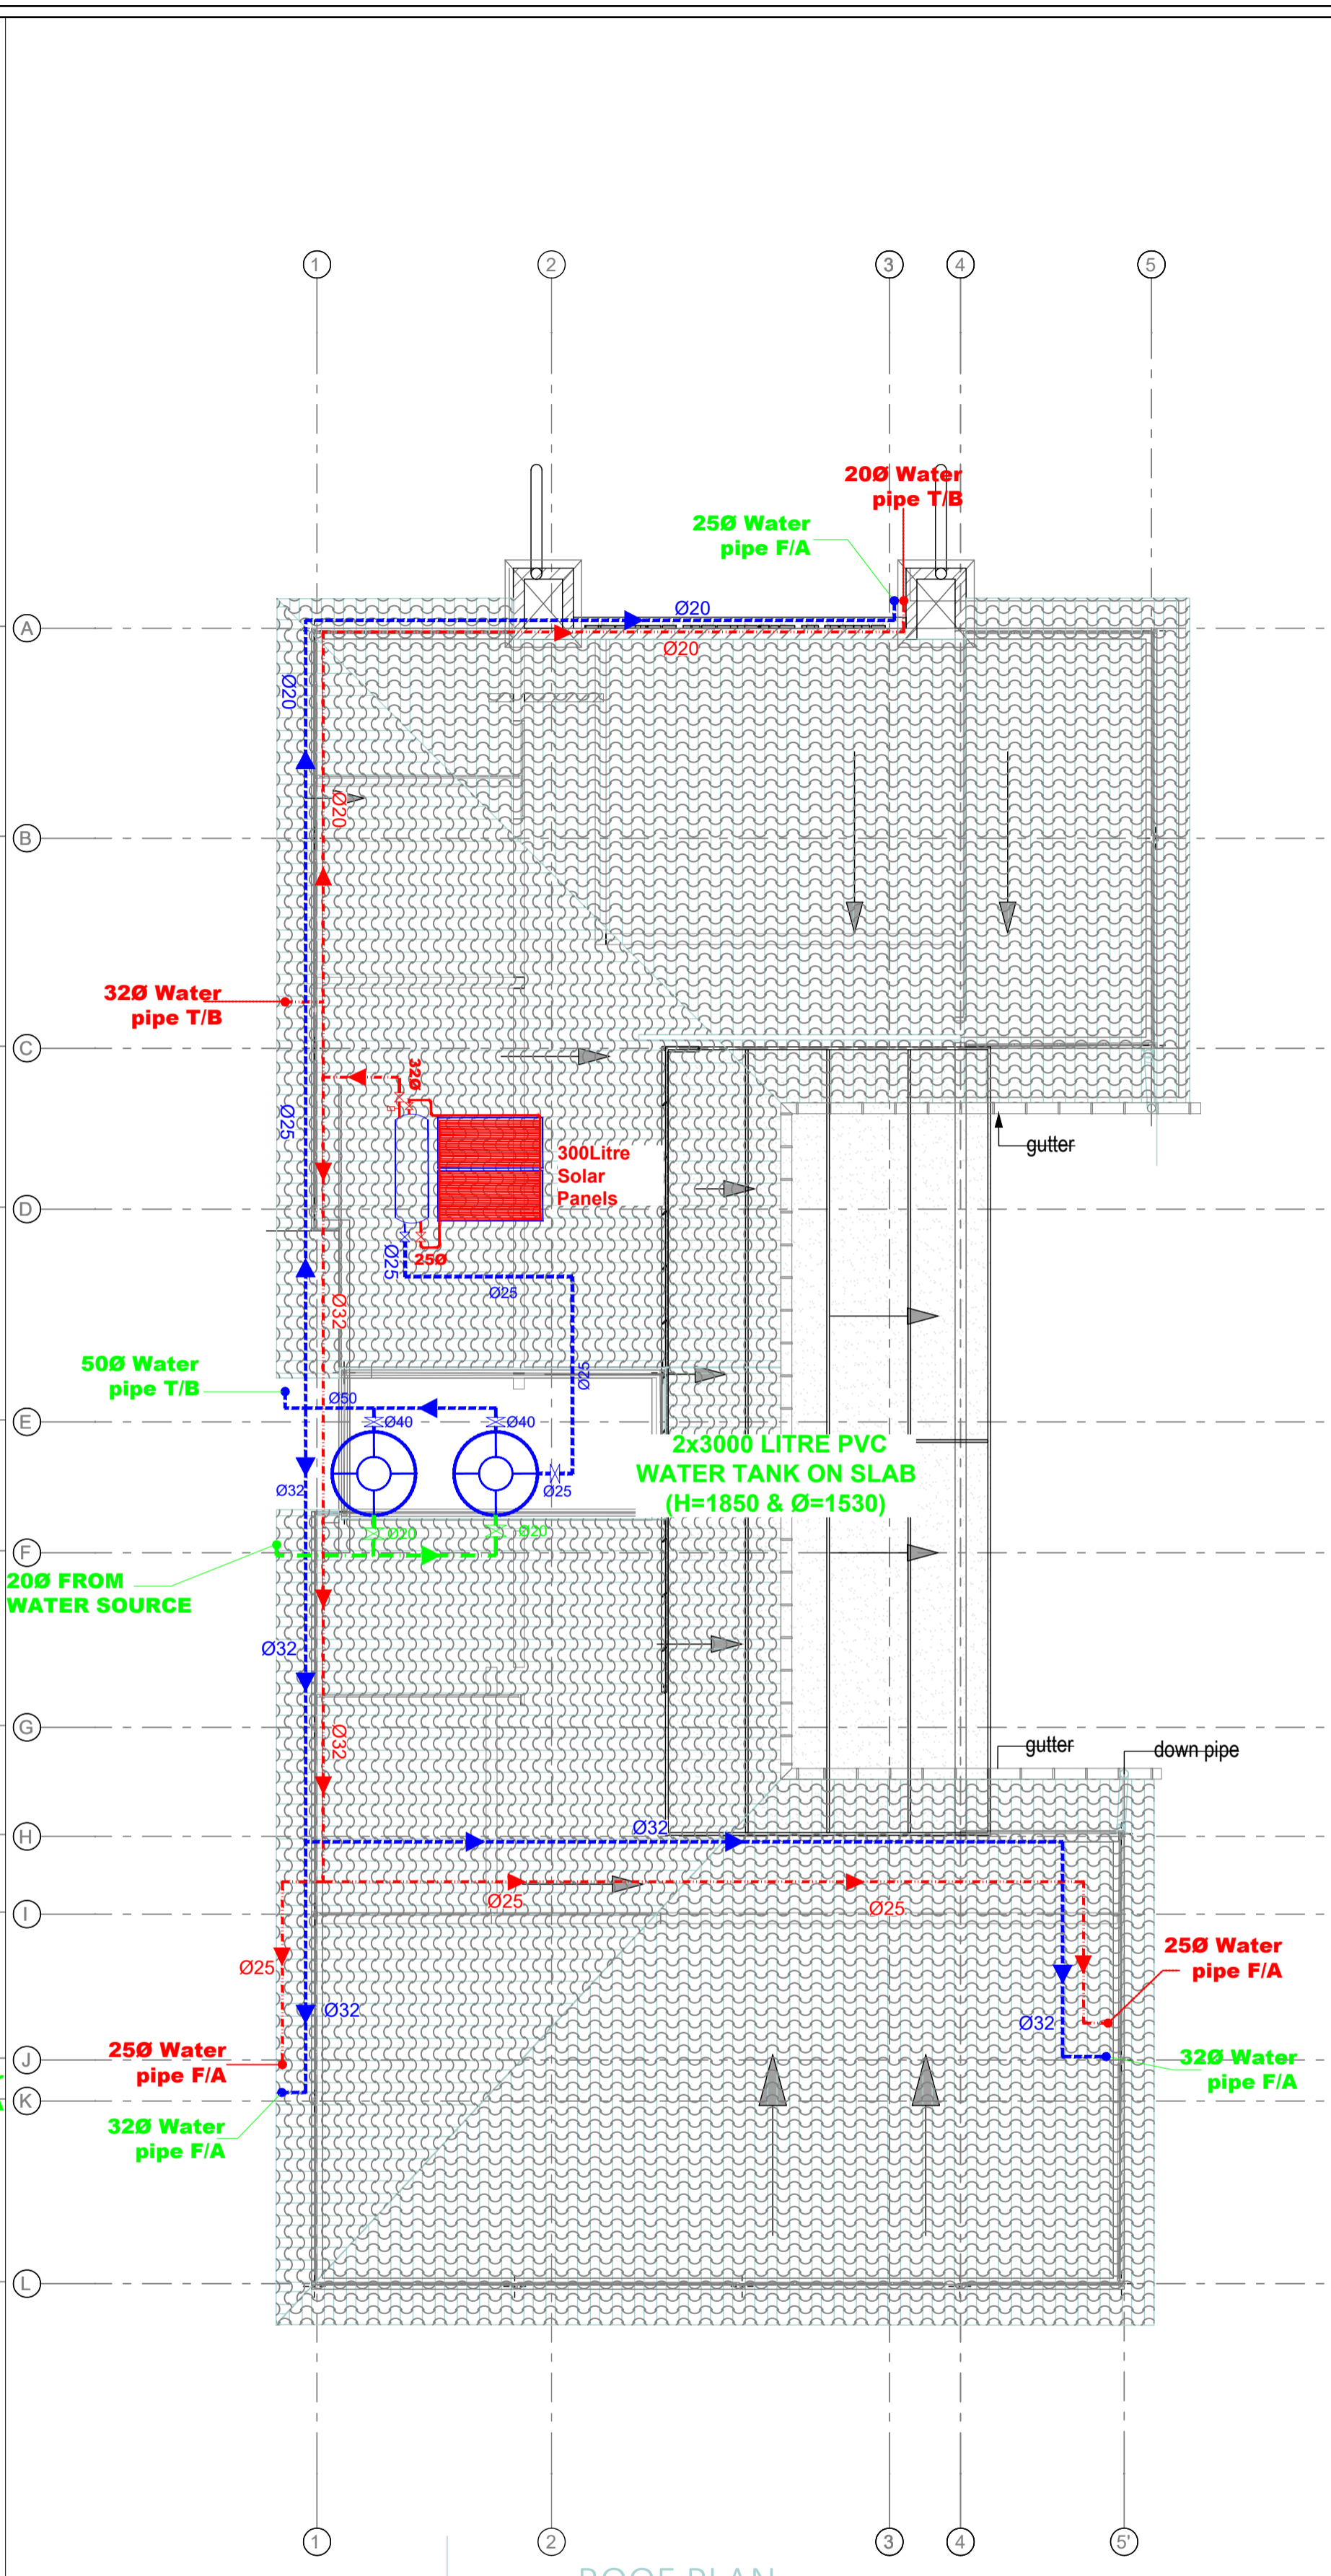

ROOF PLAN

NOTES

SYMBOL	DESCRIPTION
	Cold Water Pipe
	Supply Pipe
	Gate Valve
CIW	Chased In Wall
FA	From Above
TB	To Below
FB	From Below
IFS	In Floor Slab

revisions:

Client: **MINISTRY OF HEALTH / ENABEL**

Job Title: **PUBLIC SERVICES CONTRACT FOR CONSULTANCY SERVICES FOR DESIGN AND SUPERVISION OF WORKS FOR CALL & DISPATCH CENTRE IN ARUA REGIONAL**

STUDIONE DESIGN GROUP Ltd


ARCHITECTURE*PROJECT MANAGEMENT*ENGINEERING

Drawing Name: **MECHANICAL INSTALLATION DESIGN
PLUMBING & WATER SUPPLY LAYOUT:
FLOOR PLANS**


Drawn by: NI	Checked by: ES
Date: MARCH 2023	Scale: 1:100 @A1
Revision:	Drawing No. M02

Arch. Ssinabulya Emmanuel

ARC Reg No. 223 PC No. 2925

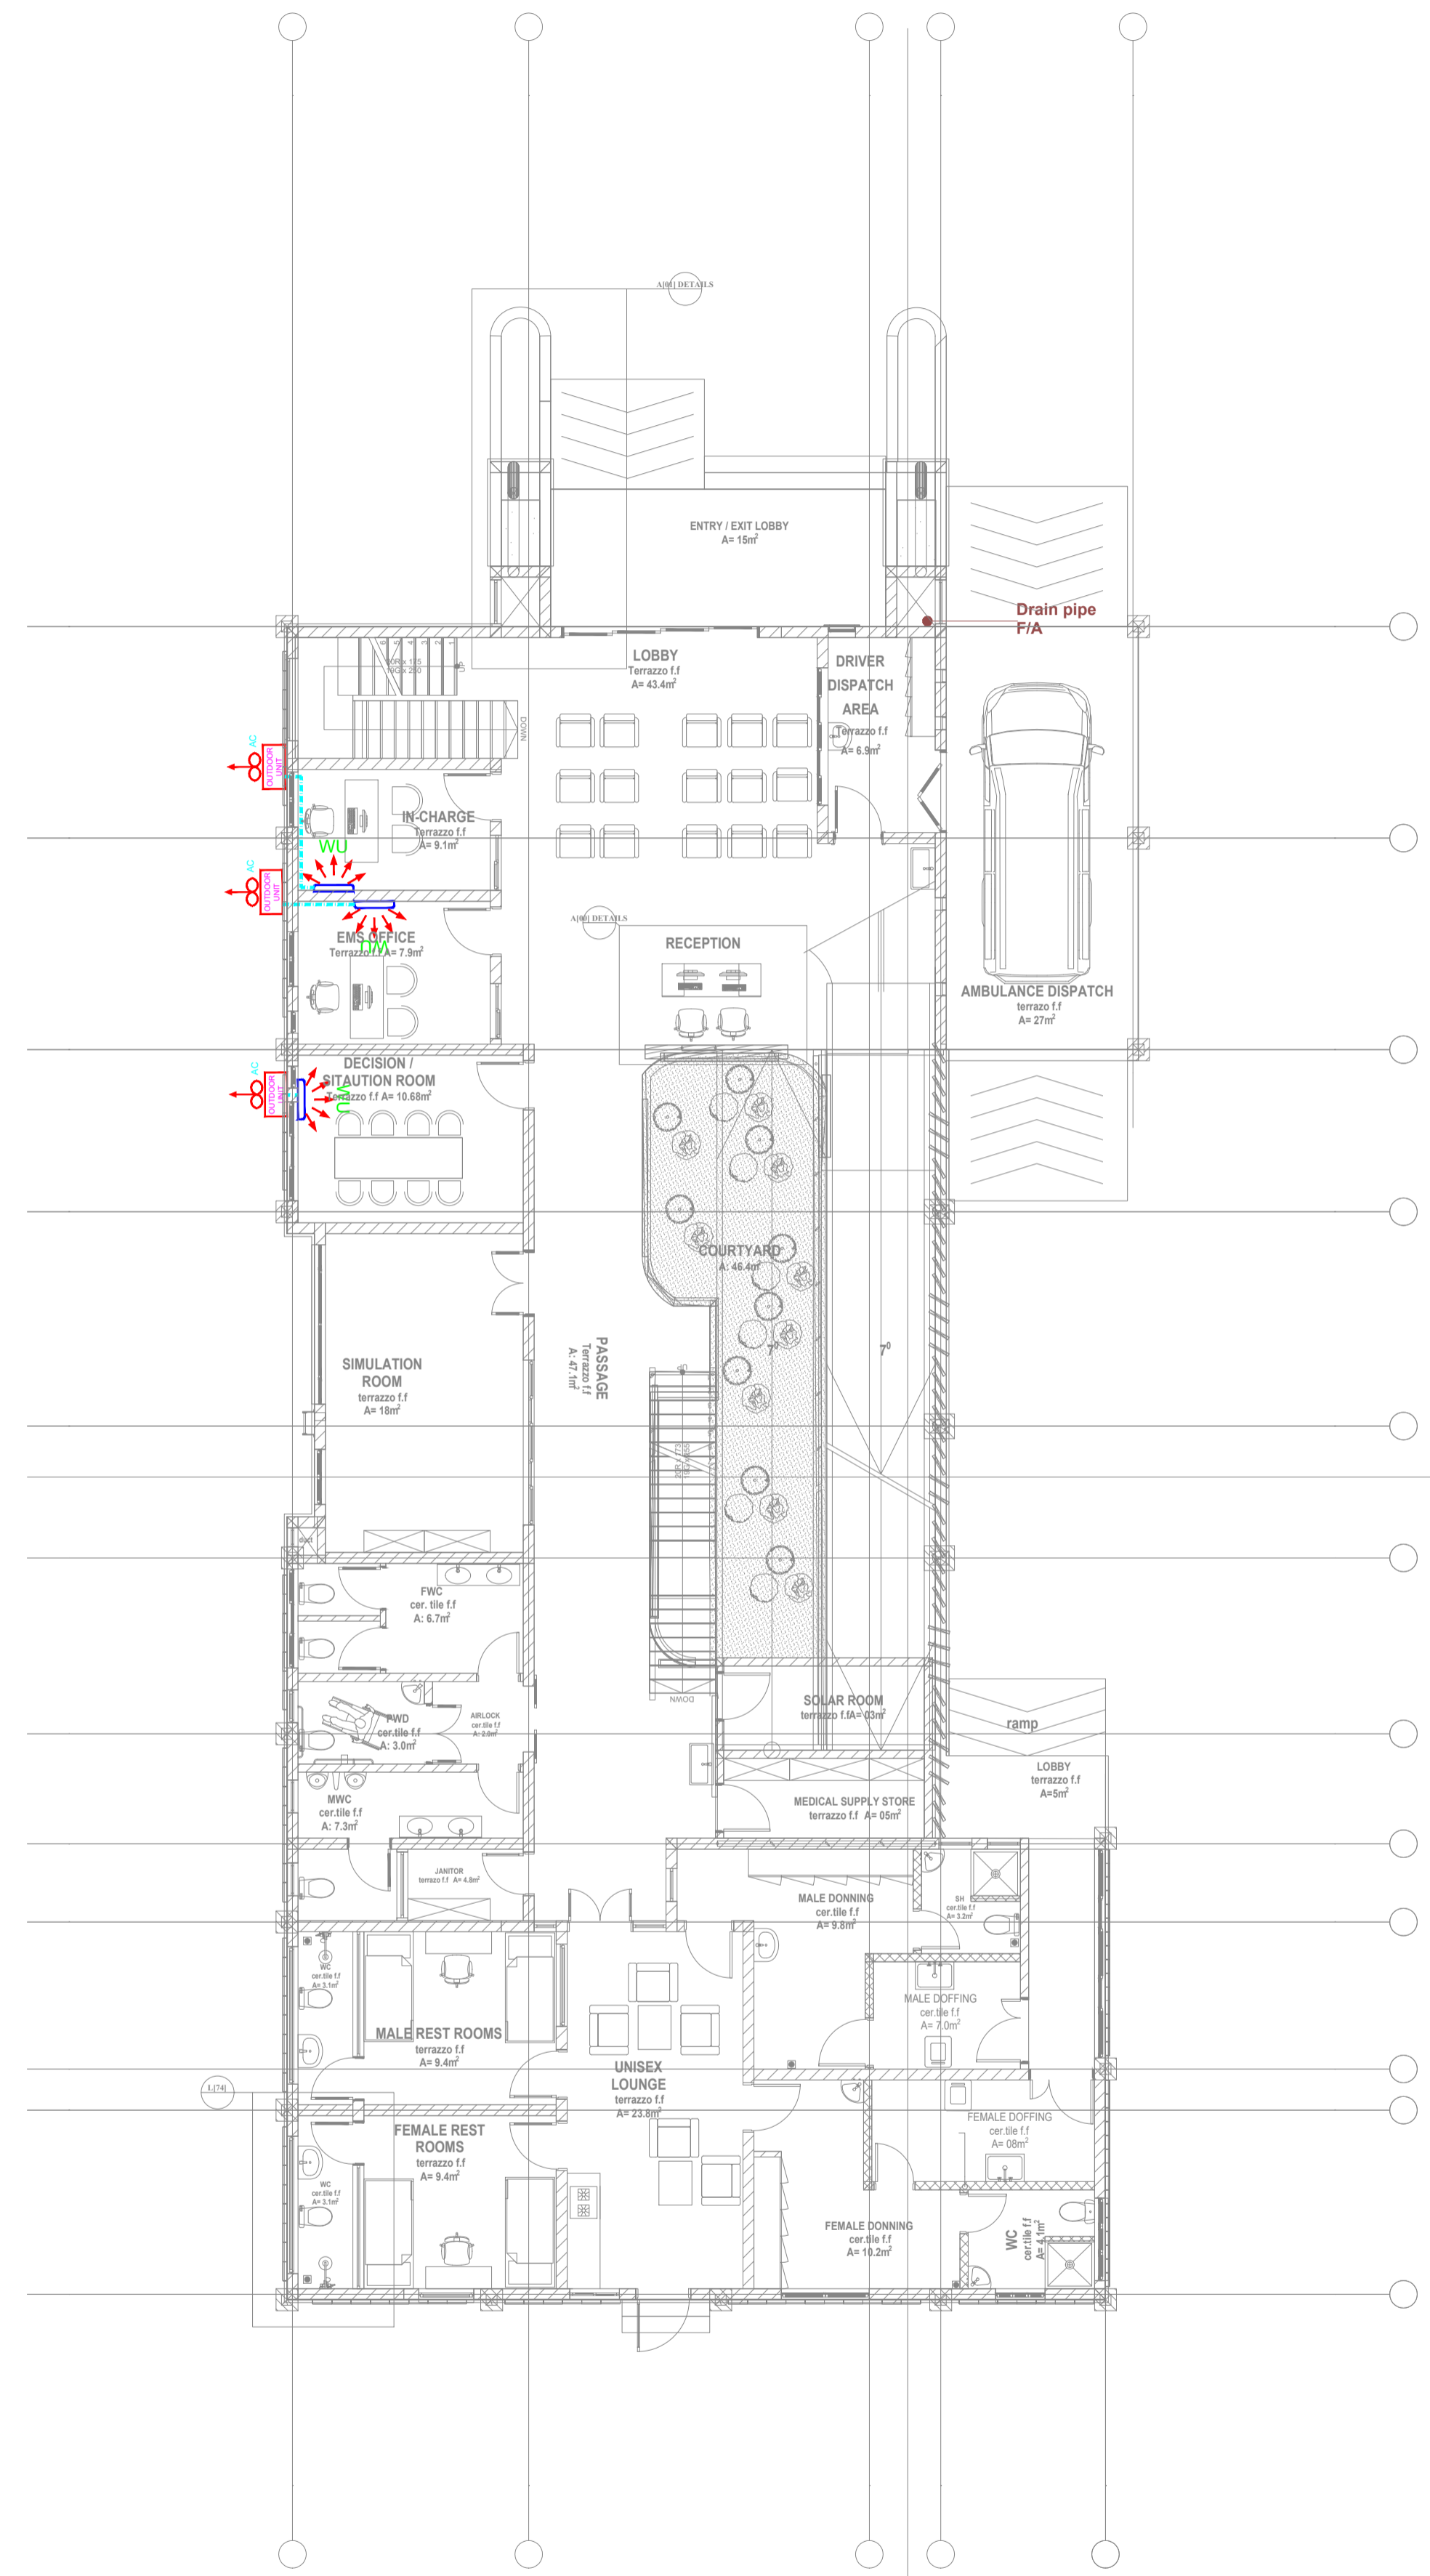

L[---] 100 GROUND FLOOR PLAN
Scale 1:100

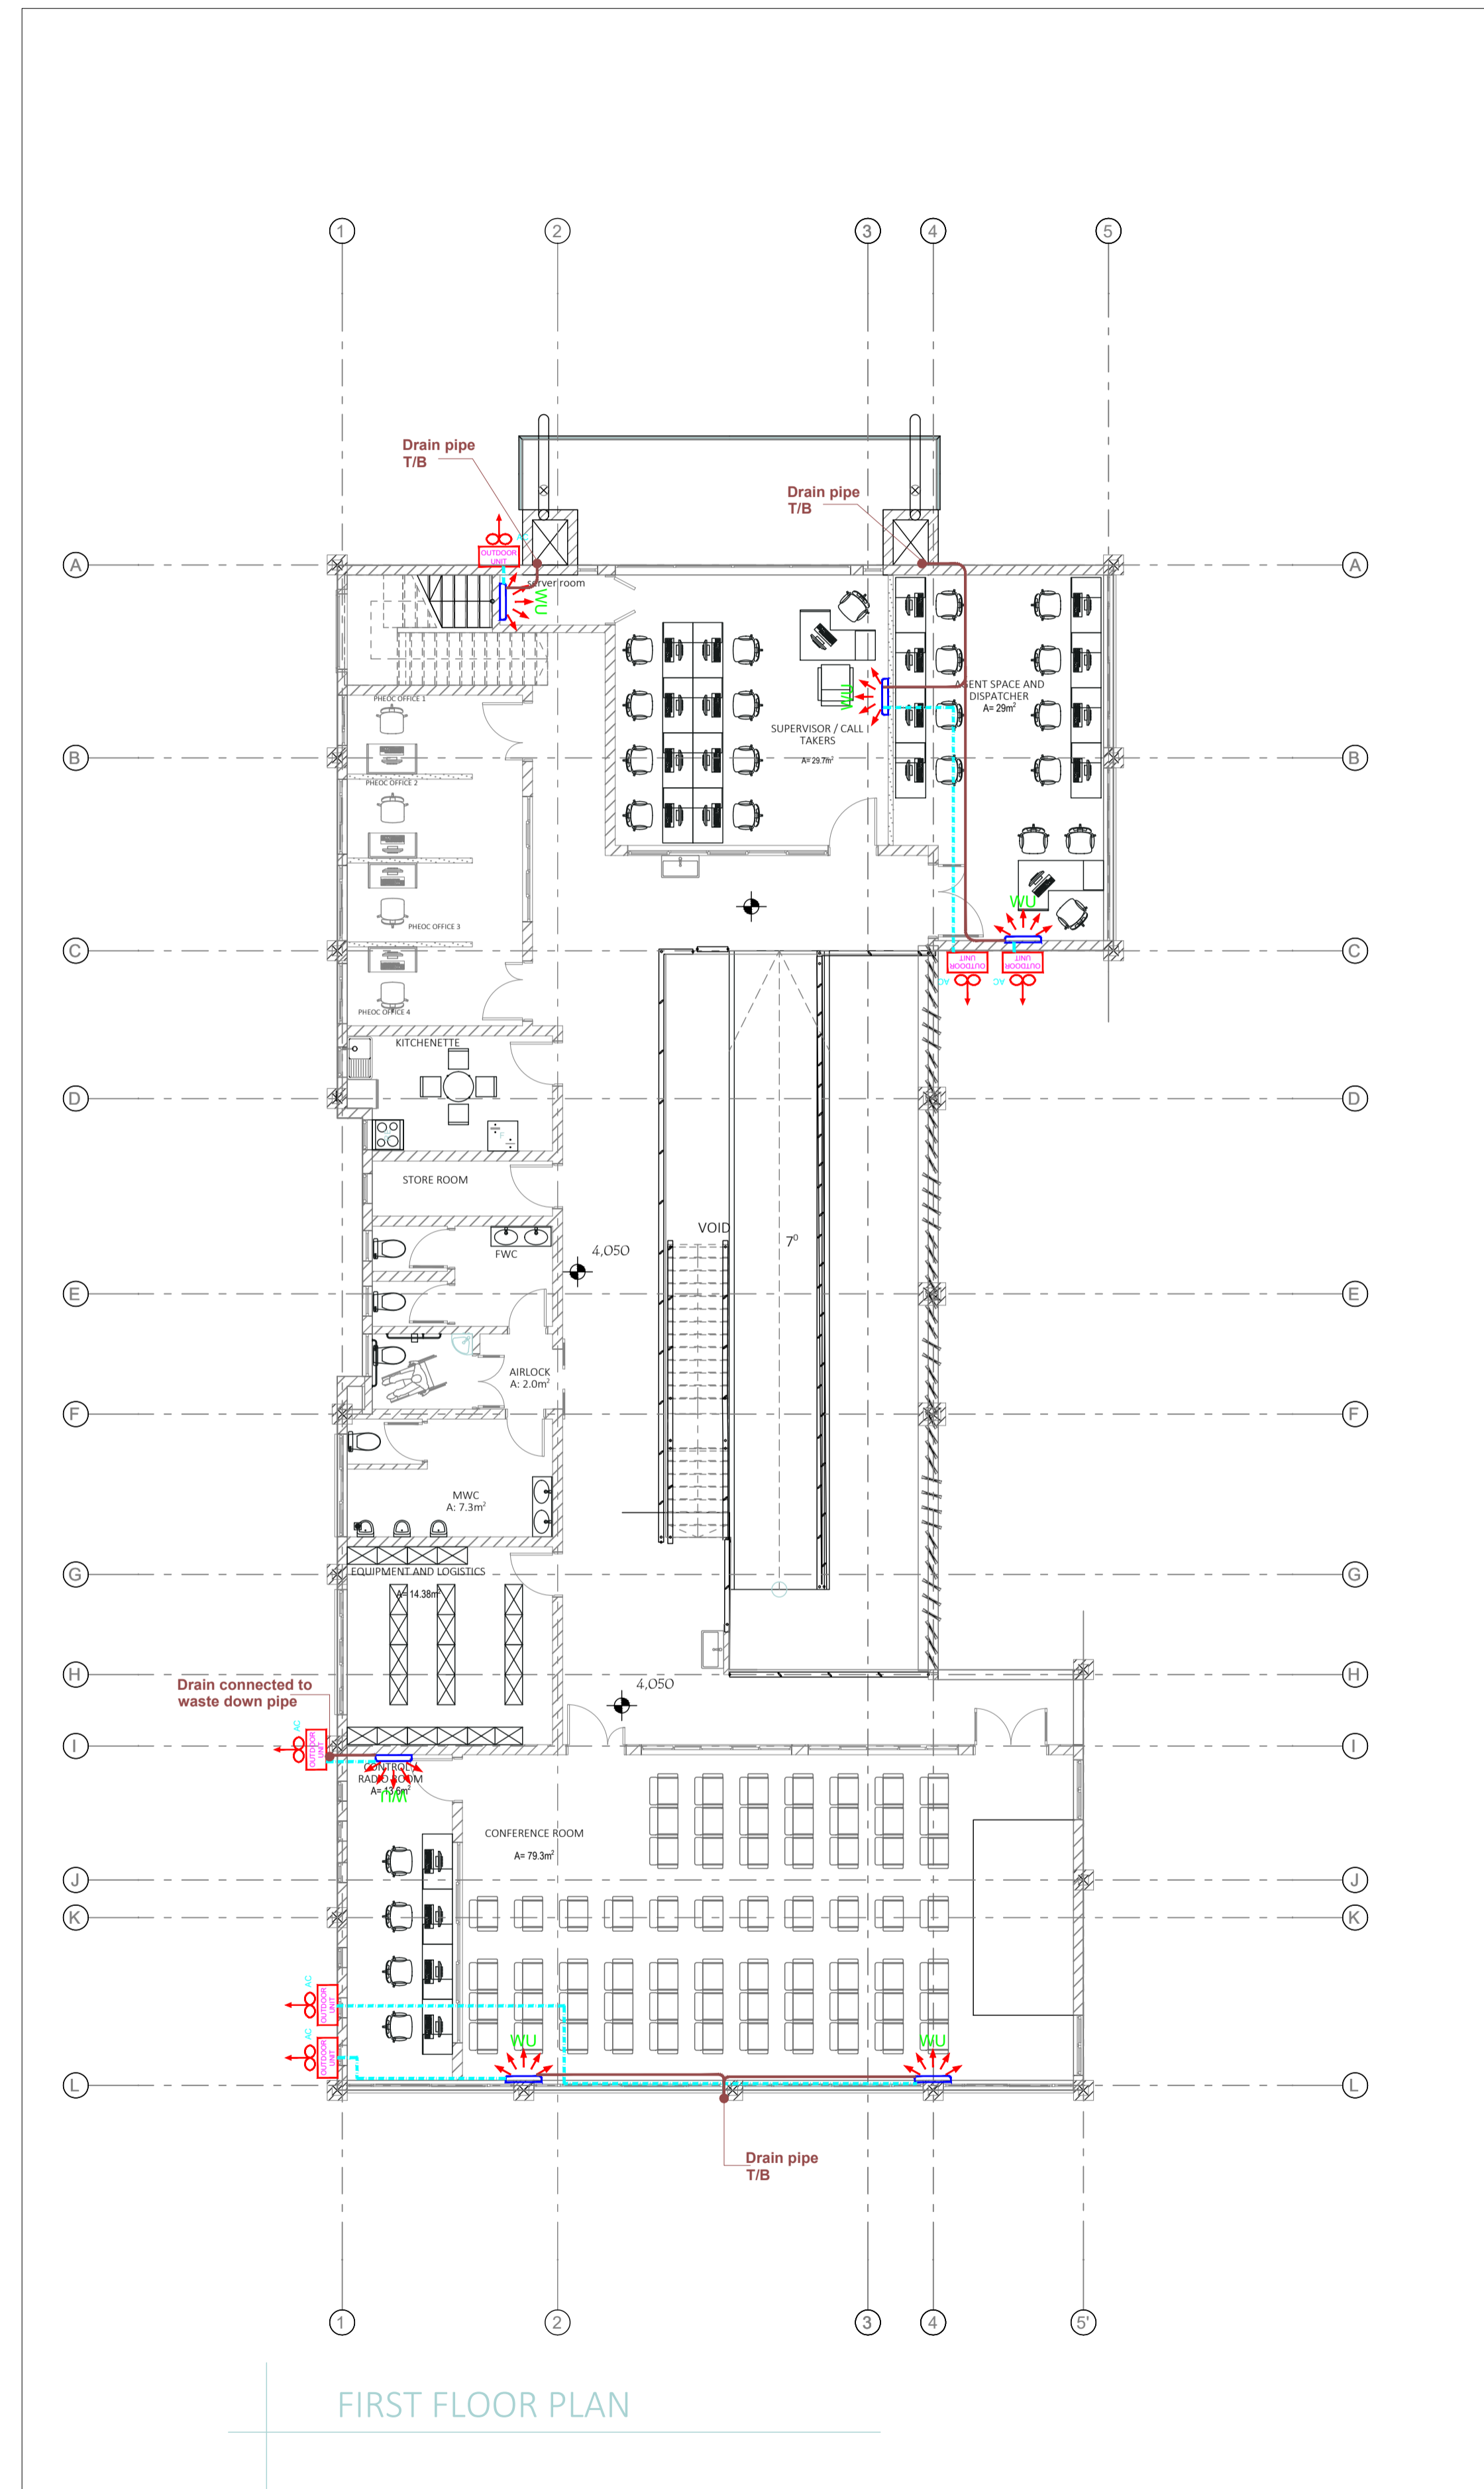

FIRST FLOOR PLAN

NOTES

SYMBOL	DESCRIPTION
	AC Wall Unit
	AC Outdoor Unit
	AC refrigeration pipe
	AC Condensate pipe

revisions:

Client **MINISTRY OF HEALTH / ENABEL**

Plot 4, Lumbwa Road, Nakuru
P.O. Box 7272, Kampala Uganda
Phone: Tel: +256 417 712260

Job Title
PUBLIC SERVICES CONTRACT FOR CONSULTANCY SERVICES FOR DESIGN AND SUPERVISION OF WORKS FOR CALL & DISPATCH CENTRE IN ARUA REGIONAL

STUDIONE DESIGN GROUP Ltd

P.O. Box 24733, AGIP HOUSE, ROOM 33, JINJA ROAD
KAMPALA, UGANDA
TEL: +256 076 711711
E-mail: info@studionedg.com
Web: www.studionedg.com

ARCHITECTURE * PROJECT MANAGEMENT * ENGINEERING

Drawing Name
**MECHANICAL INSTALLATION DESIGN
AIR CONDITIONING LAYOUT-FLOOR PLANS**

Drawn by NI	Checked by ES
Date MARCH 2023	Scale 1:100 @A1
Revision	Drawing No. M03

Arch. Ssinabulya Emmanuel

ARC Reg No. 223 PC No. 2925