

Enabel - Belgian Development Agency



Public Works Contract for the rehabilitation of 5 schools in East Jerusalem”

Reference number: PSE22001-10074

Lot 1: the rehabilitation of Al-Hasan Al-Thany, Al-Shabbat Al-Shameleh, and Al-Fata Al-Laji’a schools in Wadi Al-Joz

Funded By

June 2025

Designed by



Jerusalem - Sheikh Jarrah- Tobler8

Lot1A: Al-Shameleh Secondary Girls' school

ARCHITECTURAL DRAWINGS			
#	SHEET #	SHEET TITLE	SCALE
01	A00	LIST OF DRAWINGS & NOTES ABBREVIATION & SYMBOLS	—
02	A14	ROOF FLOOR PLAN	1:200
03	A15	Scope of Intervention at Basement Floor	1:100
04	A16	Scope of Intervention at Ground Floor	1:100
05	A17	Scope of Intervention at First & Second Floors	1:100
06	A18	Roof Epoxy Flooring	1:100
07	A19	Fence Design	1:100
08	A20	Roof Drainage	1:100

Notes

(1) All Dimensions Are In M.
(2) All Levels Are In Meter
(3) Any Missing or Unclear Detail And All Fastening Systems For All Elements Shall be Approved by The Supervisor.

Legend:

SECTION NUMBER
REFERENCE SHEET NUMBER

ROOM CODE
AREA
ROOM ID

FLOOR FINISH LEVEL (F.F.L.)
REINFORCEMENT CONCRETE LEVEL (R.C.L.)

LEVEL SIGN IN PLAN

STEEL SHEETS
RC CONCRETE FOR COLUMNS
RC CONCRETE FOR WALLS
CONCRETE
STONE WALL
HOLLOW BLOCKS
CEMENT TILE
PORCELAIN TILE
LOCAL MARBLE
Gypsum partition

ENTRANCE
ARTIFICIAL GRASS
PORCELAIN TILES (PARQUET STYLE)
DEMOLISHING AND REMOVAL
NEW INTERVENTION

R.C.L.: REN. CONCRETE LEVEL
F.F.L.: FINISH FLOOR LEVEL
S.L.: SEA LEVEL

REVISIONS

NO.	DRAWINGS	DATE
(1)		
(2)		
(3)		

Contracting Authority:

Enabel

Funded By:

Belgium

partner in development

Project Title:

"Public Works Contract for the rehabilitation of 5 schools in East Jerusalem"

Reference number: PSE22001-10074

Lot 1: the rehabilitation of Al-Hasan Al-Thany, Al-Shabbat Al-Shameleh, and Al-Fata Al-Laji'a schools in Wadi Al-Joz

Al-Shameleh Secondary Girls' school

Designed by:


HOSH STUDIO

ARCHITECTURE & TOWN PLANNING

Jerusalem - Sheikh Jarrah- Tobler8
email: mr.wasimhija@gmail.com

Tel. 02-9948344/ 052-8327076
Fax: 02-9948344

Drawing Title	Table of Drawings	Date: 25/3/2025 Scale: 1:100
Designed by:	Arch. Hiba Al Ayoubi	Drawing No:
Checked by:	Arch. Wasim Abu El-Hija	A00
Approved by:		
Coordinate Manager:		

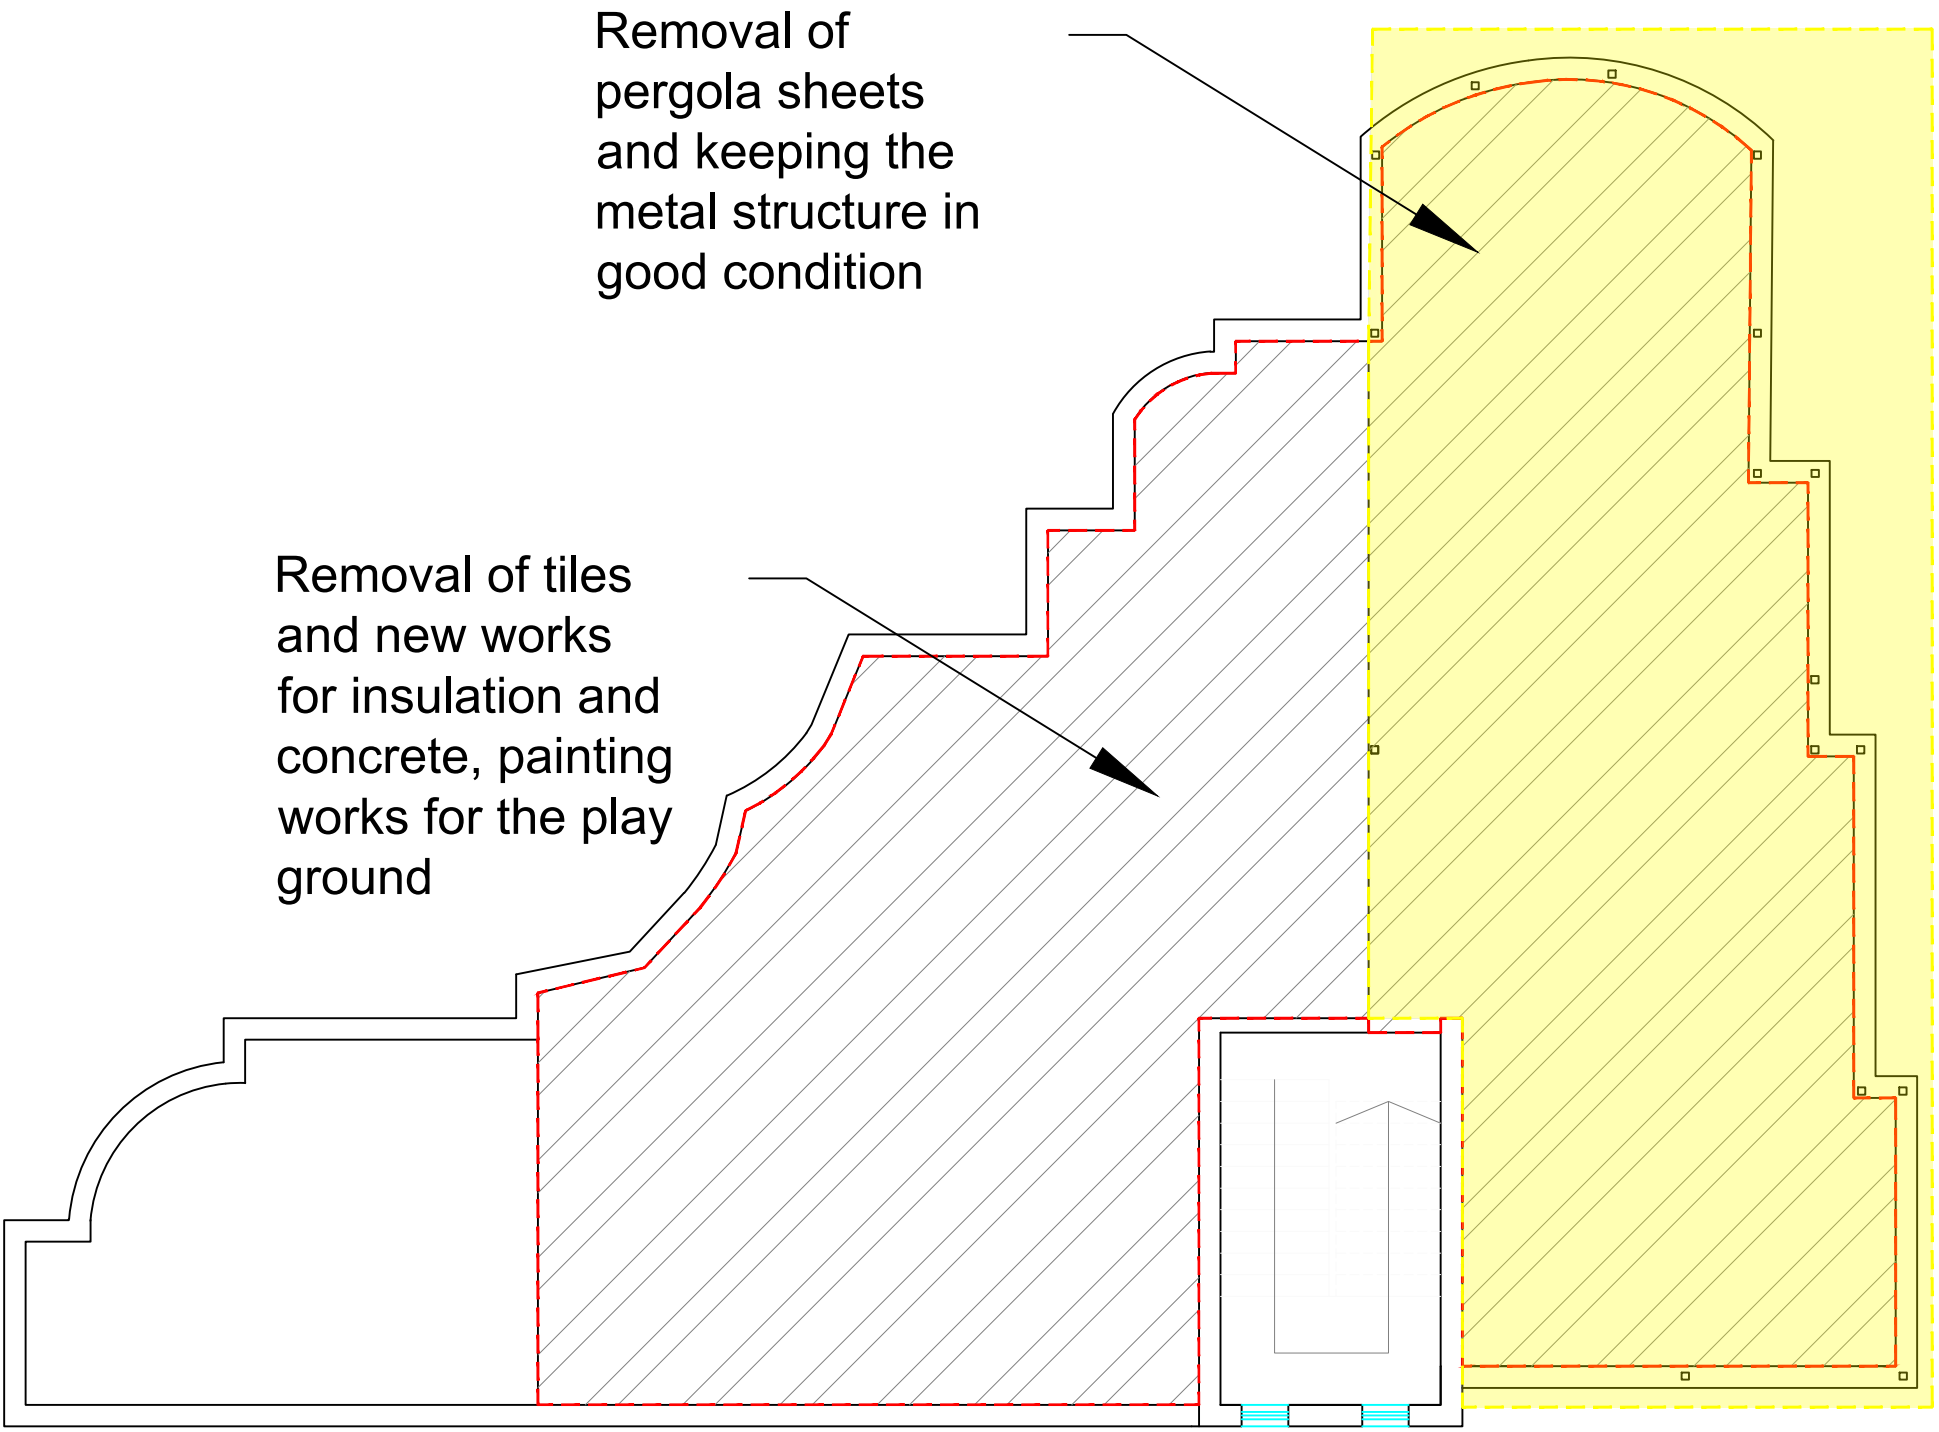

ROOF FLOOR PLAN

Notes

(1) All Dimensions Are In M.
(2) All Levels Are In Meter
(3) Any Missing or Unclear Detail And All Fastening Systems For All Elements Shall be Approved by The Supervisor.

Legend:

SECTION NUMBER
REFERENCE SHEET NUMBER
REFERENCE DETAIL SHEET NUMBER
FLOOR FINISH LEVEL (F.F.L.)
REINFORCEMENT CONCRETE LEVEL (R.C.L.)
LEVEL SIGN IN PLAN
STEEL SHEETS
RC CONCRETE FOR COLUMNS
RC CONCRETE FOR WALLS
CONCRETE
STONE WALL
HOLLOW BLOCKS
CEMENT TILE
PORCELAIN TILE
LOCAL MARBLE
Gypsum partition
FUNCTION
ROOM CODE
AREA
ROOM ID
DOOR NUMBER
REFERENCE DETAIL SHEET NUMBER
WINDOW NUMBER
REFERENCE DETAIL SHEET NUMBER
ENTRANCE
ARTIFICIAL GRASS
PORCELAIN TILES (PARQUET STYLE)
DEMOLISHING AND REMOVAL
NEW INTERVENTION
R.C.L.: REN. CONCRETE LEVEL
F.F.L.: FINISH FLOOR LEVEL
S.L.: SEA LEVEL

REVISIONS		
NO.	DRAWINGS	DATE
(1)		
(2)		
(3)		

Contracting Authority:

Enabel

Funded By:

Belgium
partner in development

Project Title:

“Public Works Contract for the rehabilitation of 5 schools in East Jerusalem”

Reference number: PSE22001-10074

Lot 1: the rehabilitation of Al-Hasan Al-Thany, Al-Shabbat Al-Shameleh, and Al-Fata Al-Laji'a schools in Wadi Al-Joz

Al-Shameleh Secondary Girls' school

Designed by:

HOSH STUDIO
ARCHITECTURE & TOWN PLANNING

Jerusalem - Sheikh Jarrah- Tobler8
email: mr.wasimhija@gmail.com
Tel. 02-9948344/ 052-8327076
Fax: 02-9948344

Drawing Title	ROOF FLOOR PLAN	Date: 25/3/2025 Scale: 1:100
Designed by:	Arch. Hiba Al Ayoubi	Drawing No: A14
Checked by:	Arch. Wasim Abu El-Hija	
Approved by:		
Coordinate Manager:		

Painting Works

BASEMENT FLOOR

- Notes
- (1) All Dimensions Are In M.

(2) All Levels Are In Meter

(3) Any Missing or Unclear Detail And All Fastening Systems For All Elements Shall be Approved by The Supervisor.

Legend:

SECTION NUMBER

REFERENCE SHEET NUMBER

REFERENCE DETAIL SHEET NUMBER

FLOOR FINISH LEVEL (F.F.L.)

REINFORCEMENT CONCRETE LEVEL (R.C.L.)

LEVEL SIGN IN PLAN

STEEL SHEETS

RC CONCRETE FOR COLUMNS

RC CONCRETE FOR WALLS

CONCRETE

STONE WALL

HOLLOW BLOCKS

CEMENT TILE

PORCELAIN TILE

LOCAL MARBLE

Gypsum partition

FUNCTION AREA

ROOM ID

DOOR NUMBER

WINDOW NUMBER

ENTRANCE

ARTIFICIAL GRASS

PORCELAIN TILES (PARQUET STYLE)

DEMOLISHING AND REMOVAL

NEW INTERVENTION

R.C.L.:REN. CONCRETE LEVEL

F.F.L.:FINISH FLOOR LEVEL

S.L. : SEA LEVEL

DETAILED SECTION AT SHEET No. A09

REVISIONS		
NO.	DRAWINGS	DATE
(1)		
(2)		
(3)		

Contracting Authority:



Funded By:



Project Title:

“Public Works Contract for the rehabilitation of 5 schools in East Jerusalem”

Reference number: PSE22001-10074

Lot 1: the rehabilitation of Al-Hasan Al-Thany, Al-Shabbat Al-Shameleh, and Al-Fata Al-Laji’a schools in Wadi Al-Joz

Al-Shameleh Secondary Girls' school

Designed by:



HOSH STUDIO

ARCHITECTURE & TOWN PLANNING


Jerusalem - Sheikh Jarrah- Tobler8

email: mr.wasimhija@gmail.com

Tel. 02-9948344/ 052-8327076

Fax: 02-9948344

Drawing Title	Scope of Intervention at Basement Floor	Date: 25/3/2025 Scale: 1:100
Designed by:	Arch. Hiba Al Ayoubi	Drawing No: A15
Checked by:	Arch. Wasim Abu El-Hija	
Approved by:		
Coordinate Manager:		

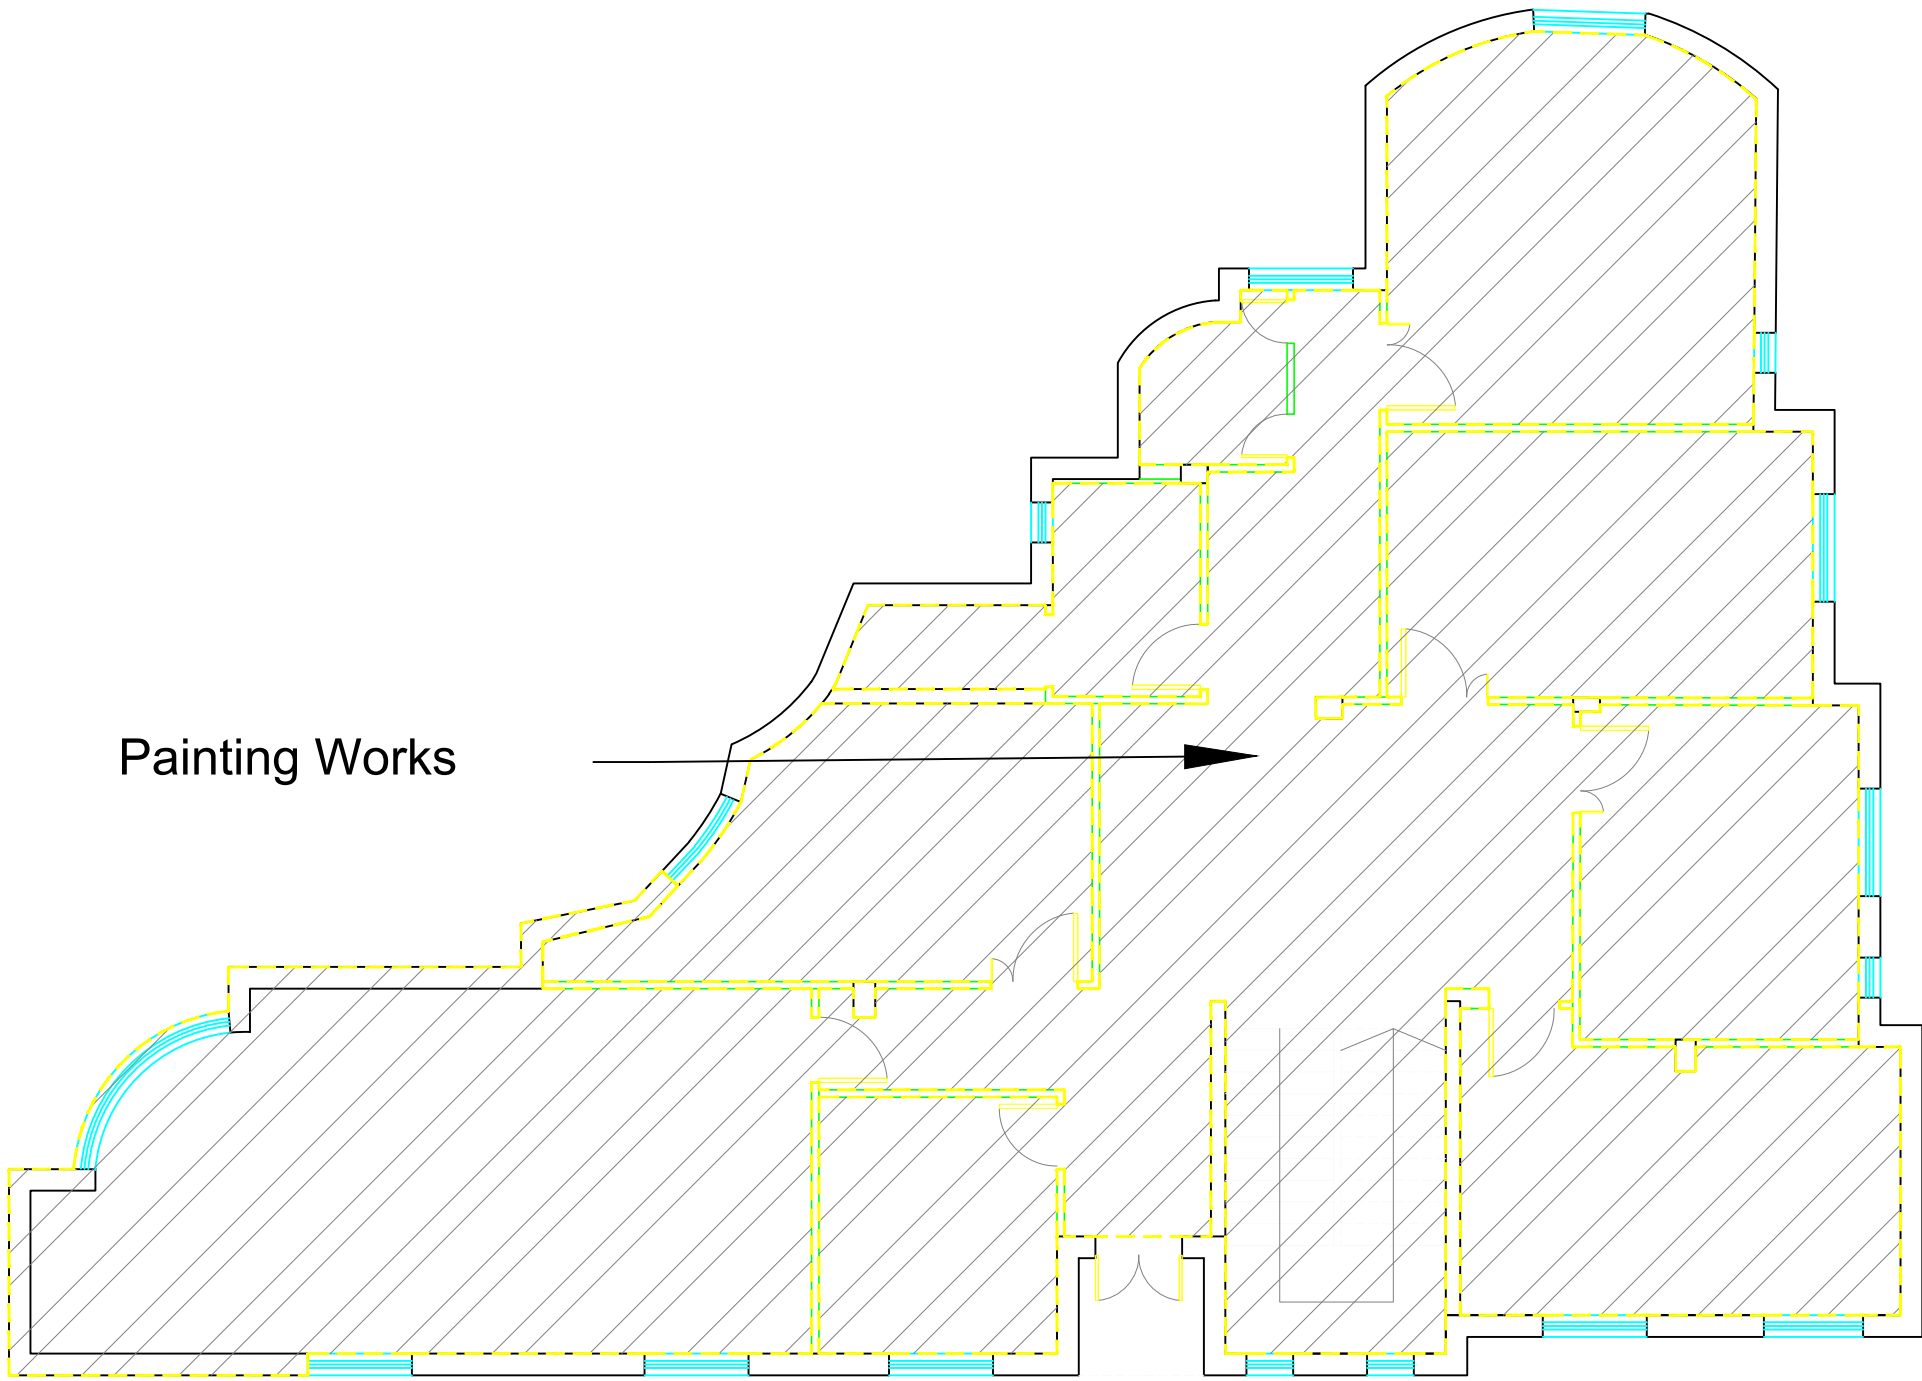

GROUND FLOOR

Notes

- (1) All Dimensions Are In M.
- (2) All Levels Are In Meter
- (3) Any Missing or Unclear Detail And All Fastening Systems For All Elements Shall be Approved by The Supervisor.

Legend:

	SECTION NUMBER		ROOM CODE		FUNCTION
	REFERENCE SHEET NUMBER		ROOM AREA		ROOM ID
	REFERENCE DETAIL SHEET NUMBER		DOOR NUMBER		DOOR NUMBER REFERENCE DETAIL SHEET NUMBER
	FLOOR FINISH LEVEL (F.F.L.)		WINDOW NUMBER		WINDOW NUMBER REFERENCE DETAIL SHEET NUMBER
	REINFORCEMENT CONCRETE LEVEL (R.C.L.)		DETAILED SECTION AT SHEET No. A09		
	LEVEL SIGN IN PLAN				

	STEEL SHEETS		ENTRANCE
	RC CONCRETE FOR COLUMNS		ARTIFICIAL GRASS
	RC CONCRETE FOR WALLS		PORCELAIN TILES (PARQUET STYLE)
	CONCRETE		DEMOLISHING AND REMOVAL
	STONE WALL		NEW INTERVENTION
	HOLLOW BLOCKS		
	CEMENT TILE		
	PORCELAIN TILE		
	LOCAL MARBLE		
	Gypsum partition		

	R.C.L.: REN. CONCRETE LEVEL
	F.F.L.: FINISH FLOOR LEVEL
	S.L.: SEA LEVEL

REVISIONS

NO.	DRAWINGS	DATE
(1)		
(2)		
(3)		

Contracting Authority:



Funded By:



Project Title:

“Public Works Contract for the rehabilitation of 5 schools in East Jerusalem”

Reference number: PSE22001-10074

Lot 1: the rehabilitation of Al-Hasan Al-Thany, Al-Shabbat Al-Shameleh, and Al-Fata Al-Laji’a schools in Wadi Al-Joz


Al-Shameleh Secondary Girls' school

Designed by:



Jerusalem - Sheikh Jarrah - Tobler8
email: mr.wasimhija@gmail.com
Tel. 02-9948344/ 052-8327076
Fax: 02-9948344

Drawing Title	Scope of Intervention at Ground Floor	Date: 25/3/2025 Scale: 1:100
Designed by:	Arch. Hiba Al Ayoubi	Drawing No:
Checked by:	Arch. Wasim Abu El-Hija	A16
Approved by:		
Coordinate Manager:		

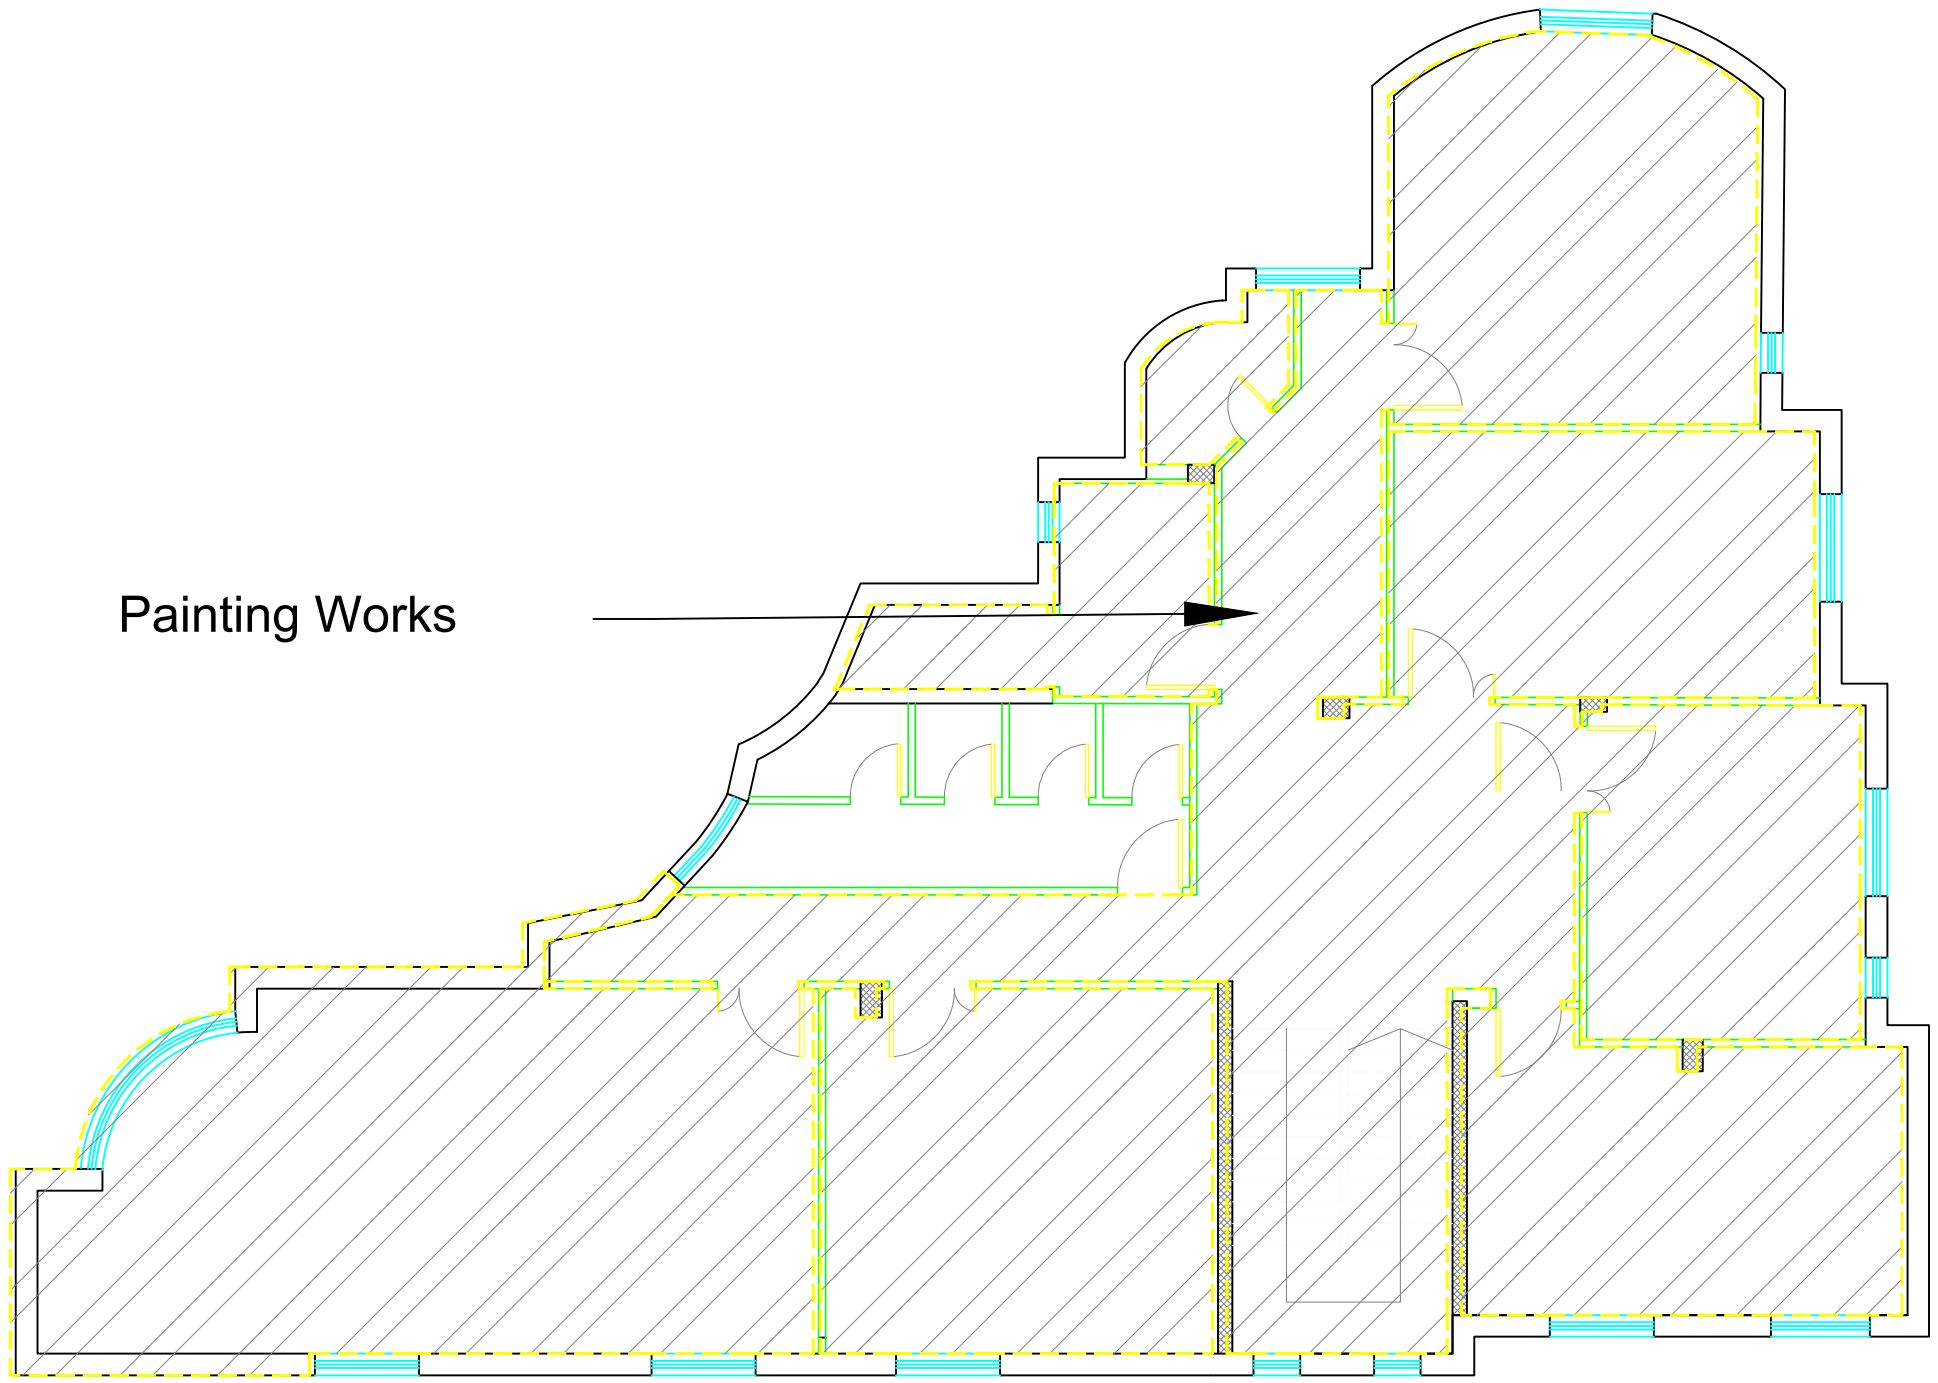

FIRST FLOOR & SECOND FLOOR

Notes

- (1) All Dimensions Are In M.
- (2) All Levels Are In Meter
- (3) Any Missing or Unclear Detail And All Fastening Systems For All Elements Shall be Approved by The Supervisor.

Legend:

SECTION NUMBER
REFERENCE SHEET NUMBER

REFERENCE DETAIL SHEET NUMBER

FLOOR FINISH LEVEL (F.F.L.)
REINFORCEMENT CONCRETE LEVEL (R.C.L.)

LEVEL SIGN IN PLAN

STEEL SHEETS

RC CONCRETE FOR COLUMNS

RC CONCRETE FOR WALLS

CONCRETE

STONE WALL

HOLLOW BLOCKS

CEMENT TILE

PORCELAIN TILE

LOCAL MARBLE

Gypsum partition

ENTRANCE

ARTIFICIAL GRASS

PORCELAIN TILES (PARQUET STYLE)

DEMOLISHING AND REMOVAL

NEW INTERVENTION

ROOM CODE
ROOM ID

DOOR NUMBER
REFERENCE DETAIL SHEET NUMBER

WINDOW NUMBER
REFERENCE DETAIL SHEET NUMBER

DETAILED SECTION AT SHEET No. A09

R.C.L.: REN. CONCRETE LEVEL

F.F.L.: FINISH FLOOR LEVEL

S.L.: SEA LEVEL

REVISIONS

NO.	DRAWINGS	DATE
(1)		
(2)		
(3)		

Contracting Authority:



Funded By:


Project Title:

Designed by:



Jerusalem - Sheikh Jarrah- Tobler8
email: mr.wasimhija@gmail.com
Tel. 02-9948344/ 052-8327076
Fax: 02-9948344

Drawing Title	Scope of Intervention at First & Second Floors	Date: 25/3/2025 Scale: 1:100
Designed by:	Arch. Hiba Al Ayoubi	Drawing No: A17
Checked by:	Arch. Wasim Abu El-Hija	
Approved by:		
Coordinate Manager:		

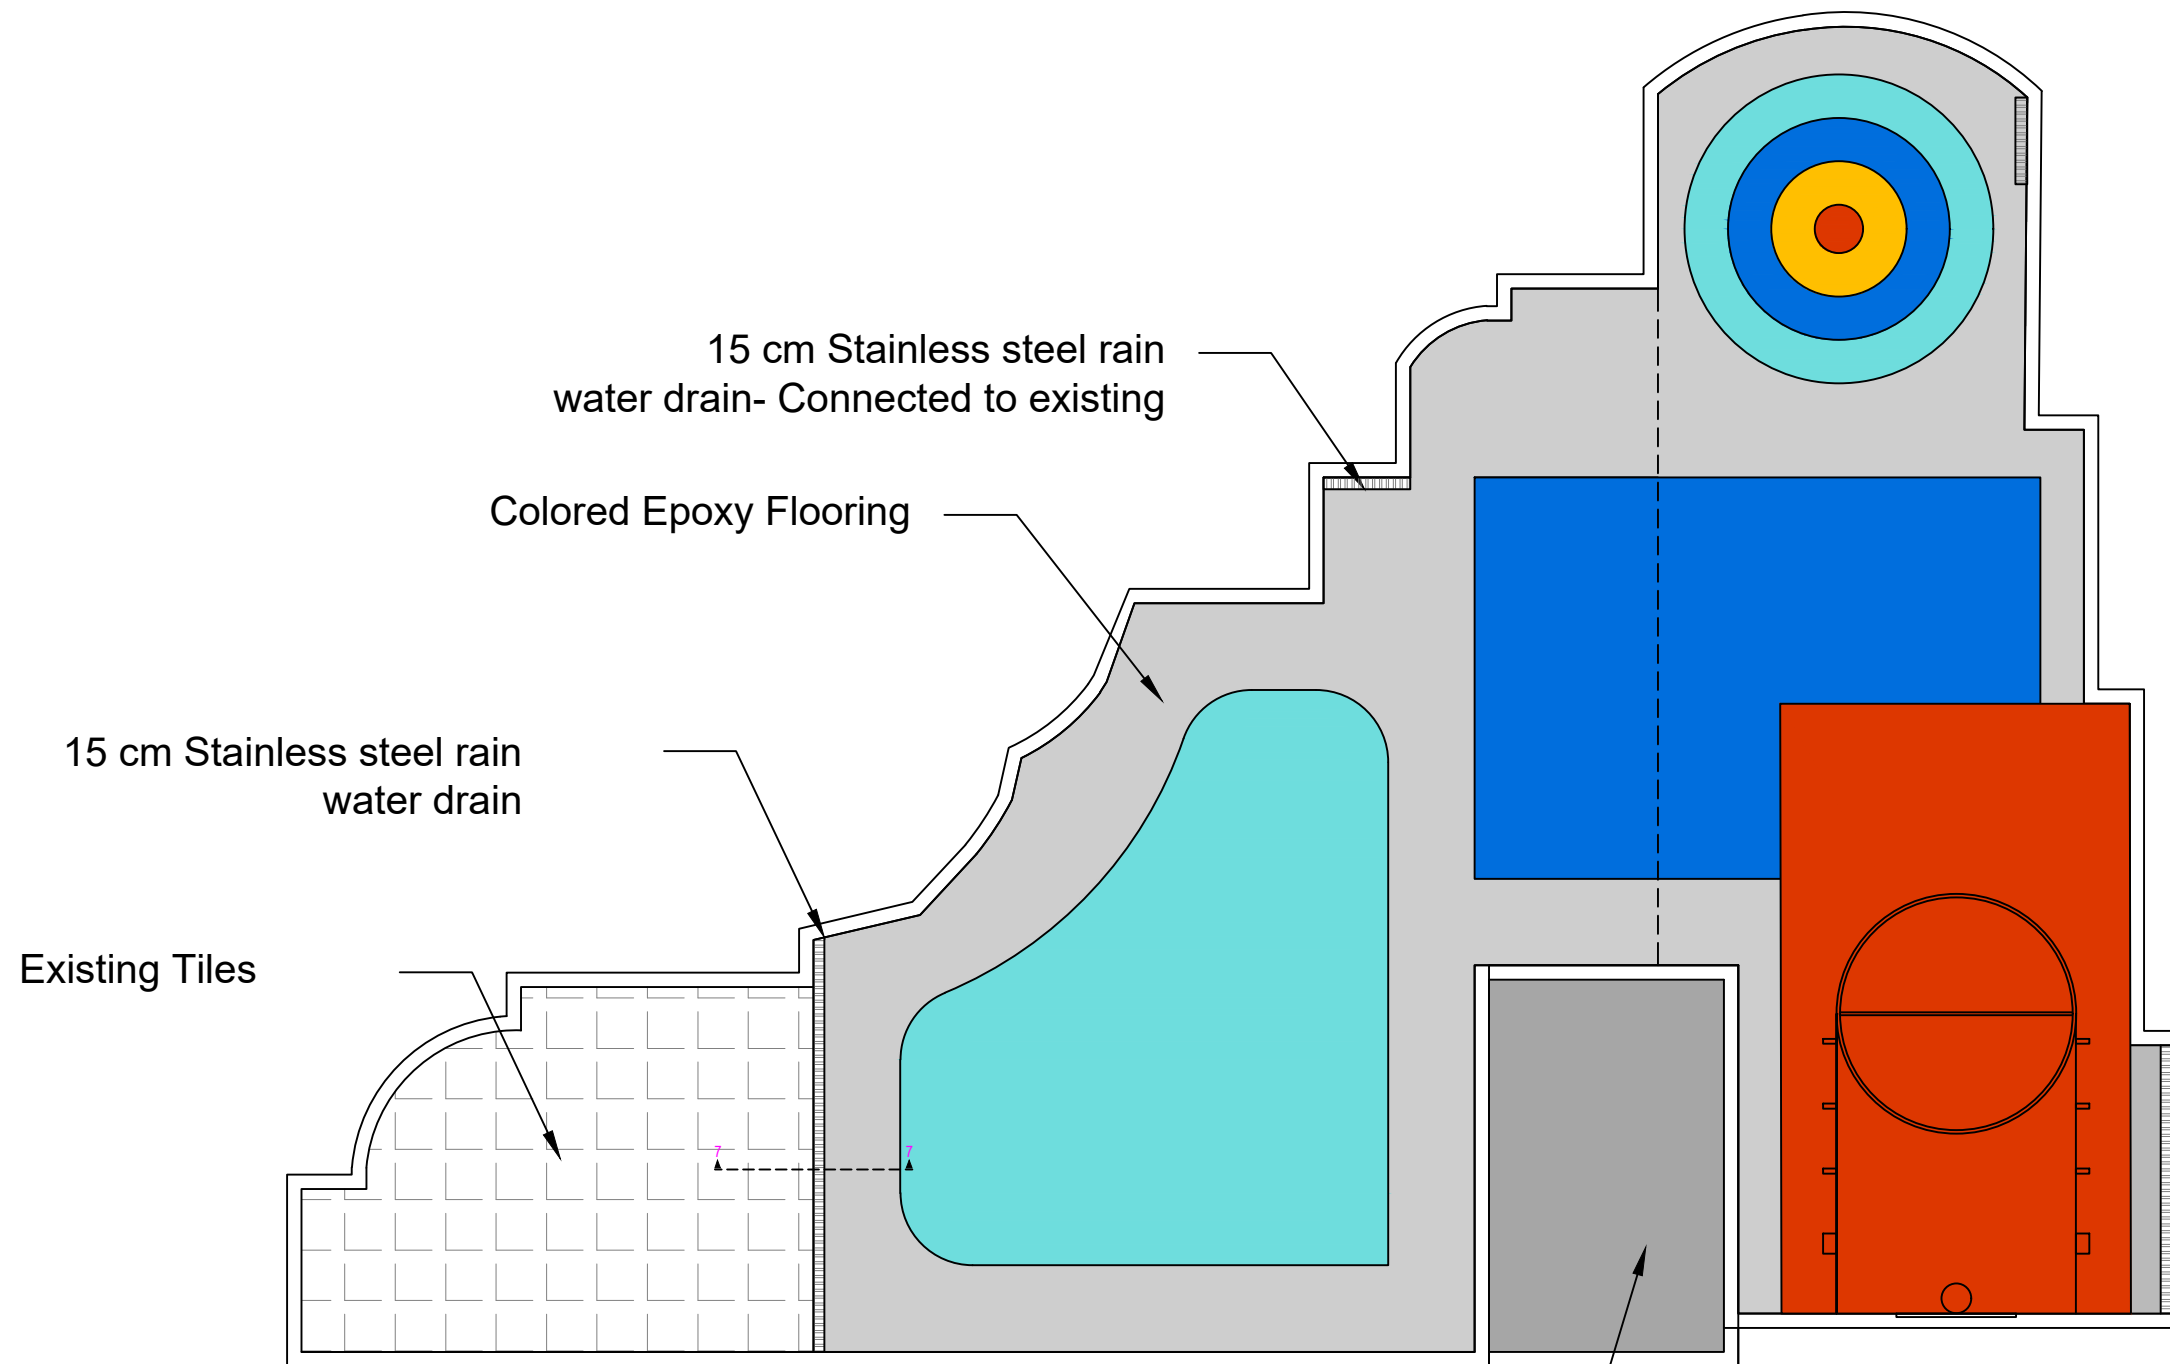

Notes

(1) All Dimensions Are In M.
(2) All Levels Are In Meter
(3) Any Missing or Unclear Detail And All Fastening Systems For All Elements Shall be Approved by The Supervisor.

Legend:

SECTION NUMBER
REFERENCE SHEET NUMBER
FLOOR FINISH LEVEL (F.F.L.)
REINFORCEMENT CONCRETE LEVEL (R.C.L.)
LEVEL SIGN IN PLAN
DOOR NUMBER
WINDOW NUMBER
DETAILED SECTION AT SHEET No. A09

STEEL SHEETS
RC CONCRETE FOR COLUMNS
RC CONCRETE FOR WALLS
CONCRETE
STONE WALL
HOLLOW BLOCKS
CEMENT TILE
PORCELAIN TILE
LOCAL MARBLE
Gypsum partition

ENTRANCE
ARTIFICIAL GRASS
PORCELAIN TILES (PARQUET STYLE)
DEMOLISHING AND REMOVAL
NEW INTERVENTION

R.C.L.: REN. CONCRETE LEVEL
F.F.L.: FINISH FLOOR LEVEL
S.L.: SEA LEVEL

REVISIONS		
NO.	DRAWINGS	DATE
(1)		
(2)		
(3)		

Contracting Authority:

Enabel

Funded By:

Belgium
partner in development

Project Title:

“Public Works Contract for the rehabilitation of 5 schools in East Jerusalem”

Reference number: PSE22001-10074

Lot 1: the rehabilitation of Al-Hasan Al-Thany, Al-Shabbat Al-Shameleh, and Al-Fata Al-Laji’a schools in Wadi Al-Joz

Al-Shameleh Secondary Girls' school

Designed by:

HOSH STUDIO
ARCHITECTURE & TOWN PLANNING

Jerusalem - Sheikh Jarrah- Tobler8
email: mr.wasimhija@gmail.com

Tel. 02-9948344/ 052-8327076
Fax: 02-9948344


Drawing Title	Roof Epoxy Flooring	Date: 25/3/2025 Scale: 1:100
Designed by:	Arch. Hiba Al Ayoubi	Drawing No: A18
Checked by:	Arch. Wasim Abu El-Hija	
Approved by:		
Coordinate Manager:		

Hummer tone oil paint-
colors will be chosen by director of work

perforated galvanized Steel
4 mm panels with
round pattern
Height 2 m

4 mm Galvanized Steel
panels with
designed pattern


Existing tubes- to be painted
Existing Metal Mesh 15*5 cm

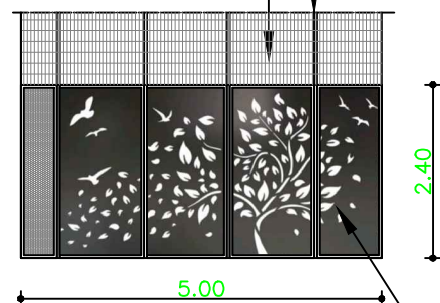


Detailed Section 5-5

4 mm Galvanized Steel
panels with
designed pattern with tube frame 20*20*2 mm

perforated galvanized Steel
4 mm panels with
round pattern
Height 2 m - frame 20*20*2 mm

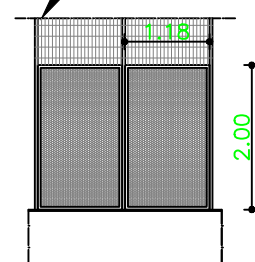

Bee Hive corrugated
polycarbonate sheet,
thickness (2.8 mm)
with slope 1%

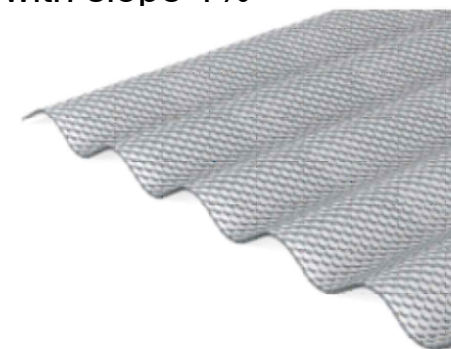


Detailed Section 6-6

Colored Plaster
Epoxy Paint
5-10 cm concrete
screed 1.5 % slope
2cm gravel
4mm waterproofing
5-10 cm concrete
screed slope 1.5-2%

Notes

- (1) All Dimensions Are In M.
- (2) All Levels Are In Meter
- (3) Any Missing or Unclear Detail And All Fastening Systems For All Elements Shall be Approved by The Supervisor.

Legend:

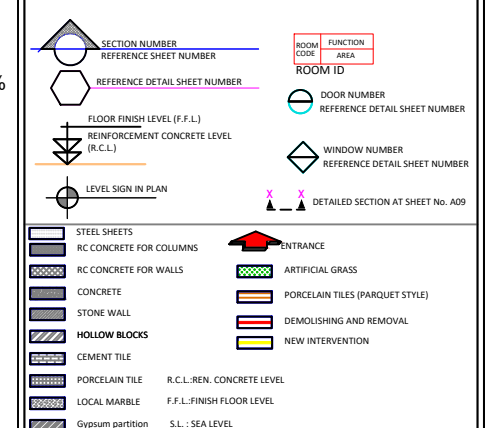

REVISIONS

NO.	DRAWINGS	DATE
(1)		
(2)		
(3)		

Contracting Authority:



Funded By:



Project Title:

"Public Works Contract for the rehabilitation
of 5 schools in East Jerusalem"

Reference number: PSE22001-10074

Lot 1: the rehabilitation of Al-Hasan
Al-Thany, Al-Shabbat Al-Shameleh, and
Al-Fata Al-Laji'a schools in Wadi Al-Joz


Al-Shameleh Secondary
Girls' school

Designed by:



Jerusalem - Sheikh Jarrah- Tobler8
email: mr.wasimhija@gmail.com
Tel: 02-9948344/ 052-8327076
Fax: 02-9948344


Drawing Title	Fence Design	Date: 25/3/2025 Scale: 1:100 Drawing No: A19
Designed by:	Arch. Hiba Al Ayoubi	
Checked by:	Arch. Wasim Abu El-Hija	
Approved by:		
Coordinate Manager:		

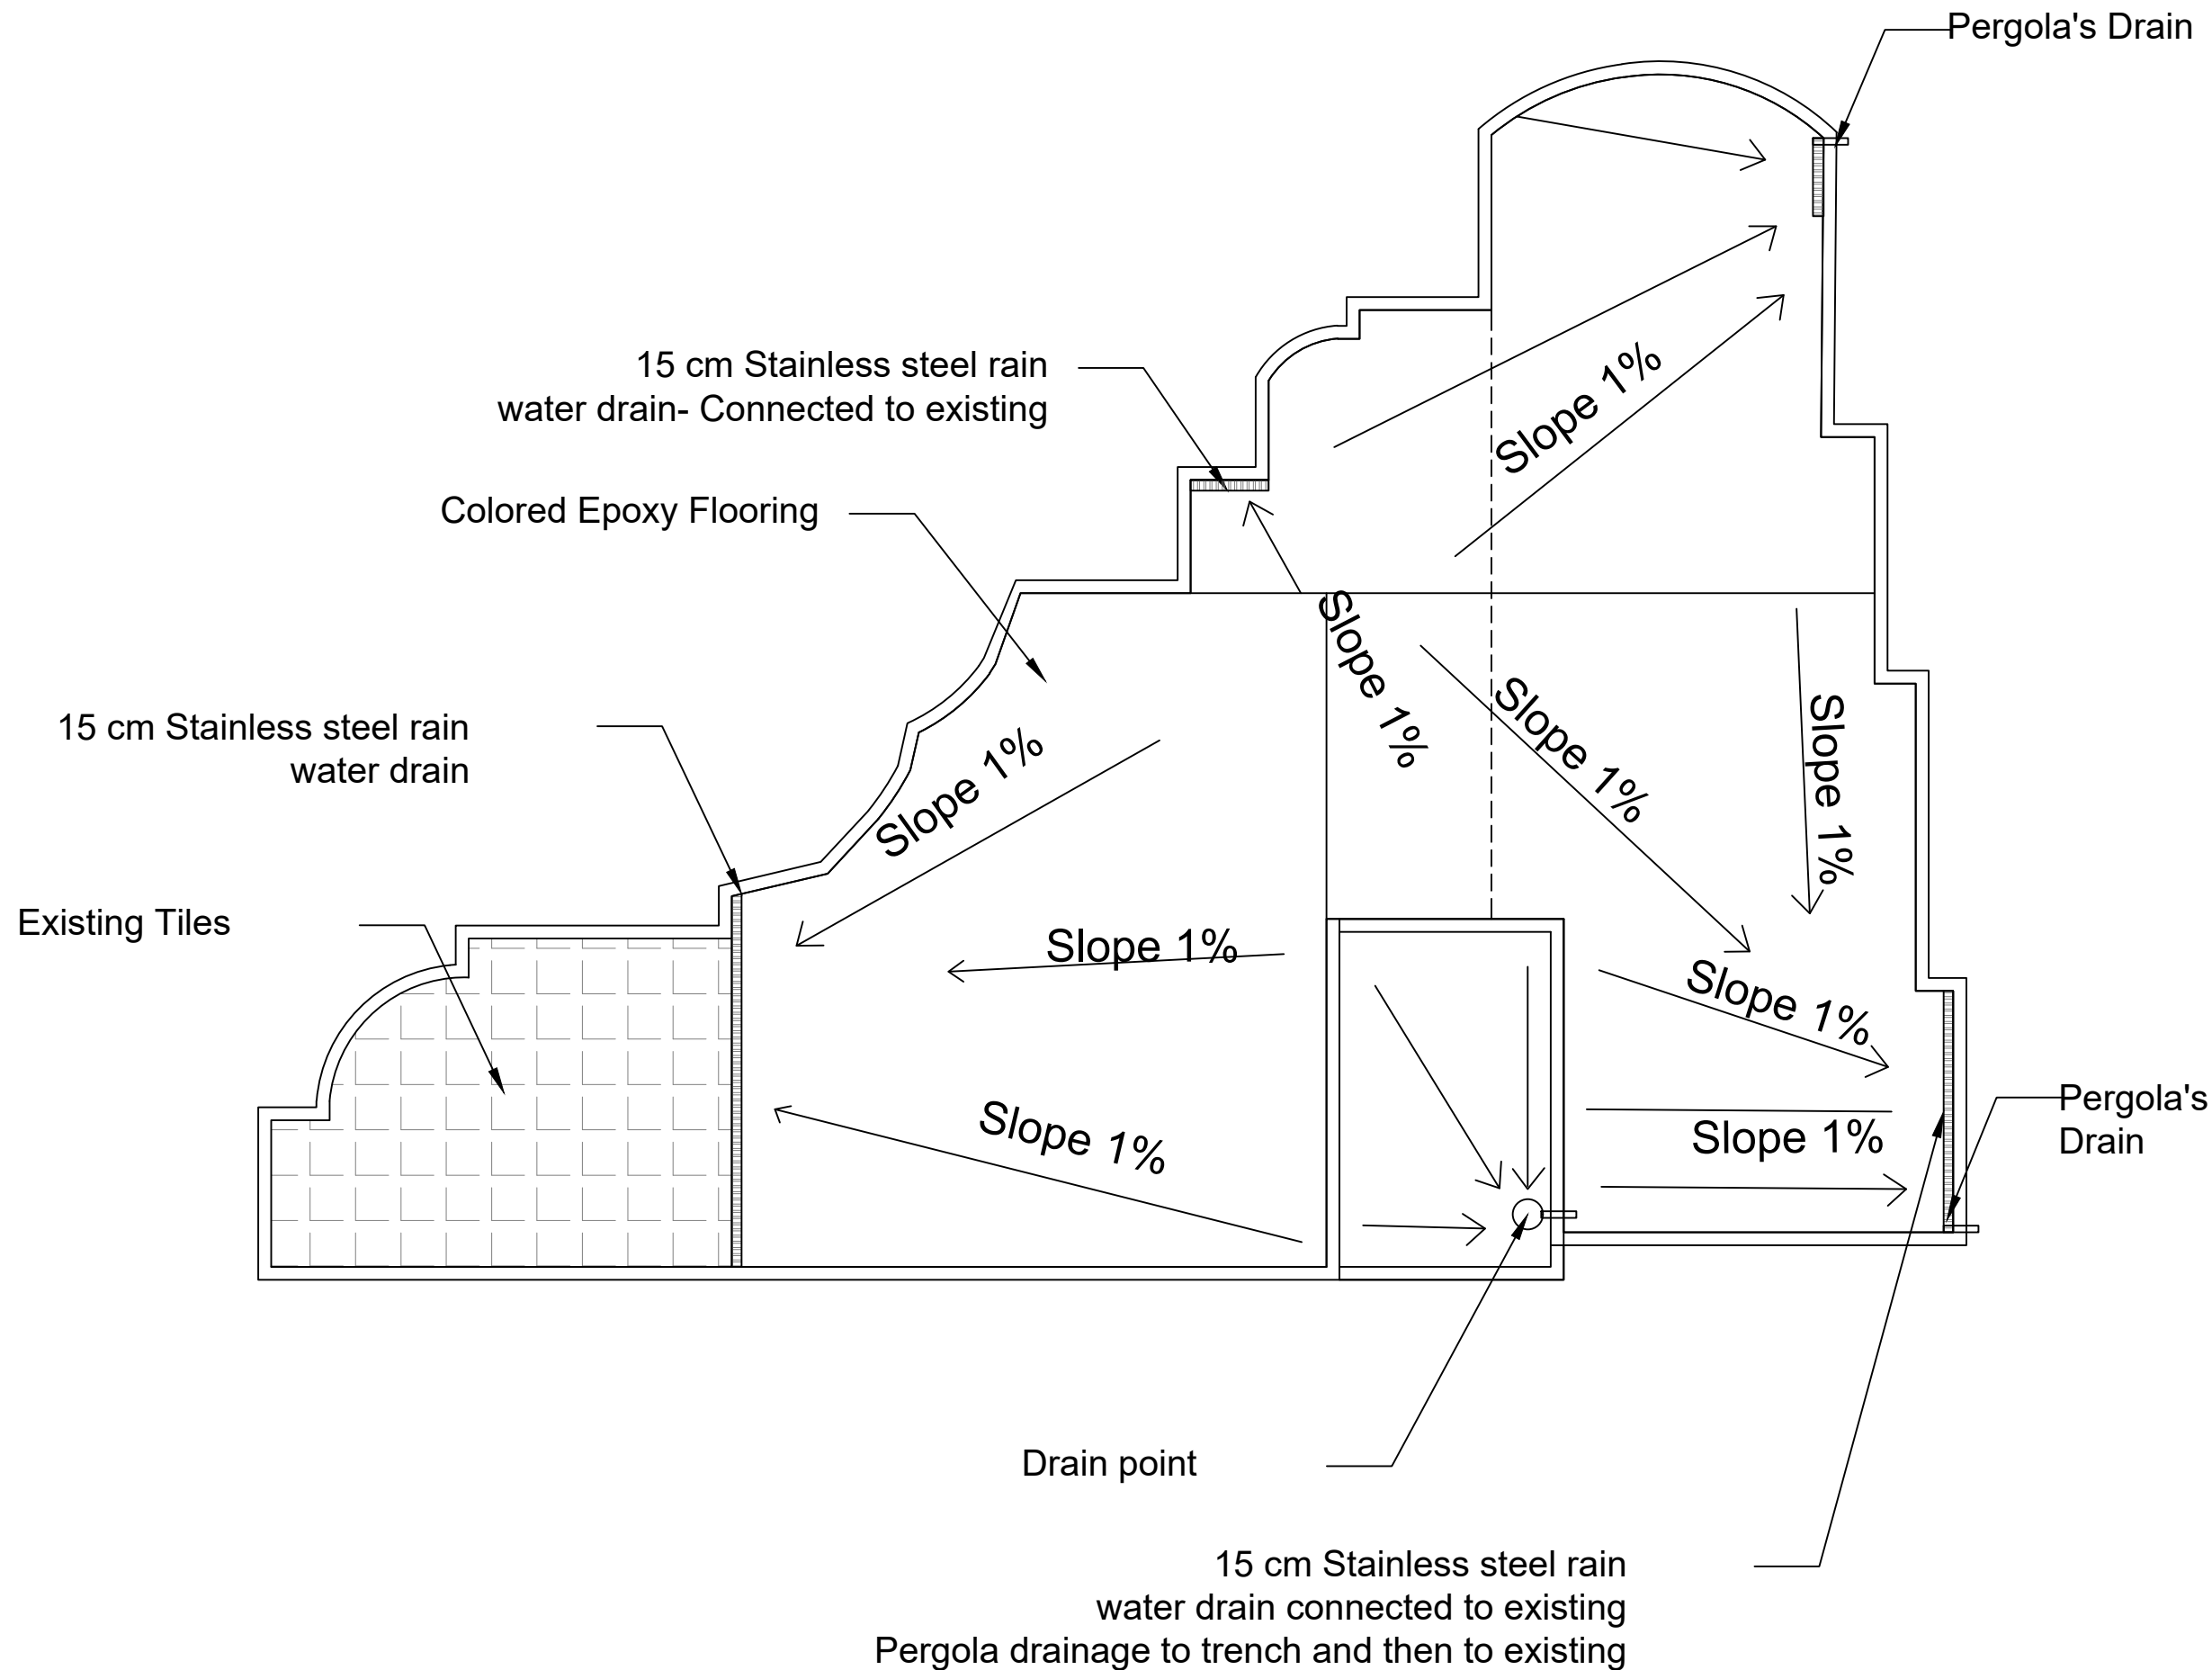

Notes

- (1) All Dimensions Are In M.
- (2) All Levels Are In Meter
- (3) Any Missing or Unclear Detail And All Fastening Systems For All Elements Shall be Approved by The Supervisor.

Legend:

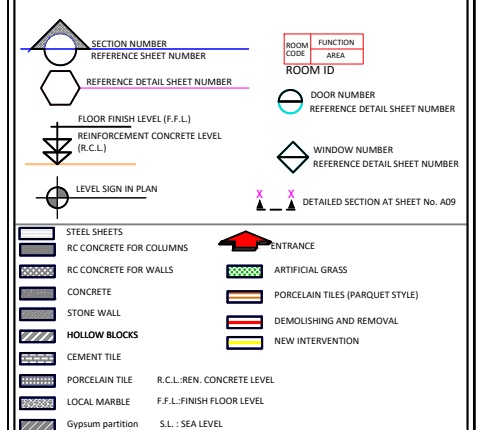

REVISIONS

NO.	DRAWINGS	DATE
(1)		
(2)		
(3)		

Contracting Authority:



Funded By:



Project Title:

"Public Works Contract for the rehabilitation of 5 schools in East Jerusalem"

Reference number: PSE22001-10074

Lot 1: the rehabilitation of Al-Hasan Al-Thany, Al-Shabbat Al-Shameleh, and Al-Fata Al-Laji'a schools in Wadi Al-Joz

Al-Shameleh Secondary Girls' school

Designed by:



Jerusalem - Sheikh Jarrah- Tobler8
email: mr.wasimhija@gmail.com
Tel. 02-9948344/ 052-8327076
Fax: 02-9948344

Drawing Title	Roof Drainage	Date: 25/3/2025 Scale: 1:100
Designed by:	Arch. Hiba Al Ayoubi	Drawing No:
Checked by:	Arch. Wasim Abu El-Hija	A20
Approved by:		
Coordinate Manager:		

Lot1: Al-Shameleh Secondary Girls' school

ARCHITECTURAL DRAWINGS

Notes
(1) All Dimensions Are In M. (2) All Levels Are In Meter (3) Any Missing or Unclear Detail And All Fastening Systems For All Elements Shall be Approved by The Supervisor.

Legend:
SECTION NUMBER REFERENCE SHEET NUMBER REFERENCE DETAIL SHEET NUMBER FLOOR FINISH LEVEL (F.F.L.) REINFORCEMENT CONCRETE LEVEL (R.C.L.) LEVEL SIGN IN PLAN ROOM CODE FUNCTION AREA ROOM ID DOOR NUMBER WINDOW NUMBER DETAILED SECTION AT SHEET No. A09
STEEL SHEETS RC CONCRETE FOR COLUMNS RC CONCRETE FOR WALLS CONCRETE STONE WALL HOLLOW BLOCKS CEMENT TILE PORCELAIN TILE LOCAL MARBLE Gypsum partition ENTRANCE ARTIFICIAL GRASS PORCELAIN TILES (PARQUET STYLE) DEMOLISHING AND REMOVAL NEW INTERVENTION R.C.L.:REN. CONCRETE LEVEL F.F.L.:FINISH FLOOR LEVEL S.L. : SEA LEVEL

REVISIONS		
NO.	DRAWINGS	DATE
(1)		
(2)		
(3)		


Contracting Authority:	
------------------------	--

Funded By:	
------------	--

Project Title: “Public Works Contract for the rehabilitation of 5 schools in East Jerusalem” Reference number: PSE22001-10074 Lot 1: the rehabilitation of Al-Hasan Al-Thany, Al-Shabbat Al-Shameleh, and Al-Fata Al-Laji’a schools in Wadi Al-Joz Al-Shameleh Secondary Girls' school

Designed by:	 HOSH STUDIO ARCHITECTURE & TOWN PLANNING Jerusalem - Sheikh Jarrah- Tobler8 email: mr.wasimhija@gmail.com Tel. 02-9948344/ 052-8327076 Fax: 02-9948344
--------------	---

Drawing Title	Scope of Intervention LIGHTING SYSTEM	Date: 25/3/2025 Scale: 1:100
Designed by:	Arch. Hiba Al Ayoubi	Drawing No:
Checked by:	Arch. Wasim Abu El-Hija	E00
Approved by:		
Coordinate Manager:		

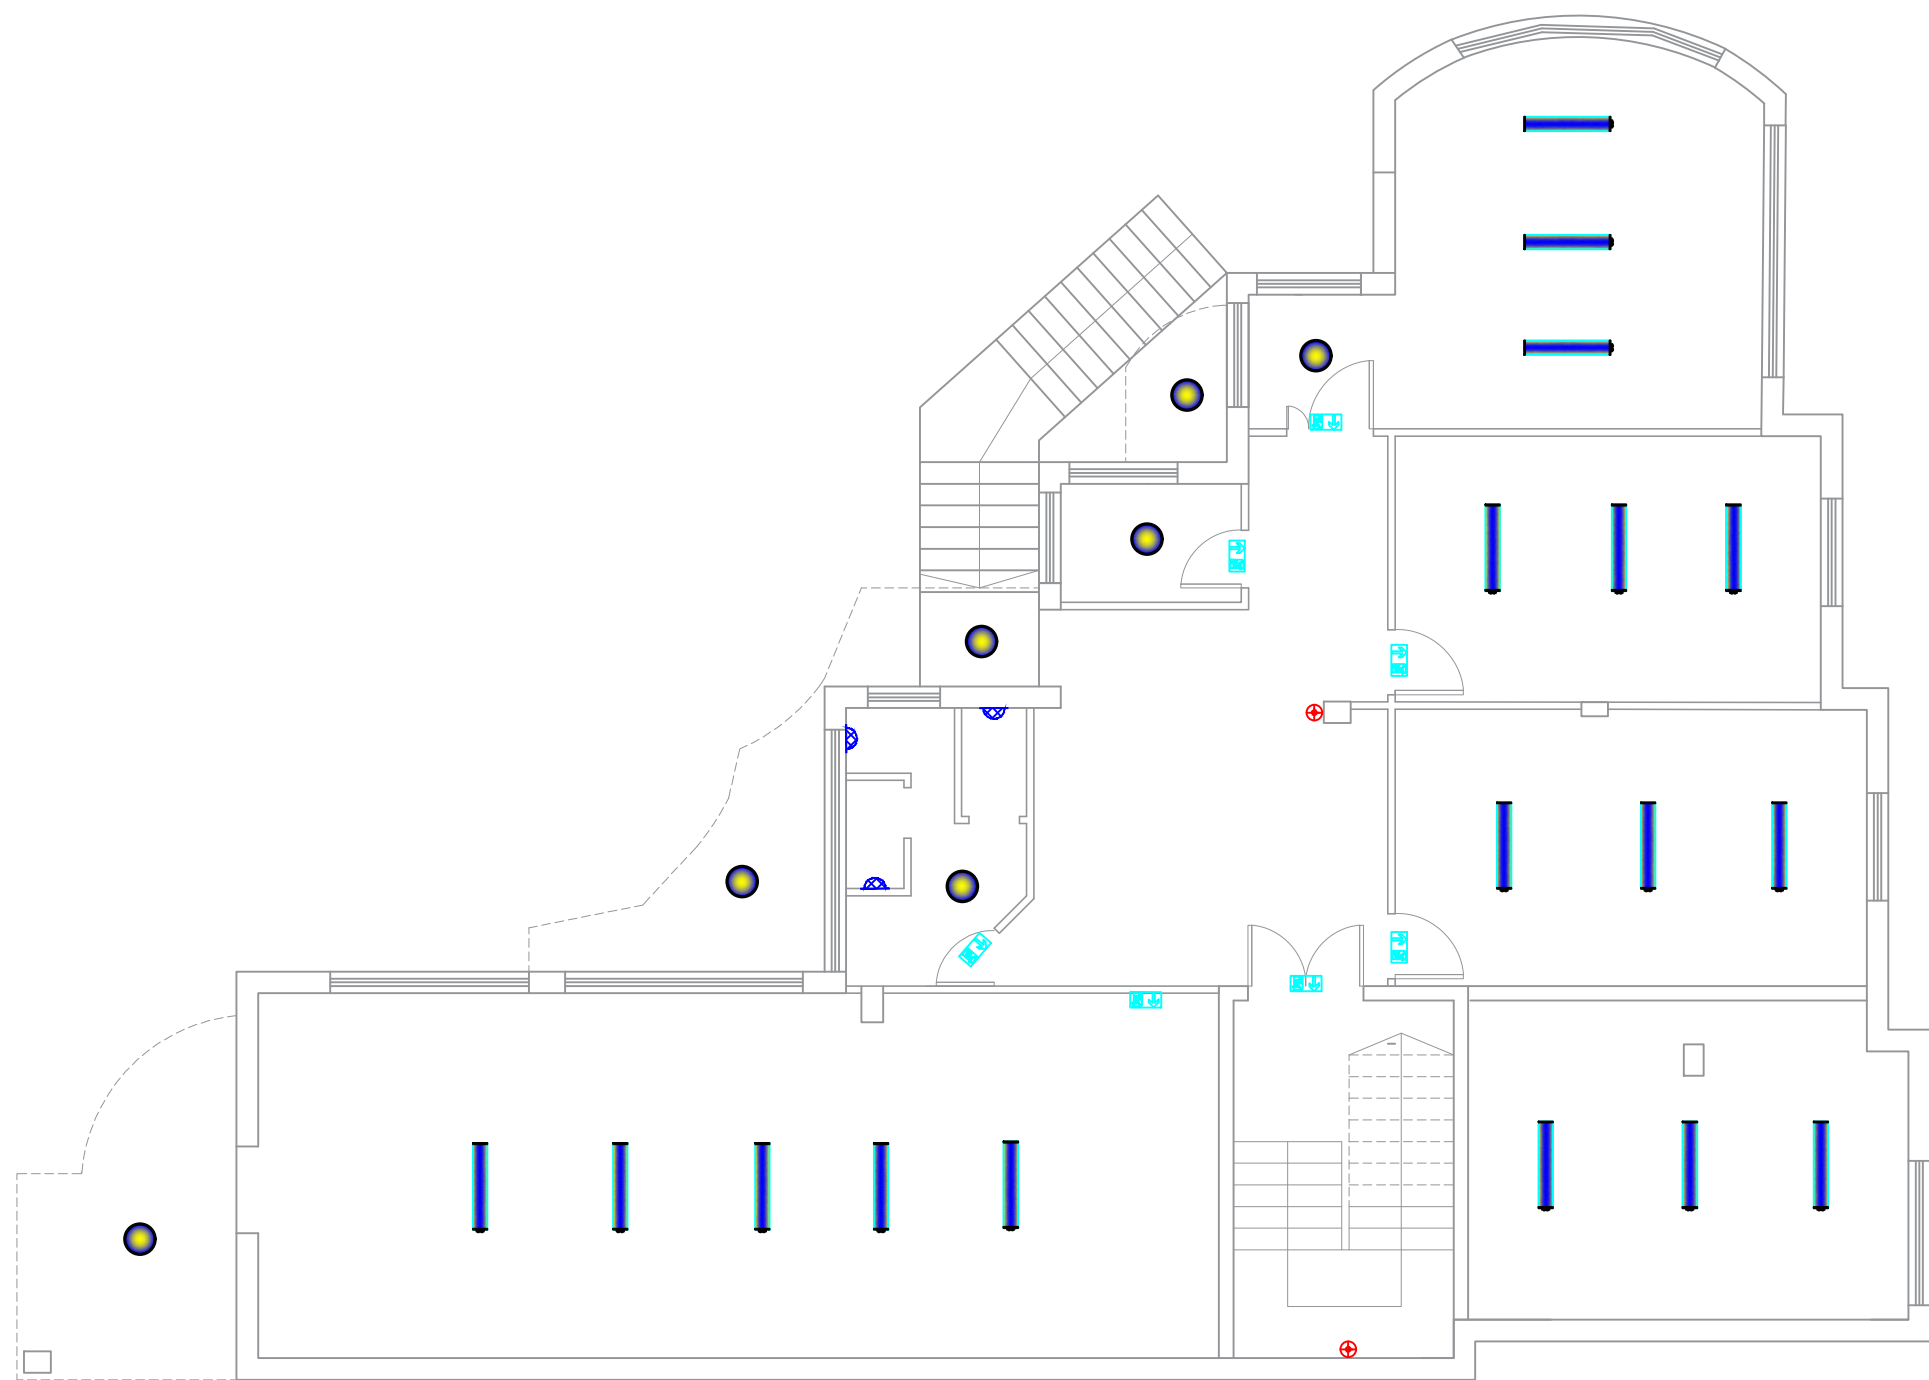

BASEMENT FLOOR

Notes

- (1) All Dimensions Are In M.
- (2) All Levels Are In Meter
- (3) Any Missing or Unclear Detail And All Fastening Systems For All Elements Shall be Approved by The Supervisor.

Legend:

	SECTION NUMBER		ROOM CODE		FUNCTION AREA
	REFERENCE SHEET NUMBER		ROOM ID		
	DOOR NUMBER				
	WINDOW NUMBER				
	FLOOR FINISH LEVEL (F.F.L.)				
	REINFORCEMENT CONCRETE LEVEL (R.C.L.)				
	LEVEL SIGN IN PLAN				
	DETAILED SECTION AT SHEET No. A09				

	STEEL SHEETS		ENTRANCE
	RC CONCRETE FOR COLUMNS		ARTIFICIAL GRASS
	RC CONCRETE FOR WALLS		PORCELAIN TILES (PARQUET STYLE)
	CONCRETE		DEMOLISHING AND REMOVAL
	STONE WALL		NEW INTERVENTION
	HOLLOW BLOCKS		
	CEMENT TILE		
	PORCELAIN TILE		
	LOCAL MARBLE		
	Gypsum partition		

	R.C.L.: REN. CONCRETE LEVEL
	F.F.L.: FINISH FLOOR LEVEL
	S.L.: SEA LEVEL

REVISIONS

NO.	DRAWINGS	DATE
(1)		
(2)		
(3)		

Contracting Authority:



Funded By:



Project Title:

“Public Works Contract for the rehabilitation of 5 schools in East Jerusalem”

Reference number: PSE22001-10074

Lot 1: the rehabilitation of Al-Hasan Al-Thany, Al-Shabbat Al-Shameleh, and Al-Fata Al-Laji’a schools in Wadi Al-Joz


Al-Shameleh Secondary Girls' school

Designed by:



Jerusalem - Sheikh Jarrah- Tobler8
email: mr.wasimhija@gmail.com
Tel. 02-9948344/ 052-8327076
Fax: 02-9948344

Drawing Title	Scope of Intervention	Date: 25/3/2025
	LIGHTING SYSTEM	Scale: 1:100
Designed by:	Arch. Hiba Al Ayoubi	Drawing No:
Checked by:	Arch. Wasim Abu El-Hija	E20
Approved by:		
Coordinate Manager:		

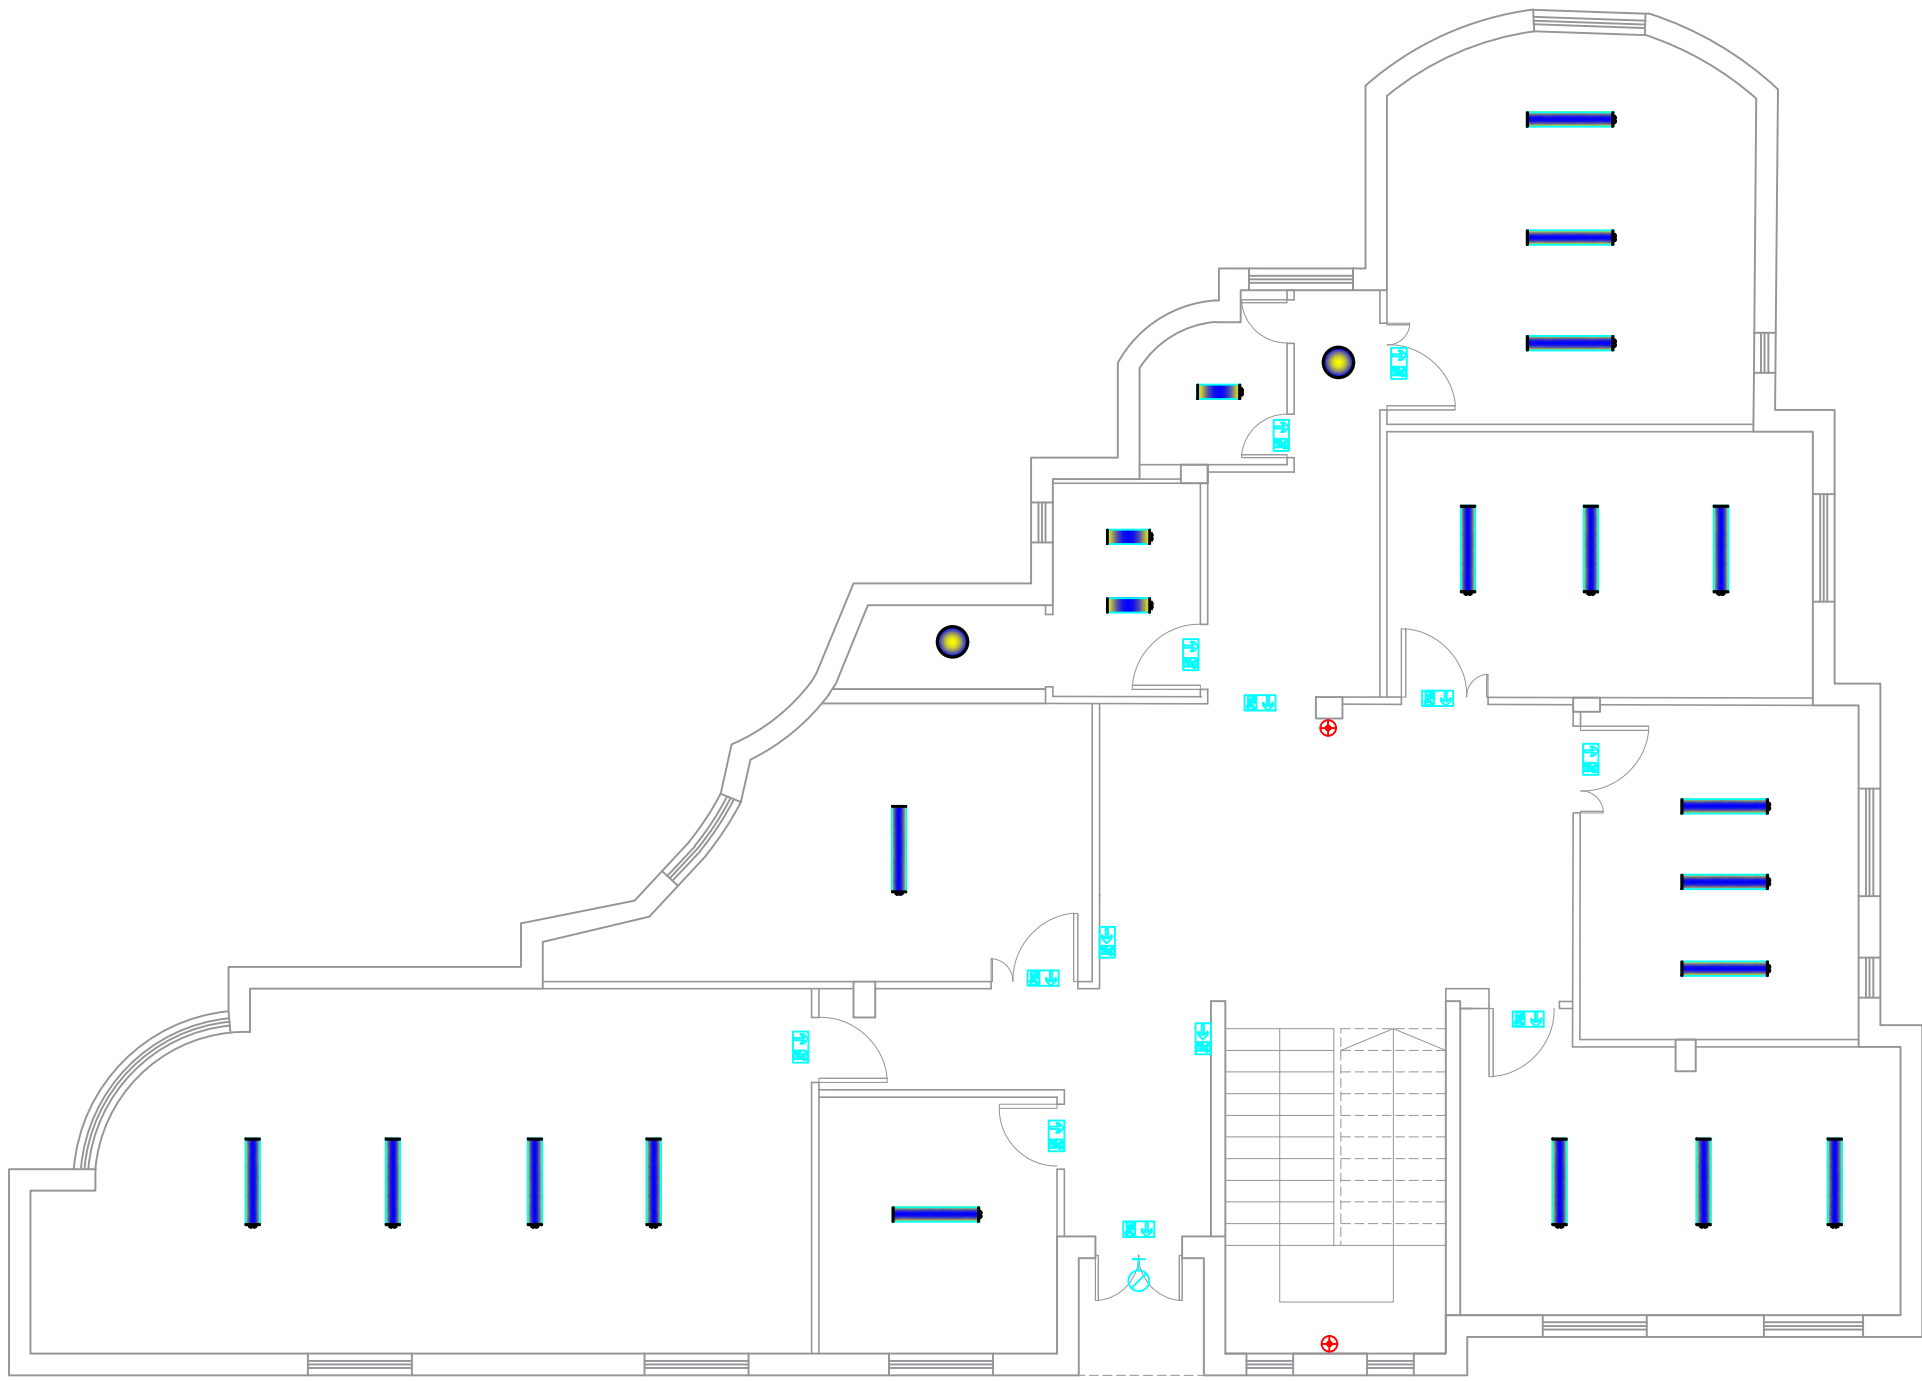

GROUND FLOOR

Notes

(1) All Dimensions Are In M.
(2) All Levels Are In Meter
(3) Any Missing or Unclear Detail And All Fastening Systems For All Elements Shall be Approved by The Supervisor.

Legend:

SECTION NUMBER
REFERENCE SHEET NUMBER

REFERENCE DETAIL SHEET NUMBER

FLOOR FINISH LEVEL (F.F.L.)
REINFORCEMENT CONCRETE LEVEL (R.C.L.)

LEVEL SIGN IN PLAN

STEEL SHEETS

RC CONCRETE FOR COLUMNS

RC CONCRETE FOR WALLS

CONCRETE

STONE WALL

HOLLOW BLOCKS

CEMENT TILE

PORCELAIN TILE

LOCAL MARBLE

Gypsum partition

ENTRANCE

ARTIFICIAL GRASS

PORCELAIN TILES (PARQUET STYLE)

DEMOLISHING AND REMOVAL

NEW INTERVENTION

DOOR NUMBER
REFERENCE DETAIL SHEET NUMBER

WINDOW NUMBER
REFERENCE DETAIL SHEET NUMBER

DETAILED SECTION AT SHEET No. A09

R.C.L.: REN. CONCRETE LEVEL

F.F.L.: FINISH FLOOR LEVEL

S.L.: SEA LEVEL

REVISIONS		
NO.	DRAWINGS	DATE
(1)		
(2)		
(3)		

Contracting Authority:

Funded By:

Project Title:

“Public Works Contract for the rehabilitation of 5 schools in East Jerusalem”

Reference number: PSE22001-10074

Lot 1: the rehabilitation of Al-Hasan Al-Thany, Al-Shabbat Al-Shameleh, and Al-Fata Al-Laji’a schools in Wadi Al-Joz

Al-Shameleh Secondary Girls' school


Designed by:

HOSH STUDIO
ARCHITECTURE & TOWN PLANNING

Jerusalem - Sheikh Jarrah- Tobler8
email: mr.wasimhija@gmail.com

Tel. 02-9948344/ 052-8327076
Fax: 02-9948344

Drawing Title	Scope of Intervention	Date: 25/3/2025 Scale: 1:100
Designed by:	Arch. Hiba Al Ayoubi	Drawing No: E21
Checked by:	Arch. Wasim Abu El-Hija	
Approved by:		
Coordinate Manager:		

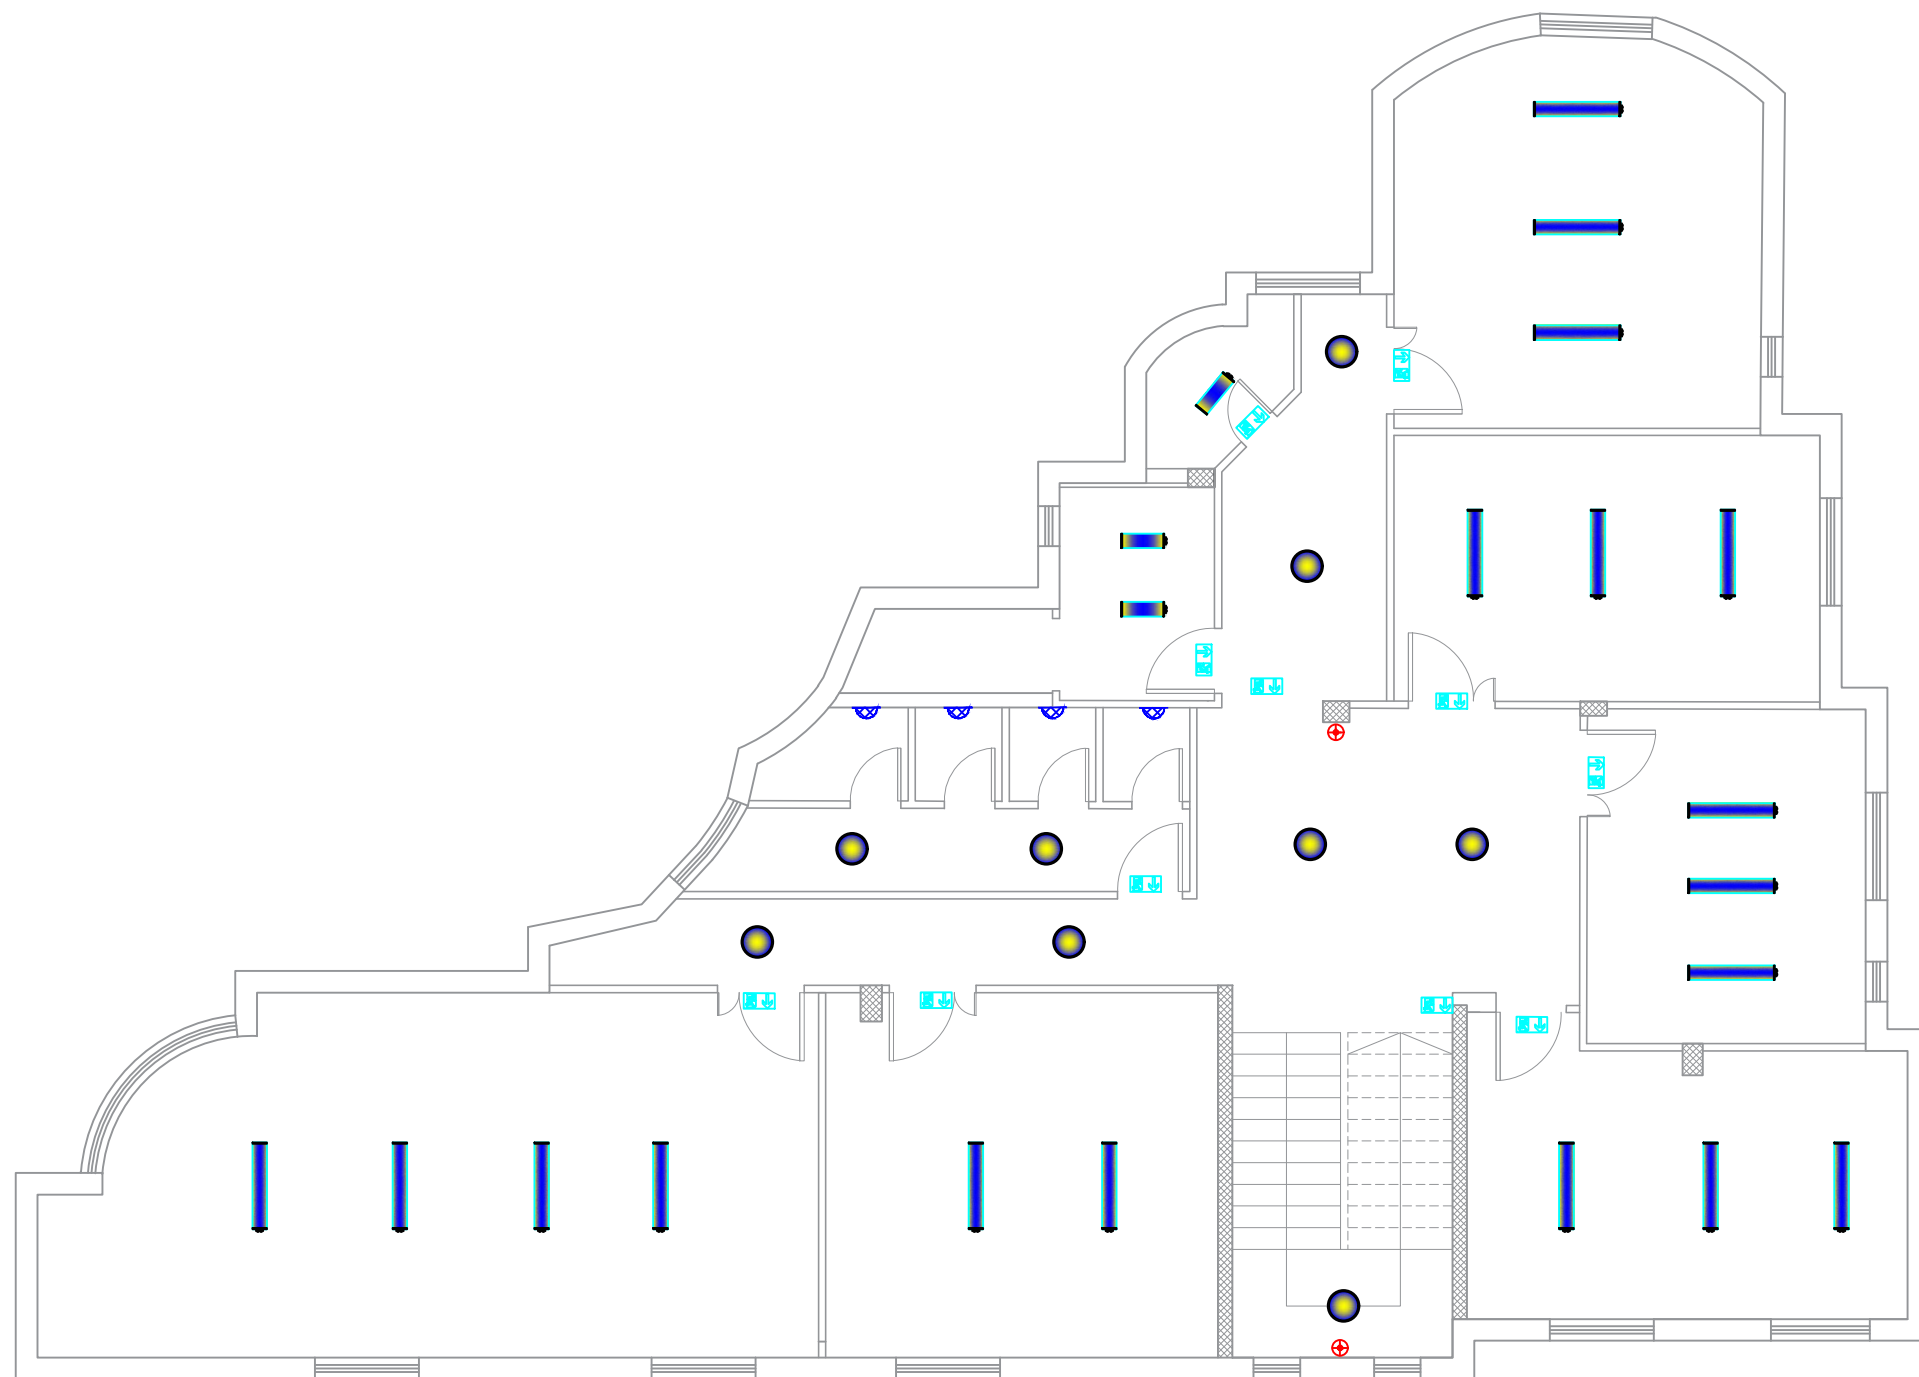

FIRST FLOOR &

Notes

- (1) All Dimensions Are In M.
- (2) All Levels Are In Meter
- (3) Any Missing or Unclear Detail And All Fastening Systems For All Elements Shall be Approved by The Supervisor.

Legend:

SECTION NUMBER
REFERENCE SHEET NUMBER
REFERENCE DETAIL SHEET NUMBER
FLOOR FINISH LEVEL (F.F.L.)
REINFORCEMENT CONCRETE LEVEL (R.C.L.)
LEVEL SIGN IN PLAN

ROOM CODE
FUNCTION AREA
ROOM ID
DOOR NUMBER
REFERENCE DETAIL SHEET NUMBER
WINDOW NUMBER
REFERENCE DETAIL SHEET NUMBER
DETAILED SECTION AT SHEET No. A09

STEEL SHEETS
RC CONCRETE FOR COLUMNS
RC CONCRETE FOR WALLS
CONCRETE
STONE WALL
HOLLOW BLOCKS
CEMENT TILE
PORCELAIN TILE
LOCAL MARBLE
Gypsum partition

ENTRANCE
ARTIFICIAL GRASS
PORCELAIN TILES (PARQUET STYLE)
DEMOLISHING AND REMOVAL
NEW INTERVENTION

R.C.L.: REN. CONCRETE LEVEL
F.F.L.: FINISH FLOOR LEVEL
S.L.: SEA LEVEL

REVISIONS

NO.	DRAWINGS	DATE
(1)		
(2)		
(3)		

Contracting Authority:



Funded By:



Project Title:

“Public Works Contract for the rehabilitation of 5 schools in East Jerusalem”

Reference number: PSE22001-10074

Lot 1: the rehabilitation of Al-Hasan Al-Thany, Al-Shabbat Al-Shameleh, and Al-Fata Al-Laji’a schools in Wadi Al-Joz


Al-Shameleh Secondary Girls' school

Designed by:



Jerusalem - Sheikh Jarrah- Tobler8
email: mr.wasimhija@gmail.com
Tel. 02-9948344/ 052-8327076
Fax: 02-9948344

Drawing Title	Scope of Intervention	Date: 25/3/2025 Scale: 1:100
Designed by:	Arch. Hiba Al Ayoubi	Drawing No: E22
Checked by:	Arch. Wasim Abu El-Hija	
Approved by:		
Coordinate Manager:		

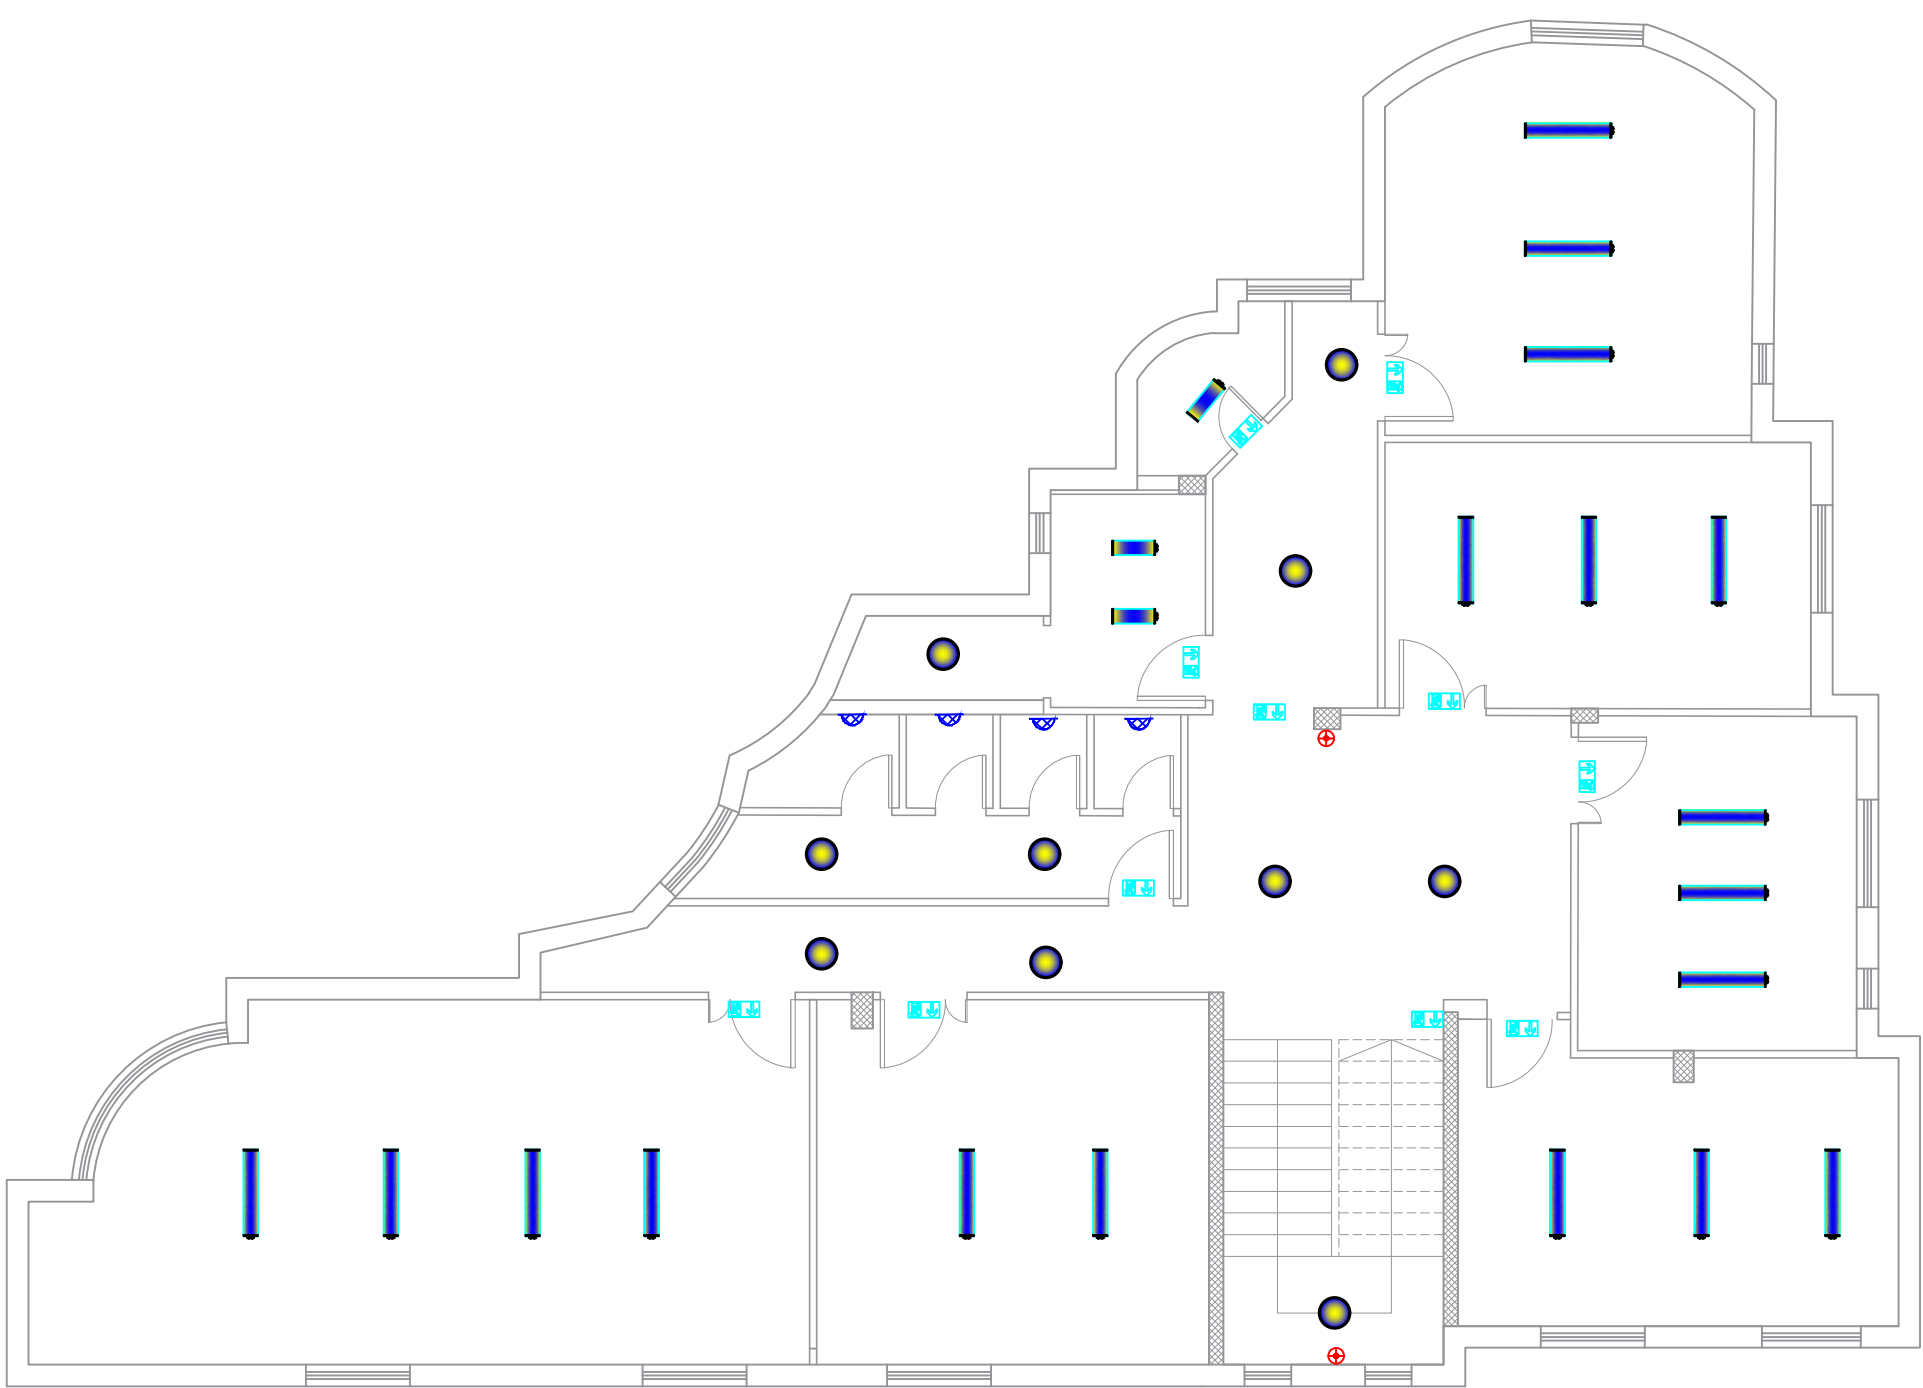

SECOND FLOOR

Notes

(1) All Dimensions Are In M.
(2) All Levels Are In Meter
(3) Any Missing or Unclear Detail And All Fastening Systems For All Elements Shall be Approved by The Supervisor.

Legend:

SECTION NUMBER
REFERENCE SHEET NUMBER

REFERENCE DETAIL SHEET NUMBER

FLOOR FINISH LEVEL (F.F.L.)

REINFORCEMENT CONCRETE LEVEL (R.C.L.)

LEVEL SIGN IN PLAN

STEEL SHEETS

RC CONCRETE FOR COLUMNS

RC CONCRETE FOR WALLS

CONCRETE

STONE WALL

HOLLOW BLOCKS

CEMENT TILE

PORCELAIN TILE

LOCAL MARBLE

Gypsum partition

ENTRANCE

ARTIFICIAL GRASS

PORCELAIN TILES (PARQUET STYLE)

DEMOLISHING AND REMOVAL

NEW INTERVENTION

DOOR NUMBER
REFERENCE DETAIL SHEET NUMBER

WINDOW NUMBER
REFERENCE DETAIL SHEET NUMBER

DETAILED SECTION AT SHEET No. A09

R.C.L.:REN. CONCRETE LEVEL

F.F.L.:FINISH FLOOR LEVEL

S.L. : SEA LEVEL

REVISIONS		
NO.	DRAWINGS	DATE
(1)		
(2)		
(3)		

Contracting Authority:

Funded By:

Project Title:

“Public Works Contract for the rehabilitation of 5 schools in East Jerusalem”

Reference number: PSE22001-10074

Lot 1: the rehabilitation of Al-Hasan Al-Thany, Al-Shabbat Al-Shameleh, and Al-Fata Al-Laji’a schools in Wadi Al-Joz

Al-Shameleh Secondary Girls' school


Designed by:

HOSH STUDIO
ARCHITECTURE & TOWN PLANNING

Jerusalem - Sheikh Jarrah- Tobler8
email: mr.wasimhija@gmail.com

Tel. 02-9948344/ 052-8327076
Fax: 02-9948344

Drawing Title	Scope of Intervention	Date: 25/3/2025 Scale: 1:100
Designed by:	Arch. Hiba Al Ayoubi	Drawing No: E23
Checked by:	Arch. Wasim Abu El-Hija	
Approved by:		
Coordinate Manager:		

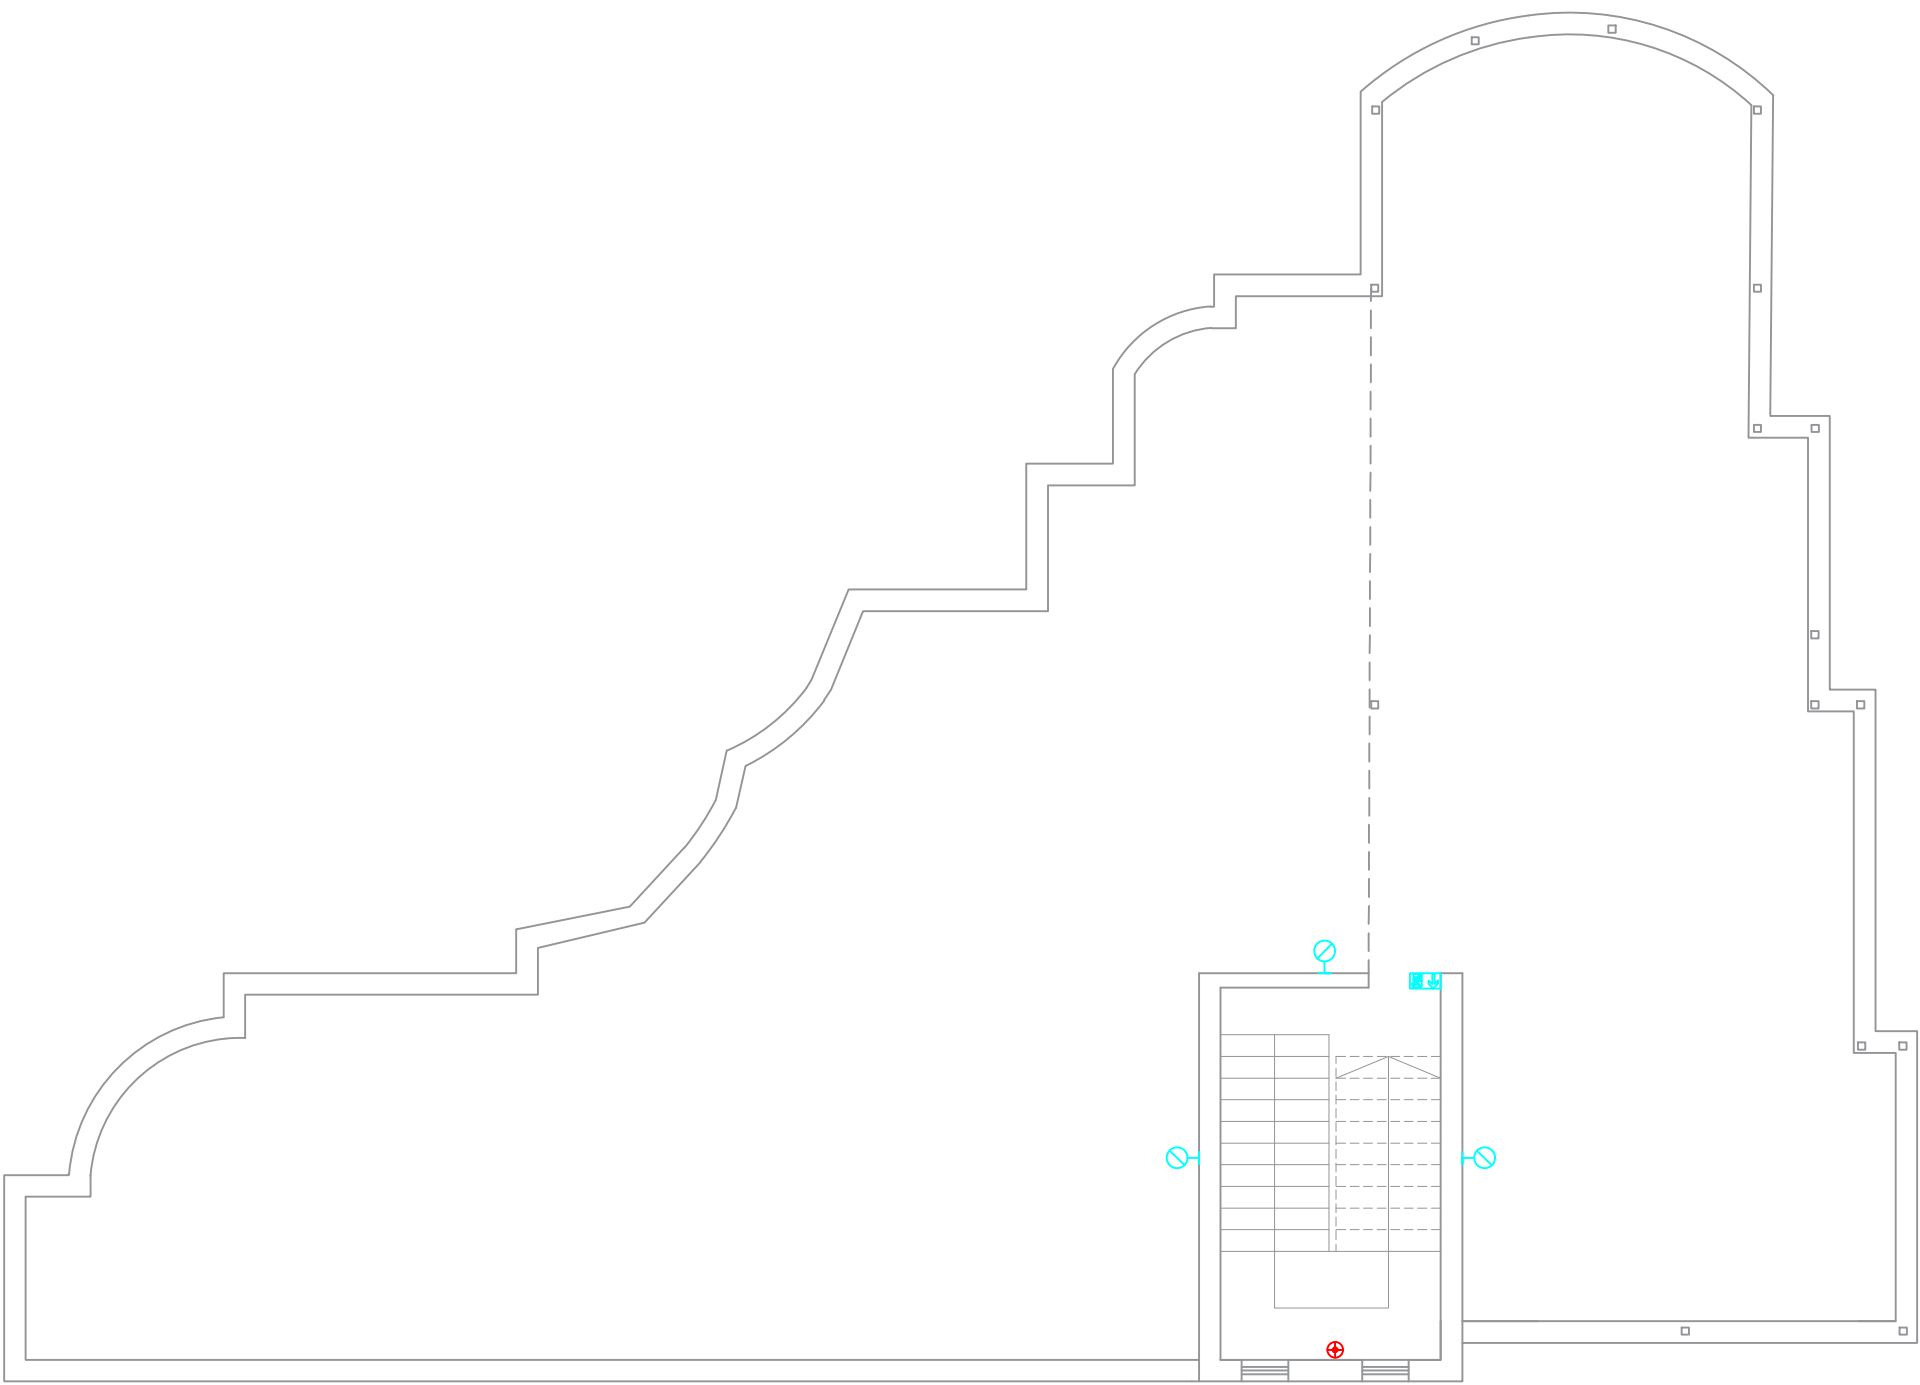

ROOF FLOOR PLAN

Notes

(1) All Dimensions Are In M.
(2) All Levels Are In Meter
(3) Any Missing or Unclear Detail And All Fastening Systems For All Elements Shall be Approved by The Supervisor.

Legend:

SECTION NUMBER
REFERENCE SHEET NUMBER

REFERENCE DETAIL SHEET NUMBER

FLOOR FINISH LEVEL (F.F.L.)
REINFORCEMENT CONCRETE LEVEL (R.C.L.)

LEVEL SIGN IN PLAN

STEEL SHEETS

RC CONCRETE FOR COLUMNS

RC CONCRETE FOR WALLS

STONE WALL

HOLLOW BLOCKS

CEMENT TILE

PORCELAIN TILE

LOCAL MARBLE

Gypsum partition

FUNCTION
AREA
ROOM ID

DOOR NUMBER
REFERENCE DETAIL SHEET NUMBER

WINDOW NUMBER
REFERENCE DETAIL SHEET NUMBER

ENTRANCE

ARTIFICIAL GRASS

PORCELAIN TILES (PARQUET STYLE)

DEMOLISHING AND REMOVAL

NEW INTERVENTION

R.C.L.:REN. CONCRETE LEVEL

F.F.L.:FINISH FLOOR LEVEL

S.L. : SEA LEVEL

DETAILED SECTION AT SHEET No. A09

REVISIONS

NO.	DRAWINGS	DATE
(1)		
(2)		
(3)		

Contracting Authority:

Enabel

Funded By:

Belgium

partner in development

Project Title:

“Public Works Contract for the rehabilitation of 5 schools in East Jerusalem”

Reference number: PSE22001-10074

Lot 1: the rehabilitation of Al-Hasan Al-Thany, Al-Shabbat Al-Shameleh, and Al-Fata Al-Laji’a schools in Wadi Al-Joz

Al-Shameleh Secondary Girls' school

Designed by:


HOSH STUDIO

ARCHITECTURE & TOWN PLANNING

Jerusalem - Sheikh Jarrah- Tobler8
email: mr.wasimhija@gmail.com

Tel. 02-9948344/ 052-8327076
Fax: 02-9948344

Drawing Title	Scope of Intervention LIGHTING SYSTEM	Date: 25/3/2025 Scale: 1:100
Designed by:	Arch. Hiba Al Ayoubi	Drawing No: E24
Checked by:	Arch. Wasim Abu El-Hija	
Approved by:		
Coordinate Manager:		

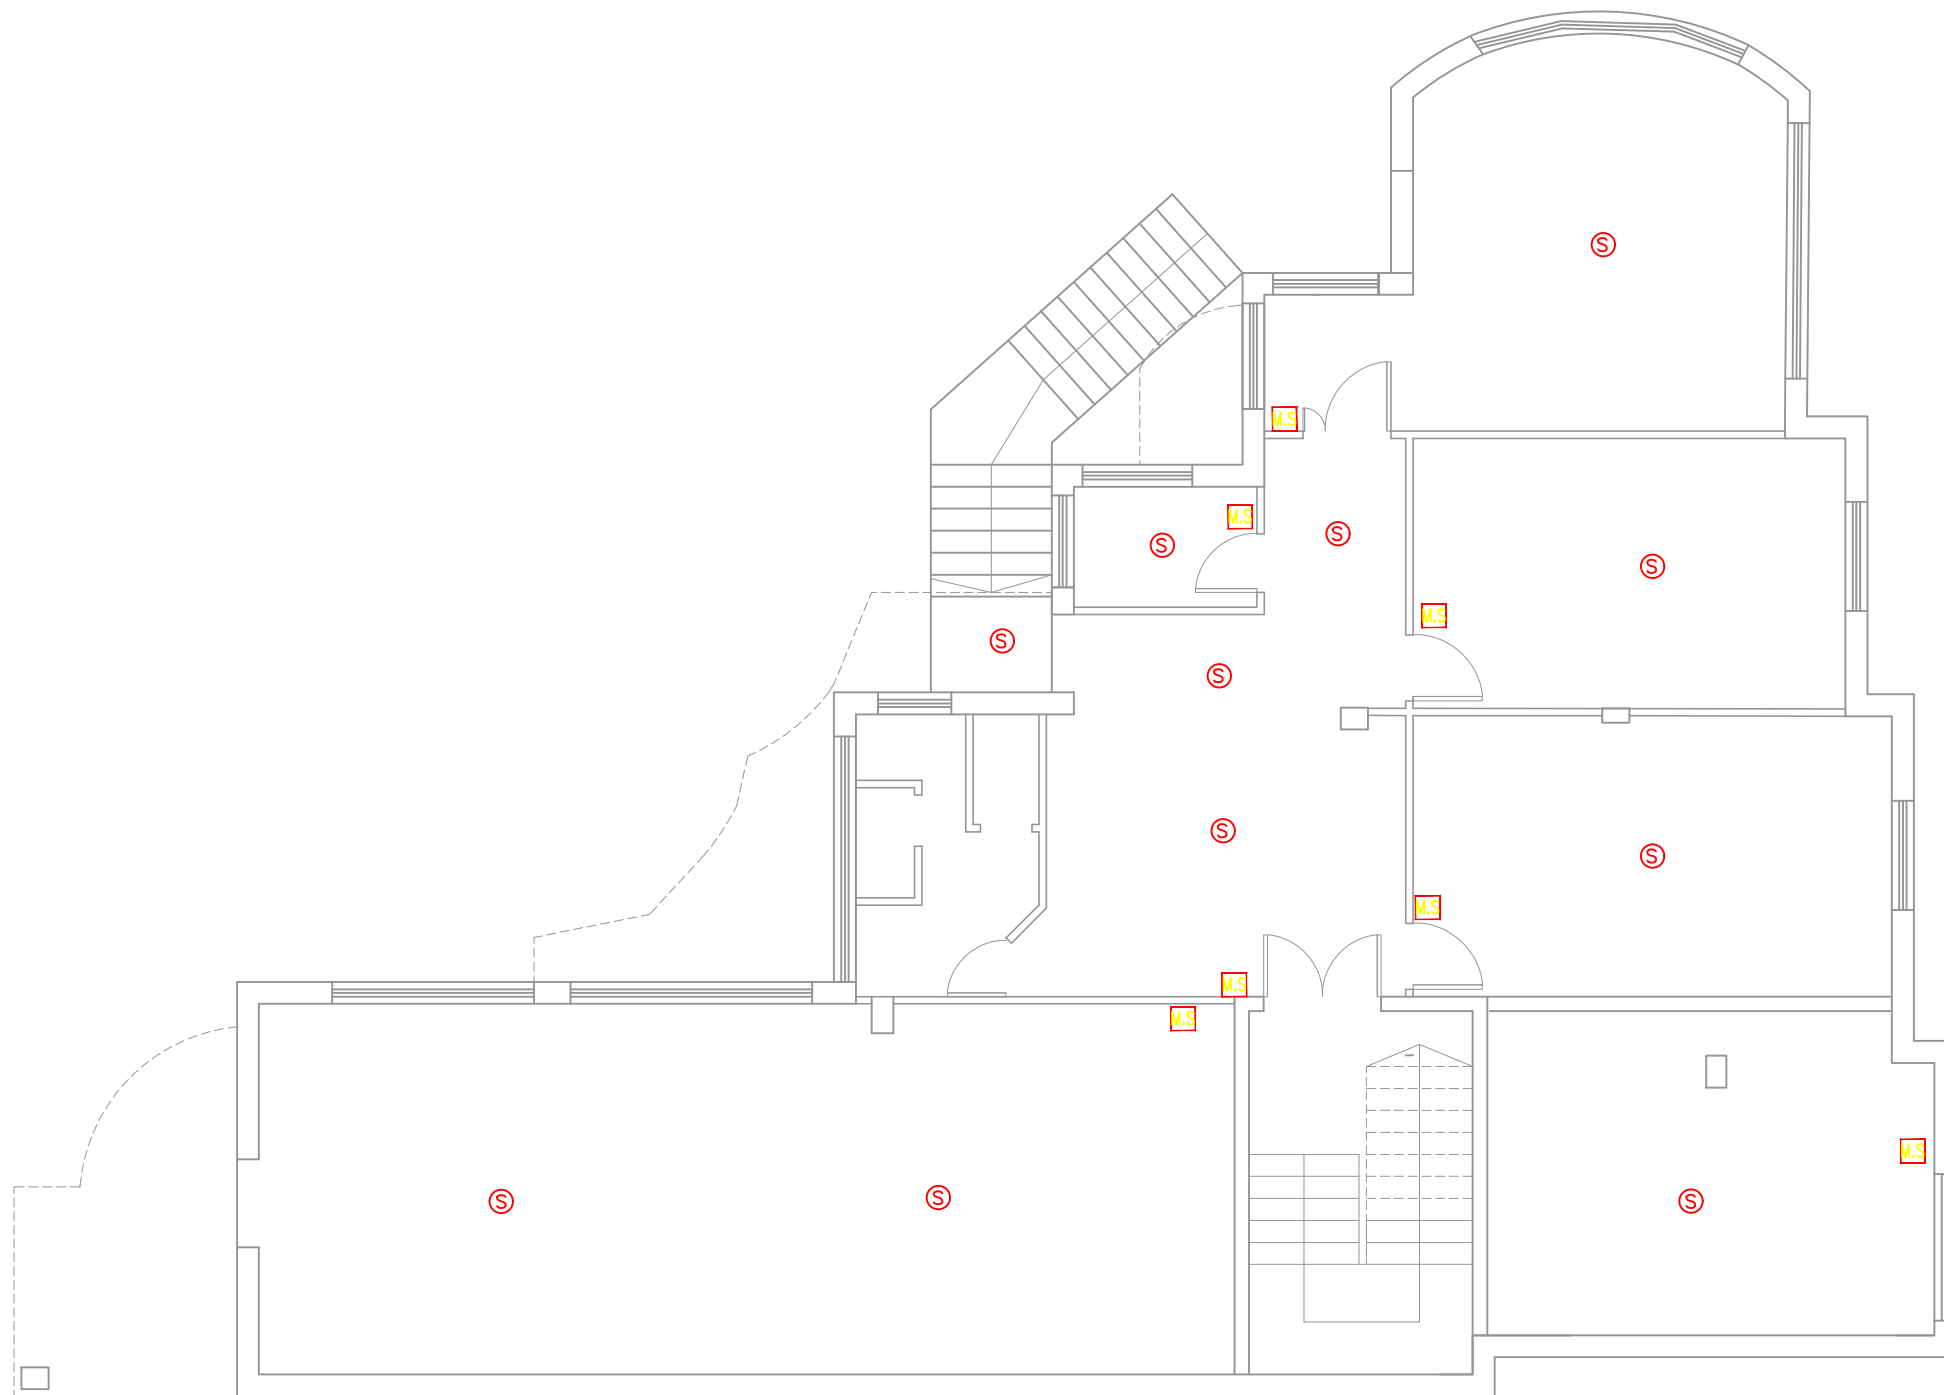

BASEMENT FLOOR

Notes

(1) All Dimensions Are In M.
(2) All Levels Are In Meter
(3) Any Missing or Unclear Detail And All Fastening Systems For All Elements Shall be Approved by The Supervisor.

Legend:

SECTION NUMBER

REFERENCE SHEET NUMBER

REFERENCE DETAIL SHEET NUMBER

FLOOR FINISH LEVEL (F.F.L.)

REINFORCEMENT CONCRETE LEVEL (R.C.L.)

LEVEL SIGN IN PLAN

ROOM

AREA

ROOM ID

DOOR NUMBER

REFERENCE DETAIL SHEET NUMBER

WINDOW NUMBER

REFERENCE DETAIL SHEET NUMBER

DETAILED SECTION AT SHEET No. A09

STEEL SHEETS

RC CONCRETE FOR COLUMNS

RC CONCRETE FOR WALLS

CONCRETE

STONE WALL

HOLLOW BLOCKS

CEMENT TILE

PORCELAIN TILE

LOCAL MARBLE

Gypsum partition

ENTRANCE

ARTIFICIAL GRASS

PORCELAIN TILES (PARQUET STYLE)

DEMOLISHING AND REMOVAL

NEW INTERVENTION

R.C.L.:REN. CONCRETE LEVEL

F.F.L.:FINISH FLOOR LEVEL

S.L. : SEA LEVEL

REVISIONS		
NO.	DRAWINGS	DATE
(1)		
(2)		
(3)		

Contracting Authority:

Funded By:

Project Title:

“Public Works Contract for the rehabilitation of 5 schools in East Jerusalem”

Reference number: PSE22001-10074

Lot 1: the rehabilitation of Al-Hasan Al-Thany, Al-Shabbat Al-Shameleh, and Al-Fata Al-Laji’a schools in Wadi Al-Joz

Al-Shameleh Secondary Girls' school


Designed by:

HOSH STUDIO
ARCHITECTURE & TOWN PLANNING

Jerusalem - Sheikh Jarrah- Tobler8
email: mr.wasimhija@gmail.com

Tel. 02-9948344/ 052-8327076
Fax: 02-9948344

Drawing Title	Scope of Intervention	Date: 25/3/2025 Scale: 1:100
Designed by:	Arch. Hiba Al Ayoubi	Drawing No:
Checked by:	Arch. Wasim Abu El-Hija	E25
Approved by:		
Coordinate Manager:		

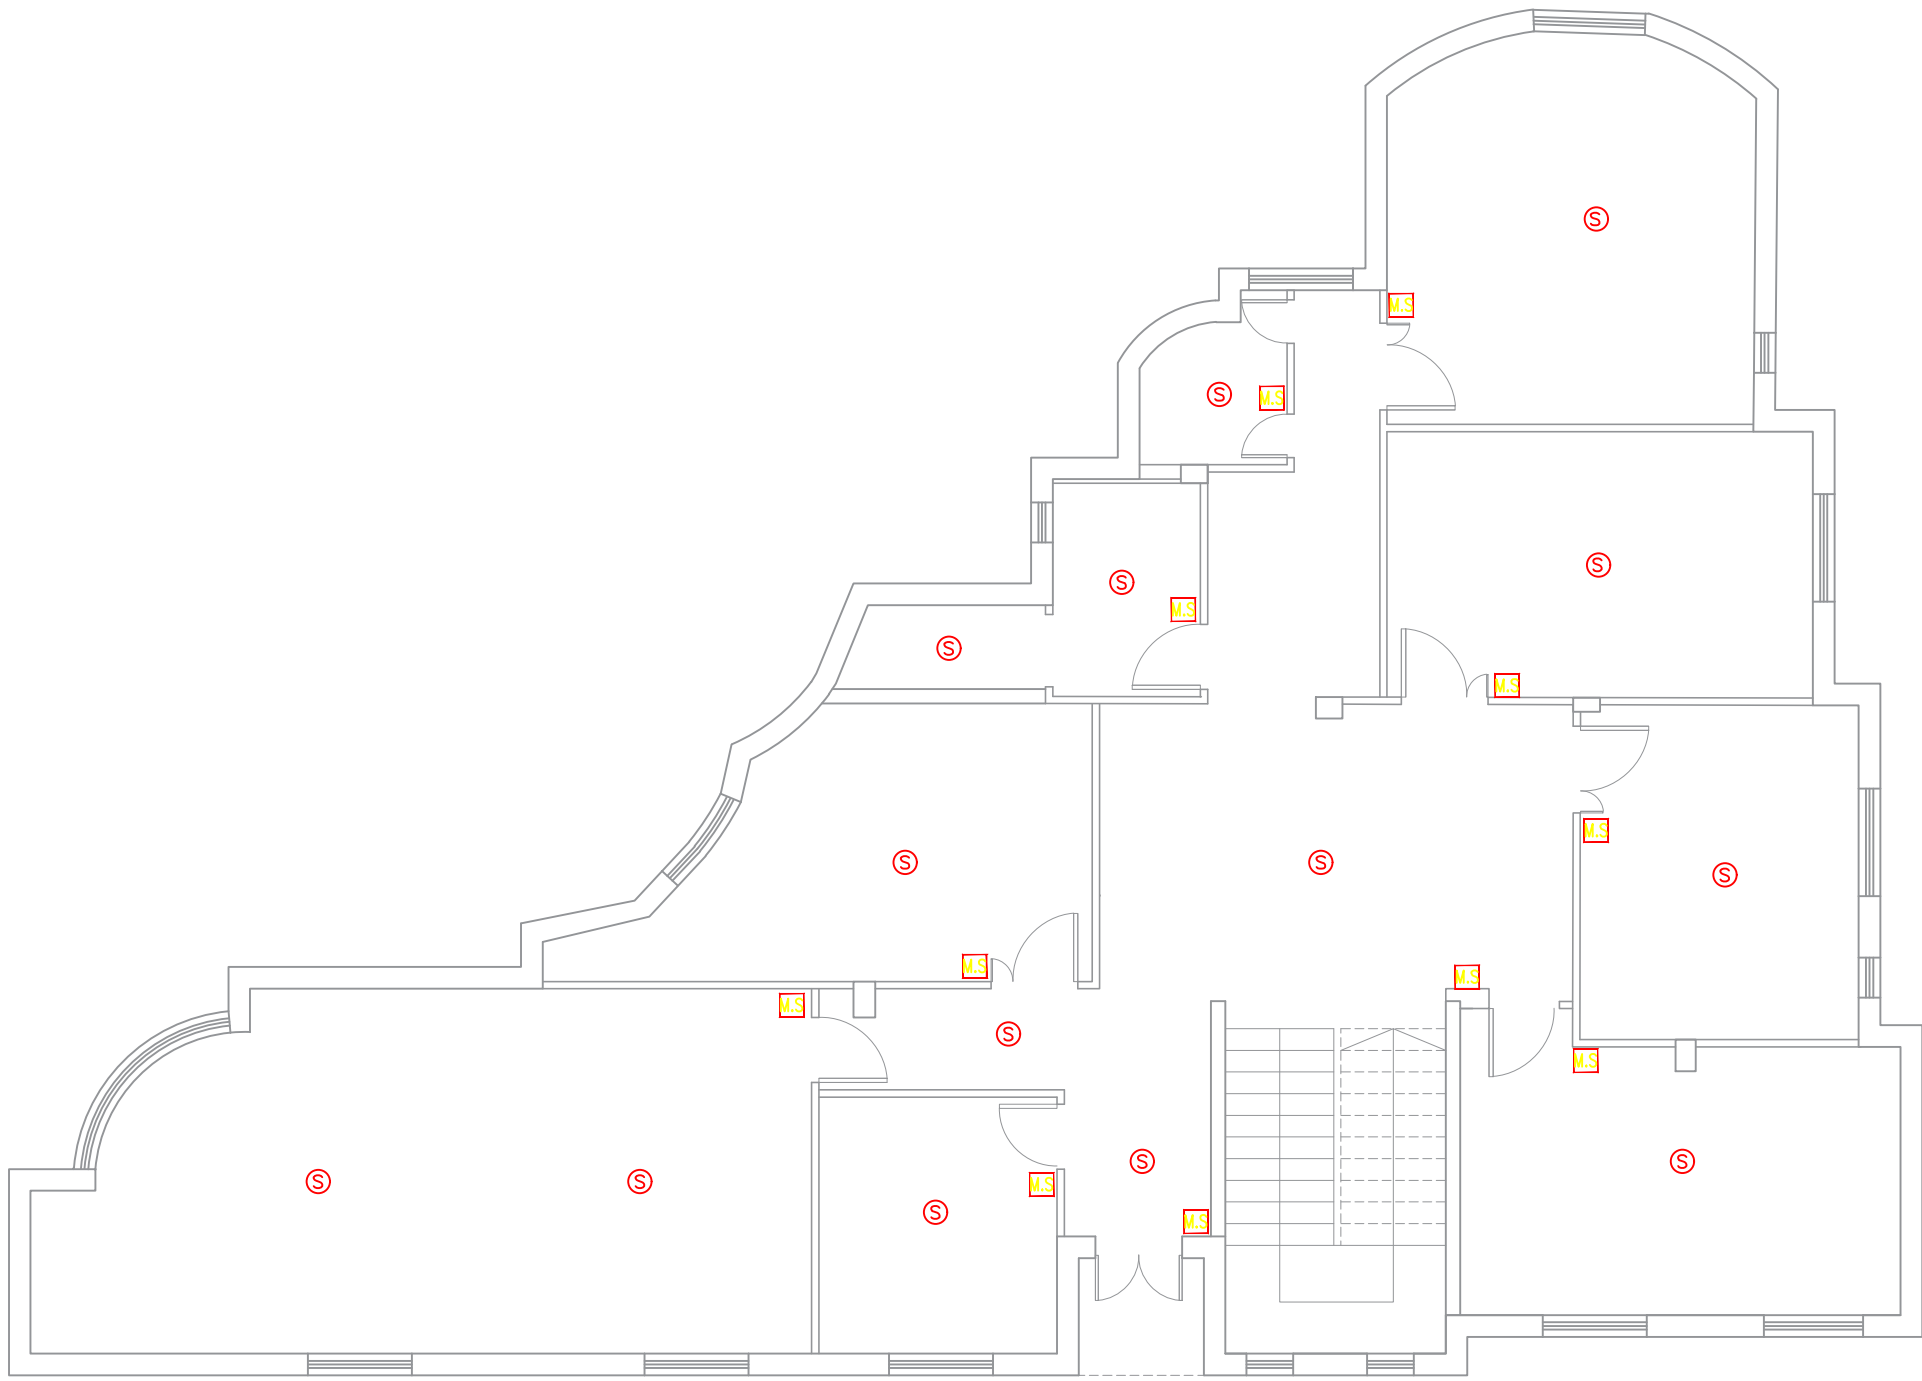

GROUND FLOOR

Notes

(1) All Dimensions Are In M.
(2) All Levels Are In Meter
(3) Any Missing or Unclear Detail And All Fastening Systems For All Elements Shall be Approved by The Supervisor.

Legend:

SECTION NUMBER
REFERENCE SHEET NUMBER

REFERENCE DETAIL SHEET NUMBER

FLOOR FINISH LEVEL (F.F.L.)
REINFORCEMENT CONCRETE LEVEL (R.C.L.)

LEVEL SIGN IN PLAN

STEEL SHEETS

RC CONCRETE FOR COLUMNS

RC CONCRETE FOR WALLS

CONCRETE

STONE WALL

HOLLOW BLOCKS

CEMENT TILE

PORCELAIN TILE

LOCAL MARBLE

Gypsum partition

ENTRANCE

ARTIFICIAL GRASS

PORCELAIN TILES (PARQUET STYLE)

DEMOLISHING AND REMOVAL

NEW INTERVENTION

DOOR NUMBER
REFERENCE DETAIL SHEET NUMBER

WINDOW NUMBER
REFERENCE DETAIL SHEET NUMBER

DETAILED SECTION AT SHEET No. A09

ROOM CODE
ROOM ID

FUNCTION AREA

R.C.L.: REN. CONCRETE LEVEL

F.F.L.: FINISH FLOOR LEVEL

S.L.: SEA LEVEL

REVISIONS		
NO.	DRAWINGS	DATE
(1)		
(2)		
(3)		

Contracting Authority:

Funded By:

Project Title:

“Public Works Contract for the rehabilitation of 5 schools in East Jerusalem”

Reference number: PSE22001-10074

Lot 1: the rehabilitation of Al-Hasan Al-Thany, Al-Shabbat Al-Shameleh, and Al-Fata Al-Laji’a schools in Wadi Al-Joz

Al-Shameleh Secondary Girls' school


Designed by:

HOSH STUDIO
ARCHITECTURE & TOWN PLANNING

Jerusalem - Sheikh Jarrah- Tobler8
email: mr.wasimhija@gmail.com

Tel. 02-9948344/ 052-8327076
Fax: 02-9948344

Drawing Title	Scope of Intervention	Date: 25/3/2025 Scale: 1:100
Designed by:	Arch. Hiba Al Ayoubi	Drawing No: E26
Checked by:	Arch. Wasim Abu El-Hija	
Approved by:		
Coordinate Manager:		

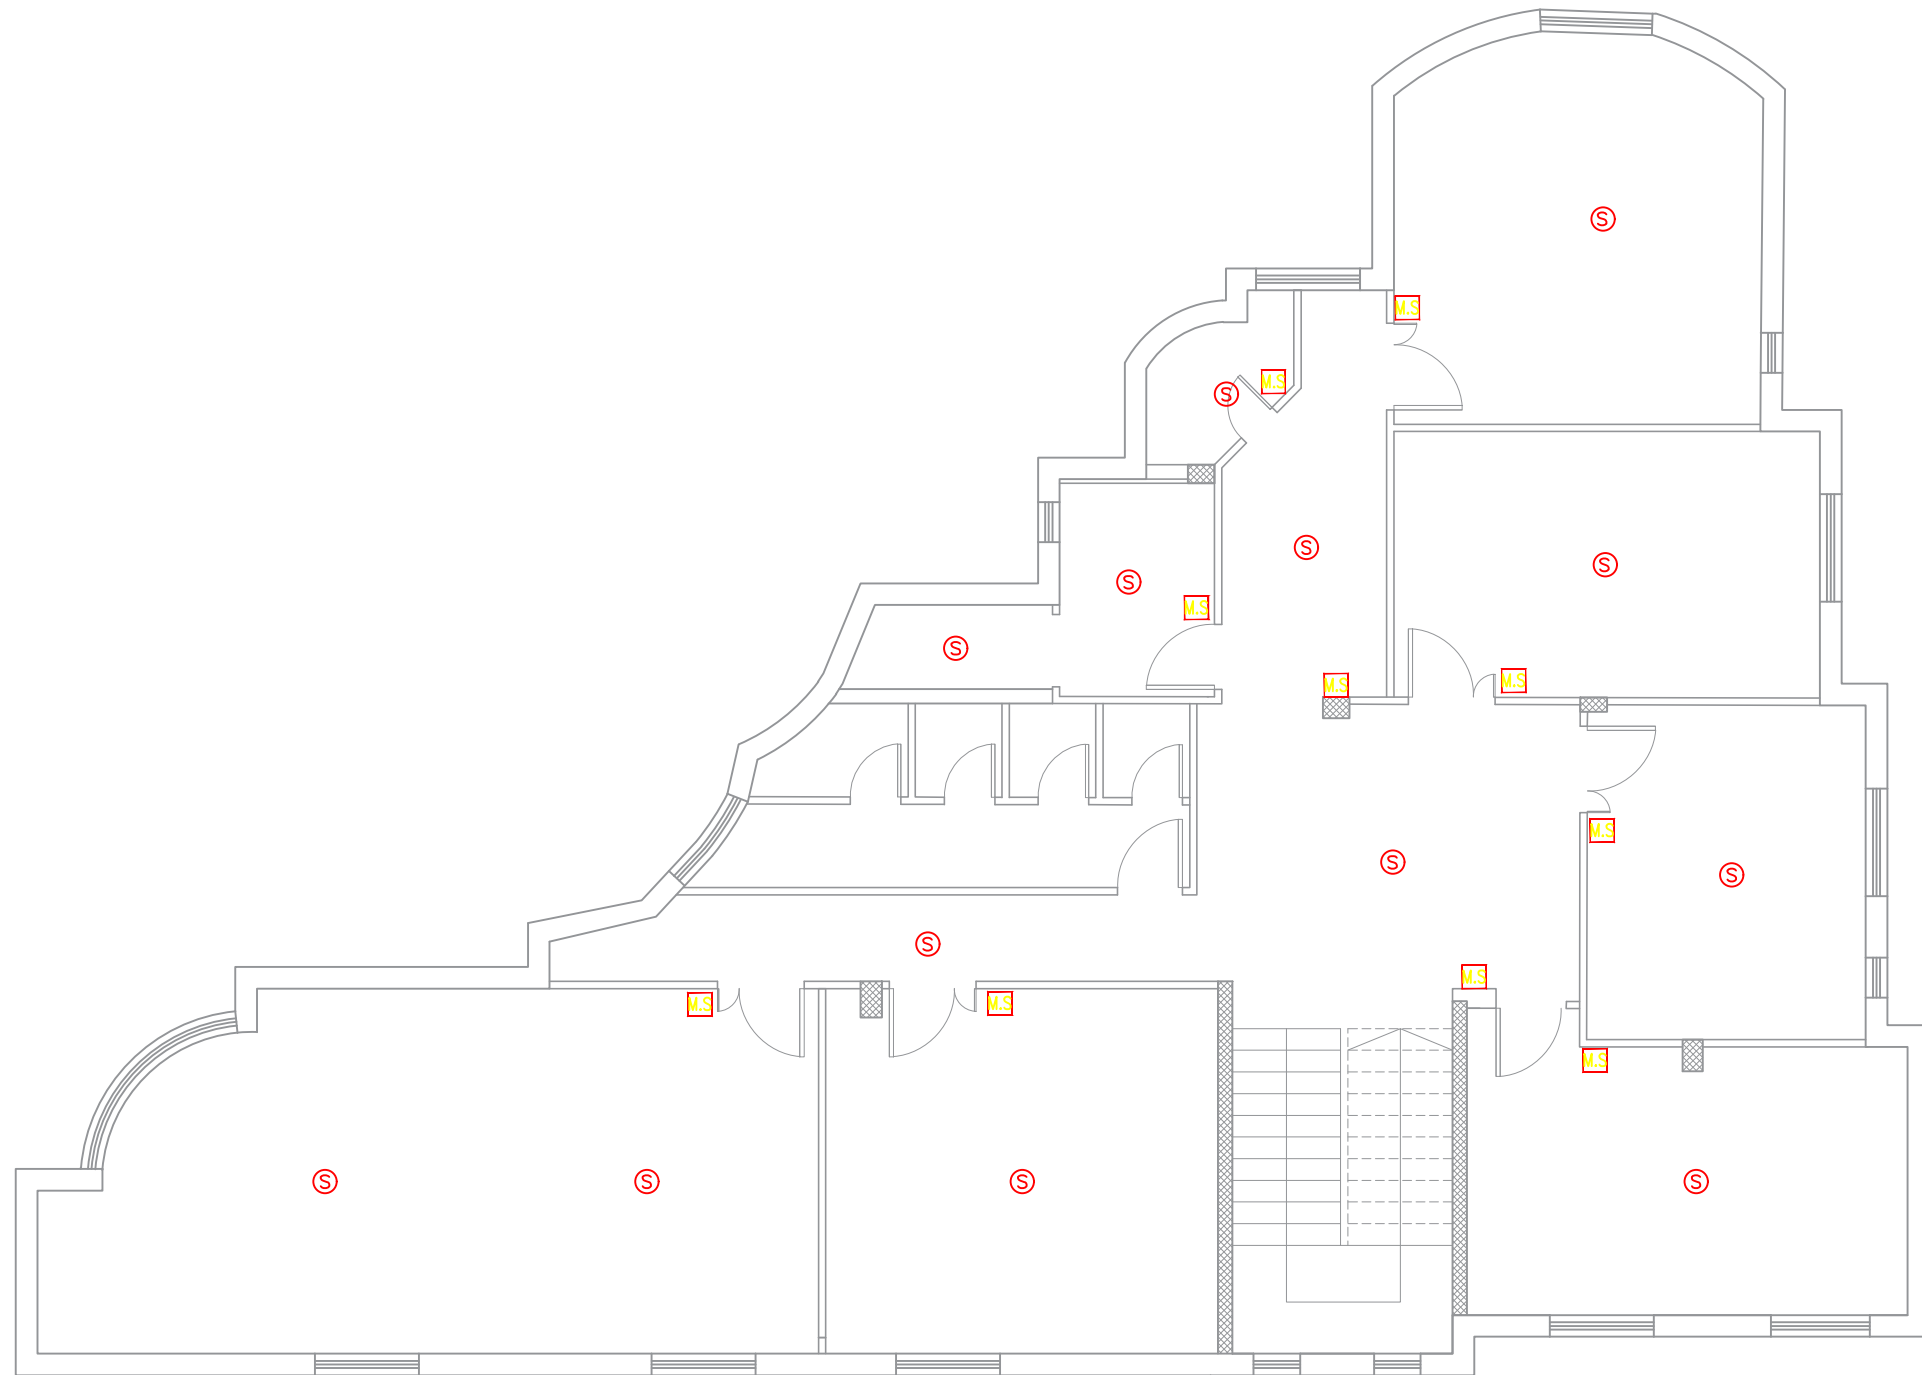

FIRST FLOOR &

Notes

- (1) All Dimensions Are In M.
- (2) All Levels Are In Meter
- (3) Any Missing or Unclear Detail And All Fastening Systems For All Elements Shall be Approved by The Supervisor.

Legend:

SECTION NUMBER
REFERENCE SHEET NUMBER
REFERENCE DETAIL SHEET NUMBER
FLOOR FINISH LEVEL (F.F.L.)
REINFORCEMENT CONCRETE LEVEL (R.C.L.)
LEVEL SIGN IN PLAN

ROOM CODE
FUNCTION AREA
ROOM ID
DOOR NUMBER
REFERENCE DETAIL SHEET NUMBER
WINDOW NUMBER
REFERENCE DETAIL SHEET NUMBER
DETAILED SECTION AT SHEET No. A09

STEEL SHEETS
RC CONCRETE FOR COLUMNS
RC CONCRETE FOR WALLS
CONCRETE
STONE WALL
HOLLOW BLOCKS
CEMENT TILE
PORCELAIN TILE
LOCAL MARBLE
Gypsum partition

ENTRANCE
ARTIFICIAL GRASS
PORCELAIN TILES (PARQUET STYLE)
DEMOLISHING AND REMOVAL
NEW INTERVENTION

R.C.L.: REN. CONCRETE LEVEL
F.F.L.: FINISH FLOOR LEVEL
S.L.: SEA LEVEL

REVISIONS

NO.	DRAWINGS	DATE
(1)		
(2)		
(3)		

Contracting Authority:



Funded By:



Project Title:

“Public Works Contract for the rehabilitation of 5 schools in East Jerusalem”

Reference number: PSE22001-10074

Lot 1: the rehabilitation of Al-Hasan Al-Thany, Al-Shabbat Al-Shameleh, and Al-Fata Al-Laji’a schools in Wadi Al-Joz


Al-Shameleh Secondary Girls' school

Designed by:



Jerusalem - Sheikh Jarrah- Tobler8
email: mr.wasimhija@gmail.com
Tel. 02-9948344/ 052-8327076
Fax: 02-9948344

Drawing Title	Scope of Intervention	Date: 25/3/2025 Scale: 1:100
Designed by:	Arch. Hiba Al Ayoubi	Drawing No: E27
Checked by:	Arch. Wasim Abu El-Hija	
Approved by:		
Coordinate Manager:		

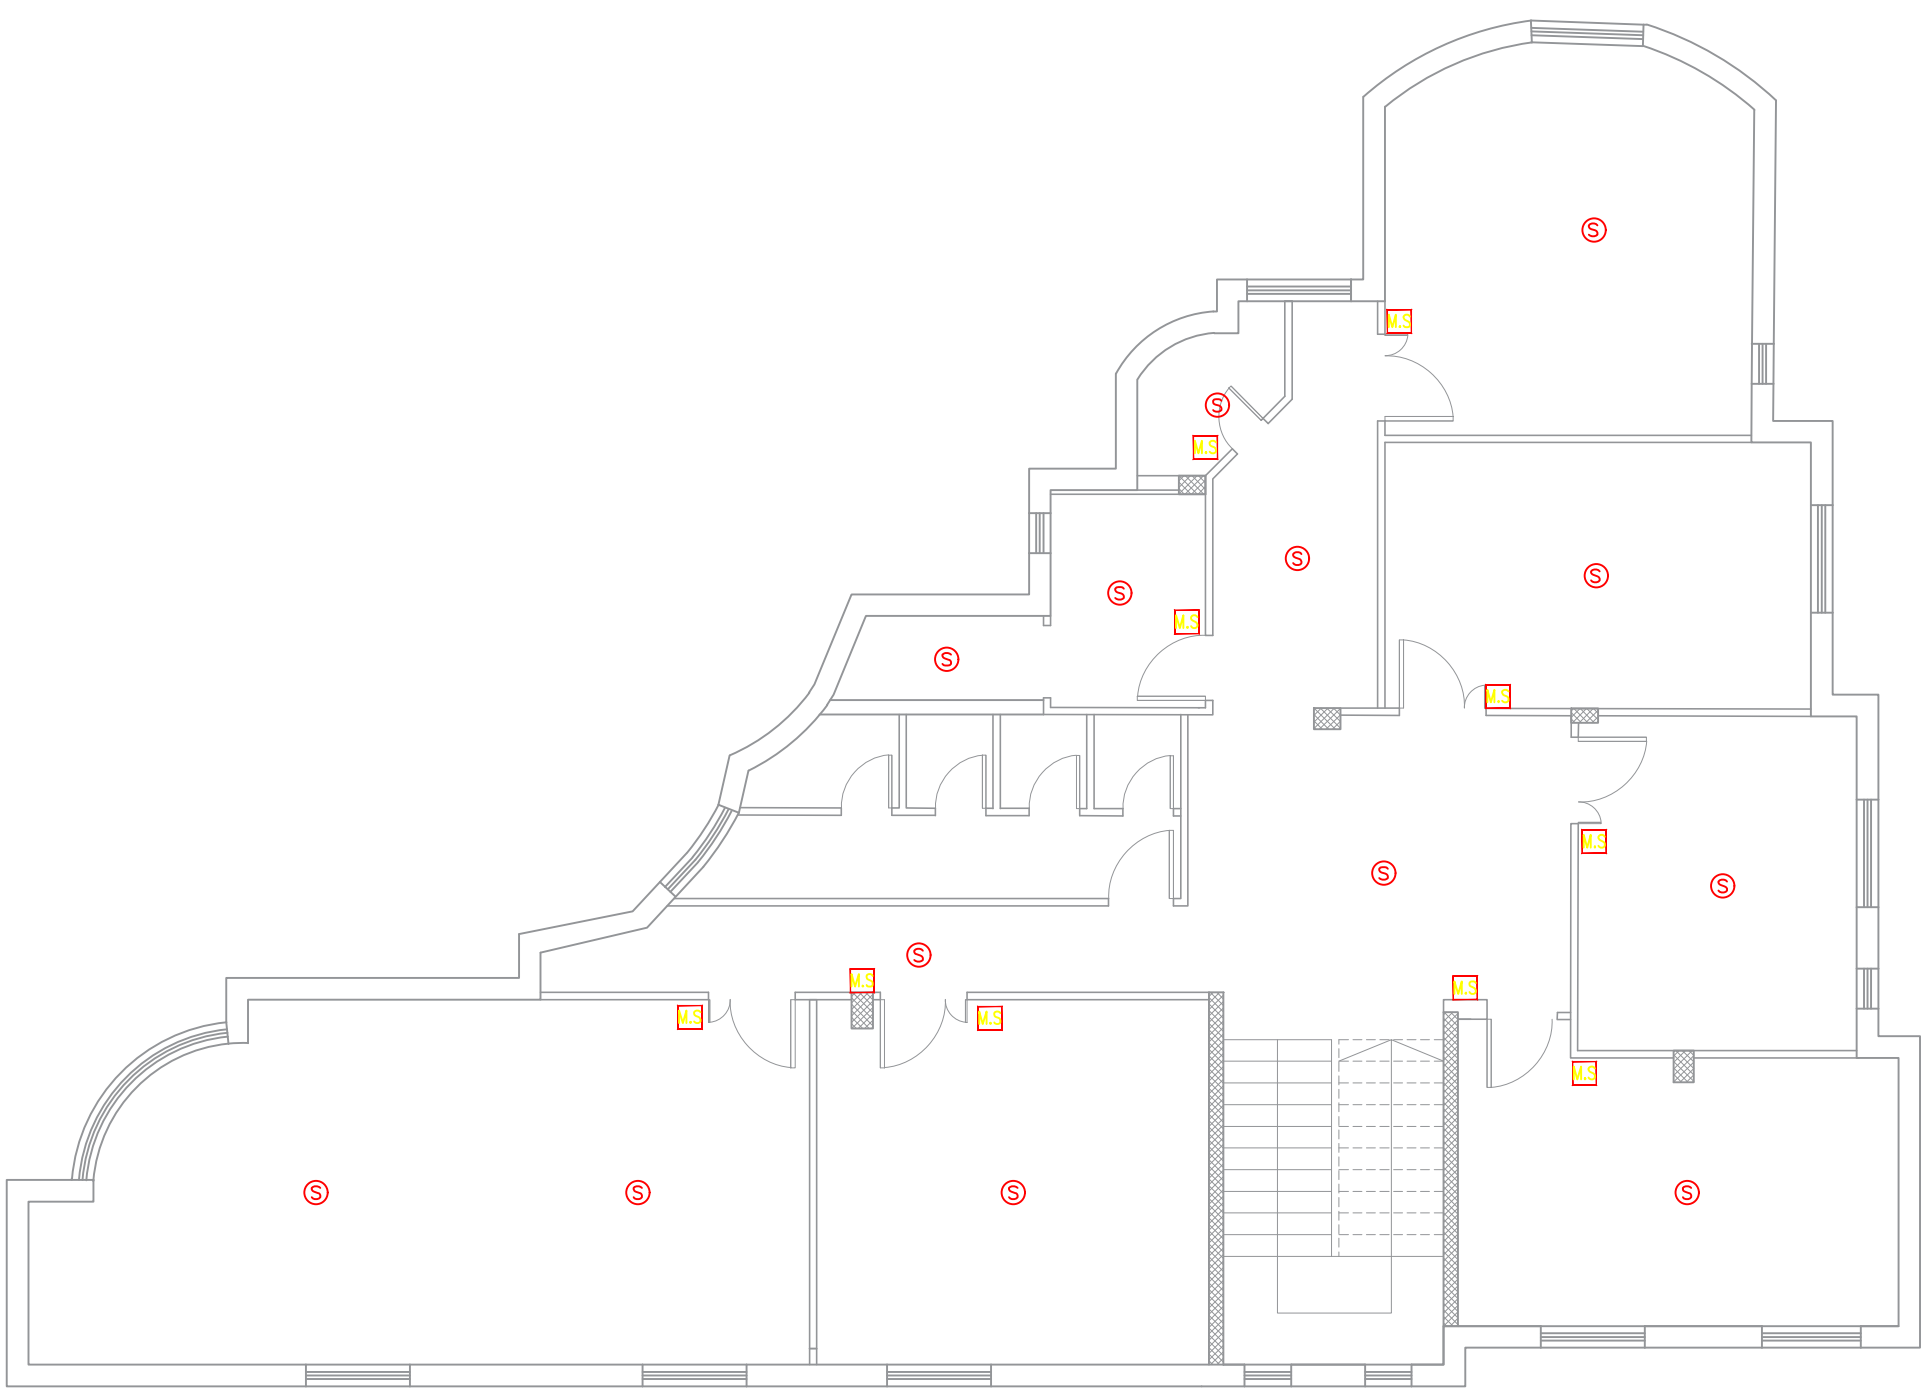

SECOND FLOOR

Notes

(1) All Dimensions Are In M.
(2) All Levels Are In Meter
(3) Any Missing or Unclear Detail And All Fastening Systems For All Elements Shall be Approved by The Supervisor.

Legend:

SECTION NUMBER
REFERENCE SHEET NUMBER

REFERENCE DETAIL SHEET NUMBER

FLOOR FINISH LEVEL (F.F.L.)
REINFORCEMENT CONCRETE LEVEL (R.C.L.)

LEVEL SIGN IN PLAN

ROOM CODE
AREA
ROOM ID

DOOR NUMBER
REFERENCE DETAIL SHEET NUMBER

WINDOW NUMBER
REFERENCE DETAIL SHEET NUMBER

DETAILED SECTION AT SHEET No. A09

STEEL SHEETS
RC CONCRETE FOR COLUMNS
RC CONCRETE FOR WALLS
CONCRETE
STONE WALL
HOLLOW BLOCKS
CEMENT TILE
PORCELAIN TILE
LOCAL MARBLE
Gypsum partition

ENTRANCE
ARTIFICIAL GRASS
PORCELAIN TILES (PARQUET STYLE)
DEMOLISHING AND REMOVAL
NEW INTERVENTION

R.C.L.: REN. CONCRETE LEVEL
F.F.L.: FINISH FLOOR LEVEL
S.L.: SEA LEVEL

REVISIONS

NO.	DRAWINGS	DATE
(1)		
(2)		
(3)		

Contracting Authority:

Enabel

Funded By:

Belgium
partner in development

Project Title:

“Public Works Contract for the rehabilitation of 5 schools in East Jerusalem”

Reference number: PSE22001-10074

Lot 1: the rehabilitation of Al-Hasan Al-Thany, Al-Shabbat Al-Shameleh, and Al-Fata Al-Laji’a schools in Wadi Al-Joz

Al-Shameleh Secondary Girls' school


Designed by:

HOSH STUDIO
ARCHITECTURE & TOWN PLANNING

Jerusalem - Sheikh Jarrah- Tobler8
email: mr.wasimhija@gmail.com

Tel. 02-9948344/ 052-8327076
Fax: 02-9948344

Drawing Title	Scope of Intervention	Date: 25/3/2025 Scale: 1:100
Designed by:	Arch. Hiba Al Ayoubi	Drawing No: E28
Checked by:	Arch. Wasim Abu El-Hija	
Approved by:		
Coordinate Manager:		

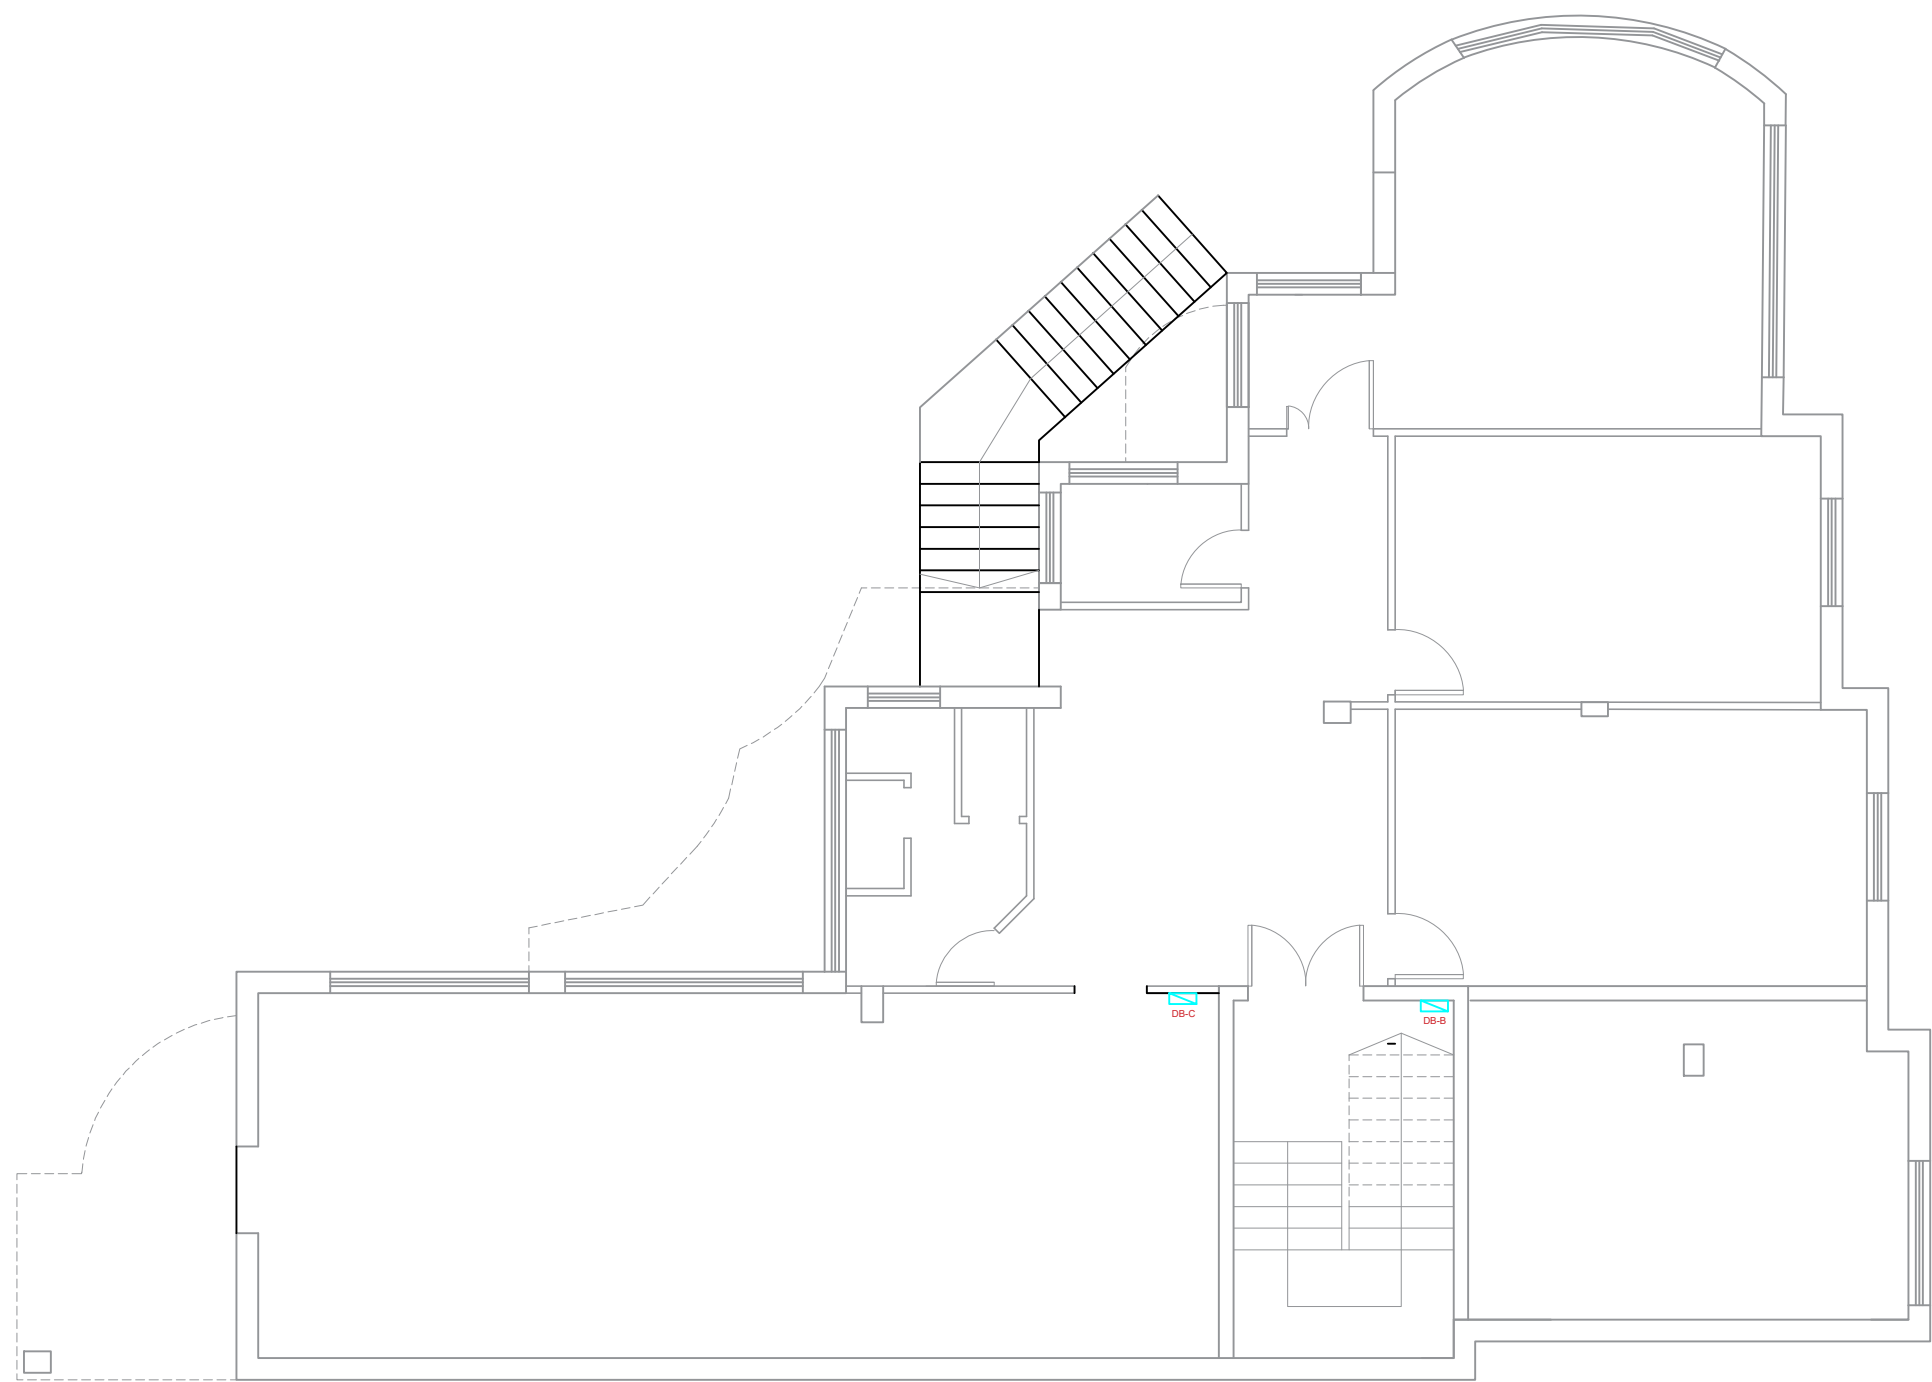

BASEMENT FLOOR

Notes

- (1) All Dimensions Are In M.
- (2) All Levels Are In Meter
- (3) Any Missing or Unclear Detail And All Fastening Systems For All Elements Shall be Approved by The Supervisor.

Legend:

SECTION NUMBER
REFERENCE SHEET NUMBER

DOOR NUMBER
REFERENCE DETAIL SHEET NUMBER

FLOOR FINISH LEVEL (F.F.L.)
REINFORCEMENT CONCRETE LEVEL (R.C.L.)

LEVEL SIGN IN PLAN

ROOM CODE
FUNCTION AREA
ROOM ID

DOOR NUMBER
REFERENCE DETAIL SHEET NUMBER

WINDOW NUMBER
REFERENCE DETAIL SHEET NUMBER

DETAILED SECTION AT SHEET No. A09

STEEL SHEETS
RC CONCRETE FOR COLUMNS
RC CONCRETE FOR WALLS
CONCRETE
STONE WALL
HOLLOW BLOCKS
CEMENT TILE
PORCELAIN TILE
LOCAL MARBLE
Gypsum partition

ENTRANCE
ARTIFICIAL GRASS
PORCELAIN TILES (PARQUET STYLE)
DEMOLISHING AND REMOVAL
NEW INTERVENTION

R.C.L.: REN. CONCRETE LEVEL
F.F.L.: FINISH FLOOR LEVEL
S.L.: SEA LEVEL

REVISIONS

NO.	DRAWINGS	DATE
(1)		
(2)		
(3)		

Contracting Authority:



Funded By:



Project Title:

“Public Works Contract for the rehabilitation of 5 schools in East Jerusalem”

Reference number: PSE22001-10074

Lot 1: the rehabilitation of Al-Hasan Al-Thany, Al-Shabbat Al-Shameleh, and Al-Fata Al-Laji’a schools in Wadi Al-Joz

Al-Shameleh Secondary Girls' school

Designed by:



Jerusalem - Sheikh Jarrah- Tobler8
email: mr.wasimhija@gmail.com
Tel. 02-9948344/ 052-8327076
Fax: 02-9948344

Drawing Title	Scope of Intervention	Date: 25/3/2025 Scale: 1:100
Designed by:	Arch. Hiba Al Ayoubi	Drawing No: E29
Checked by:	Arch. Wasim Abu El-Hija	
Approved by:		
Coordinate Manager:		



GROUND FLOOR

Notes

(1) All Dimensions Are In M.
(2) All Levels Are In Meter
(3) Any Missing or Unclear Detail And All Fastening Systems For All Elements Shall be Approved by The Supervisor.

Legend:

SECTION NUMBER
REFERENCE SHEET NUMBER

REFERENCE DETAIL SHEET NUMBER

FLOOR FINISH LEVEL (F.F.L.)
REINFORCEMENT CONCRETE LEVEL (R.C.L.)

LEVEL SIGN IN PLAN

ROOM CODE
FUNCTION
AREA
ROOM ID

DOOR NUMBER
REFERENCE DETAIL SHEET NUMBER

WINDOW NUMBER
REFERENCE DETAIL SHEET NUMBER

DETAILED SECTION AT SHEET No. A09

STEEL SHEETS

RC CONCRETE FOR COLUMNS

RC CONCRETE FOR WALLS

CONCRETE

STONE WALL

HOLLOW BLOCKS

CEMENT TILE

PORCELAIN TILE

LOCAL MARBLE

Gypsum partition

ENTRANCE

ARTIFICIAL GRASS

PORCELAIN TILES (PARQUET STYLE)

DEMOLISHING AND REMOVAL

NEW INTERVENTION

R.C.L.:REN. CONCRETE LEVEL

F.F.L.:FINISH FLOOR LEVEL

S.L. : SEA LEVEL

REVISIONS		
NO.	DRAWINGS	DATE
(1)		
(2)		
(3)		

Contracting Authority:

Funded By:

Project Title:

“Public Works Contract for the rehabilitation of 5 schools in East Jerusalem”

Reference number: PSE22001-10074

Lot 1: the rehabilitation of Al-Hasan Al-Thany, Al-Shabbat Al-Shameleh, and Al-Fata Al-Laji’a schools in Wadi Al-Joz

Al-Shameleh Secondary Girls' school


Designed by:

HOSH STUDIO
ARCHITECTURE & TOWN PLANNING

Jerusalem - Sheikh Jarrah- Tobler8
email: mr.wasimhija@gmail.com

Tel. 02-9948344/ 052-8327076
Fax: 02-9948344

Drawing Title	Scope of Intervention	Date: 25/3/2025
	Location Of Distribution Board	Scale: 1:100
Designed by:	Arch. Hiba Al Ayoubi	Drawing No: E30
Checked by:	Arch. Wasim Abu El-Hija	
Approved by:		
Coordinate Manager:		

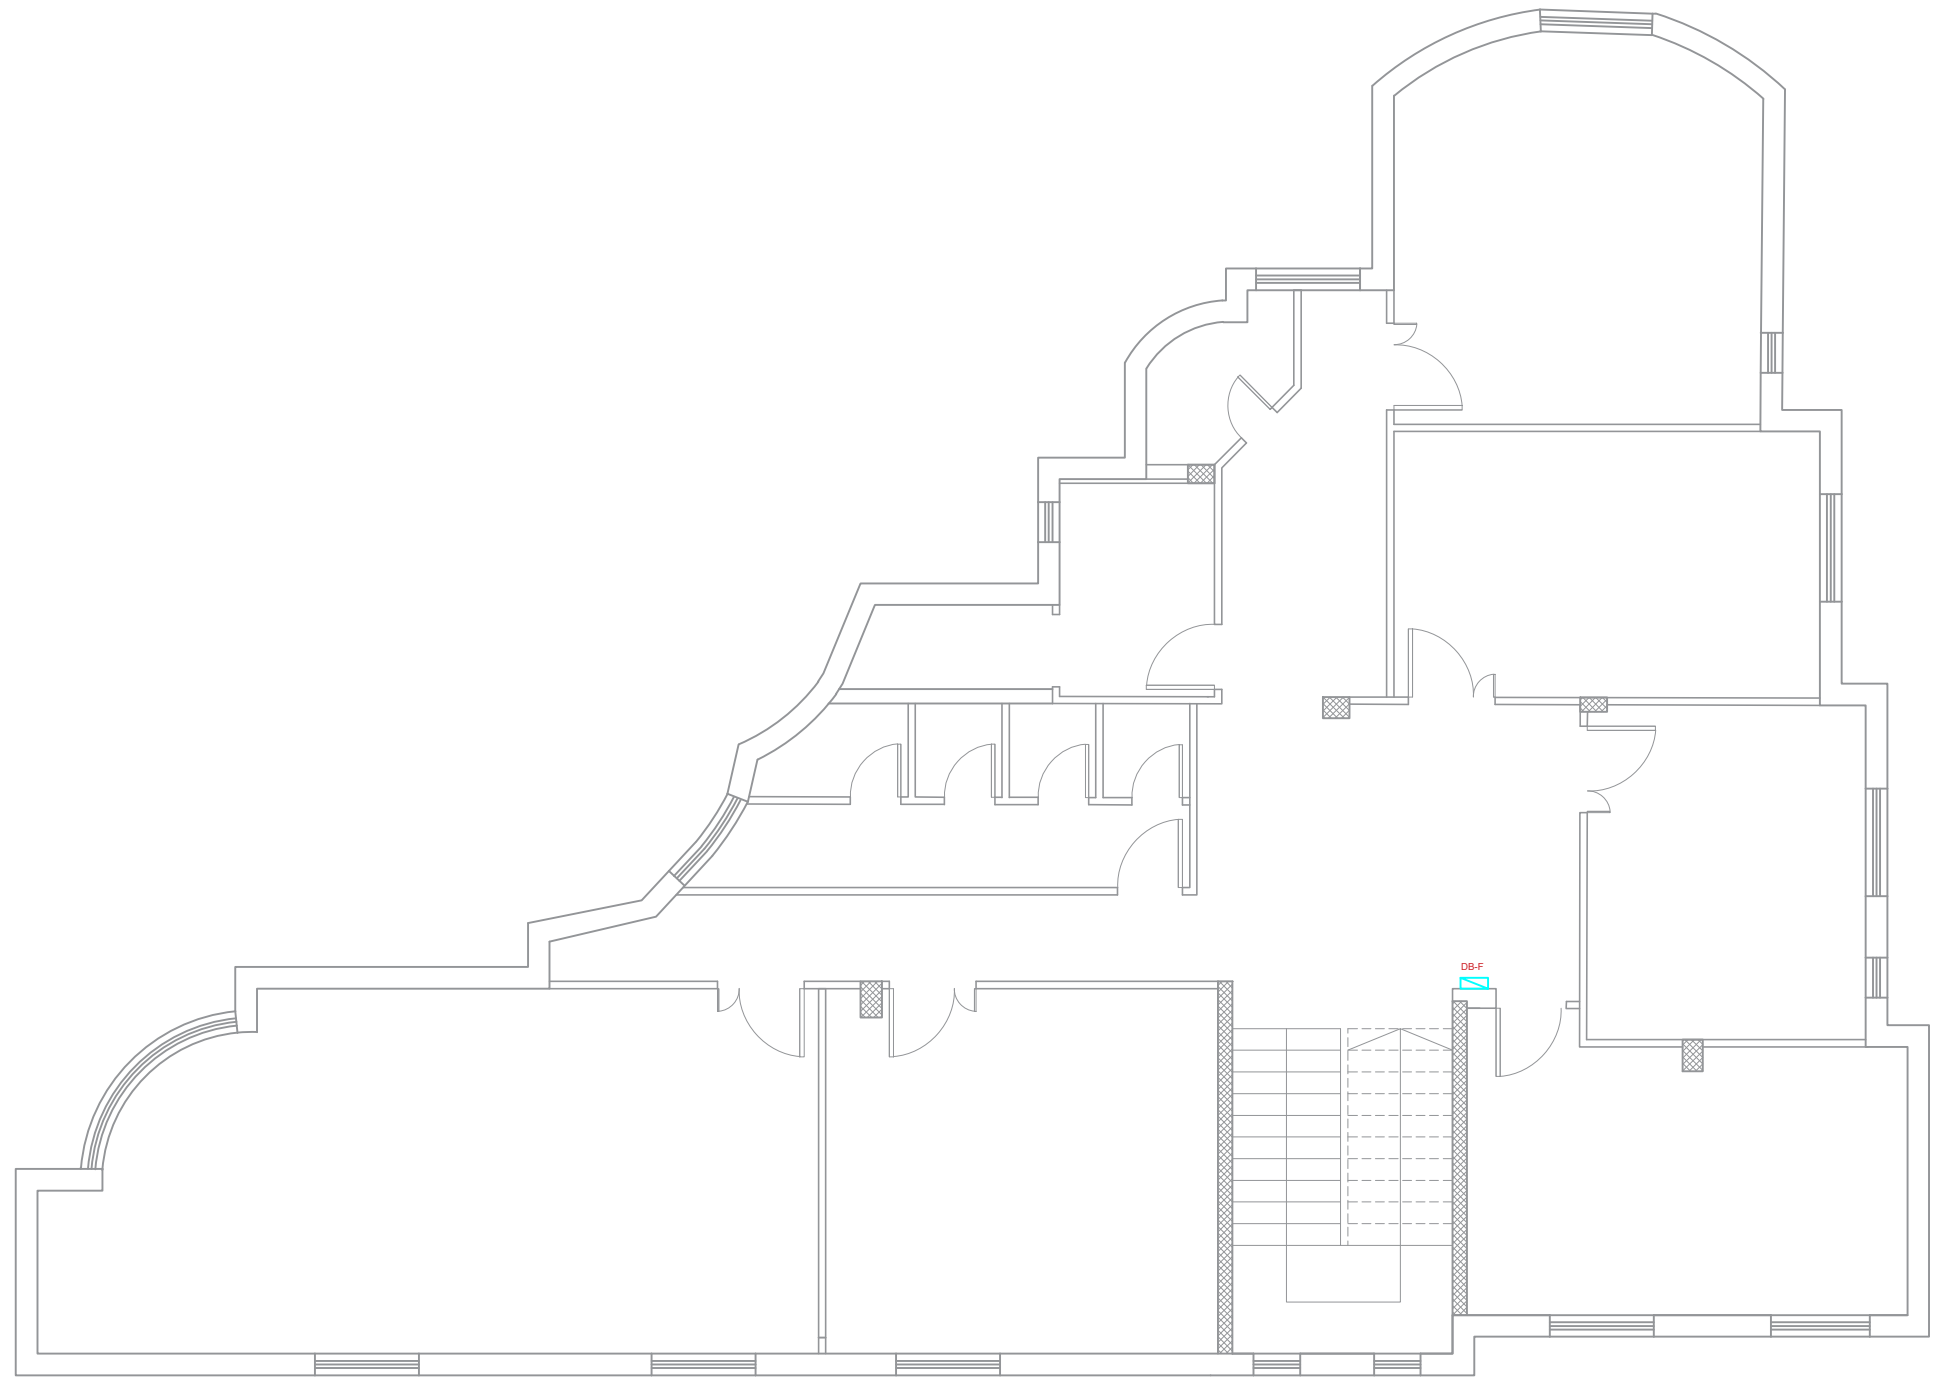

FIRST FLOOR &

Notes

- (1) All Dimensions Are In M.
- (2) All Levels Are In Meter
- (3) Any Missing or Unclear Detail And All Fastening Systems For All Elements Shall be Approved by The Supervisor.

Legend:

SECTION NUMBER
REFERENCE SHEET NUMBER

REFERENCE DETAIL SHEET NUMBER

FLOOR FINISH LEVEL (F.F.L.)

REINFORCEMENT CONCRETE LEVEL
(R.C.L.)

LEVEL SIGN IN PLAN

STEEL SHEETS

RC CONCRETE FOR COLUMNS

RC CONCRETE FOR WALLS

CONCRETE

STONE WALL

HOLLOW BLOCKS

CEMENT TILE

PORCELAIN TILE

LOCAL MARBLE

Gypsum partition

ENTRANCE

ARTIFICIAL GRASS

PORCELAIN TILES (PARQUET STYLE)

DEMOLISHING AND REMOVAL

NEW INTERVENTION

R.C.L.: REN. CONCRETE LEVEL

F.F.L.: FINISH FLOOR LEVEL

S.L.: SEA LEVEL

DOOR NUMBER
REFERENCE DETAIL SHEET NUMBER

WINDOW NUMBER
REFERENCE DETAIL SHEET NUMBER

ROOM CODE
FUNCTION
AREA
ROOM ID

DETAILED SECTION AT SHEET No. A09

REVISIONS

NO.	DRAWINGS	DATE
(1)		
(2)		
(3)		

Contracting Authority:



Funded By:



Project Title:

“Public Works Contract for the rehabilitation of 5 schools in East Jerusalem”

Reference number: PSE22001-10074

Lot 1: the rehabilitation of Al-Hasan Al-Thany, Al-Shabbat Al-Shameleh, and Al-Fata Al-Laji’a schools in Wadi Al-Joz


Al-Shameleh Secondary Girls' school

Designed by:



Jerusalem - Sheikh Jarrah- Tobler8
email: mr.wasimhija@gmail.com
Tel. 02-9948344/ 052-8327076
Fax: 02-9948344

Drawing Title	Scope of Intervention	Date: 25/3/2025 Scale: 1:100
Designed by:	Arch. Hiba Al Ayoubi	Drawing No: E31
Checked by:	Arch. Wasim Abu El-Hija	
Approved by:		
Coordinate Manager:		

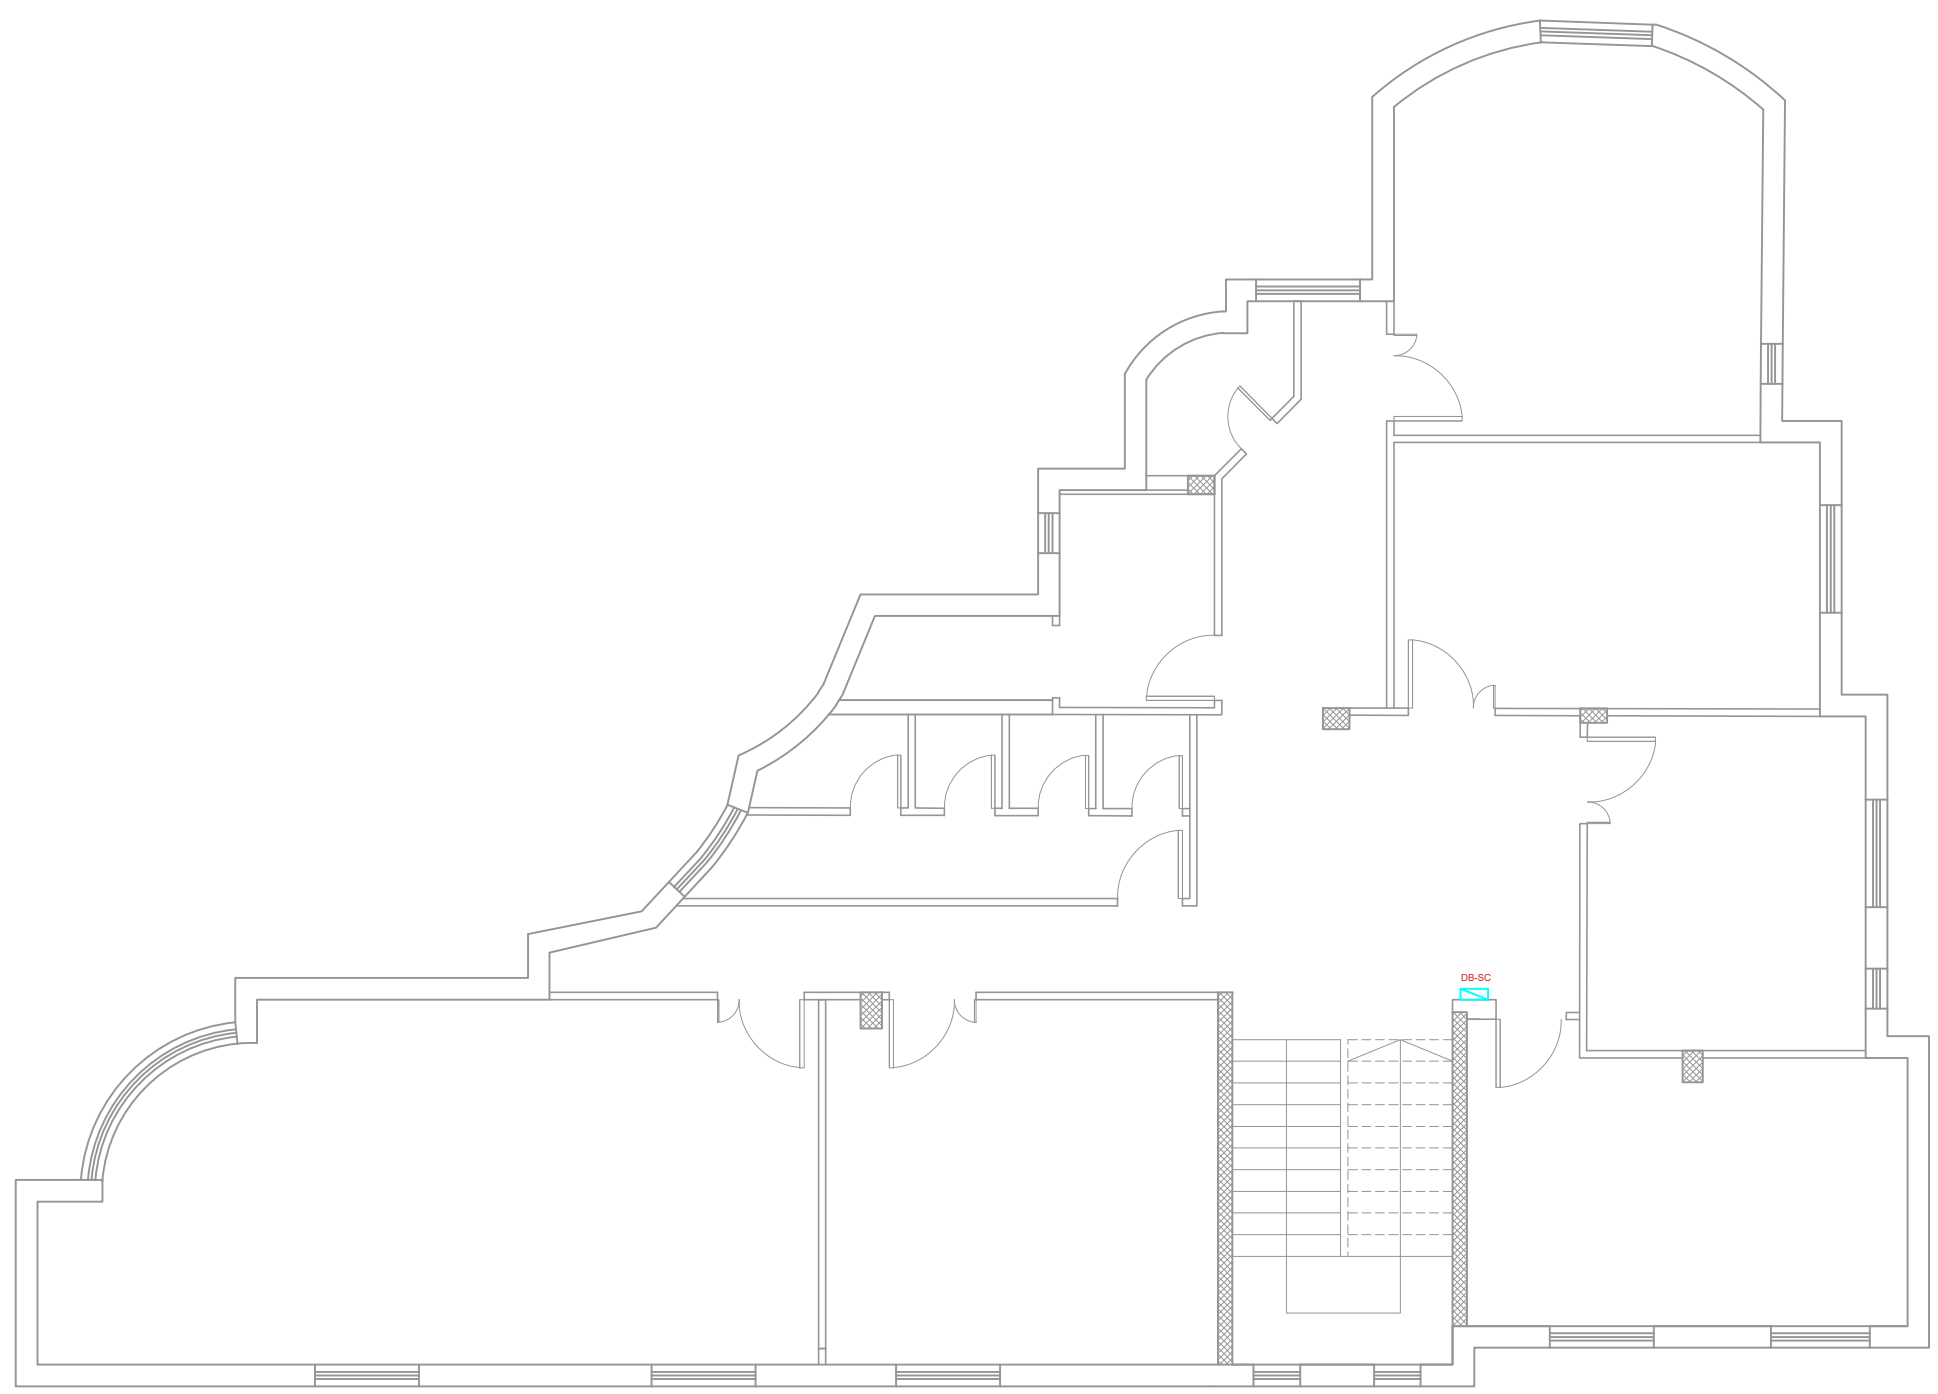

SECOND FLOOR

Notes

- (1) All Dimensions Are In M.
- (2) All Levels Are In Meter
- (3) Any Missing or Unclear Detail And All Fastening Systems For All Elements Shall be Approved by The Supervisor.

Legend:

SECTION NUMBER
REFERENCE SHEET NUMBER

REFERENCE DETAIL SHEET NUMBER

FLOOR FINISH LEVEL (F.F.L.)

REINFORCEMENT CONCRETE LEVEL (R.C.L.)

LEVEL SIGN IN PLAN

STEEL SHEETS

RC CONCRETE FOR COLUMNS

RC CONCRETE FOR WALLS

STONE WALL

HOLLOW BLOCKS

CEMENT TILE

PORCELAIN TILE

LOCAL MARBLE

Gypsum partition

ENTRANCE

ARTIFICIAL GRASS

PORCELAIN TILES (PARQUET STYLE)

DEMOLISHING AND REMOVAL

NEW INTERVENTION

DOOR NUMBER
REFERENCE DETAIL SHEET NUMBER

WINDOW NUMBER
REFERENCE DETAIL SHEET NUMBER

DETAILED SECTION AT SHEET No. A09

ROOM CODE
AREA
ROOM ID

R.C.L.:REN. CONCRETE LEVEL

F.F.L.:FINISH FLOOR LEVEL

S.L. : SEA LEVEL

REVISIONS

NO.	DRAWINGS	DATE
(1)		
(2)		
(3)		

Contracting Authority:



Funded By:



Project Title:

“Public Works Contract for the rehabilitation of 5 schools in East Jerusalem”

Reference number: PSE22001-10074

Lot 1: the rehabilitation of Al-Hasan Al-Thany, Al-Shabbat Al-Shameleh, and Al-Fata Al-Laji’a schools in Wadi Al-Joz


Al-Shameleh Secondary Girls' school

Designed by:



Jerusalem - Sheikh Jarrah- Tobler8
email: mr.wasimhija@gmail.com
Tel. 02-9948344/ 052-8327076
Fax: 02-9948344

Drawing Title	Scope of Intervention	Date: 25/3/2025 Scale: 1:100
Designed by:	Arch. Hiba Al Ayoubi	Drawing No: E32
Checked by:	Arch. Wasim Abu El-Hija	
Approved by:		
Coordinate Manager:		

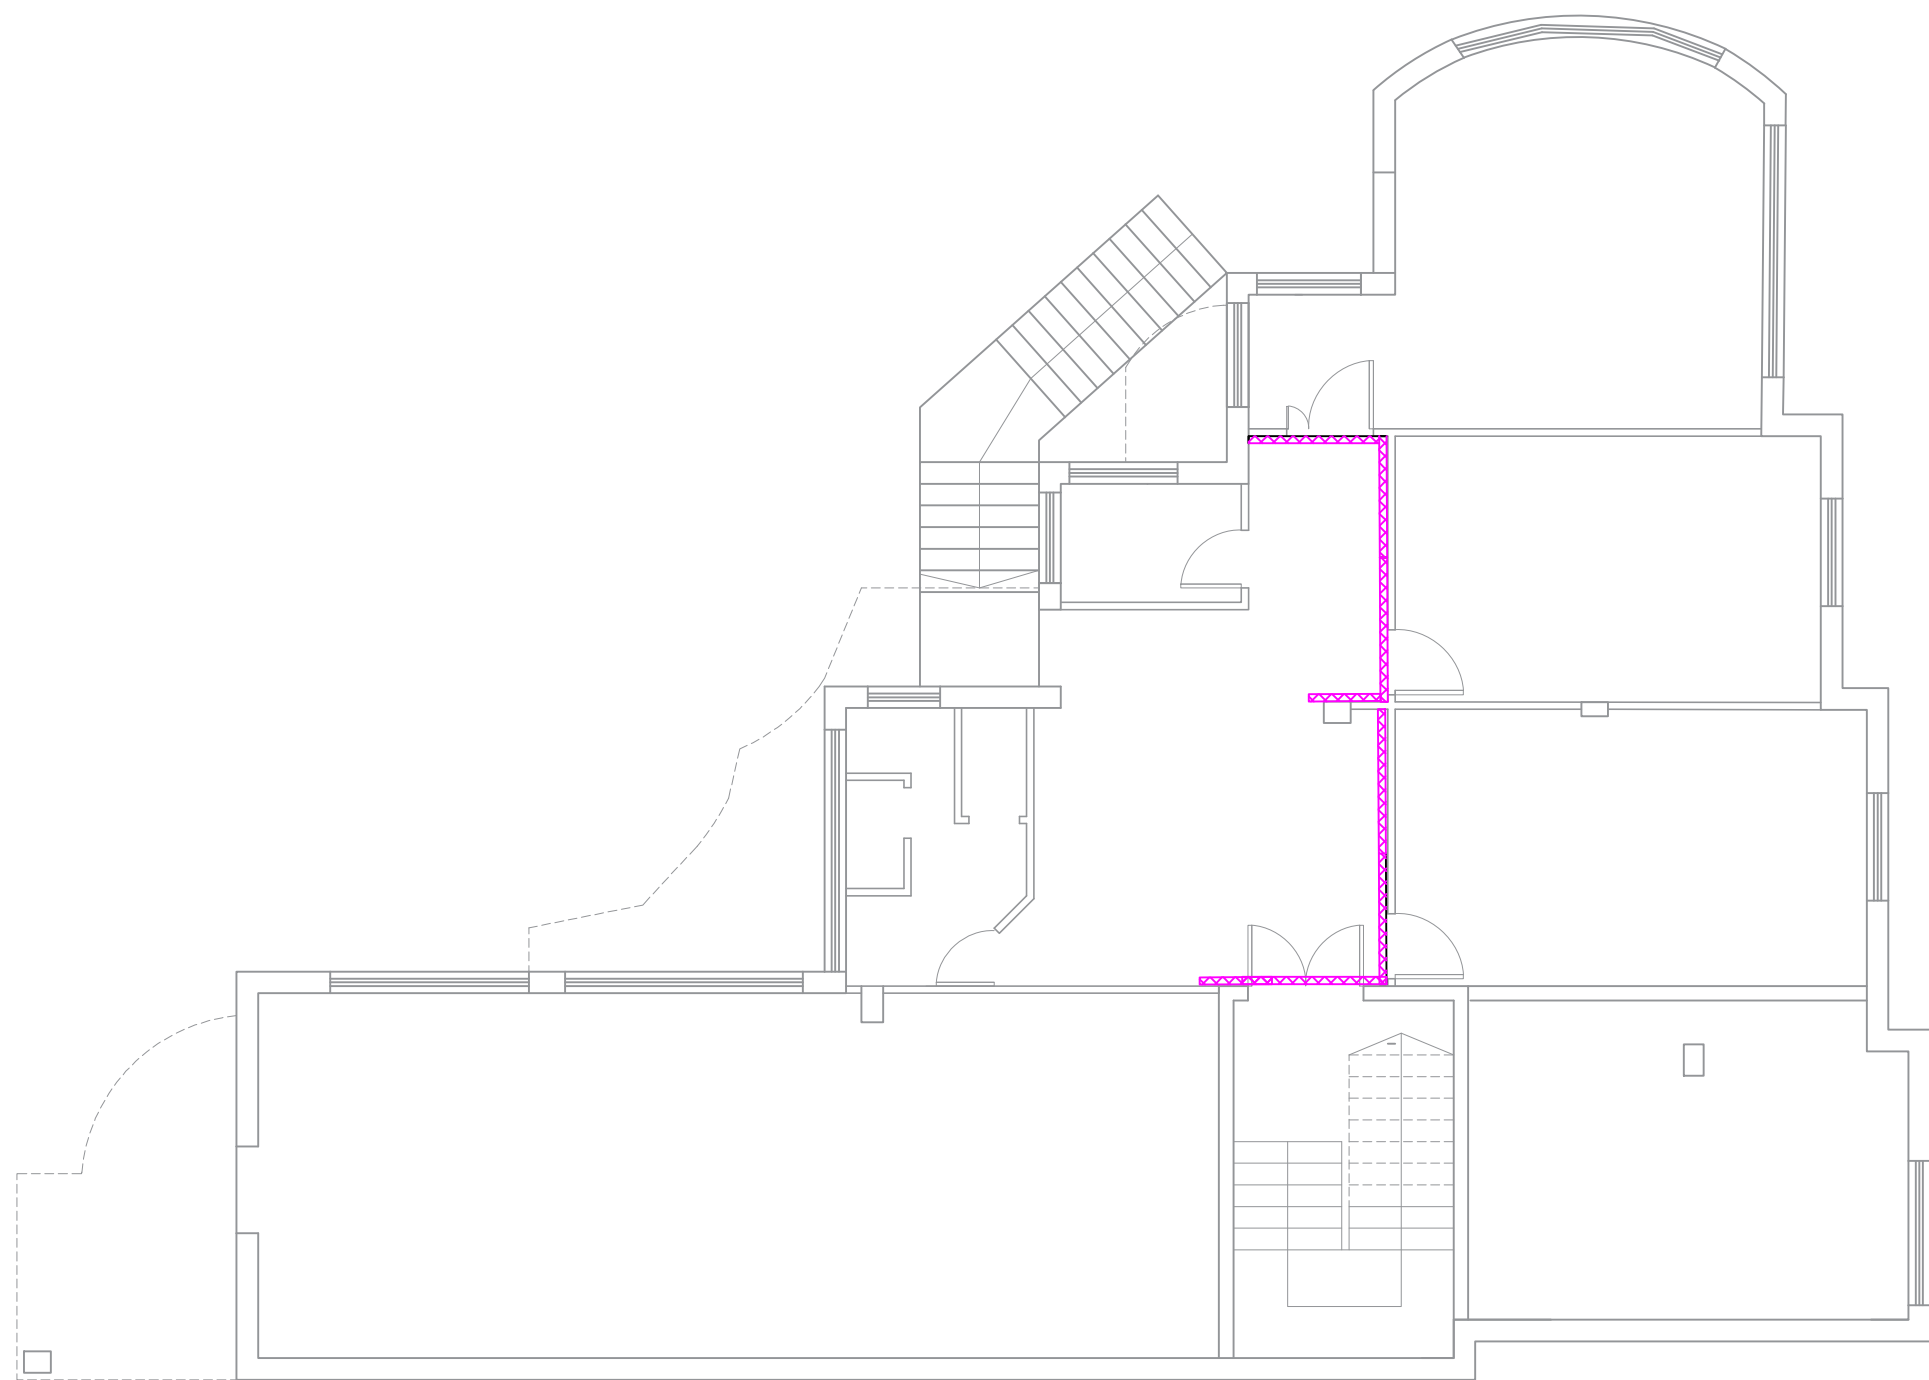

BASEMENT FLOOR

Notes

- (1) All Dimensions Are In M.
- (2) All Levels Are In Meter
- (3) Any Missing or Unclear Detail And All Fastening Systems For All Elements Shall be Approved by The Supervisor.

Legend:

SECTION NUMBER
REFERENCE SHEET NUMBER

REFERENCE DETAIL SHEET NUMBER

FLOOR FINISH LEVEL (F.F.L.)
REINFORCEMENT CONCRETE LEVEL (R.C.L.)

LEVEL SIGN IN PLAN

ROOM CODE
FUNCTION
AREA
ROOM ID

DOOR NUMBER
REFERENCE DETAIL SHEET NUMBER

WINDOW NUMBER
REFERENCE DETAIL SHEET NUMBER

DETAILED SECTION AT SHEET No. A09

STEEL SHEETS
RC CONCRETE FOR COLUMNS
RC CONCRETE FOR WALLS
CONCRETE
STONE WALL
HOLLOW BLOCKS
CEMENT TILE
PORCELAIN TILE
LOCAL MARBLE
Gypsum partition

ENTRANCE
ARTIFICIAL GRASS
PORCELAIN TILES (PARQUET STYLE)
DEMOLISHING AND REMOVAL
NEW INTERVENTION

R.C.L.: REN. CONCRETE LEVEL
F.F.L.: FINISH FLOOR LEVEL
S.L.: SEA LEVEL

REVISIONS

NO.	DRAWINGS	DATE
(1)		
(2)		
(3)		

Contracting Authority:



Funded By:



Project Title:

“Public Works Contract for the rehabilitation of 5 schools in East Jerusalem”

Reference number: PSE22001-10074

Lot 1: the rehabilitation of Al-Hasan Al-Thany, Al-Shabbat Al-Shameleh, and Al-Fata Al-Laji’a schools in Wadi Al-Joz


Al-Shameleh Secondary Girls' school

Designed by:



Jerusalem - Sheikh Jarrah- Tobler8
email: mr.wasimhija@gmail.com
Tel. 02-9948344/ 052-8327076
Fax: 02-9948344

Drawing Title	Scope of Intervention	Date: 25/3/2025 Scale: 1:100
Designed by:	Arch. Hiba Al Ayoubi	Drawing No: E33
Checked by:	Arch. Wasim Abu El-Hija	
Approved by:		
Coordinate Manager:		

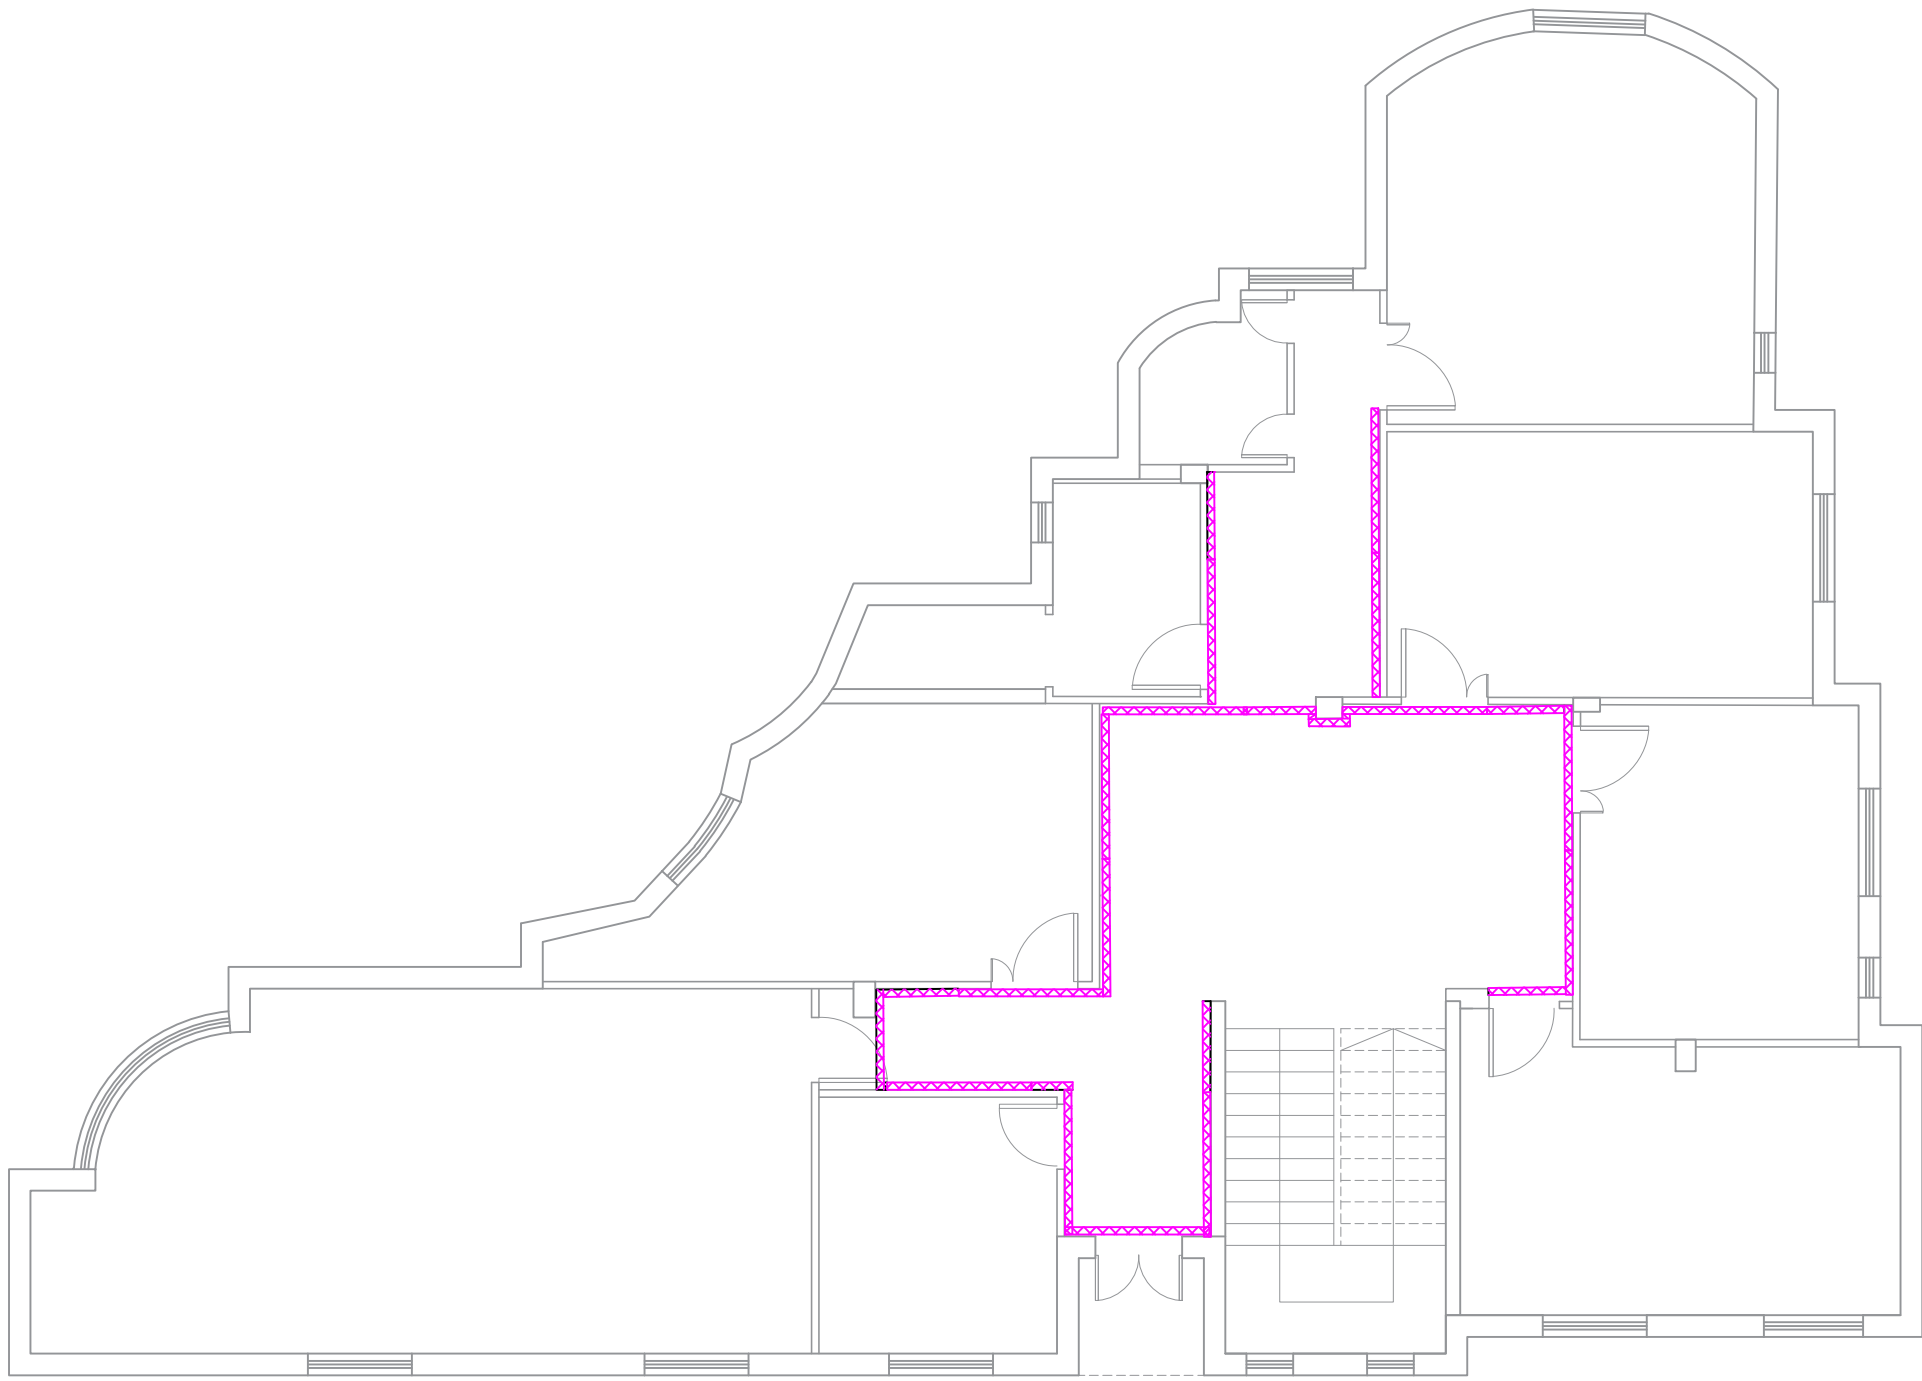

GROUND FLOOR

Notes

(1) All Dimensions Are In M.
(2) All Levels Are In Meter
(3) Any Missing or Unclear Detail And All Fastening Systems For All Elements Shall be Approved by The Supervisor.

Legend:

SECTION NUMBER
REFERENCE SHEET NUMBER

REFERENCE DETAIL SHEET NUMBER

FLOOR FINISH LEVEL (F.F.L.)
REINFORCEMENT CONCRETE LEVEL (R.C.L.)

LEVEL SIGN IN PLAN

STEEL SHEETS

RC CONCRETE FOR COLUMNS

RC CONCRETE FOR WALLS

CONCRETE

STONE WALL

HOLLOW BLOCKS

CEMENT TILE

PORCELAIN TILE

LOCAL MARBLE

Gypsum partition

ENTRANCE

ARTIFICIAL GRASS

PORCELAIN TILES (PARQUET STYLE)

DEMOLISHING AND REMOVAL

NEW INTERVENTION

DOOR NUMBER
REFERENCE DETAIL SHEET NUMBER

WINDOW NUMBER
REFERENCE DETAIL SHEET NUMBER

DETAILED SECTION AT SHEET No. A09

ROOM CODE
ROOM ID

FUNCTION AREA

R.C.L.:REN. CONCRETE LEVEL

F.F.L.:FINISH FLOOR LEVEL

S.L. : SEA LEVEL

REVISIONS		
NO.	DRAWINGS	DATE
(1)		
(2)		
(3)		

Contracting Authority:

Funded By:

Project Title:

“Public Works Contract for the rehabilitation of 5 schools in East Jerusalem”

Reference number: PSE22001-10074

Lot 1: the rehabilitation of Al-Hasan Al-Thany, Al-Shabbat Al-Shameleh, and Al-Fata Al-Laji’a schools in Wadi Al-Joz

Al-Shameleh Secondary Girls' school


Designed by:

HOSH STUDIO
ARCHITECTURE & TOWN PLANNING

Jerusalem - Sheikh Jarrah- Tobler8
email: mr.wasimhija@gmail.com

Tel. 02-9948344/ 052-8327076
Fax: 02-9948344

Drawing Title	Scope of Intervention	Date: 25/3/2025 Scale: 1:100
Designed by:	Arch. Hiba Al Ayoubi	Drawing No: E34
Checked by:	Arch. Wasim Abu El-Hija	
Approved by:		
Coordinate Manager:		

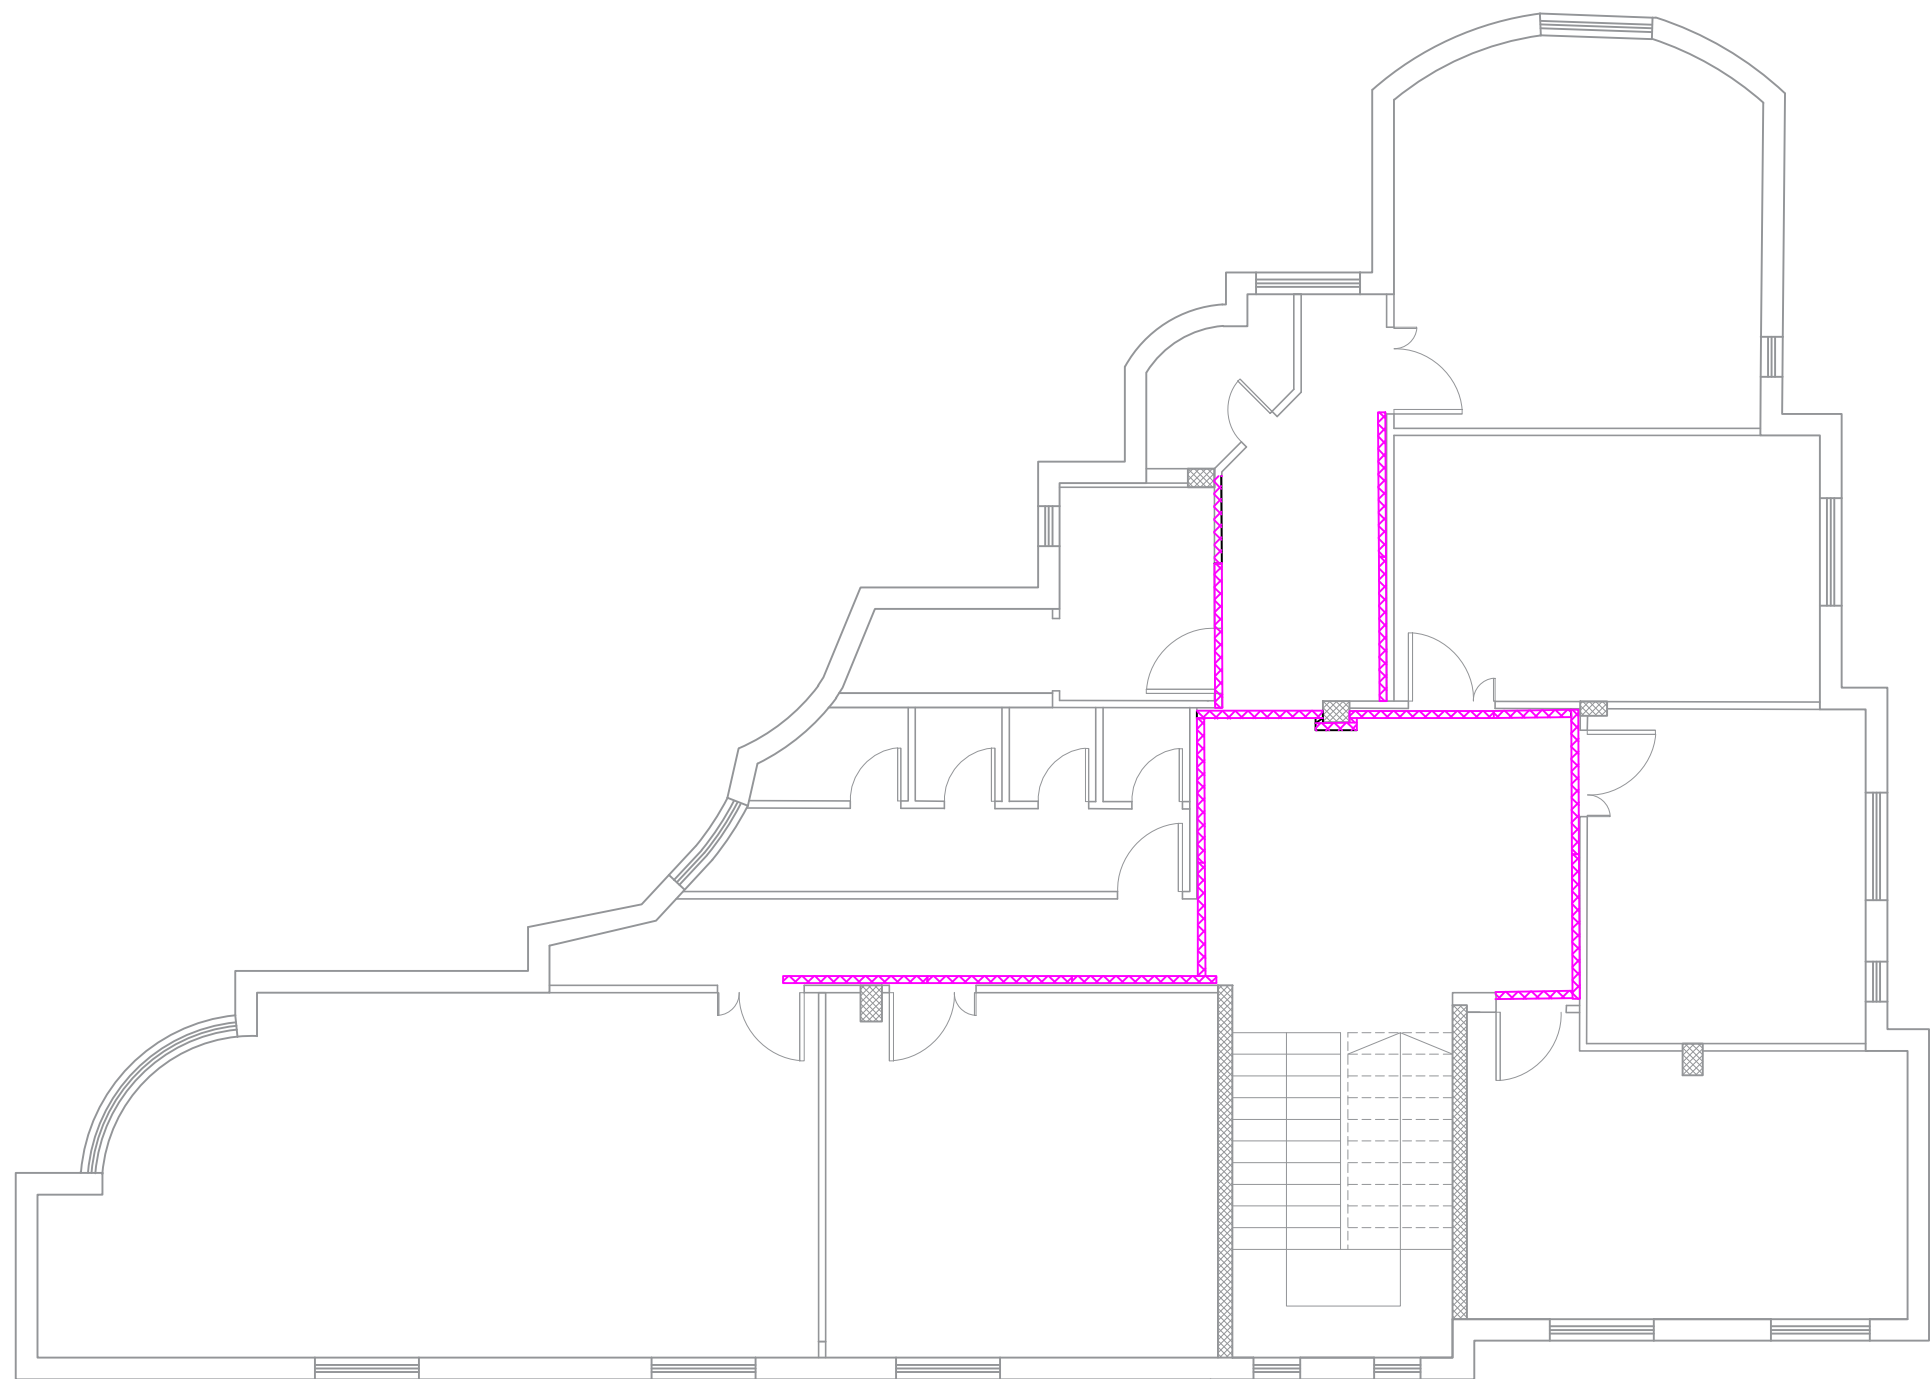

FIRST FLOOR &

Notes

- (1) All Dimensions Are In M.
- (2) All Levels Are In Meter
- (3) Any Missing or Unclear Detail And All Fastening Systems For All Elements Shall be Approved by The Supervisor.

Legend:

SECTION NUMBER
REFERENCE SHEET NUMBER

DOOR CODE
FUNCTION
AREA
ROOM ID

DOOR NUMBER
REFERENCE DETAIL SHEET NUMBER

FLOOR FINISH LEVEL (F.F.L.)
REINFORCEMENT CONCRETE LEVEL (R.C.L.)

WINDOW NUMBER
REFERENCE DETAIL SHEET NUMBER

LEVEL SIGN IN PLAN

DETAILED SECTION AT SHEET No. A09

STEEL SHEETS
RC CONCRETE FOR COLUMNS
RC CONCRETE FOR WALLS
CONCRETE
STONE WALL
HOLLOW BLOCKS
CEMENT TILE
PORCELAIN TILE
LOCAL MARBLE
Gypsum partition

ENTRANCE
ARTIFICIAL GRASS
PORCELAIN TILES (PARQUET STYLE)
DEMOLISHING AND REMOVAL
NEW INTERVENTION

R.C.L.: REN. CONCRETE LEVEL
F.F.L.: FINISH FLOOR LEVEL
S.L.: SEA LEVEL

REVISIONS

NO.	DRAWINGS	DATE
(1)		
(2)		
(3)		

Contracting Authority:



Funded By:



Project Title:

“Public Works Contract for the rehabilitation of 5 schools in East Jerusalem”

Reference number: PSE22001-10074

Lot 1: the rehabilitation of Al-Hasan Al-Thany, Al-Shabbat Al-Shameleh, and Al-Fata Al-Laji’a schools in Wadi Al-Joz


Al-Shameleh Secondary Girls' school

Designed by:



Jerusalem - Sheikh Jarrah- Tobler8
email: mr.wasimhija@gmail.com
Tel. 02-9948344/ 052-8327076
Fax: 02-9948344

Drawing Title	Scope of Intervention	Date: 25/3/2025 Scale: 1:100
Designed by:	Arch. Hiba Al Ayoubi	Drawing No: E35
Checked by:	Arch. Wasim Abu El-Hija	
Approved by:		
Coordinate Manager:		

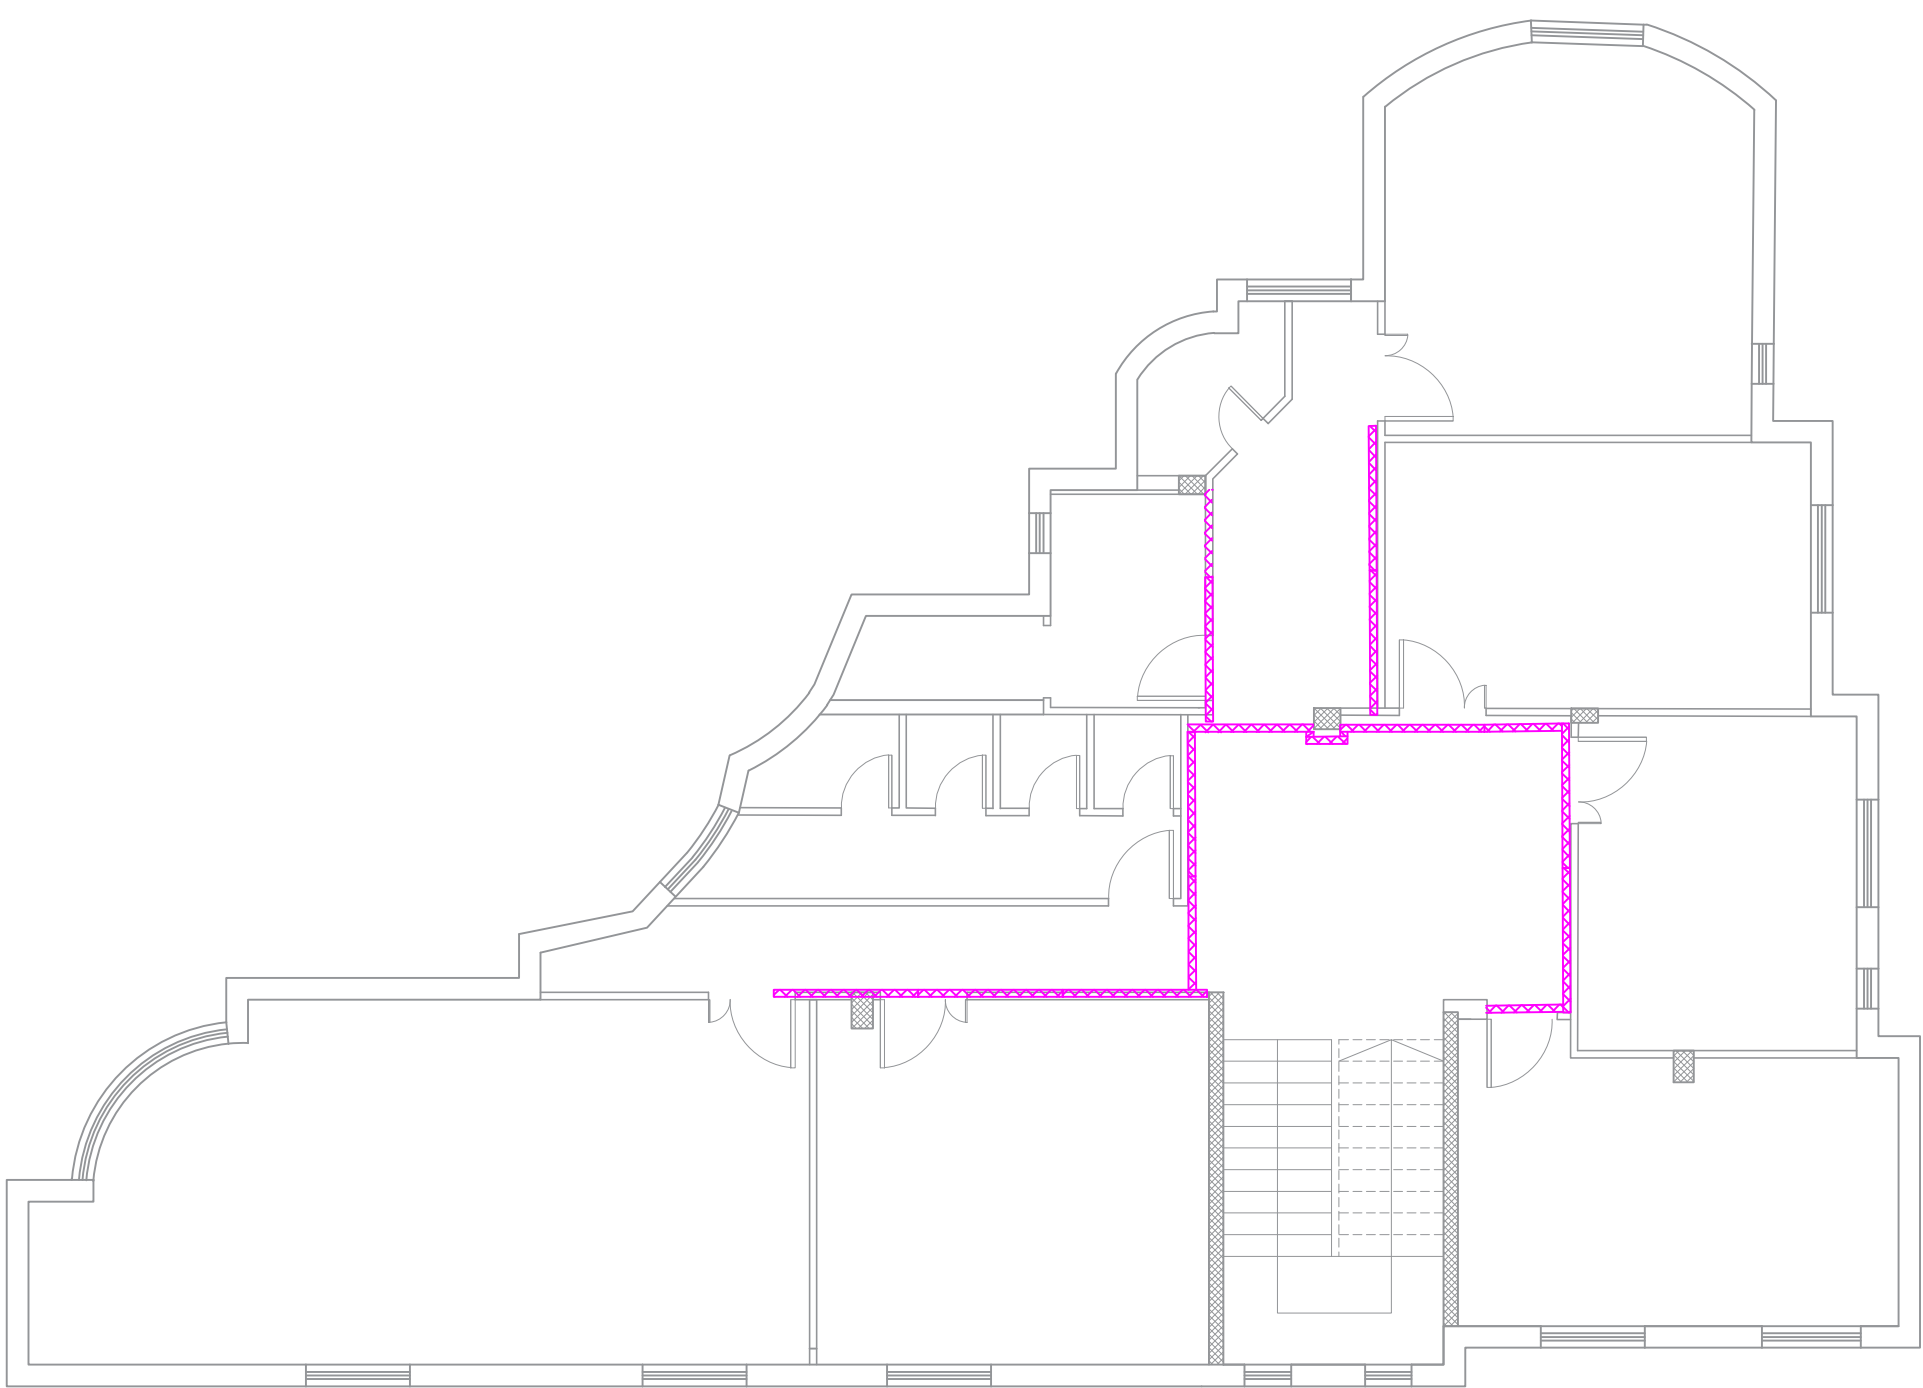

SECOND FLOOR

Notes

(1) All Dimensions Are In M.

(2) All Levels Are In Meter

(3) Any Missing or Unclear Detail And All Fastening Systems For All Elements Shall be Approved by The Supervisor.

Legend:

SECTION NUMBER

REFERENCE SHEET NUMBER

DOOR CODE

ROOM ID

FLOOR FINISH LEVEL (F.F.L.)

REINFORCEMENT CONCRETE LEVEL (R.C.L.)

LEVEL SIGN IN PLAN

DOOR NUMBER

REFERENCE DETAIL SHEET NUMBER

WINDOW NUMBER

REFERENCE DETAIL SHEET NUMBER

DETAILED SECTION AT SHEET No. A09

STEEL SHEETS

RC CONCRETE FOR COLUMNS

RC CONCRETE FOR WALLS

CONCRETE

STONE WALL

HOLLOW BLOCKS

CEMENT TILE

PORCELAIN TILE

LOCAL MARBLE

Gypsum partition

ENTRANCE

ARTIFICIAL GRASS

PORCELAIN TILES (PARQUET STYLE)

DEMOLISHING AND REMOVAL

NEW INTERVENTION

R.C.L.:REN. CONCRETE LEVEL

F.F.L.:FINISH FLOOR LEVEL

S.L. : SEA LEVEL

REVISIONS		
NO.	DRAWINGS	DATE
(1)		
(2)		
(3)		

Contracting Authority:

Funded By:

Project Title:

“Public Works Contract for the rehabilitation of 5 schools in East Jerusalem”

Reference number: PSE22001-10074

Lot 1: the rehabilitation of Al-Hasan Al-Thany, Al-Shabbat Al-Shameleh, and Al-Fata Al-Laji’a schools in Wadi Al-Joz

Al-Shameleh Secondary Girls' school

Designed by:


Jerusalem - Sheikh Jarrah- Tobler8

email: mr.wasimhija@gmail.com

Tel. 02-9948344/ 052-8327076

Fax: 02-9948344

Drawing Title	Scope of Intervention	Date: 25/3/2025
	Cable Trays For Power & LV <td>Scale: 1:100</td>	Scale: 1:100
Designed by:	Arch. Hiba Al Ayoubi	Drawing No: E36
Checked by:	Arch. Wasim Abu El-Hija	
Approved by:		
Coordinate Manager:		

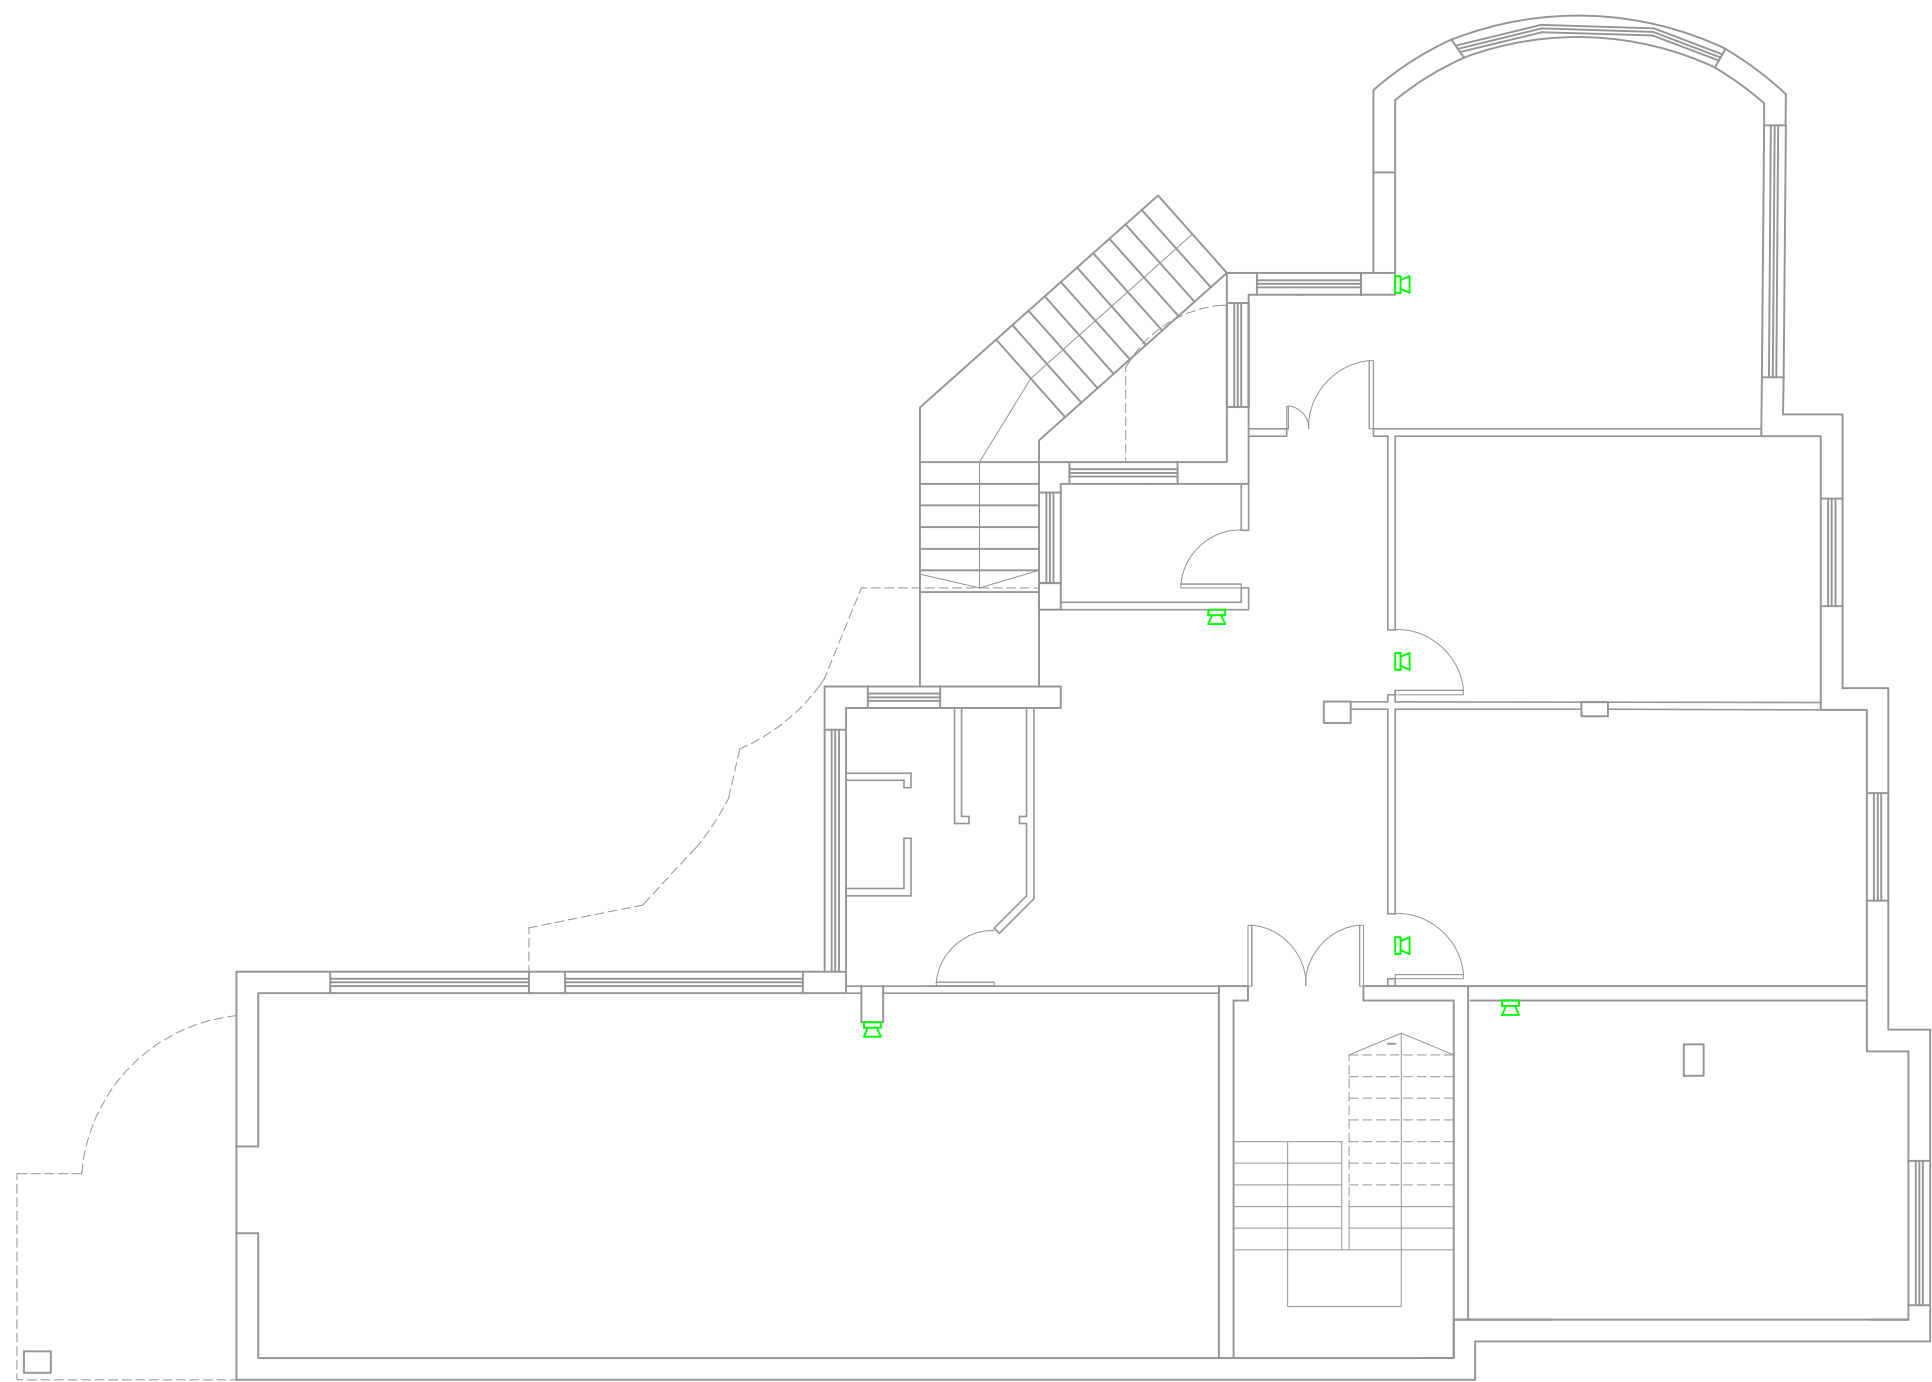

BASEMENT FLOOR

Notes

(1) All Dimensions Are In M.
(2) All Levels Are In Meter
(3) Any Missing or Unclear Detail And All Fastening Systems For All Elements Shall be Approved by The Supervisor.

Legend:

SECTION NUMBER
REFERENCE SHEET NUMBER

REFERENCE DETAIL SHEET NUMBER

FLOOR FINISH LEVEL (F.F.L.)
REINFORCEMENT CONCRETE LEVEL (R.C.L.)

LEVEL SIGN IN PLAN

ROOM CODE
AREA
ROOM ID

DOOR NUMBER
REFERENCE DETAIL SHEET NUMBER

WINDOW NUMBER
REFERENCE DETAIL SHEET NUMBER

DETAILED SECTION AT SHEET No. A09

STEEL SHEETS
RC CONCRETE FOR COLUMNS
RC CONCRETE FOR WALLS
STONE WALL
HOLLOW BLOCKS
CEMENT TILE
PORCELAIN TILE
LOCAL MARBLE
Gypsum partition

ENTRANCE
ARTIFICIAL GRASS
PORCELAIN TILES (PARQUET STYLE)
DEMOLISHING AND REMOVAL
NEW INTERVENTION

R.C.L.:REN. CONCRETE LEVEL
F.F.L.:FINISH FLOOR LEVEL
S.L.: SEA LEVEL

REVISIONS		
NO.	DRAWINGS	DATE
(1)		
(2)		
(3)		

Contracting Authority:

Funded By:

Project Title:

“Public Works Contract for the rehabilitation of 5 schools in East Jerusalem”

Reference number: PSE22001-10074

Lot 1: the rehabilitation of Al-Hasan Al-Thany, Al-Shabbat Al-Shameleh, and Al-Fata Al-Laji’a schools in Wadi Al-Joz

Al-Shameleh Secondary Girls' school


Designed by:

HOSH STUDIO
ARCHITECTURE & TOWN PLANNING

Jerusalem - Sheikh Jarrah- Tobler8
email: mr.wasimhija@gmail.com

Tel. 02-9948344/ 052-8327076
Fax: 02-9948344

Drawing Title	Scope of Intervention public Address System	Date: 25/3/2025 Scale: 1:100
Designed by:	Arch. Hiba Al Ayoubi	Drawing No:
Checked by:	Arch. Wasim Abu El-Hija	E37
Approved by:		
Coordinate Manager:		

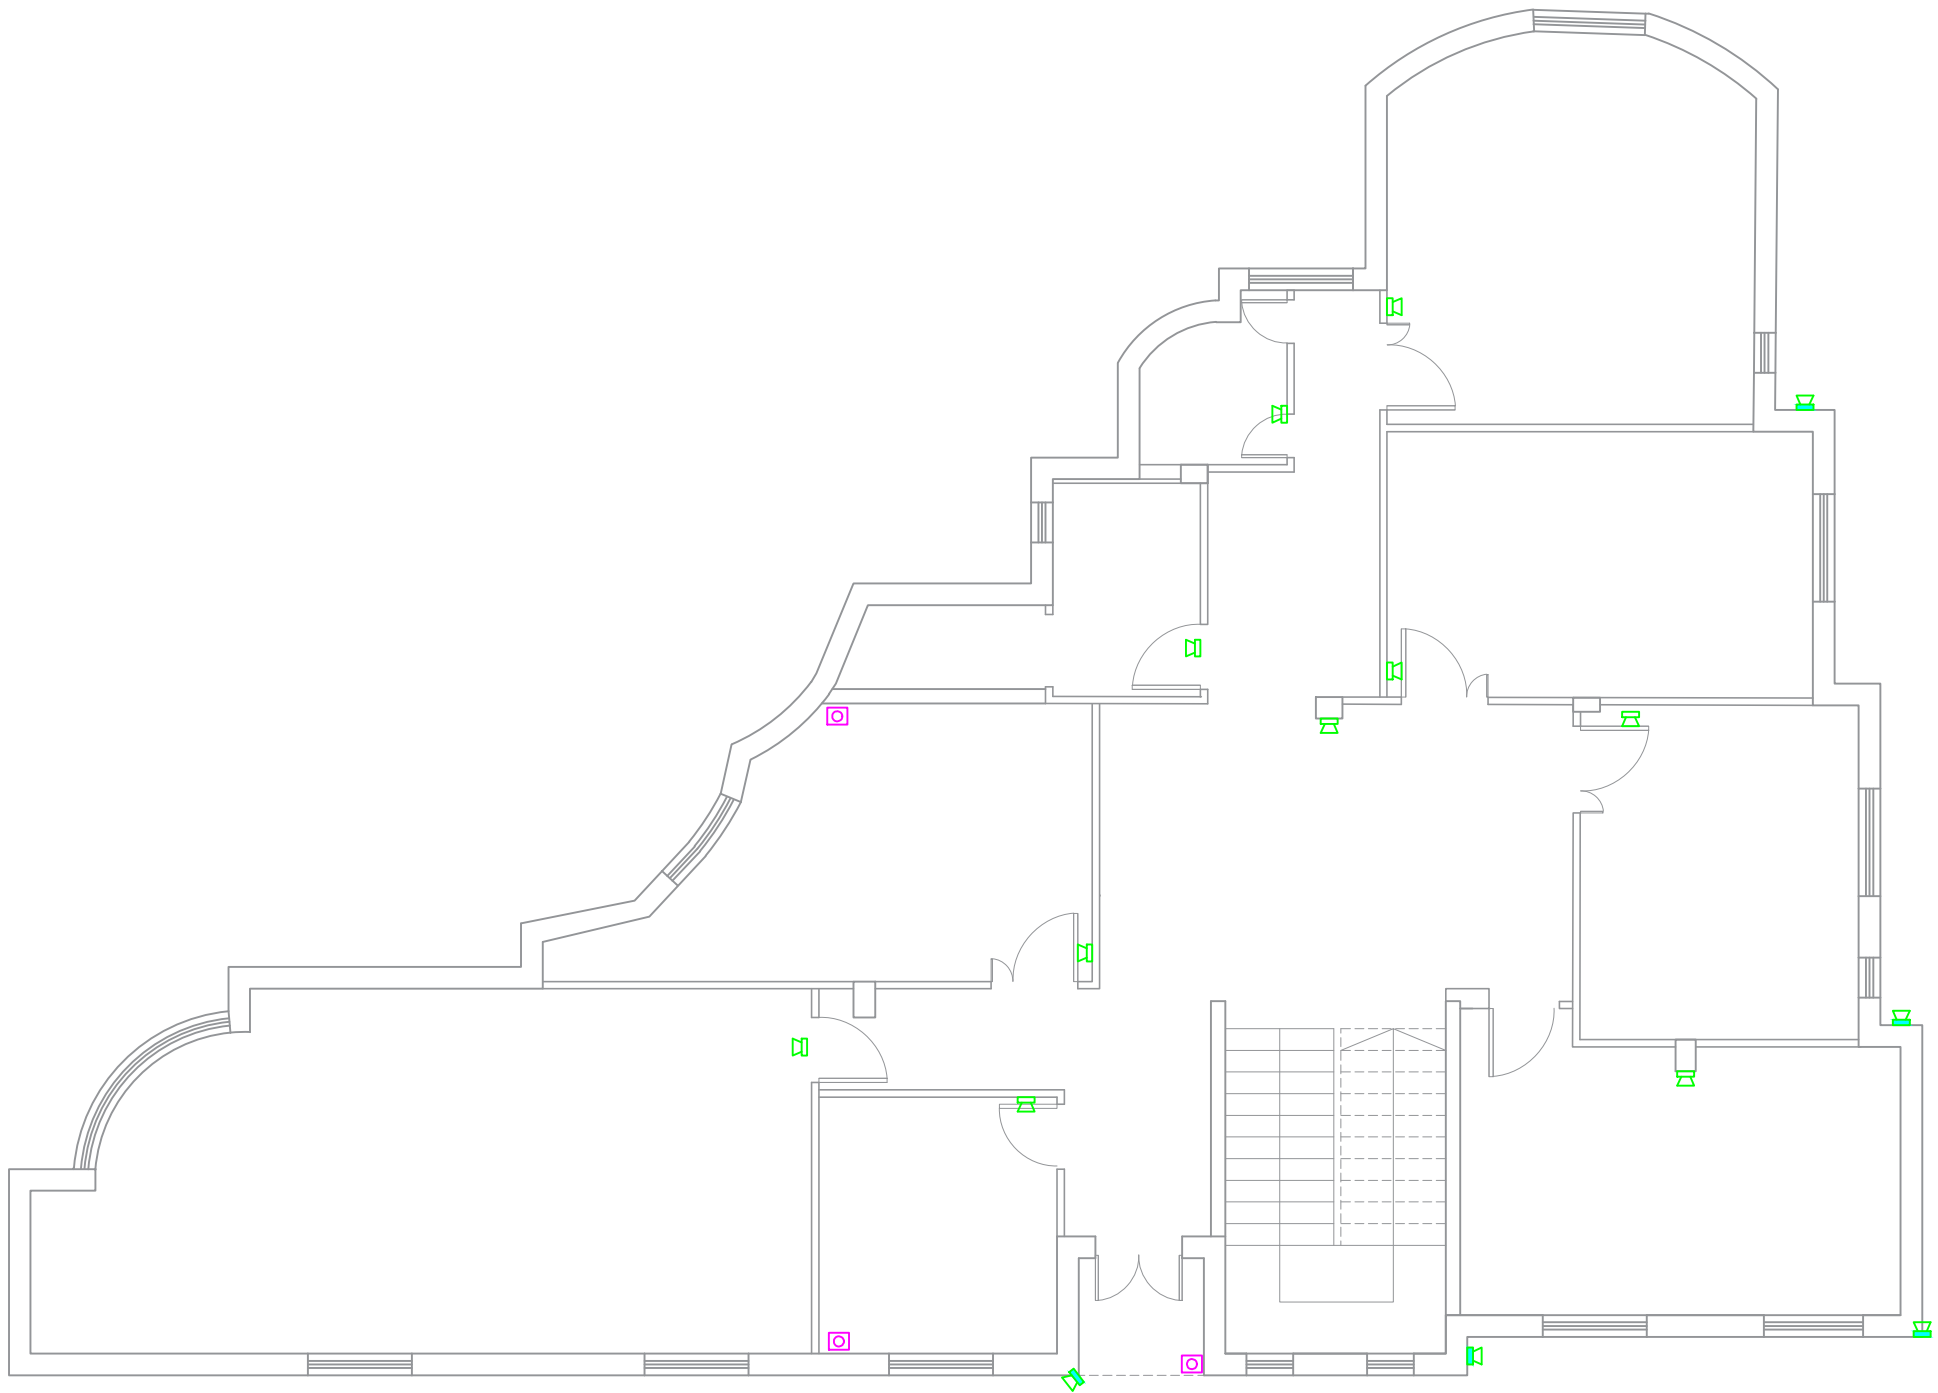

GROUND FLOOR

Notes

(1) All Dimensions Are In M.
(2) All Levels Are In Meter
(3) Any Missing or Unclear Detail And All Fastening Systems For All Elements Shall be Approved by The Supervisor.

Legend:

SECTION NUMBER
REFERENCE SHEET NUMBER

REFERENCE DETAIL SHEET NUMBER

FLOOR FINISH LEVEL (F.F.L.)
REINFORCEMENT CONCRETE LEVEL (R.C.L.)

LEVEL SIGN IN PLAN

STEEL SHEETS

RC CONCRETE FOR COLUMNS

RC CONCRETE FOR WALLS

CONCRETE

STONE WALL

HOLLOW BLOCKS

CEMENT TILE

PORCELAIN TILE

LOCAL MARBLE

Gypsum partition

ENTRANCE

ARTIFICIAL GRASS

PORCELAIN TILES (PARQUET STYLE)

DEMOLISHING AND REMOVAL

NEW INTERVENTION

DOOR NUMBER
REFERENCE DETAIL SHEET NUMBER

WINDOW NUMBER
REFERENCE DETAIL SHEET NUMBER

DETAILED SECTION AT SHEET No. A09

ROOM CODE
ROOM ID

FUNCTION AREA

R.C.L.: REN. CONCRETE LEVEL

F.F.L.: FINISH FLOOR LEVEL

S.L.: SEA LEVEL

REVISIONS		
NO.	DRAWINGS	DATE
(1)		
(2)		
(3)		

Contracting Authority:

Funded By:

Project Title:

“Public Works Contract for the rehabilitation of 5 schools in East Jerusalem”

Reference number: PSE22001-10074

Lot 1: the rehabilitation of Al-Hasan Al-Thany, Al-Shabbat Al-Shameleh, and Al-Fata Al-Laji’a schools in Wadi Al-Joz

Al-Shameleh Secondary Girls' school

Designed by:

HOSH STUDIO
ARCHITECTURE & TOWN PLANNING

Jerusalem - Sheikh Jarrah- Tobler8
email: mr.wasimhija@gmail.com

Tel. 02-9948344/ 052-8327076
Fax: 02-9948344

Drawing Title	Scope of Intervention	Date: 25/3/2025 Scale: 1:100
Designed by:	Arch. Hiba Al Ayoubi	Drawing No: E38
Checked by:	Arch. Wasim Abu El-Hija	
Approved by:		
Coordinate Manager:		



FIRST FLOOR &

Notes

(1) All Dimensions Are In M.

(2) All Levels Are In Meter

(3) Any Missing or Unclear Detail And All Fastening Systems For All Elements Shall be Approved by The Supervisor.

Legend:

SECTION NUMBER
REFERENCE SHEET NUMBER

REFERENCE DETAIL SHEET NUMBER

FLOOR FINISH LEVEL (F.F.L.)
REINFORCEMENT CONCRETE LEVEL (R.C.L.)

LEVEL SIGN IN PLAN

ROOM CODE
FUNCTION AREA
ROOM ID

DOOR NUMBER
REFERENCE DETAIL SHEET NUMBER

WINDOW NUMBER
REFERENCE DETAIL SHEET NUMBER

X X
DETAILED SECTION AT SHEET No. A09

STEEL SHEETS

RC CONCRETE FOR COLUMNS

RC CONCRETE FOR WALLS

CONCRETE

STONE WALL

HOLLOW BLOCKS

CEMENT TILE

PORCELAIN TILE

LOCAL MARBLE

Gypsum partition

ENTRANCE

ARTIFICIAL GRASS

PORCELAIN TILES (PARQUET STYLE)

DEMOLISHING AND REMOVAL

NEW INTERVENTION

R.C.L.:REN. CONCRETE LEVEL

F.F.L.:FINISH FLOOR LEVEL

S.L.: SEA LEVEL

REVISIONS		
NO.	DRAWINGS	DATE
(1)		
(2)		
(3)		

Contracting Authority:

Funded By:

Project Title:

“Public Works Contract for the rehabilitation of 5 schools in East Jerusalem”

Reference number: PSE22001-10074

Lot 1: the rehabilitation of Al-Hasan Al-Thany, Al-Shabbat Al-Shameleh, and Al-Fata Al-Laji’a schools in Wadi Al-Joz

Al-Shameleh Secondary Girls' school


Designed by:

HOSH STUDIO
ARCHITECTURE & TOWN PLANNING

Jerusalem - Sheikh Jarrah- Tobler8
email: mr.wasimhija@gmail.com

Tel. 02-9948344/ 052-8327076
Fax: 02-9948344

Drawing Title	Scope of Intervention public Address System	Date: 25/3/2025 Scale: 1:100
Designed by:	Arch. Hiba Al Ayoubi	Drawing No: E39
Checked by:	Arch. Wasim Abu El-Hija	
Approved by:		
Coordinate Manager:		

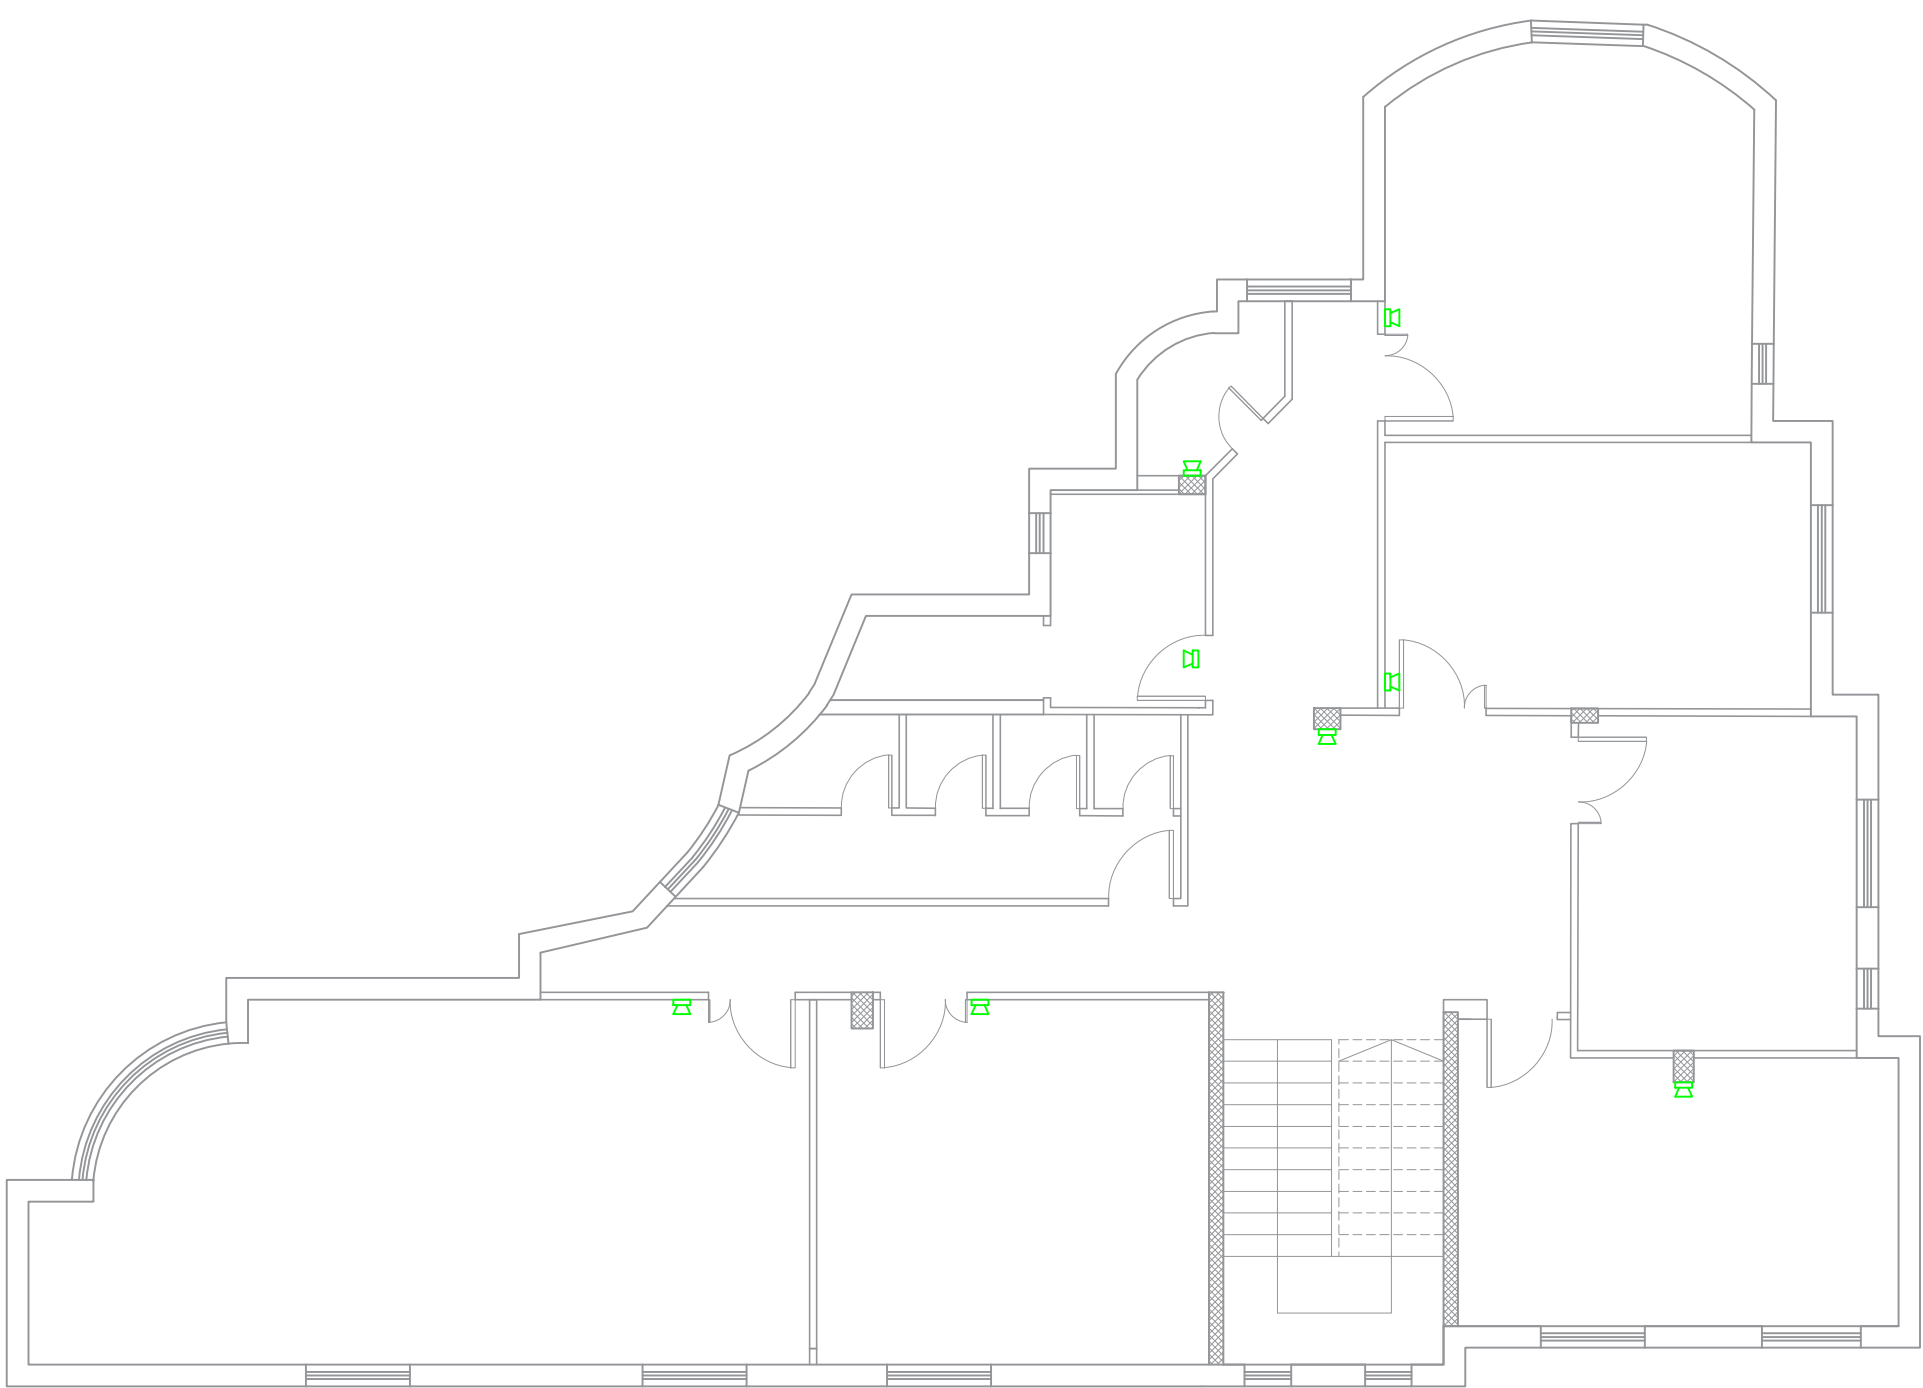

SECOND FLOOR

Notes

(1) All Dimensions Are In M.
(2) All Levels Are In Meter
(3) Any Missing or Unclear Detail And All Fastening Systems For All Elements Shall be Approved by The Supervisor.

Legend:

SECTION NUMBER
REFERENCE SHEET NUMBER

REFERENCE DETAIL SHEET NUMBER

FLOOR FINISH LEVEL (F.F.L.)
REINFORCEMENT CONCRETE LEVEL (R.C.L.)

LEVEL SIGN IN PLAN

ROOM CODE
AREA
ROOM ID

DOOR NUMBER
REFERENCE DETAIL SHEET NUMBER

WINDOW NUMBER
REFERENCE DETAIL SHEET NUMBER

DETAILED SECTION AT SHEET No. A09

STEEL SHEETS
RC CONCRETE FOR COLUMNS
RC CONCRETE FOR WALLS
CONCRETE
STONE WALL
HOLLOW BLOCKS
CEMENT TILE
PORCELAIN TILE
LOCAL MARBLE
Gypsum partition

ENTRANCE
ARTIFICIAL GRASS
PORCELAIN TILES (PARQUET STYLE)
DEMOLISHING AND REMOVAL
NEW INTERVENTION

R.C.L.:REN. CONCRETE LEVEL
F.F.L.:FINISH FLOOR LEVEL
S.L.: SEA LEVEL

REVISIONS

NO.	DRAWINGS	DATE
(1)		
(2)		
(3)		

Contracting Authority:

Funded By:

Project Title:

“Public Works Contract for the rehabilitation of 5 schools in East Jerusalem”

Reference number: PSE22001-10074

Lot 1: the rehabilitation of Al-Hasan Al-Thany, Al-Shabbat Al-Shameleh, and Al-Fata Al-Laji’a schools in Wadi Al-Joz


Al-Shameleh Secondary Girls' school

Designed by:

Jerusalem - Sheikh Jarrah- Tobler8
email: mr.wasimhija@gmail.com

Tel. 02-9948344/ 052-8327076
Fax: 02-9948344

Drawing Title	Scope of Intervention	Date: 25/3/2025 Scale: 1:100
Designed by:	Arch. Hiba Al Ayoubi	Drawing No: E40
Checked by:	Arch. Wasim Abu El-Hija	
Approved by:		
Coordinate Manager:		

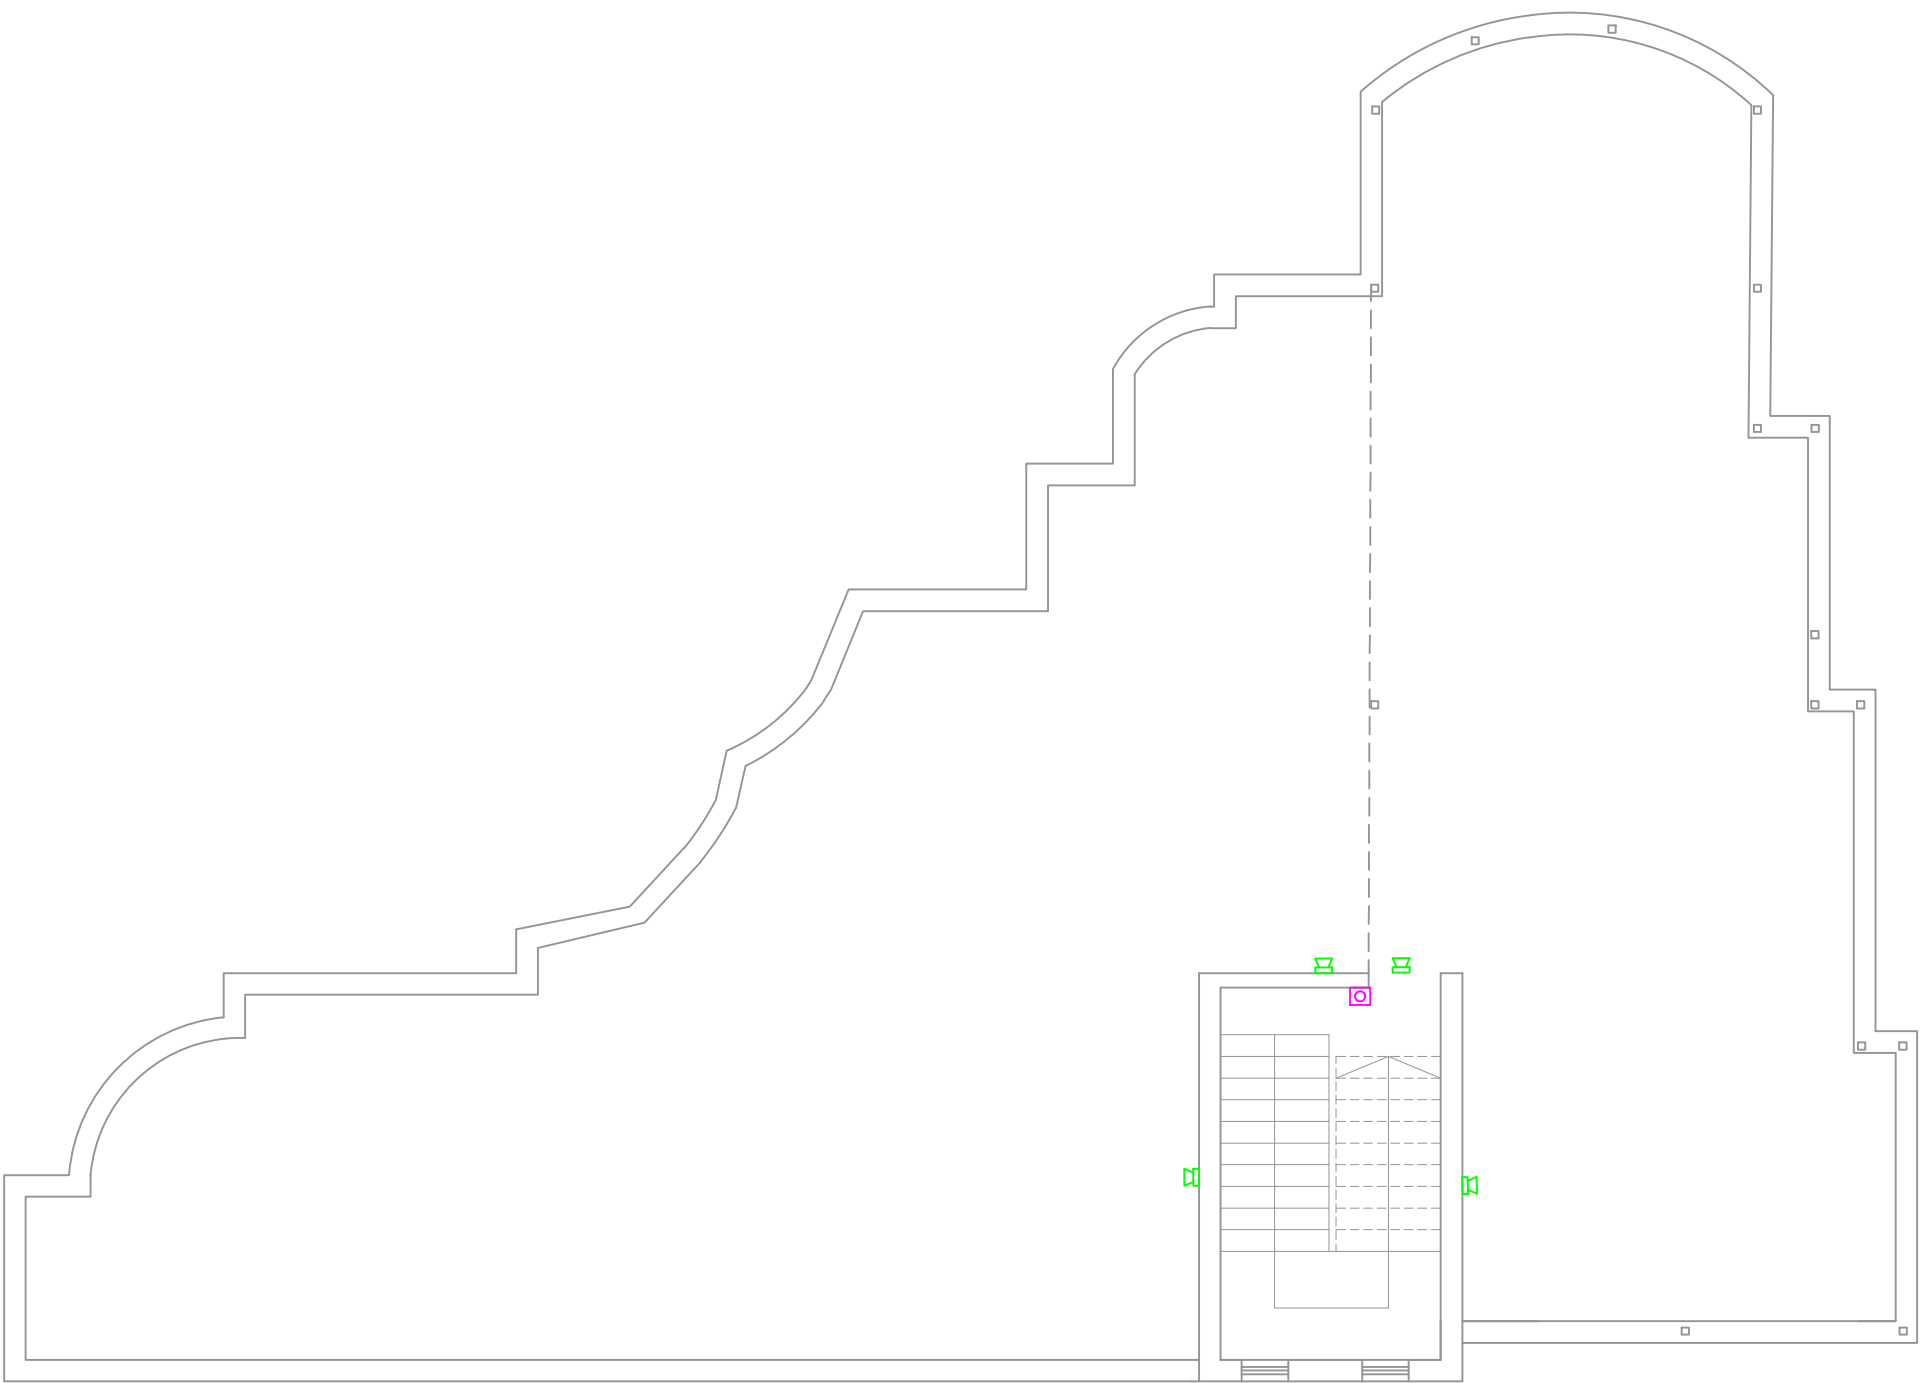

ROOF FLOOR PLAN

Notes

(1) All Dimensions Are In M.
(2) All Levels Are In Meter
(3) Any Missing or Unclear Detail And All Fastening Systems For All Elements Shall be Approved by The Supervisor.

Legend:

SECTION NUMBER
REFERENCE SHEET NUMBER

REFERENCE DETAIL SHEET NUMBER

FLOOR FINISH LEVEL (F.F.L.)
REINFORCEMENT CONCRETE LEVEL (R.C.L.)

LEVEL SIGN IN PLAN

STEEL SHEETS

RC CONCRETE FOR COLUMNS

RC CONCRETE FOR WALLS

STONE WALL

HOLLOW BLOCKS

CEMENT TILE

PORCELAIN TILE

LOCAL MARBLE

Gypsum partition

FUNCTION
AREA
ROOM ID

DOOR NUMBER
REFERENCE DETAIL SHEET NUMBER

WINDOW NUMBER
REFERENCE DETAIL SHEET NUMBER

ENTRANCE

ARTIFICIAL GRASS

PORCELAIN TILES (PARQUET STYLE)

DEMOLISHING AND REMOVAL

NEW INTERVENTION

R.C.L.:REN. CONCRETE LEVEL

F.F.L.:FINISH FLOOR LEVEL

S.L. : SEA LEVEL

DETAILED SECTION AT SHEET No. A09

REVISIONS

NO.	DRAWINGS	DATE
(1)		
(2)		
(3)		

Contracting Authority:

Enabel

Funded By:

Belgium
partner in development

Project Title:

“Public Works Contract for the rehabilitation of 5 schools in East Jerusalem”

Reference number: PSE22001-10074

Lot 1: the rehabilitation of Al-Hasan Al-Thany, Al-Shabbat Al-Shameleh, and Al-Fata Al-Laji’a schools in Wadi Al-Joz

Al-Shameleh Secondary Girls' school

Designed by:

HOSH STUDIO
ARCHITECTURE & TOWN PLANNING

Jerusalem - Sheikh Jarrah- Tobler8
email: mr.wasimhija@gmail.com

Tel. 02-9948344/ 052-8327076
Fax: 02-9948344

Drawing Title	Scope of Intervention Public Address System	Date: 25/3/2025 Scale: 1:100
Designed by:	Arch. Hiba Al Ayoubi	Drawing No:
Checked by:	Arch. Wasim Abu El-Hija	E41
Approved by:		
Coordinate Manager:		

From JEDCO



MDB

DB G - AC

DB G

MDB

KWH

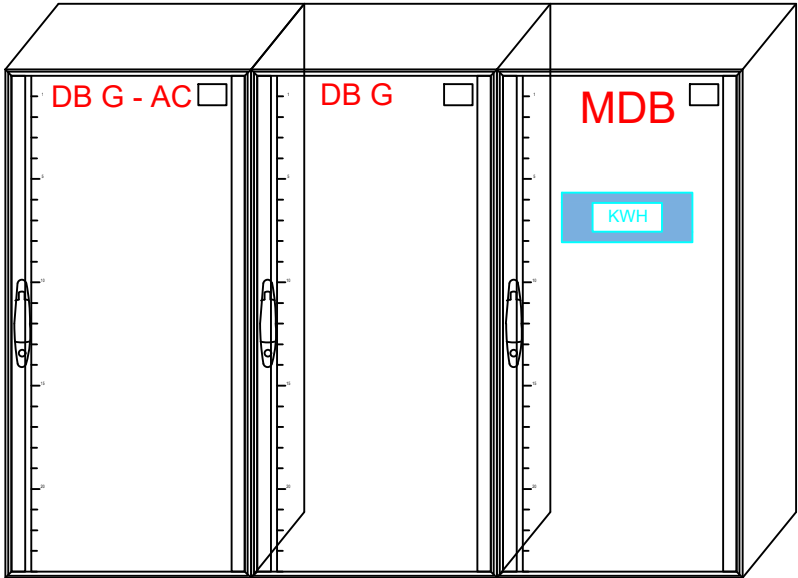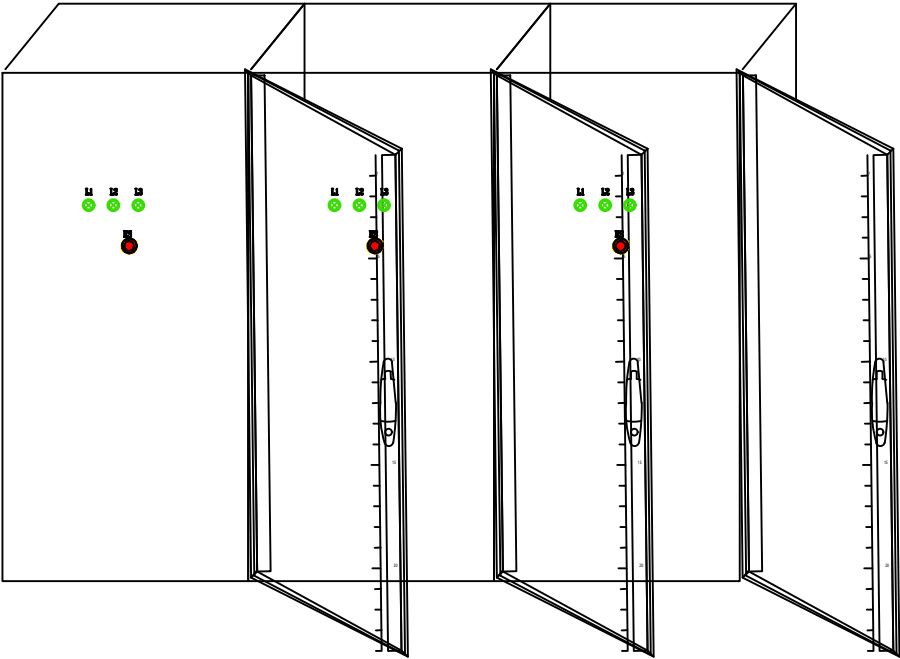

Notes

- (1) All Dimensions Are In M.
(2) All Levels Are In Meter
(3) Any Missing or Unclear Detail And All Fastening Systems For All Elements Shall be Approved by The Supervisor.

Legend:

REVISIONS		
NO.	DRAWINGS	DATE
(1)		
(2)		
(3)		

Contracting Authority:



Funded By:



Project Title:

"Public Works Contract for the rehabilitation of 5 schools in East Jerusalem"

Reference number: PSE22001-10074

Lot 1: the rehabilitation of Al-Hasan Al-Thany, Al-Shabbat Al-Shameleh, and Al-Fata Al-Laji'a schools in Wadi Al-Joz


Al-Shameleh Secondary Girls' school

Designed by:



Jerusalem - Sheikh Jarrah - Tobler8
email: mr.wasimhija@gmail.com
Tel. 02-9948344/ 052-8327076
Fax: 02-9948344

Drawing Title	Scope of Intervention	Date: 25/3/2025
		Scale: 1:100
Designed by:	Eng. Adli Naser Al-Deen	Drawing No: E42
Checked by:	Eng. Adli Naser Al-Deen	
Approved by:		
Coordinate Manager:		

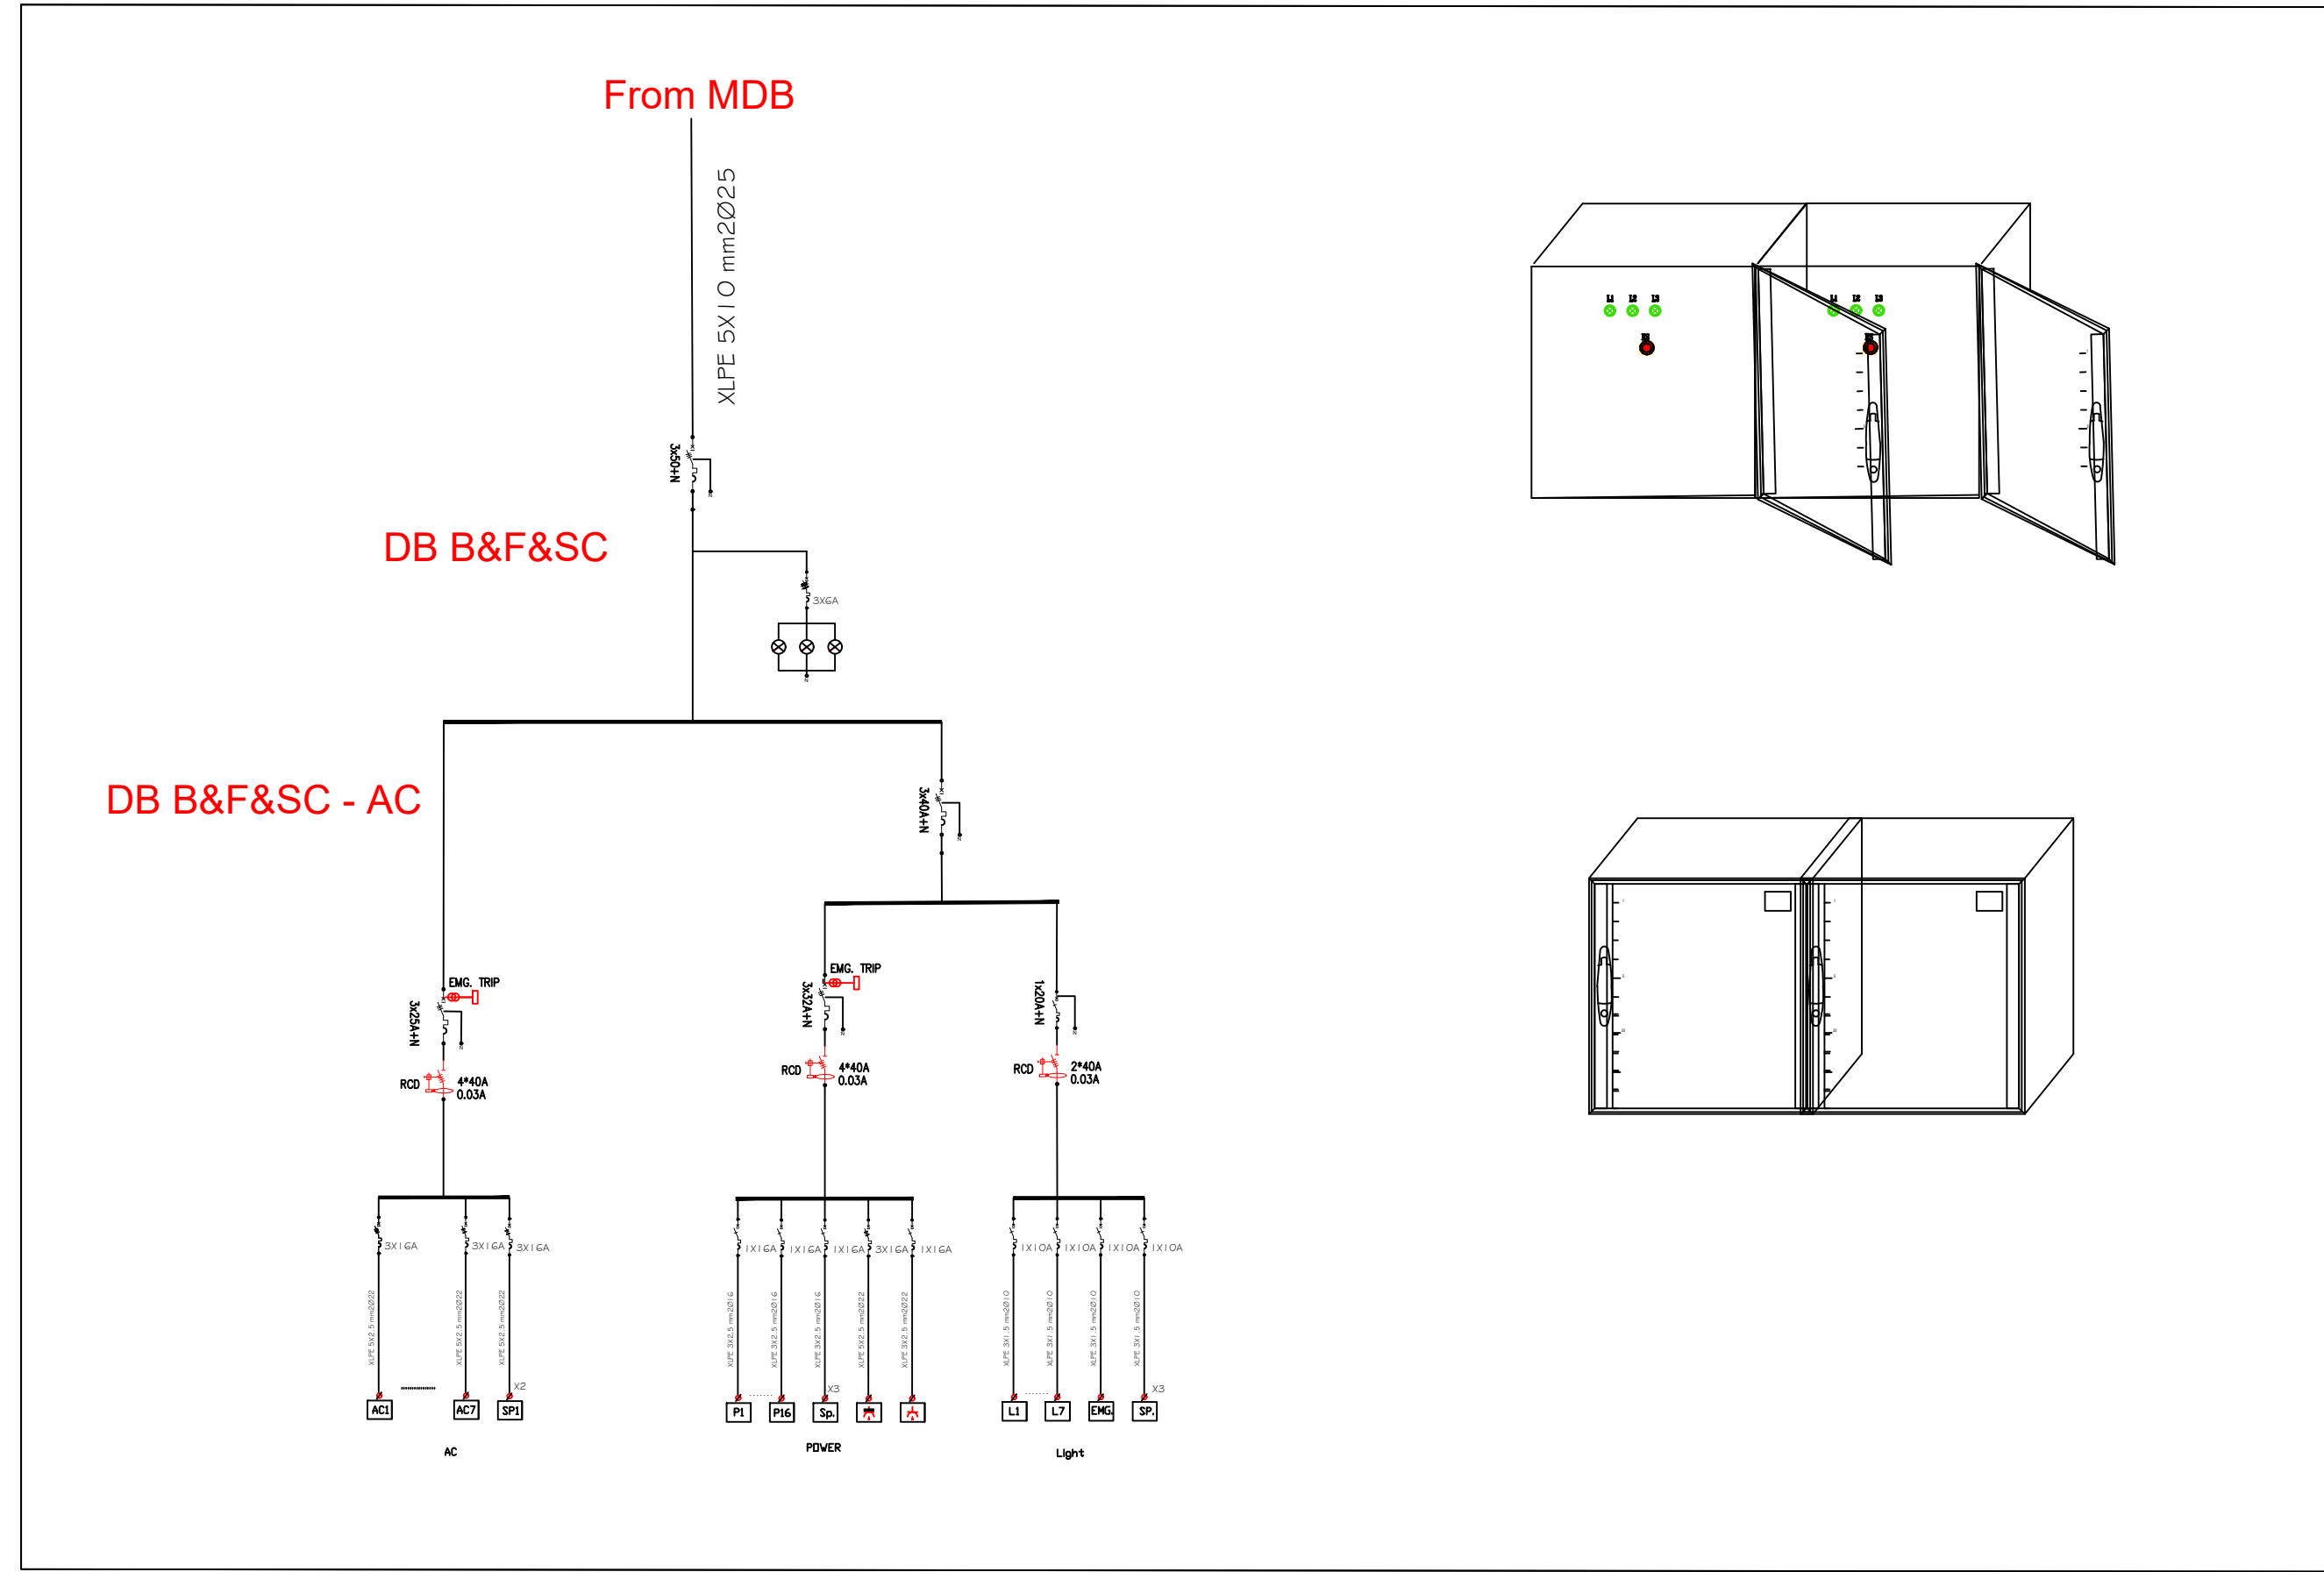

Notes

(1) All Dimensions Are In M.
(2) All Levels Are In Meter
(3) Any Missing or Unclear Detail And All Fastening Systems For All Elements Shall be Approved by The Supervisor.

Legend:

REVISIONS		
NO.	DRAWINGS	DATE
(1)		
(2)		
(3)		

Contracting Authority:

Enabel

Funded By:

Belgium
partner in development

Project Title:

“Public Works Contract for the rehabilitation of 5 schools in East Jerusalem”

Reference number: PSE22001-10074

Lot 1: the rehabilitation of Al-Hasan Al-Thany, Al-Shabbat Al-Shameleh, and Al-Fata Al-Laji’a schools in Wadi Al-Joz

Al-Shameleh Secondary Girls' school

Designed by:

HOSH STUDIO
ARCHITECTURE & TOWN PLANNING

Jerusalem - Sheikh Jarrah- Tobler8
email: mr.wasimhija@gmail.com

Tel. 02-9948344/ 052-8327076
Fax: 02-9948344

Drawing Title	Scope of Intervention	Date: 25/3/2025
	Sub Distribution Board	Scale: 1:100
Designed by:	Eng. Adli Naser Al-Deen	Drawing No:
Checked by:	Eng. Adli Naser Al-Deen	E43
Approved by:		
Coordinate Manager:		

Lot1B: Hasan Al Thani school

ARCHITECTURAL DRAWINGS				
#	SHETT	#	SHEET TITLE	SCALE
01	A00		LIST OF DRAWINGS & NOTES ABBREVIATION & SYMBOLS	—
02	A08		Scope of Intervention in the Site Plan	1:200
03	A09		Caravan Detail	1:100
Structural DRAWINGS				
01	S01		Caravan Structural Details	
MECHANICAL DRAWINGS				
#	SHETT	#	SHEET TITLE	SCALE
01	M02		Mechanical works	1:50

Notes
(1) All Dimensions Are In M. (2) All Levels Are In Meter (3) Any Missing or Unclear Detail And All Fastening Systems For All Elements Shall be Approved by The Supervisor.

Legend:
SECTION NUMBER REFERENCE SHEET NUMBER DOOR NUMBER WINDOW NUMBER FLOOR FINISH LEVEL (F.F.L.) REINFORCEMENT CONCRETE LEVEL (R.C.L.) LEVEL SIGN IN PLAN DETAILED SECTION AT SHEET No. A09 ROOM CODE AREA ROOM ID FUNCTION ENTRANCE ARTIFICIAL GRASS PORCELAIN TILES (PARQUET STYLE) DEMOLISHING AND REMOVAL NEW INTERVENTION STEEL SHEETS RC CONCRETE FOR COLUMNS RC CONCRETE FOR WALLS CONCRETE STONE WALL HOLLOW BLOCKS CEMENT TILE PORCELAIN TILE LOCAL MARBLE Gypsum partition R.C.L.:REN. CONCRETE LEVEL F.F.L.:FINISH FLOOR LEVEL S.L.: SEA LEVEL

REVISIONS		
NO.	DRAWINGS	DATE
(1)		
(2)		
(3)		


Contracting Authority:	
------------------------	--

Funded By:	
------------	--

“Public Works Contract for the rehabilitation of 5 schools in East Jerusalem” Reference number: PSE22001-10074 Lot 1: the rehabilitation of Al-Hasan Al-Thany, Al-Shabbat Al-Shameleh, and Al-Fata Al-Laji’a schools in Wadi Al-Joz Hasan Al Thani school

Designed by:	 HOSH STUDIO ARCHITECTURE & TOWN PLANNING
Jerusalem - Sheikh Jarrah- Tobler8 email: mr.wasimhija@gmail.com	
Tel. 02-9948344/ 052-8327076 Fax: 02-9948344	

Drawing Title	Table of Drawings	Date: 25/3/2025 Scale: 1:100
Designed by:	Arch. Hiba Al Ayoubi	Drawing No:
Checked by:	Arch. Wasim Abu El-Hija	A00
Approved by:		
Coordinate Manager:		

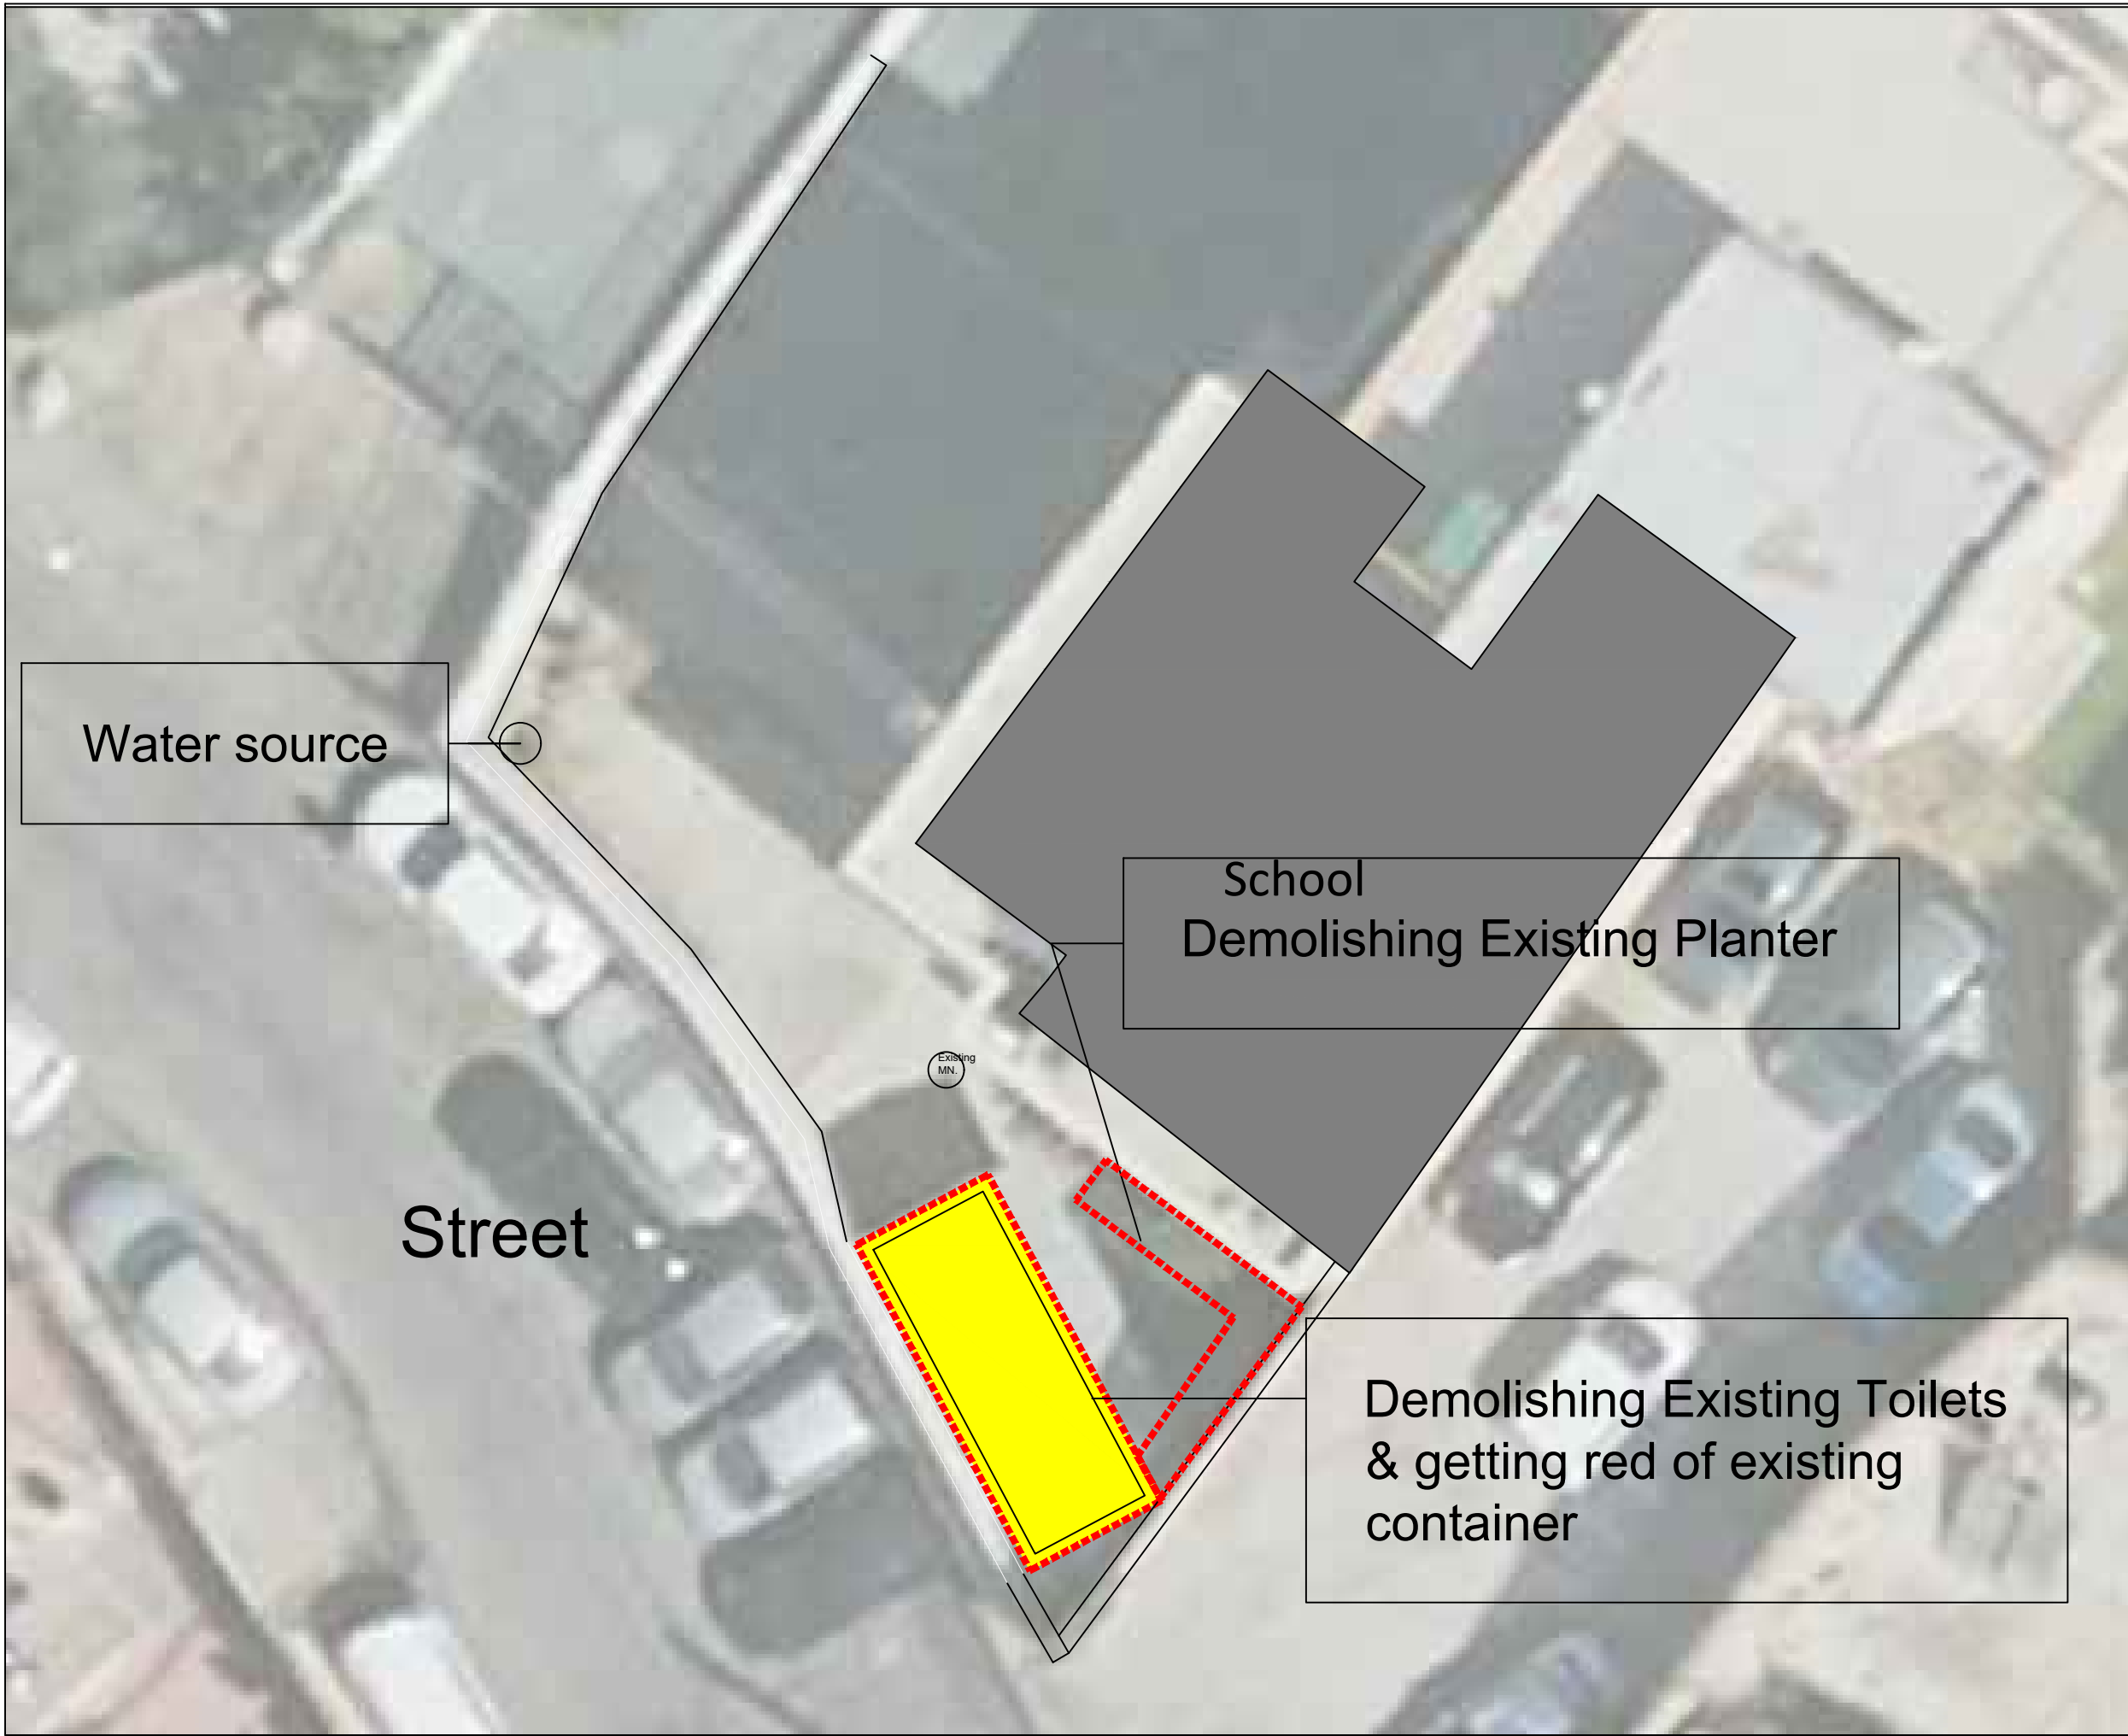

Notes

- (1) All Dimensions Are In M.
- (2) All Levels Are In Meter
- (3) Any Missing or Unclear Detail And All Fastening Systems For All Elements Shall be Approved by The Supervisor.

Legend:

SECTION NUMBER
REFERENCE SHEET NUMBER

REFERENCE DETAIL SHEET NUMBER

FLOOR FINISH LEVEL (F.F.L.)
REINFORCEMENT CONCRETE LEVEL (R.C.L.)

LEVEL SIGN IN PLAN

ROOM CODE
FUNCTION
AREA
ROOM ID

DOOR NUMBER
REFERENCE DETAIL SHEET NUMBER

WINDOW NUMBER
REFERENCE DETAIL SHEET NUMBER

DETAILED SECTION AT SHEET No. A09

STEEL SHEETS

RC CONCRETE FOR COLUMNS

RC CONCRETE FOR WALLS

CONCRETE

STONE WALL

HOLLOW BLOCKS

CEMENT TILE

PORCELAIN TILE

LOCAL MARBLE

Gypsum partition

ENTRANCE

ARTIFICIAL GRASS

PORCELAIN TILES (PARQUET STYLE)

DEMOLISHING AND REMOVAL

NEW INTERVENTION

R.C.L.: REN. CONCRETE LEVEL

F.F.L.: FINISH FLOOR LEVEL

S.L.: SEA LEVEL

REVISIONS

NO.	DRAWINGS	DATE
(1)		
(2)		
(3)		

Contracting Authority:



Funded By:



“Public Works Contract for the rehabilitation of 5 schools in East Jerusalem”

Reference number: PSE22001-10074

Lot 1: the rehabilitation of Al-Hasan Al-Thany, Al-Shabbat Al-Shameleh, and Al-Fata Al-Laji’a schools in Wadi Al-Joz

Hasan Al Thani school


Designed by:




Jerusalem - Sheikh Jarrah- Tobler8
email: mr.wasimhija@gmail.com
Tel. 02-9948344/ 052-8327076
Fax: 02-9948344

Drawing Title	Scope of Intervention	Date: 25/3/2025 Scale: 1:100
Designed by:	Arch. Hiba Al Ayoubi	Drawing No:
Checked by:	Arch. Wasim Abu El-Hija	A08
Approved by:		
Coordinate Manager:		

Removal the
existing concrete
or asphalt flooring

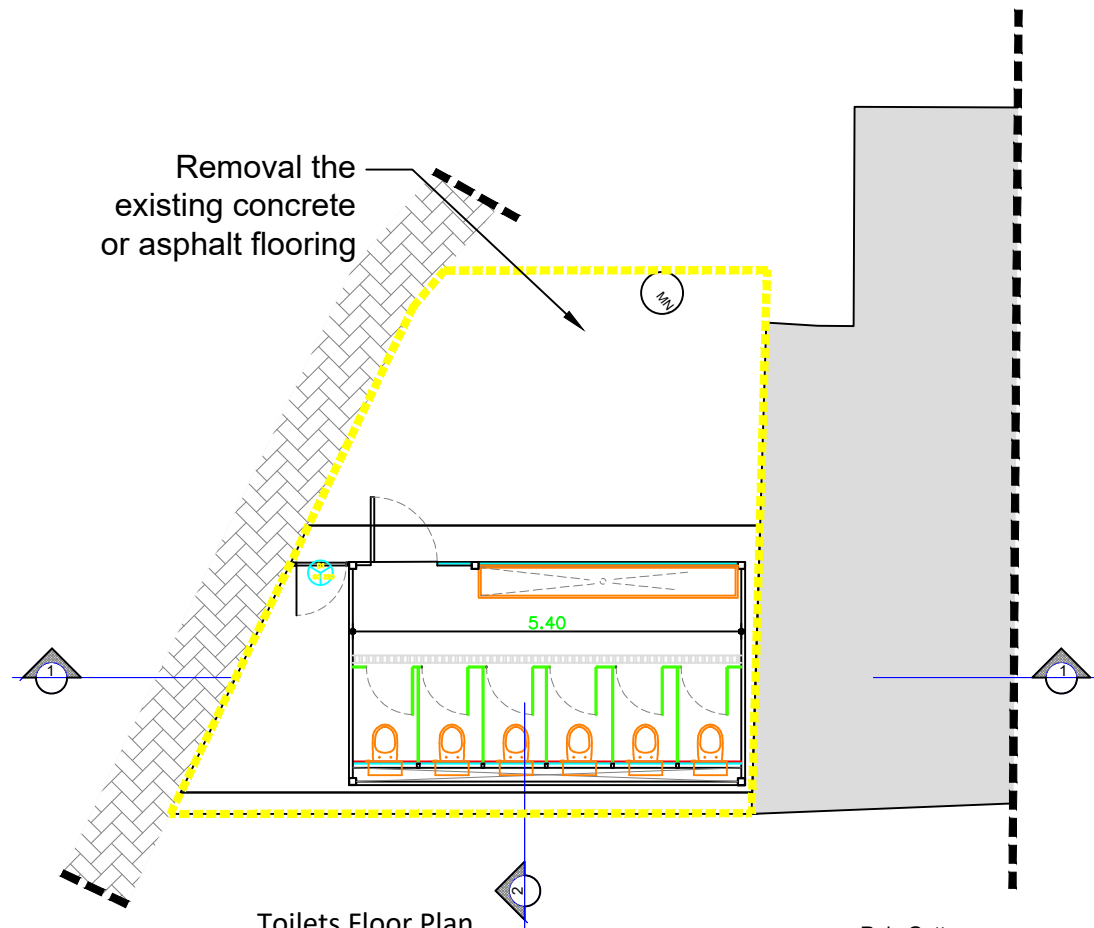

Toilets Floor Plan
Scale 1:100

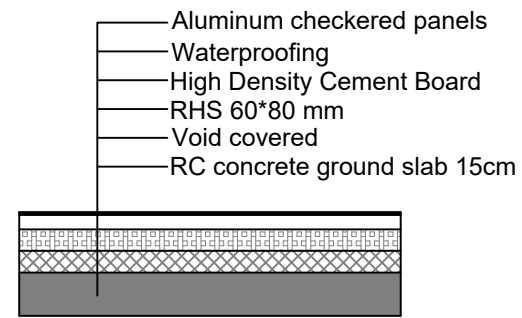

Toilets Floor main components




Cement Board



Aluminum Patterned Plate




Long Floor Drain

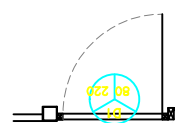


- 40 mm *40 mm*2mm Galvanized Steel Square Tubes
- Galvanized perforated panels—4 mm oil painted
- 40 mm *80 mm*2.6 mm Galvanized Steel Square Tubes
- External handle, lock, ironmongery, hardware, jack
- 4 cm space for safety by using hinge of 4.5 cm space
- 40 mm *40 mm*2mm Galvanized Steel Square Tubes
- Metal Plate 100*100*8mm


D1 Detail
Scale 1:50

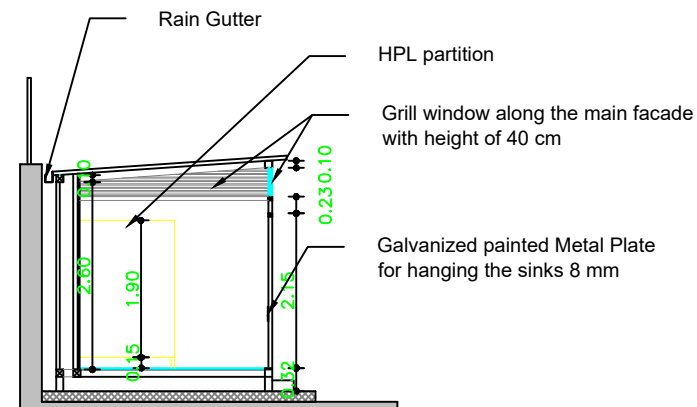


Section 2-2

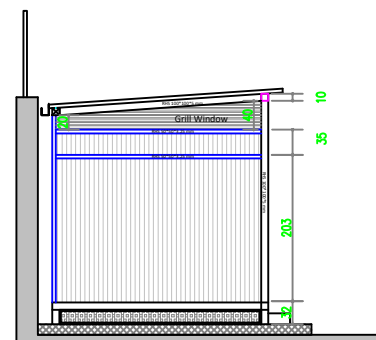

Side elevations

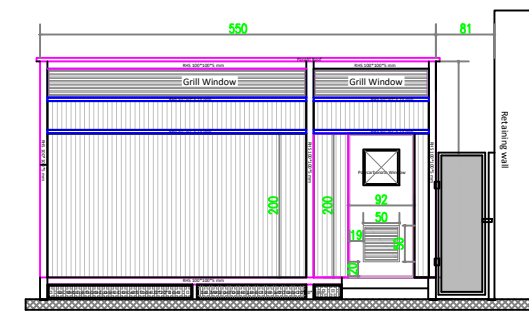

Main elevation

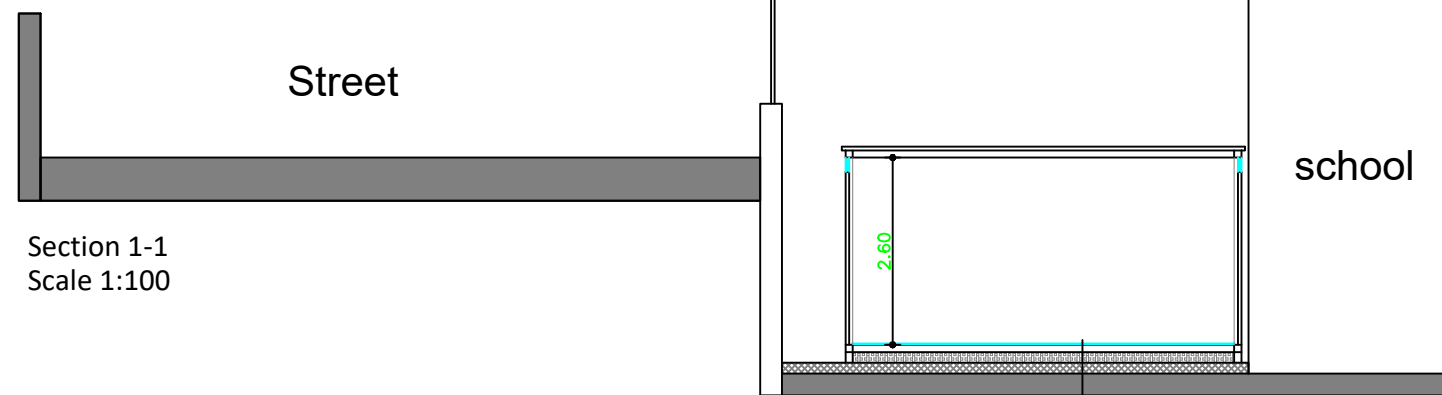


Section 1-1
Scale 1:100

- Aluminum checkered panels
- Waterproofing
- High Density Cement Board
- RHS 60*80 mm
- Void covered
- RC concrete ground slab 15cm

Notes

- (1) All Dimensions Are In M.
- (2) All Levels Are In Meter
- (3) Any Missing or Unclear Detail And All Fastening Systems For All Elements Shall be Approved by The Supervisor.

Legend:

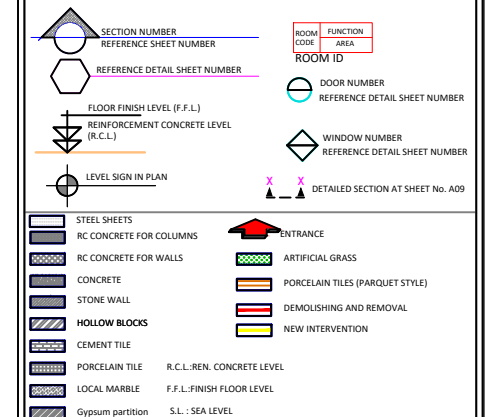

REVISIONS

NO.	DRAWINGS	DATE
(1)		
(2)		
(3)		

Contracting Authority:



Funded By:



“Public Works Contract for the rehabilitation
of 5 schools in East Jerusalem”

Reference number: PSE22001-10074

Lot 1: the rehabilitation of Al-Hasan
Al-Thany, Al-Shabbat Al-Shameleh, and
Al-Fata Al-Lajji'a schools in Wadi Al-Joz










Hasan Al Thani school

Designed by:



Jerusalem - Sheikh Jarrah- Tobler8
email: mr.wasimhija@gmail.com
Tel. 02-9948344/ 052-8327076
Fax: 02-9948344


Drawing Title	Caravan Detail	Date: 25/3/2025 Scale: 1:100
Designed by:	Arch. Hiba Al Ayoubi	Drawing No:
Checked by:	Arch. Wasim Abu El-Hija	A09
Approved by:		
Coordinate Manager:		

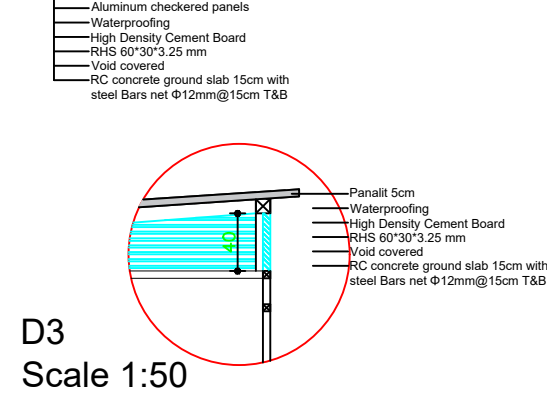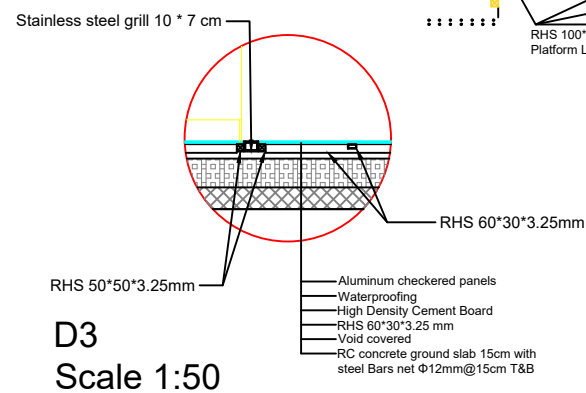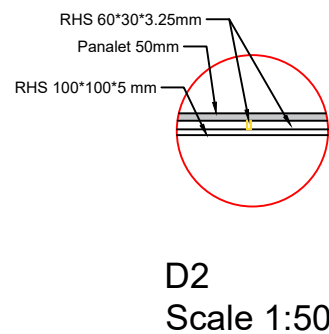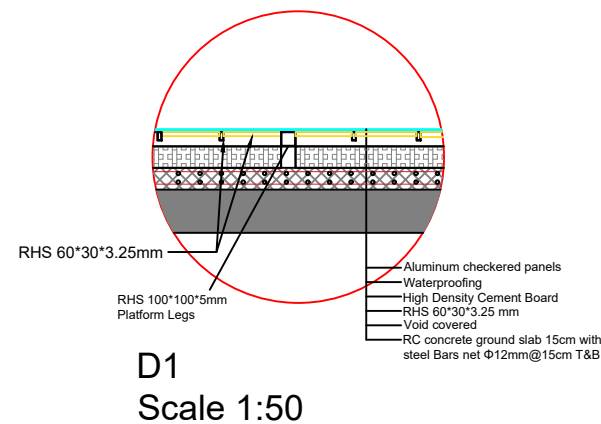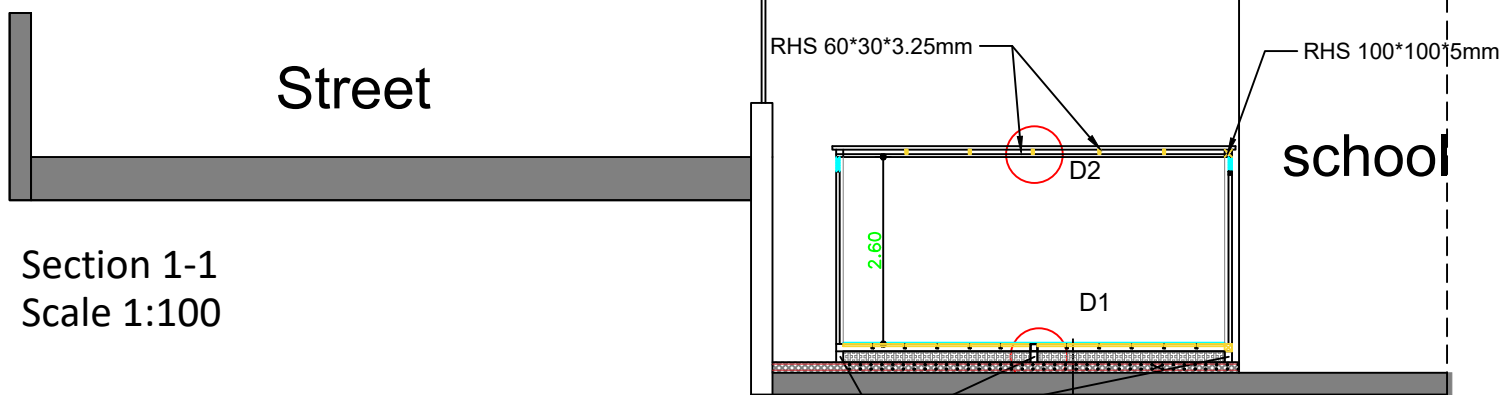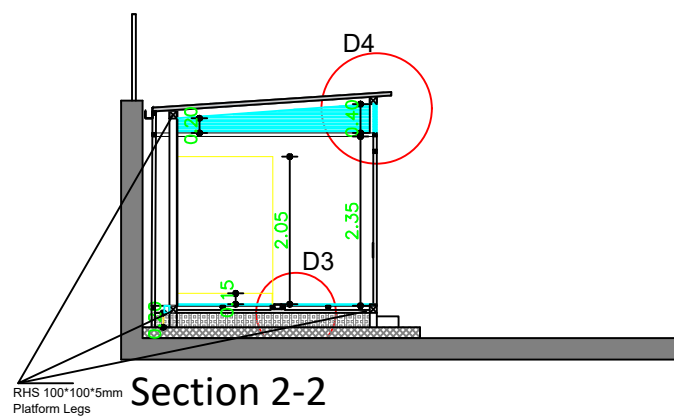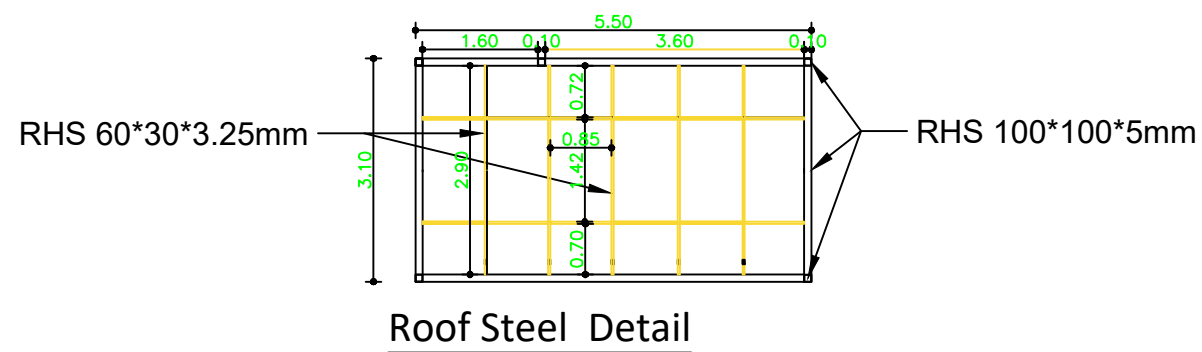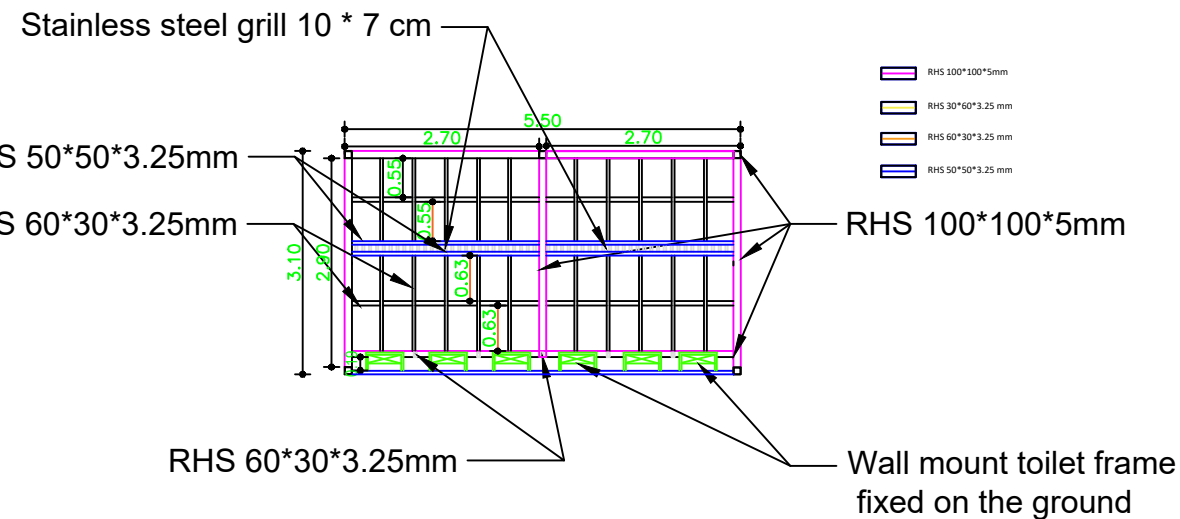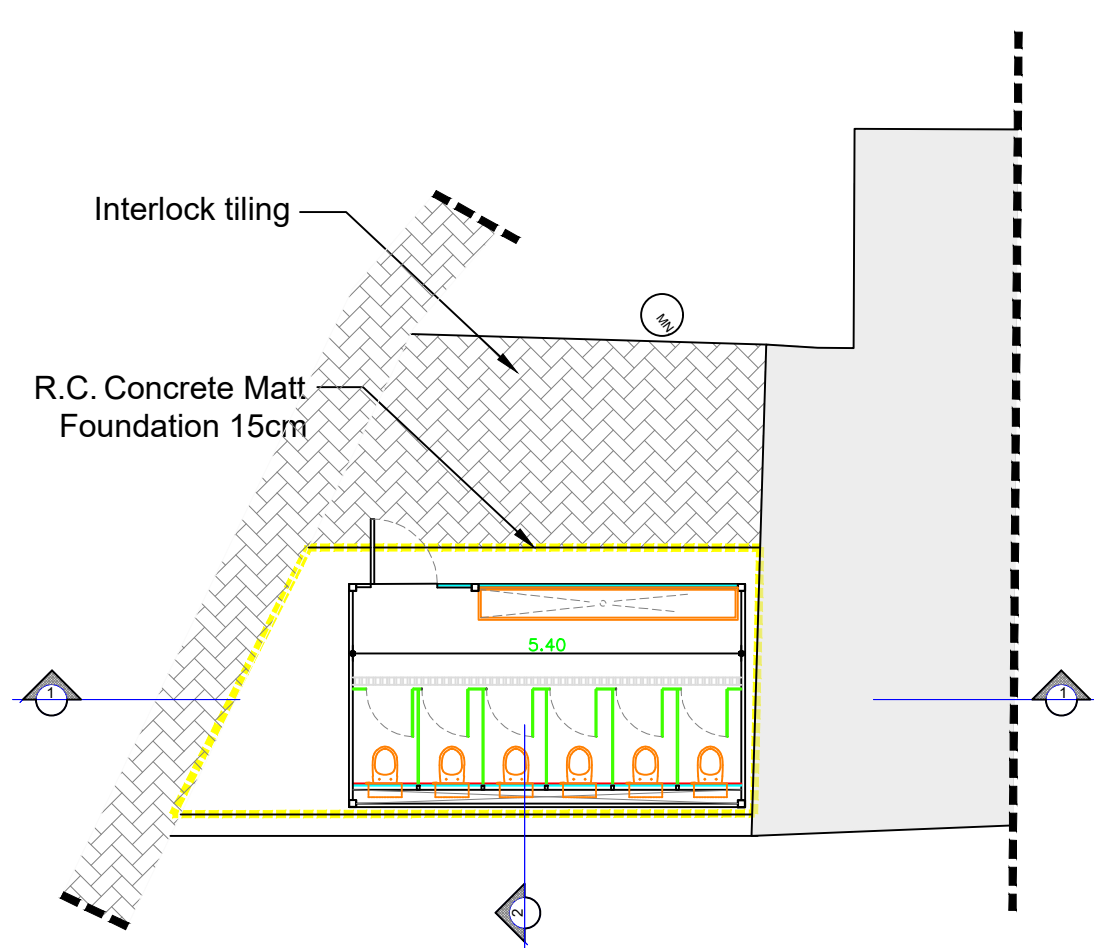

Notes

- (1) All Dimensions Are In M.
- (2) All Levels Are In Meter
- (3) Any Missing or Unclear Detail And All Fastening Systems For All Elements Shall be Approved by The Supervisor.

Legend:

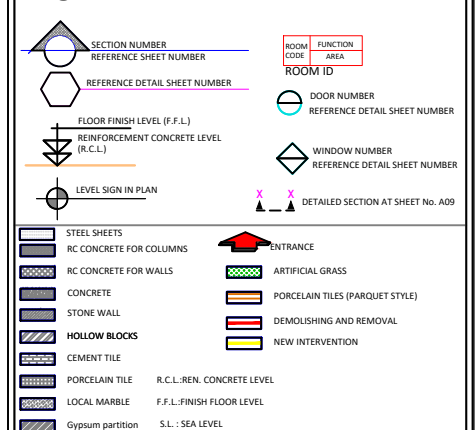

REVISIONS

NO.	DRAWINGS	DATE
(1)		
(2)		
(3)		

Contracting Authority:



Funded By:



"Public Works Contract for the rehabilitation of 5 schools in East Jerusalem"

Reference number: PSE22001-10074

Lot 1: the rehabilitation of Al-Hasan Al-Thany, Al-Shabbat Al-Shameleh, and Al-Fata Al-Laji'a schools in Wadi Al-Joz

Hasan Al Thani school


Designed by:



Jerusalem - Sheikh Jarrah- Tobler8
email: mr.wasimhija@gmail.com

Tel. 02-9948344/ 052-8327076
Fax: 02-9948344


Drawing Title	Scope of Intervention	Date: 25/3/2025
Designed by:	Eng. Saba Ameereh	Scale: 1:100
Checked by:	Arch. Wasim Abu El-Hija	Drawing No: S01
Approved by:		
Coordinate Manager:		

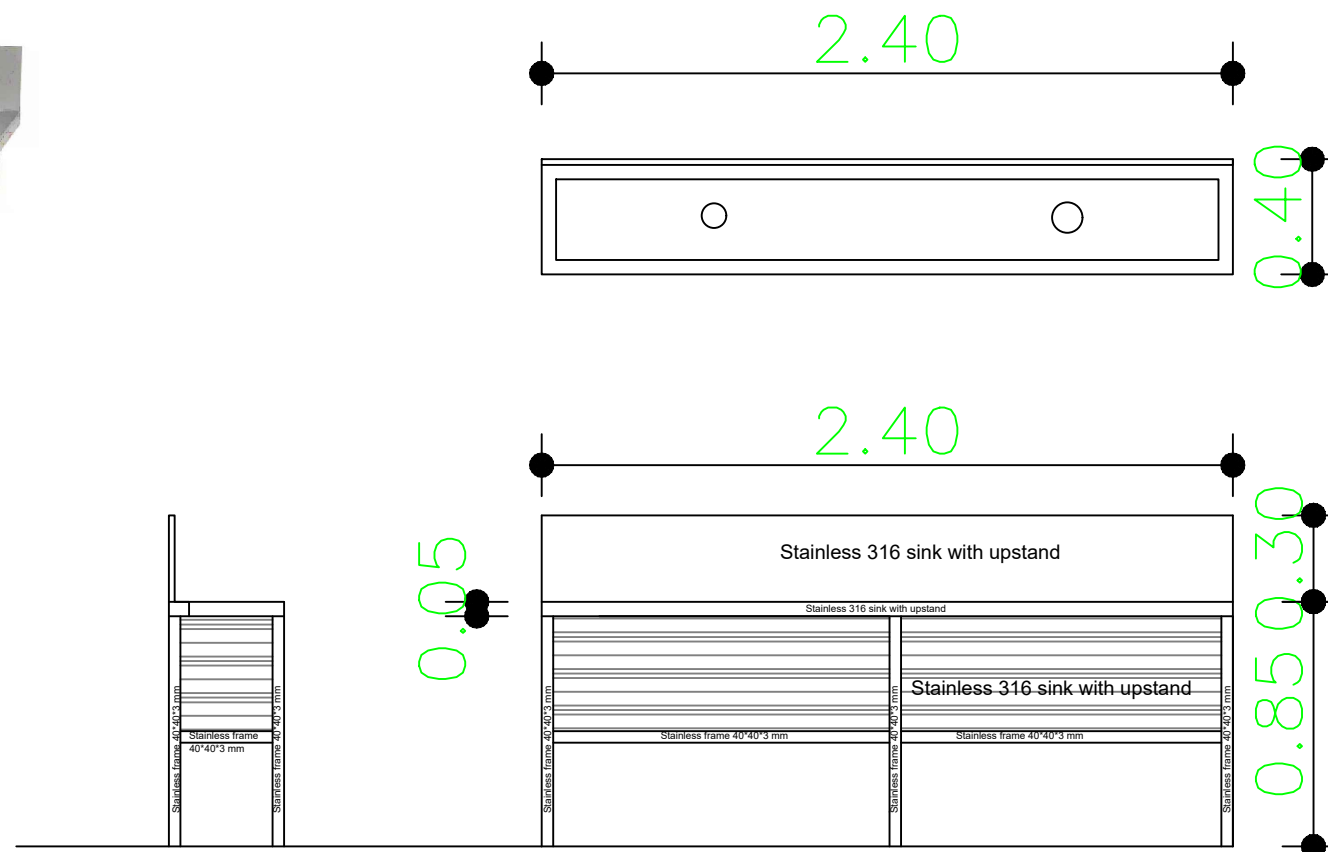

Notes

- (1) All Dimensions Are In M.
- (2) All Levels Are In Meter
- (3) Any Missing or Unclear Detail And All Fastening Systems For All Elements Shall be Approved by The Supervisor.

Legend:

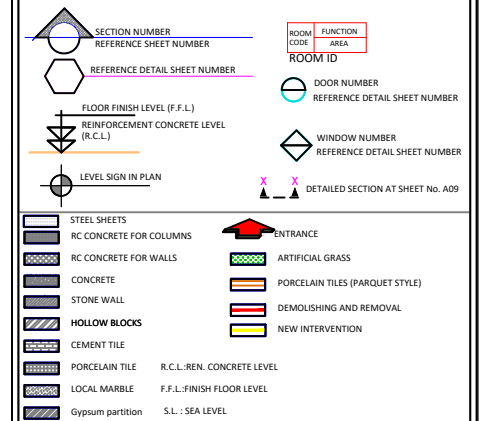

REVISIONS

NO.	DRAWINGS	DATE
(1)		
(2)		
(3)		

Contracting Authority:



Funded By:



“Public Works Contract for the rehabilitation of 5 schools in East Jerusalem”

Reference number: PSE22001-10074

Lot 1: the rehabilitation of Al-Hasan Al-Thany, Al-Shabbat Al-Shameleh, and Al-Fata Al-Laji’a schools in Wadi Al-Joz


Hasan Al Thani school

Designed by:




Jerusalem - Sheikh Jarrah- Tobler8
email: mr.wasimhija@gmail.com
Tel. 02-9948344/ 052-8327076
Fax: 02-9948344

Drawing Title	Caravan Detail	Date: 25/3/2025 Scale: 1:100
Designed by:	Arch. Hiba Al Ayoubi	Drawing No:
Checked by:	Arch. Wasim Abu El-Hija	A10
Approved by:		
Coordinate Manager:		

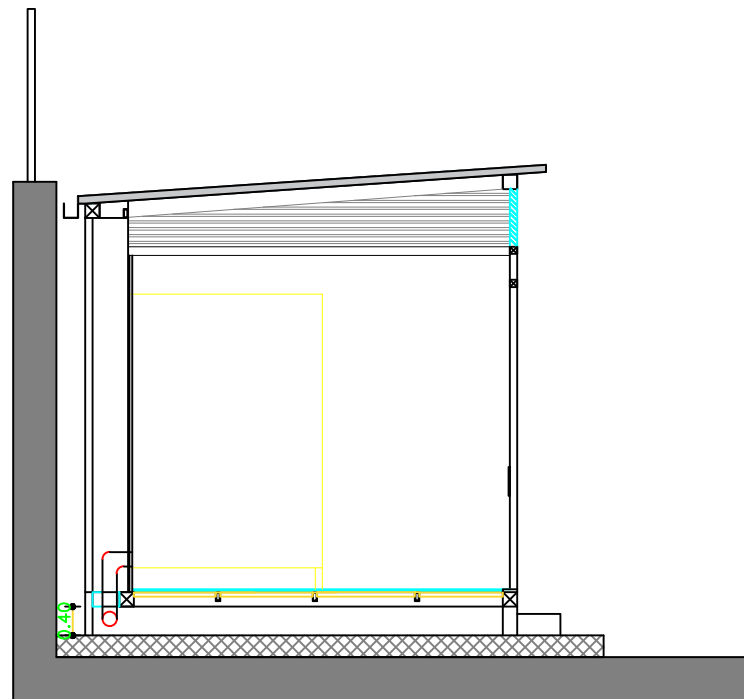

Section 2-2

Replacing the existing manhole

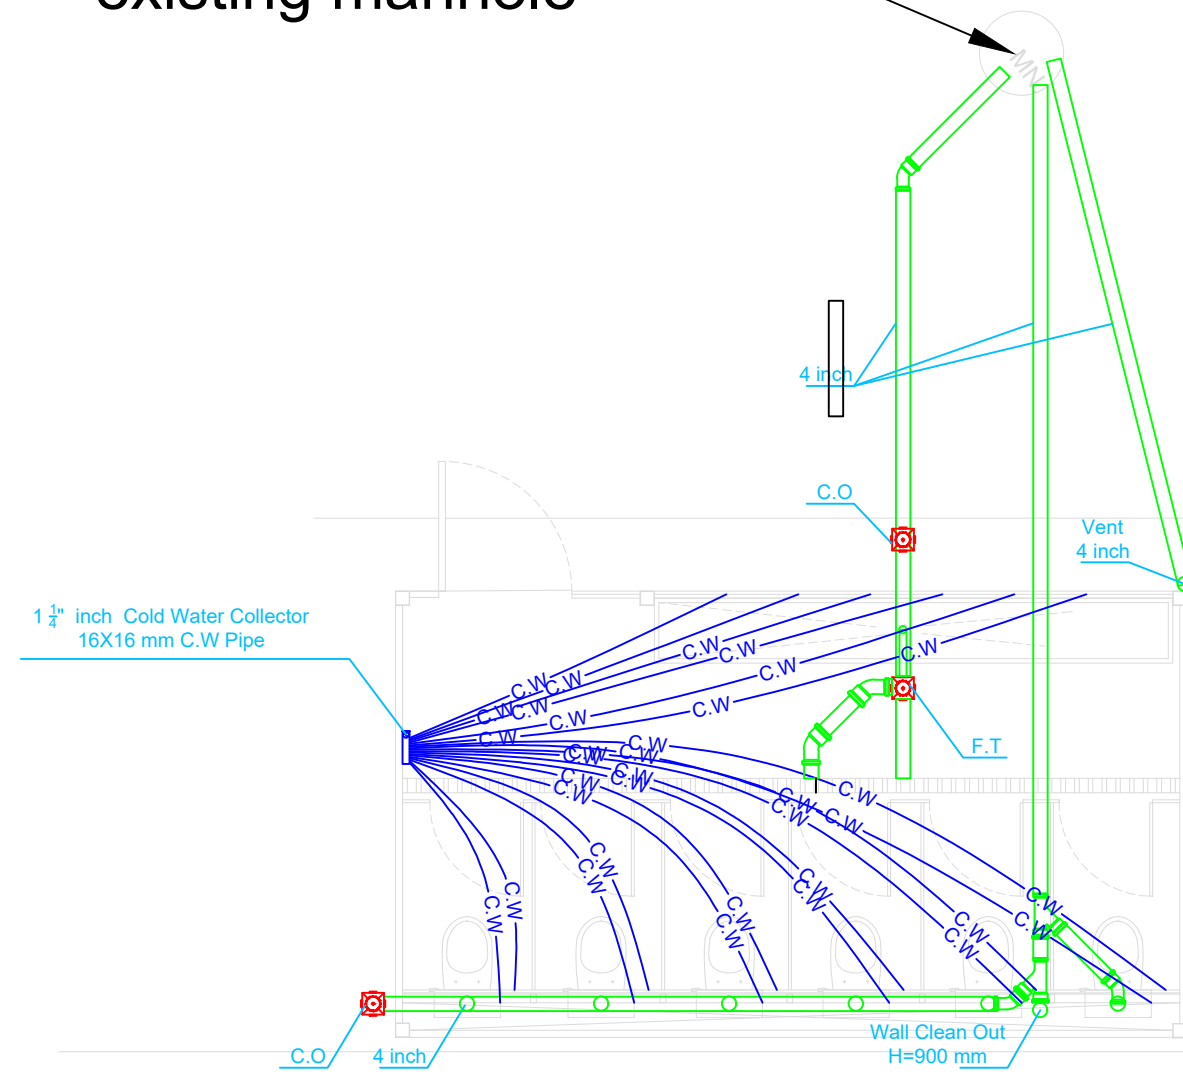

- (1) All Dimensions Are In M.
- (2) All Levels Are In Meter
- (3) Any Missing or Unclear Detail And All Fastening Systems For All Elements Shall be Approved by The Supervisor.

SECTION NUMBER
REFERENCE SHEET NUMBER

REFERENCE DETAIL SHEET NUMBER

FLOOR FINISH LEVEL (F.F.L.)
REINFORCEMENT CONCRETE LEVEL (R.C.L.)

LEVEL SIGN IN PLAN

ROOM CODE **FUNCTION AREA**

ROOM ID

DOOR NUMBER
REFERENCE DETAIL SHEET NUMBER

WINDOW NUMBER
REFERENCE DETAIL SHEET NUMBER

X X
DETAILED SECTION AT SHEET No. A09

STEEL SHEETS

RC CONCRETE FOR COLUMNS

RC CONCRETE FOR WALLS

CONCRETE

STONE WALL

HOLLOW BLOCKS

CEMENT TILE

PORCELAIN TILE R.C.L.-REN. CONCRETE LEVEL

LOCAL MARBLE F.F.L.-FINISH FLOOR LEVEL

Gypsum partition S.L.: SEA LEVEL

ENTRANCE

ARTIFICIAL GRASS

PORCELAIN TILES (PARQUET STYLE)

DEMOLISHING AND REMOVAL

NEW INTERVENTION

NO.	DRAWINGS	DATE
(1)		
(2)		
(3)		

Enabel 




Hasan Al Thani school




HOSH STUDIO
ARCHITECTURE & TOWN PLANNING

Jerusalem - Sheikh Jarrah- Tobler8
email: mr.wasimhija@gmail.com

Drawing Title	Mechanical works		Date: 25/3/2025
			Scale: 1:50
	Designed by:	Arch. Hiba Al Ayoubi	Drawing No:
	Checked by:	Arch. Wasim Abu El-Hija	M02
	Approved by:		
Coordinate Manager:			

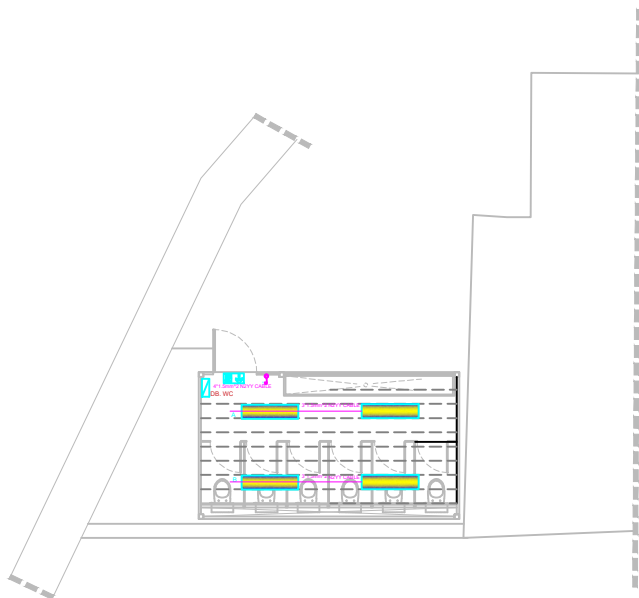

Lighting System

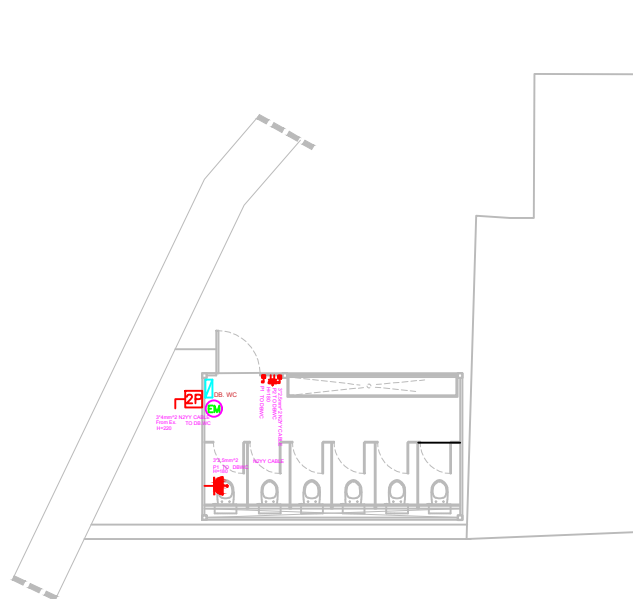

Power System

Notes

- (1) All Dimensions Are In M.
- (2) All Levels Are In Meter
- (3) Any Missing or Unclear Detail And All Fastening Systems For All Elements Shall be Approved by The Supervisor.

Legend:

REVISIONS		
NO.	DRAWINGS	DATE
(1)		
(2)		
(3)		

Contracting Authority:



Funded By:



"Public Works Contract for the rehabilitation of 5 schools in East Jerusalem"

Reference number: PSE22001-10074

Lot 1: the rehabilitation of Al-Hasan Al-Thany, Al-Shabbat Al-Shameleh, and Al-Fata Al-Laji'a schools in Wadi Al-Joz

Hasan Al Thani school


Designed by:



Jerusalem - Sheikh Jarrah - Tolleris
email: mr.wasimhija@gmail.com

Tel: 02-9948344/ 052-8327076
Fax: 02-9948344

Drawing Title	Electrical Plans	Date
Designed by:	Eng. Adli Naser Al-Deen	25/3/2025
Checked by:	Eng. Adli Naser Al-Deen	Scale: 1:100
Approved by:		Drawing No: E01
Coordinate Manager:		

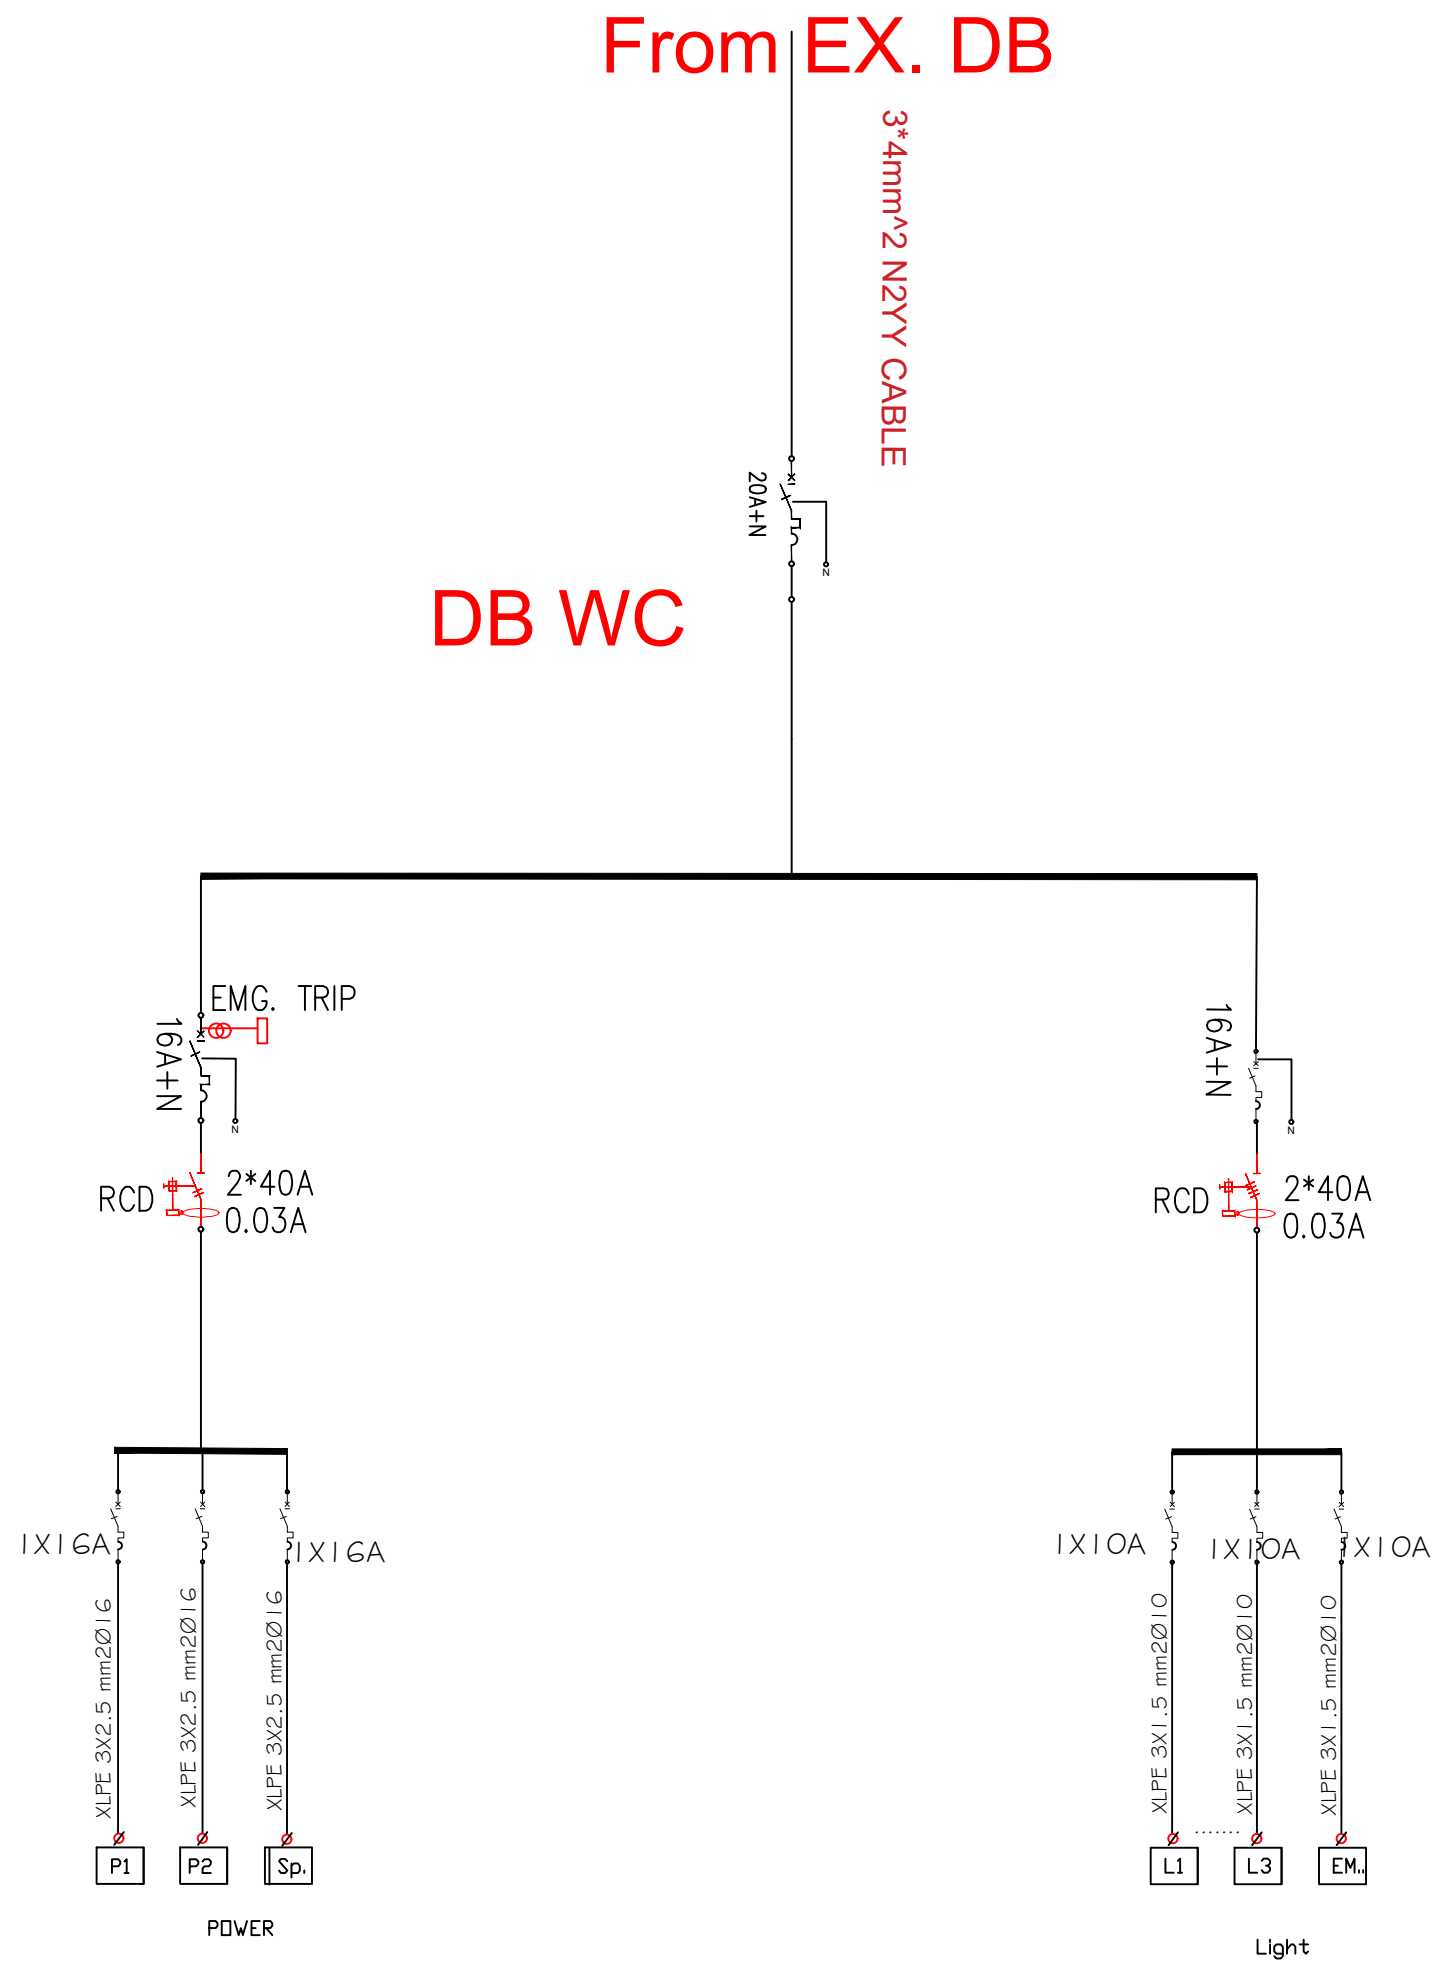

Notes

- (1) All Dimensions Are In M.
- (2) All Levels Are In Meter
- (3) Any Missing or Unclear Detail And All Fastening Systems For All Elements Shall be Approved by The Supervisor.

Legend:

REVISIONS		
NO.	DRAWINGS	DATE
(1)		
(2)		
(3)		

Contracting Authority:



Funded By:



“Public Works Contract for the rehabilitation of 5 schools in East Jerusalem”

Reference number: PSE22001-10074

Lot 1: the rehabilitation of Al-Hasan Al-Thany, Al-Shabbat Al-Shameleh, and Al-Fata Al-Laji'a schools in Wadi Al-Joz

Hasan Al Thani school

Designed by:



Jerusalem - Sheikh Jarrah- Tobler8
email: mr.wasimhija@gmail.com

Tel. 02-9948344/ 052-8327076
Fax: 02-9948344

Drawing Title	Electrical Distribution Board	Date: 25/3/2025 Scale: 1:100
Designed by:	Eng. Adli Naser Al-Deen	Drawing No:
Checked by:	Eng. Adli Naser Al-Deen	E02
Approved by:		
Coordinate Manager:		

Lot1C : Al-Fata Al-Laji'a A Secondary Girls' School

ARCHITECTURAL DRAWINGS			
#	SHETT #	SHEET TITLE	SCALE
01	A00	LIST OF DRAWINGS & NOTES ABBREVIATION & SYMBOLS	—
02	A10	Scope of Intervention on site level	1:200
03	A11	Scope of Intervention in Building 1&2	1:100
04	A12	Scope of Intervention in Building 3	1:100
05	A13	Pergola Design	1:100
Structural DRAWINGS			
01	S02	Pergola Structural Details	1:100

Notes

(1) All Dimensions Are In M.
(2) All Levels Are In Meter
(3) Any Missing or Unclear Detail And All Fastening Systems For All Elements Shall be Approved by The Supervisor.

Legend:

SECTION NUMBER

REFERENCE SHEET NUMBER

ROOM CODE

AREA

ROOM ID

FLOOR FINISH LEVEL (F.F.L.)

REINFORCEMENT CONCRETE LEVEL (R.C.L.)

LEVEL SIGN IN PLAN

DETAILED SECTION AT SHEET No. A09

STEEL SHEETS

RC CONCRETE FOR COLUMNS

RC CONCRETE FOR WALLS

CONCRETE

STONE WALL

HOLLOW BLOCKS

CEMENT TILE

PORCELAIN TILE

LOCAL MARBLE

Gypsum partition

ENTRANCE

WPC

R.C.L.:REN. CONCRETE LEVEL

F.F.L.:FINISH FLOOR LEVEL

S.L. : SEA LEVEL

REVISIONS

NO.	DRAWINGS	DATE
(1)		
(2)		
(3)		

Contracting Authority:

Enabel

Funded By:

Belgium

partner in development

Project Title:

“Public Works Contract for the rehabilitation of 5 schools in East Jerusalem”

Reference number: PSE22001-10074

Lot 1: the rehabilitation of Al-Hasan Al-Thany, Al-Shabbat Al-Shameleh, and Al-Fata Al-Laji’a schools in Wadi Al-Joz

Al-Fata Al-Laji'a A Secondary Girls' School

Designed by:

HOSH STUDIO

ARCHITECTURE & TOWN PLANNING


Jerusalem - Sheikh Jarrah- Tobler8

email: mr.wasimhija@gmail.com

Tel. 02-9948344/ 052-8327076

Fax: 02-9948344

Drawing Title	Scope of Intervention on site level	Date: 25/3/2025 Scale:
Designed by:	Arch. Hiba Al Ayoubi	Drawing No:
Checked by:	Arch. Wasim Abu El-Hija	A00
Approved by:		
Coordinate Manager:		

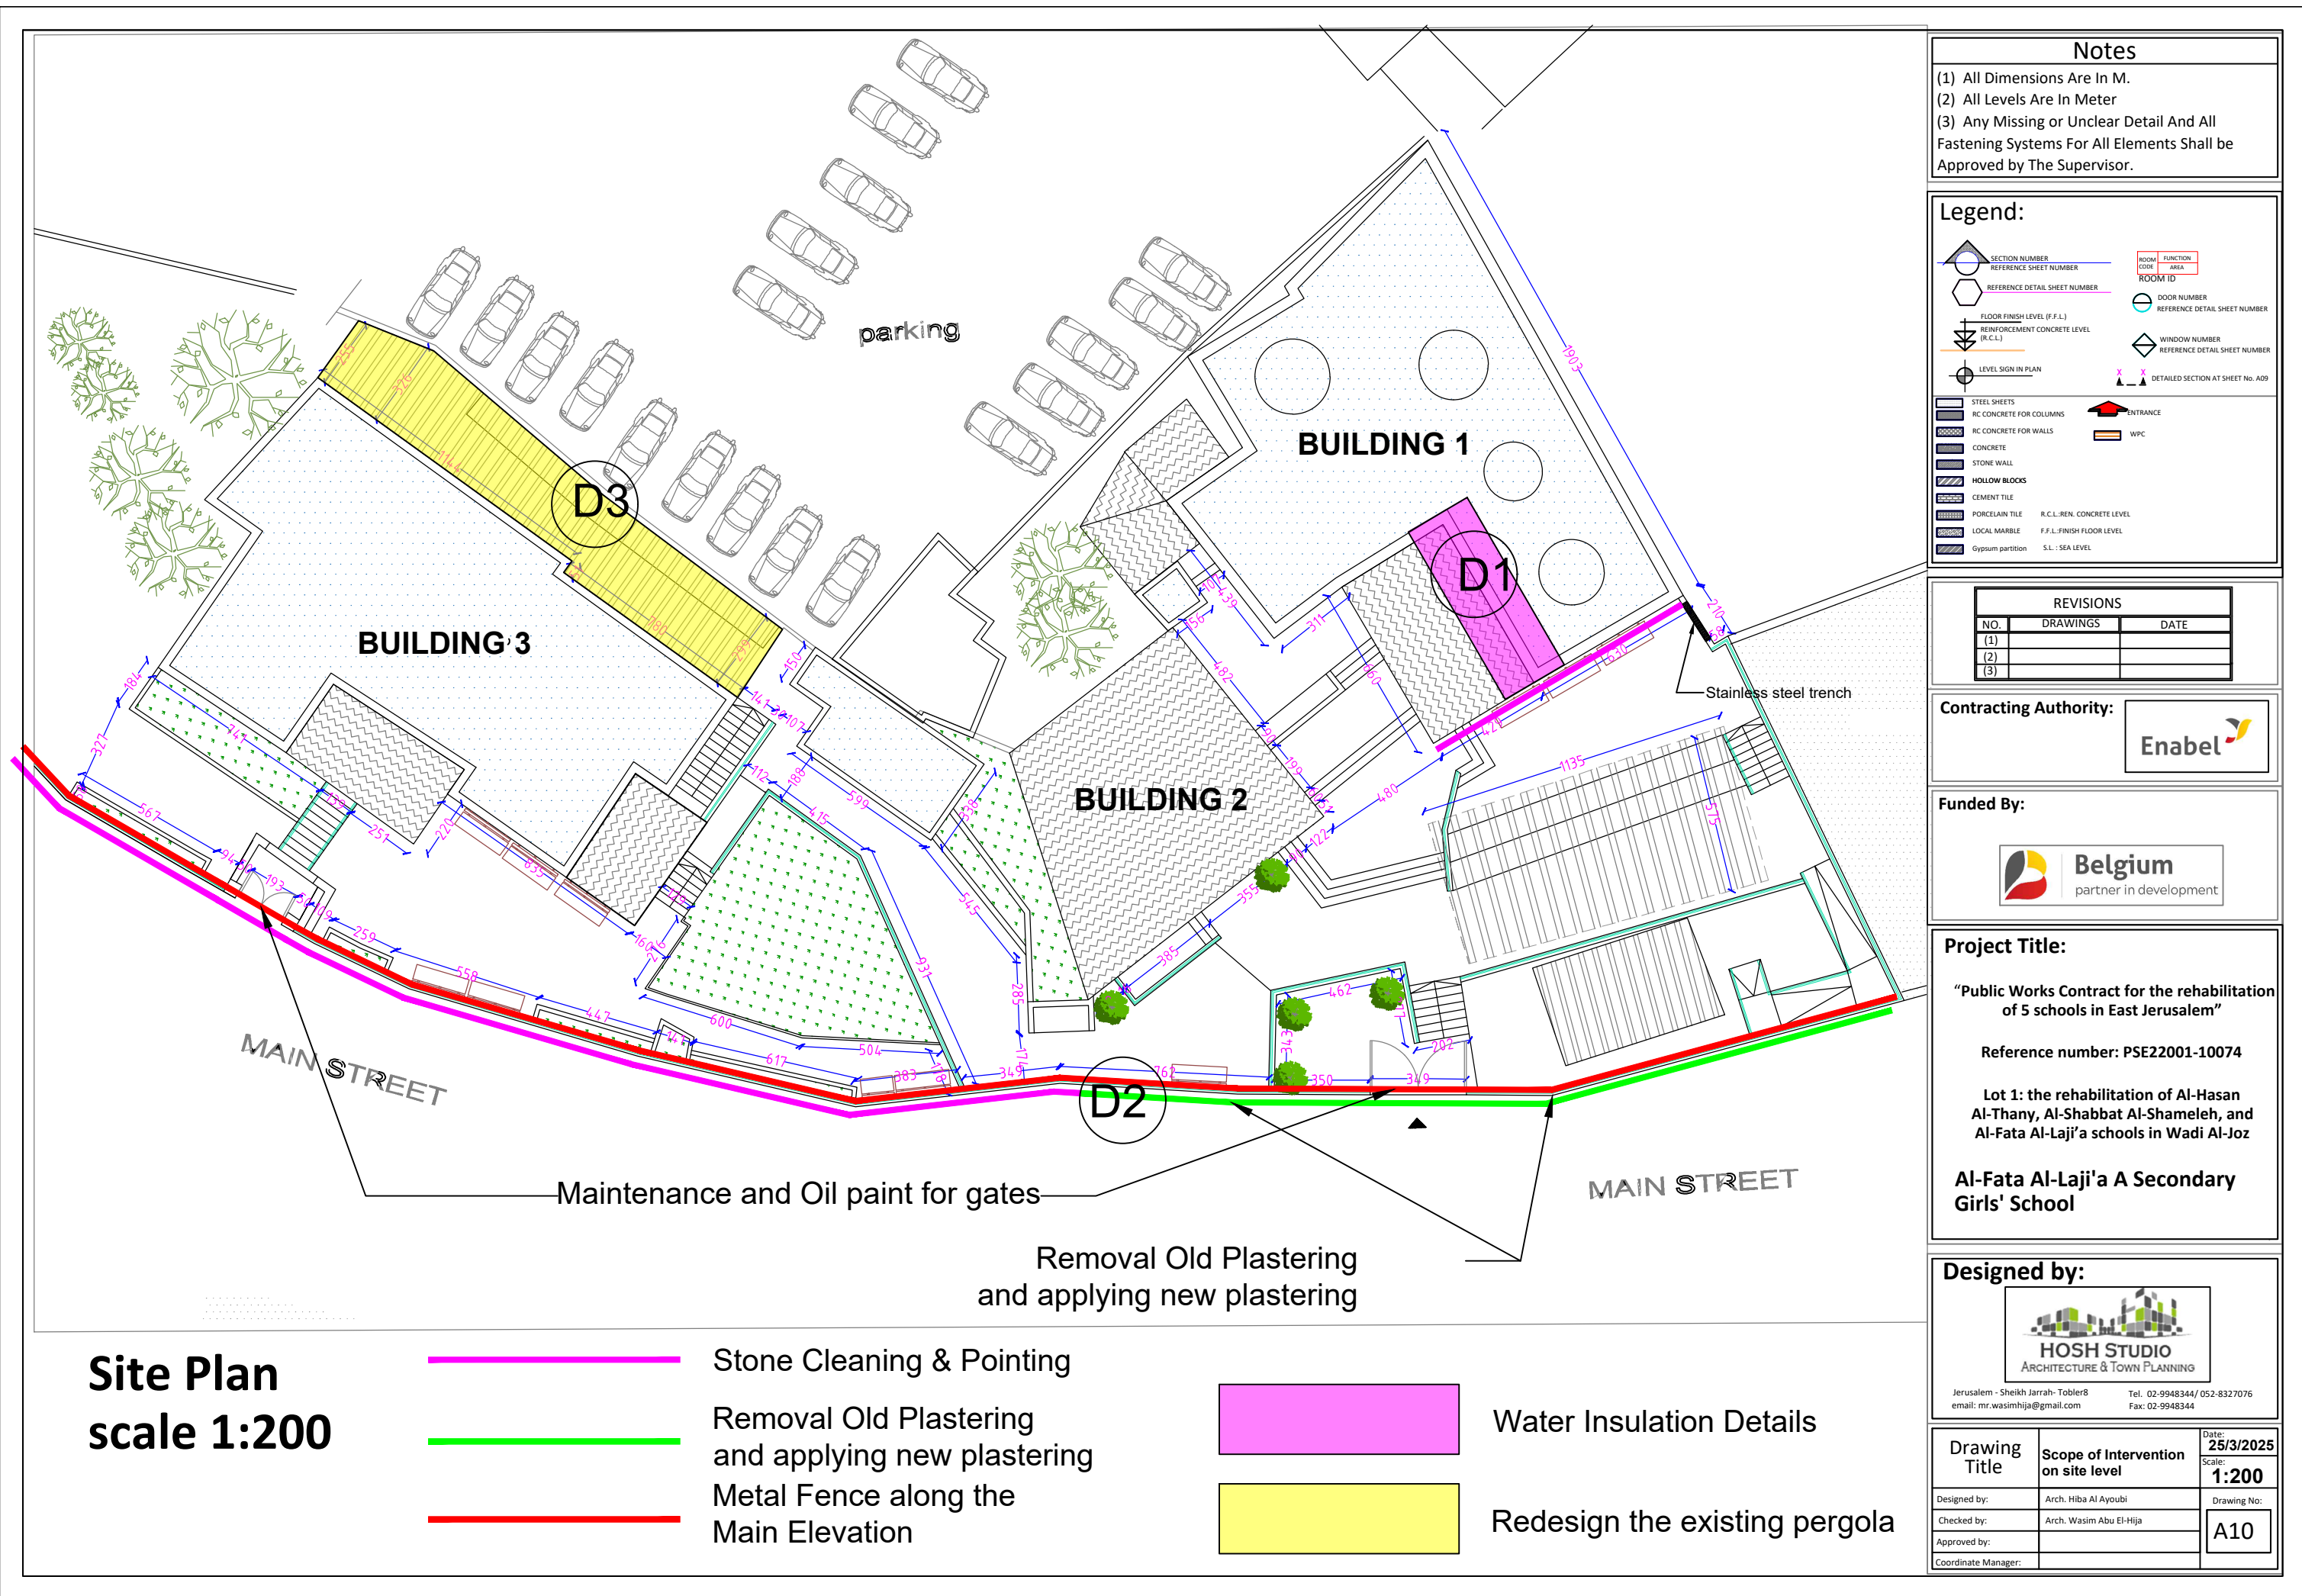

Rehabilitation works in Building 1:

- Electrical works
- Water insulation of the roof
- Plastering works for administration room and adjacent classroom
- Painting Works


Rehabilitation works in Building 2:

- Replacing Doors and fixing walls next to the doors
- Painting Works
- Removal of Existing doors and replacing with new wooden doors in building 2

Painting of Metal Doors



Fixing wall and painting of wooden doors

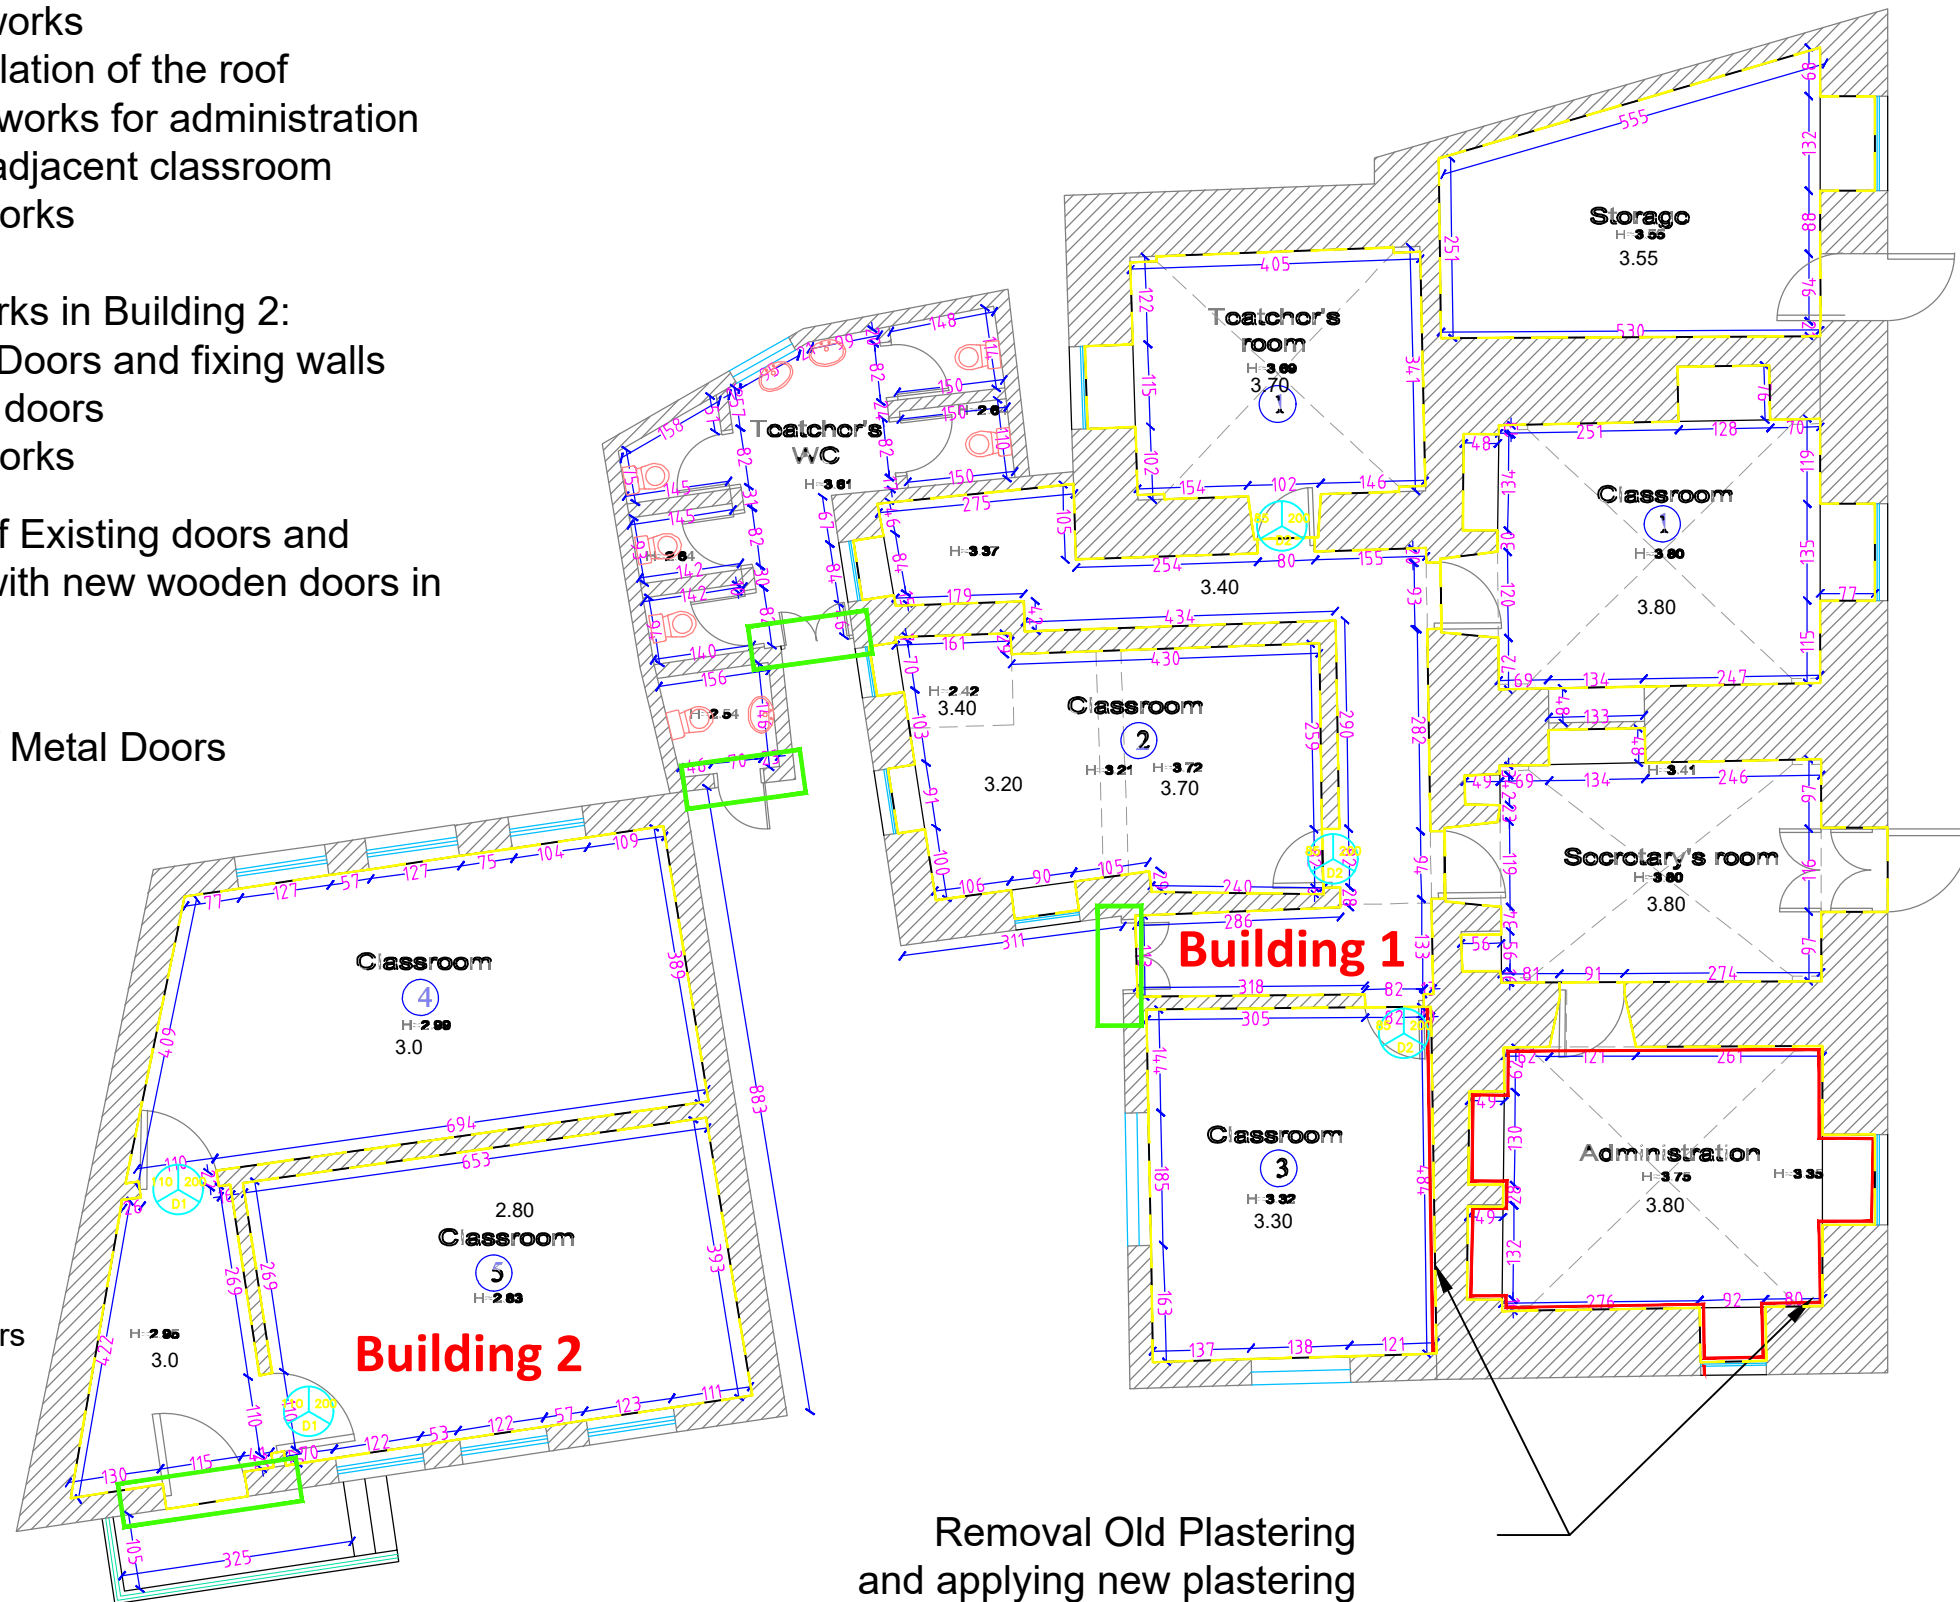

Removal Old Plastering and applying new plastering

Notes

- (1) All Dimensions Are In M.
- (2) All Levels Are In Meter
- (3) Any Missing or Unclear Detail And All Fastening Systems For All Elements Shall be Approved by The Supervisor.

Legend:

SECTION NUMBER
REFERENCE SHEET NUMBER

REFERENCE DETAIL SHEET NUMBER

FLOOR FINISH LEVEL (F.F.L.)
REINFORCEMENT CONCRETE LEVEL (R.C.L.)
LEVEL SIGN IN PLAN

ROOM CODE
FUNCTION
AREA
ROOM ID

DOOR NUMBER
REFERENCE DETAIL SHEET NUMBER

WINDOW NUMBER
REFERENCE DETAIL SHEET NUMBER

DETAILED SECTION AT SHEET No. A09

STEEL SHEETS
RC CONCRETE FOR COLUMNS
RC CONCRETE FOR WALLS
CONCRETE
STONE WALL
HOLLOW BLOCKS
CEMENT TILE
PORCELAIN TILE
LOCAL MARBLE
Gypsum partition

ENTRANCE
ARTIFICIAL GRASS
PORCELAIN TILES (PARQUET STYLE)
DEMOLISHING AND REMOVAL
NEW INTERVENTION

R.C.L.: REN. CONCRETE LEVEL
F.F.L.: FINISH FLOOR LEVEL
S.L.: SEA LEVEL

REVISIONS

NO.	DRAWINGS	DATE
(1)		
(2)		
(3)		

Contracting Authority:



Funded By:



Project Title:

"Public Works Contract for the rehabilitation of 5 schools in East Jerusalem"

Reference number: PSE22001-10074

Lot 1: the rehabilitation of Al-Hasan Al-Thany, Al-Shabbat Al-Shameleh, and Al-Fata Al-Laji'a schools in Wadi Al-Joz

Al-Fata Al-Laji'a A Secondary Girls' School

Designed by:




Jerusalem - Sheikh Jarrah- Tobler8
email: mr.wasimhija@gmail.com

Tel. 02-9948344/ 052-8327076
Fax: 02-9948344

Drawing Title	Scope of Intervention in Building 1&2	Date: 25/3/2025 Scale: 1:100
Designed by:	Arch. Hiba Al Ayoubi	Drawing No:
Checked by:	Arch. Wasim Abu El-Hija	A11
Approved by:		
Coordinate Manager:		

Ground Floor Plan- scale 1:100

Removal Old Plastering
and applying new colored plastering

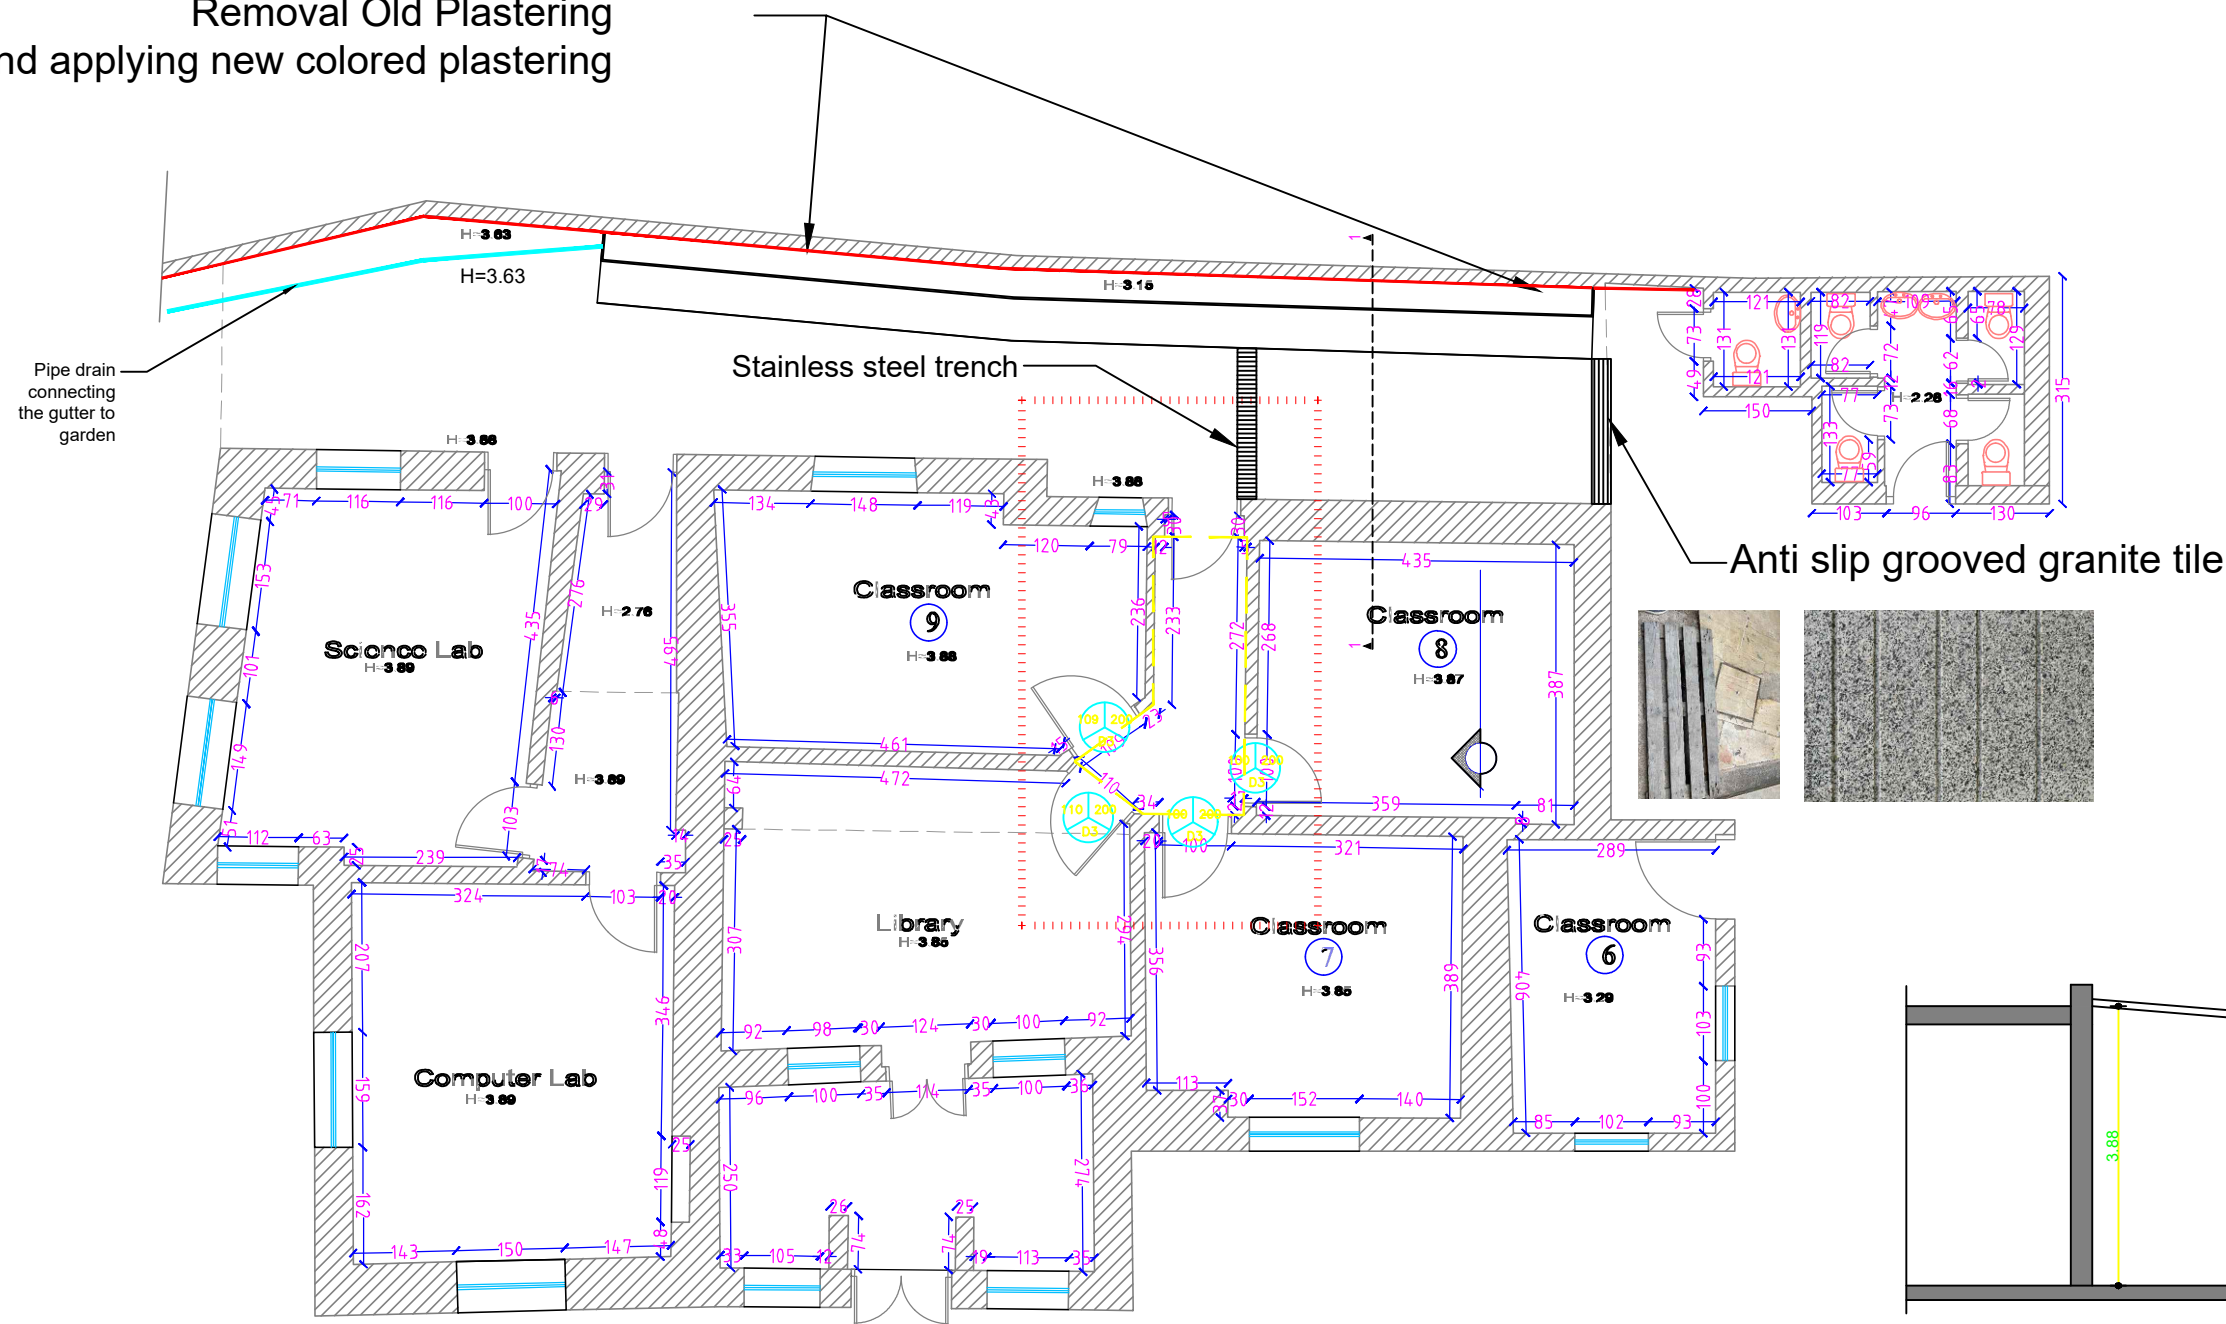

Ground Floor Plan- scale 1:100
Building 3

- Rehabilitation works in Building 3:
-  - Replacing Doors and fixing walls next to the doors in building 3
 -  - Painting Works
 -  - Removal Old Plastering and applying new colored plastering

Notes

- (1) All Dimensions Are In M.
- (2) All Levels Are In Meter
- (3) Any Missing or Unclear Detail And All Fastening Systems For All Elements Shall be Approved by The Supervisor.

Legend:

 SECTION NUMBER
REFERENCE SHEET NUMBER

 REFERENCE DETAIL SHEET NUMBER

 FLOOR FINISH LEVEL (F.F.L.)
REINFORCEMENT CONCRETE LEVEL (R.C.L.)

 LEVEL SIGN IN PLAN

 ROOM CODE
FUNCTION
AREA
ROOM ID

 DOOR NUMBER
REFERENCE DETAIL SHEET NUMBER

 WINDOW NUMBER
REFERENCE DETAIL SHEET NUMBER

 ENTRANCE

 STEEL SHEETS

 RC CONCRETE FOR COLUMNS

 RC CONCRETE FOR WALLS

 CONCRETE

 STONE WALL

 HOLLOW BLOCKS

 CEMENT TILE

 PORCELAIN TILE

 LOCAL MARBLE

 Gypsum partition

 ARTIFICIAL GRASS

 PORCELAIN TILES (PARQUET STYLE)

 DEMOLISHING AND REMOVAL

 NEW INTERVENTION

 R.C.L.:REN. CONCRETE LEVEL

 F.F.L.:FINISH FLOOR LEVEL

 S.L.: SEA LEVEL

REVISIONS		
NO.	DRAWINGS	DATE
(1)		
(2)		
(3)		

Contracting Authority:

Enabel

Funded By:

Belgium
partner in development

Project Title:

“Public Works Contract for the rehabilitation of 5 schools in East Jerusalem”

Reference number: PSE22001-10074

Lot 1: the rehabilitation of Al-Hasan Al-Thany, Al-Shabbat Al-Shameleh, and Al-Fata Al-Laji'a schools in Wadi Al-Joz

Al-Fata Al-Laji'a A Secondary Girls' School


Designed by:

HOSH STUDIO
ARCHITECTURE & TOWN PLANNING


Jerusalem - Sheikh Jarrah- Tobler8
email: mr.wasimhija@gmail.com

Tel. 02-9948344/ 052-8327076
Fax: 02-9948344


Drawing Title	Scope of Intervention in Building 3	Date: 25/3/2025 Scale: 1:100
Designed by:	Arch. Hiba Al Ayoubi	Drawing No:
Checked by:	Arch. Wasim Abu El-Hija	A12
Approved by:		
Coordinate Manager:		

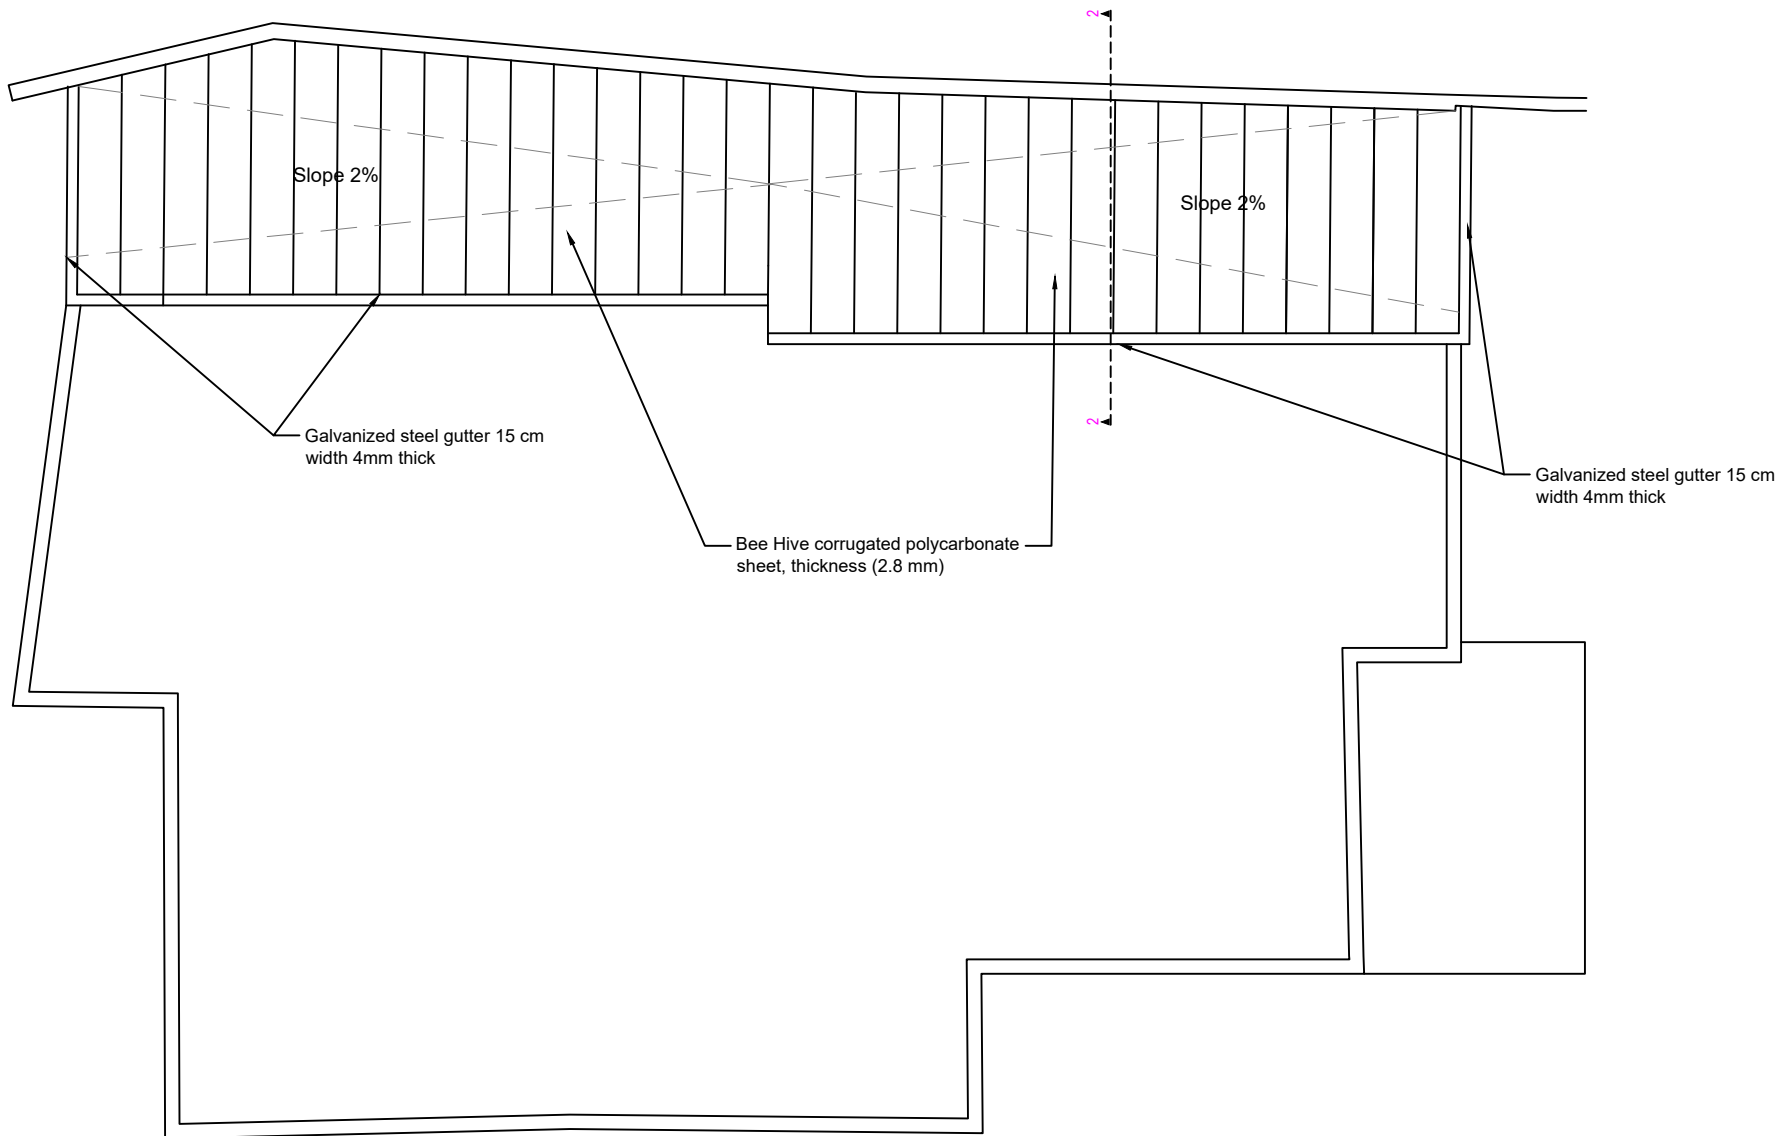


Ground Floor Plan- scale 1:100
Building 3

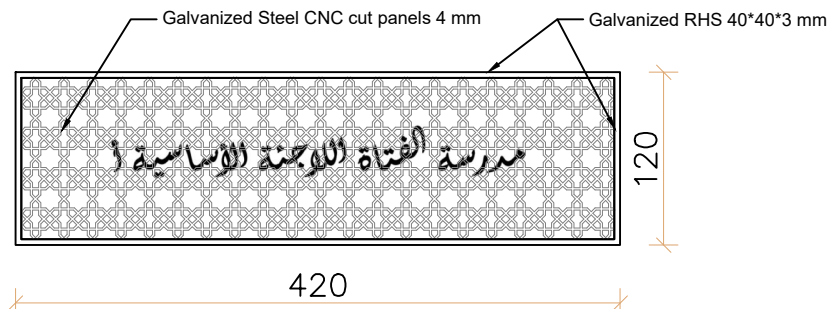

CNC Cut
Scale 1:50

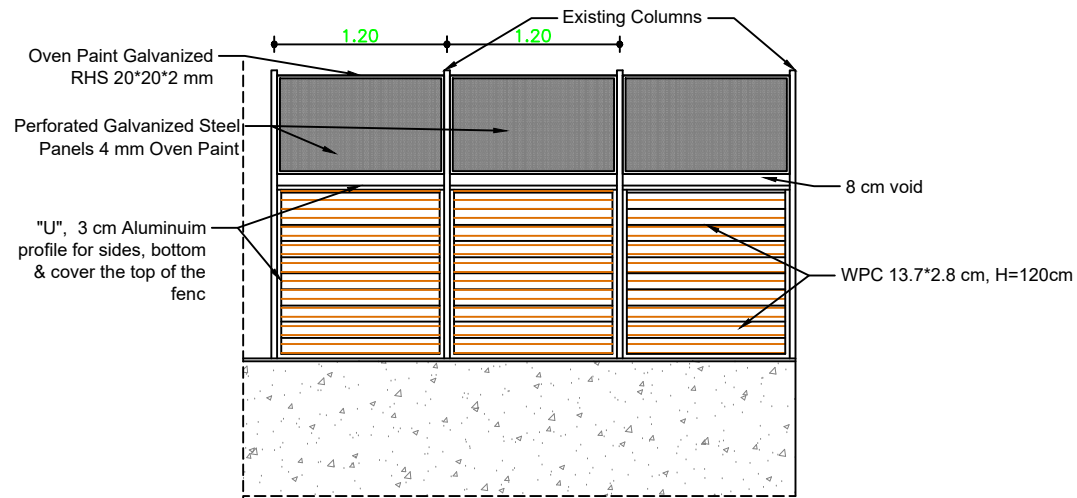

External Fence Detail
Scale 1:50

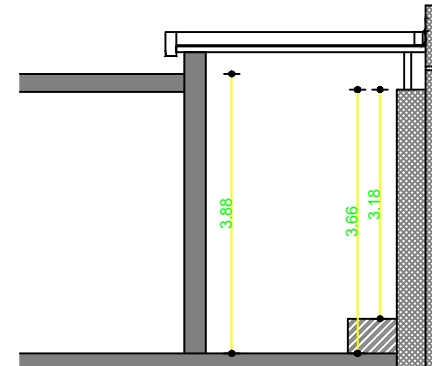


Section 1-1

Notes

- (1) All Dimensions Are In M.
- (2) All Levels Are In Meter
- (3) Any Missing or Unclear Detail And All Fastening Systems For All Elements Shall be Approved by The Supervisor.

Legend:

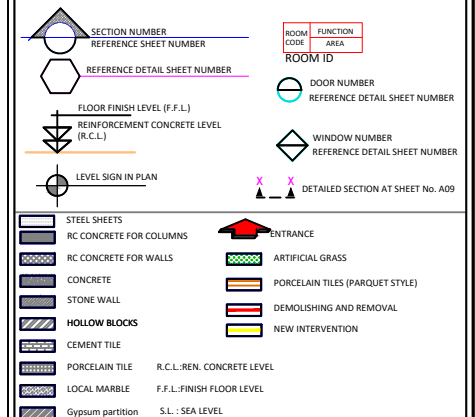

REVISIONS

NO.	DRAWINGS	DATE
(1)		
(2)		
(3)		

Contracting Authority:



Funded By:



Project Title:

“Public Works Contract for the rehabilitation of 5 schools in East Jerusalem”

Reference number: PSE22001-10074

Lot 1: the rehabilitation of Al-Hasan Al-Thany, Al-Shabbat Al-Shameleh, and Al-Fata Al-Laji'a schools in Wadi Al-Joz


Al-Fata Al-Laji'a A Secondary Girls' School

Designed by:




Jerusalem - Sheikh Jarrah- Tobler8
email: mr.wasimhija@gmail.com
Tel. 02-9948344/ 052-8327076
Fax: 02-9948344


Drawing Title	Pergola Design	Date: 25/3/2025 Scale: 1:100
Designed by:	Arch. Hiba Al Ayoubi	Drawing No:
Checked by:	Arch. Wasim Abu El-Hija	A13
Approved by:		
Coordinate Manager:		

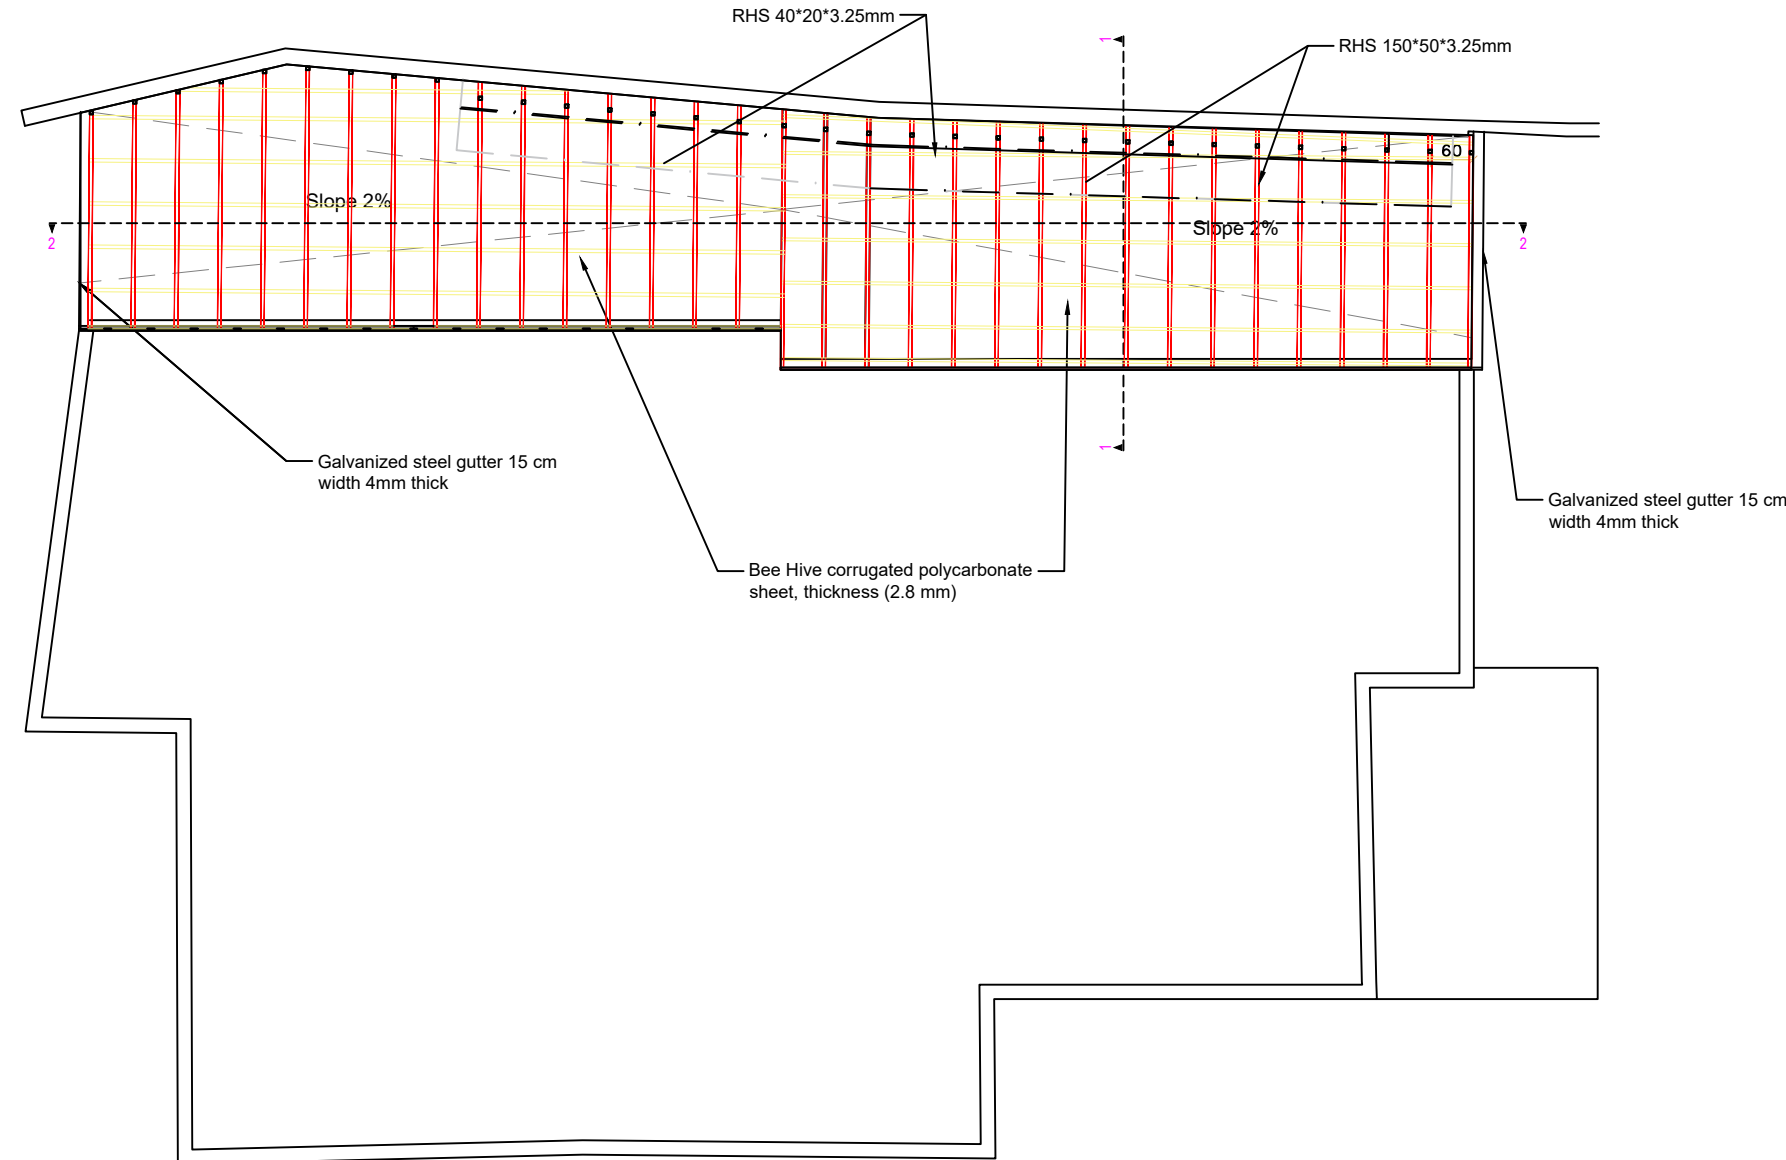


Ground Floor Plan- scale 1:100
Building 3

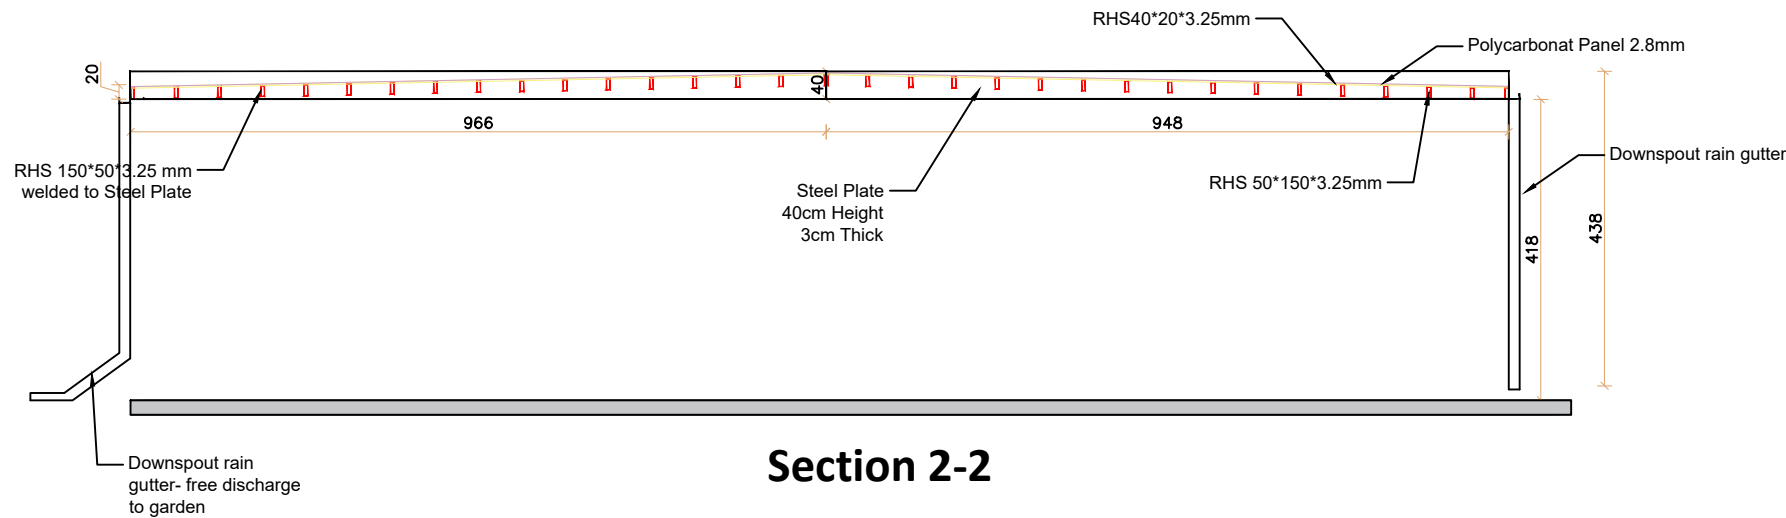

Section 2-2

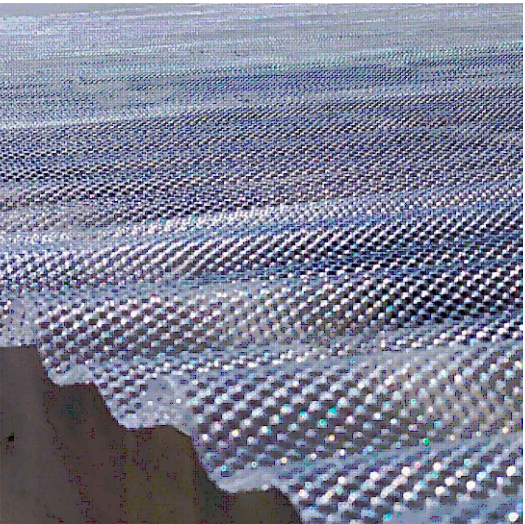

Bee Hive corrugated polycarbonate sheet, thickness (2.8 mm)

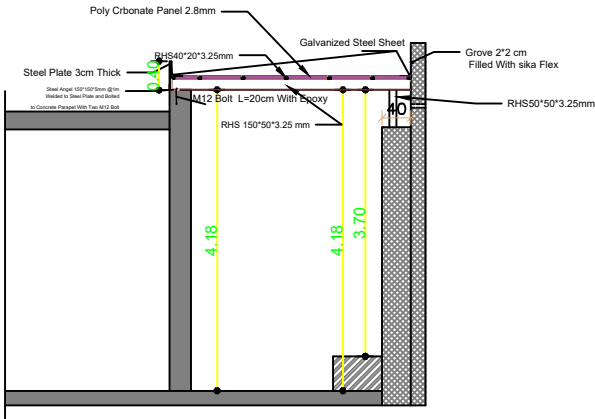

Section 1-1

- Notes**
- (1) All Dimensions Are In M.
 - (2) All Levels Are In Meter
 - (3) Any Missing or Unclear Detail And All Fastening Systems For All Elements Shall be Approved by The Supervisor.

Legend:

SECTION NUMBER
REFERENCE SHEET NUMBER

REFERENCE DETAIL SHEET NUMBER

FLOOR FINISH LEVEL (F.F.L.)
REINFORCEMENT CONCRETE LEVEL (R.C.L.)

LEVEL SIGN IN PLAN

ROOM CODE
AREA
ROOM ID

DOOR NUMBER
REFERENCE DETAIL SHEET NUMBER

WINDOW NUMBER
REFERENCE DETAIL SHEET NUMBER

ENTRANCE

ARTIFICIAL GRASS

PORCELAIN TILES (PARQUET STYLE)

DEMOLISHING AND REMOVAL

NEW INTERVENTION

STEEL SHEETS

RC CONCRETE FOR COLUMNS

RC CONCRETE FOR WALLS

CONCRETE

STONE WALL

HOLLOW BLOCKS

CEMENT TILE

PORCELAIN TILE

LOCAL MARBLE

Gypsum partition

R.C.L.:REN. CONCRETE LEVEL

F.F.L.:FINISH FLOOR LEVEL

S.L. : SEA LEVEL

REVISIONS		
NO.	DRAWINGS	DATE
(1)		
(2)		
(3)		

Contracting Authority:

Enabel

Funded By:

Belgium
partner in development

Project Title:

“Public Works Contract for the rehabilitation of 5 schools in East Jerusalem”

Reference number: PSE22001-10074

Lot 1: the rehabilitation of Al-Hasan Al-Thany, Al-Shabbat Al-Shameleh, and Al-Fata Al-Laji'a schools in Wadi Al-Joz

Al-Fata Al-Laji'a A Secondary Girls' School

Designed by:

HOSH STUDIO
ARCHITECTURE & TOWN PLANNING

Jerusalem - Sheikh Jarrah- Tobler8
email: mr.wasimhija@gmail.com

Tel. 02-9948344/ 052-8327076
Fax: 02-9948344

Drawing Title	Structural Design for Pergola	Date: 25/3/2025 Scale: 1:100
Designed by:	Saba Ameerah	Drawing No:
Checked by:	Arch. Wasim Abu El-Hija	S02
Approved by:		

Electrical Legend:

SYMBOL	DESCRIPTION	
	LIGHTING FIXTURE & SWITCHES	H= (cm) a.f.f.
	40W WH 40cm, ,6500K	
	EMERGENCY LED LIGHT, 3W	CEILING
	24W, AQUA LED ,6000K ,IP54	
	50W, NISKD JET LED SMD ,6000K,IP65	
	125X30cm,4x36W,5000K LED light	
	LED TYPE WITH EXIT SIGN AND ARROWS EMERGENCY LIGHTING FIX.	
	48W, SPEED LED WP, 6500K, IP65	
	spot light unit directed to up mounted on wall	
	spot light unit directed down mounted on wall	
	LINEAR LED LINE	
	spot light unit inside glass locker	
	SINGLE POLE ONE GANG SWITCH / W.P.	130
	SINGLE POLE TWO GANG SWITCH / W.P.	130
	SINGLE POLE THREE GANG SWITCH / W.P.	130
	SINGLE POLE FOUR GANG SWITCH / W.P.	130
	TWO WAY SWITCH / W.P.	130
	INTERMEDIATE SWITCH	130
	PUSH BUTTON	130
	FIRE ALARM SYSTEM	
	PHOTO SMOKE SENSOR	CEILING
	HEAT DETECTOR	CEILING
	BREAK GLASS With Cover	150
	INTERNAL SIREN	220
	CONTROL MODULE	CEILING
	EXTERNAL SIREN WITH FALSHER	220
	Beam Detector-Receiver	
	Beam Detector-Transmitter	
	DETECTOR INDICATION LAMP	CEILING
	PHOELECTRIC SMOKE DET. ABOVE FAULSECEILING	CEILING
	FIRE ALARM CONTROL PANEL	180
	REPEATER PANEL WITH CONTROL	150

SYMBOL	DESCRIPTION	
	POWER SOCKETS	H= (cm) a.f.f.
	16A 3 PIN SOCKET OUTLET / W.P.	
	16A 3 PIN SOCKET OUTLET CEILING MOUNTED	
	16A 3 PIN TWIN SOCKET OUTLET / W.P.	
	16A 3 PIN TRIPLE SOCKET OUTLET	
	SINGLE PHASE (2POLE) ISOLATOR, Rate As Indicated	
	THREE PHASE (4POLE) ISOLATOR, Rate As Indicated	
	DOUBLE POLE SWITCH WITH INDICATOR LAMP / W.P.	
	JUNCTION BOX	
	EMERGENCY TRIP PUSH BUTTON	
	MDB	
		CEILING
	L.V. SOCKETS	
	TELEPHONE SOCKET OUTLET	110
	T.V. SOCKET OUTLET	110
	INTERCOM SPEAKER	110
	CONNECTION BOX	110
	DATA SOCKET OUTLET	110
	LOW VOLTAGE BOX	
	COMPUTER PATCH PANEL	Top Of Panel
	CCTV SYSTEM	
	Network Video Recorder	220
		220
	DOME IN/OUT DOOR COLORED CAMERA	CEILING
	FIXED OUTDOOR COLORED CAMERA DAY/NIGHT	300
	SPLIT SCREEN MONITOR	Table
	CCTV CENTRAL MONITOR	Table
	School Bell	220
	SOUND SYSTEM	H= (cm) a.f.f.
	6WATT RECESSED LOUD SPEAKER	CEILING
	6WATT SURFACE MOUNT LOUD SPEAKER	220
	25W WALL MOUNTED ADJUSTABLE HORN	220
	END OF THE LINE	CEILING
	VOLUME CONTROL	150
	16 BUTTON CALL STATION	Table
	PUBLIC ADDRESS AND VOICE ALARM RACK	180

List Of Drawing:

CONDUIT COLORS & WIRING DETAILS

DESC.	Color	CONDUIT Size	Cable / Wires
COMPUTER	Yellow	1ø16 CONDUIT	CAT6 SHEILDDED CABLE
POWER	Green	1ø16 CONDUIT	3x2.5 mm2 wires or XLPE Cable
UPS	Green	1ø16 CONDUIT	3x2.5 mm2 wires or XLPE Cable
TELEPHONE	Brown	1ø16 CONDUIT	2 pair telephone cable
LIGHTING	Blue	1ø16 CONDUIT	3x1.5 mm2 wires or XLPE Cable
FIRE	Red	1ø16 CONDUIT	4x0.8 mm2 FIRE CABLE(RED)
CAMERA, Access Control	White	1ø16 CONDUIT	CAT6 SHEILDDED CABLE
TV,/Sat.	White	1ø16 CONDUIT	RG 59
Public Address Speakers	White	1ø16 CONDUIT	2x1 mm2 multicore speaker cable
Burglar Alarm	White	1ø16 CONDUIT	2 pair telephone cable

Notes

- (1) All Dimensions Are In M.
(2) All Levels Are In Meter
(3) Any Missing or Unclear Detail And All Fastening Systems For All Elements Shall be Approved by The Supervisor.

Legend:

REVISIONS

NO.	DRAWINGS	DATE
(1)		
(2)		
(3)		

Contracting Authority:

Enabel

Funded By:



Project Title:

“Public Works Contract for the rehabilitation of 5 schools in East Jerusalem”

Reference number: PSE22001-10074

Lot 1: the rehabilitation of Al-Hasan Al-Thany, Al-Shabbat Al-Shameleh, and Al-Fata Al-Laji'a schools in Wadi Al-Joz

Al-Fata Al-Laji'a A Secondary Girls' School

Designed by:



Jerusalem - Sheikh Jarrah- Tobler8 email: mr.wasimhija@gmail.com Tel. 02-9948344/ 052-8327076 Fax: 02-9948344

Drawing Title	Scope of Intervention Electrical Legend	Date: 25/3/2025 Scale: 1:100
Designed by:	Eng. Adli Naser Al-Deen	Drawing No:
Checked by:	Eng. Adli Naser Al-Deen	E00
Approved by:		
Coordinate Manager:		



**Scope of Intervention
Building 1 & 2**

Notes

- (1) All Dimensions Are In M.
- (2) All Levels Are In Meter
- (3) Any Missing or Unclear Detail And All Fastening Systems For All Elements Shall be Approved by The Supervisor.

Legend:

REVISIONS

NO.	DRAWINGS	DATE
(1)		
(2)		
(3)		

Contracting Authority:



Funded By:



Project Title:

**“Public Works Contract for the rehabilitation
of 5 schools in East Jerusalem”**

Reference number: PSE22001-10074

**Lot 1: the rehabilitation of Al-Hasan
Al-Thany, Al-Shabbat Al-Shameleh, and
Al-Fata Al-Laji'a schools in Wadi Al-Joz**


**Al-Fata Al-Laji'a A Secondary
Girls' School**

Designed by:



Jerusalem - Sheikh Jarrah- Tobler8
email: mr.wasimhija@gmail.com
Tel. 02-9948344/ 052-8327076
Fax: 02-9948344

Drawing Title	Fire alarm system	Date: 25/3/2025 Scale: 1:100
Designed by:	Eng. Adli Naser Al-Deen	Drawing No:
Checked by:	Eng. Adli Naser Al-Deen	E01
Approved by:		
Coordinate Manager:		

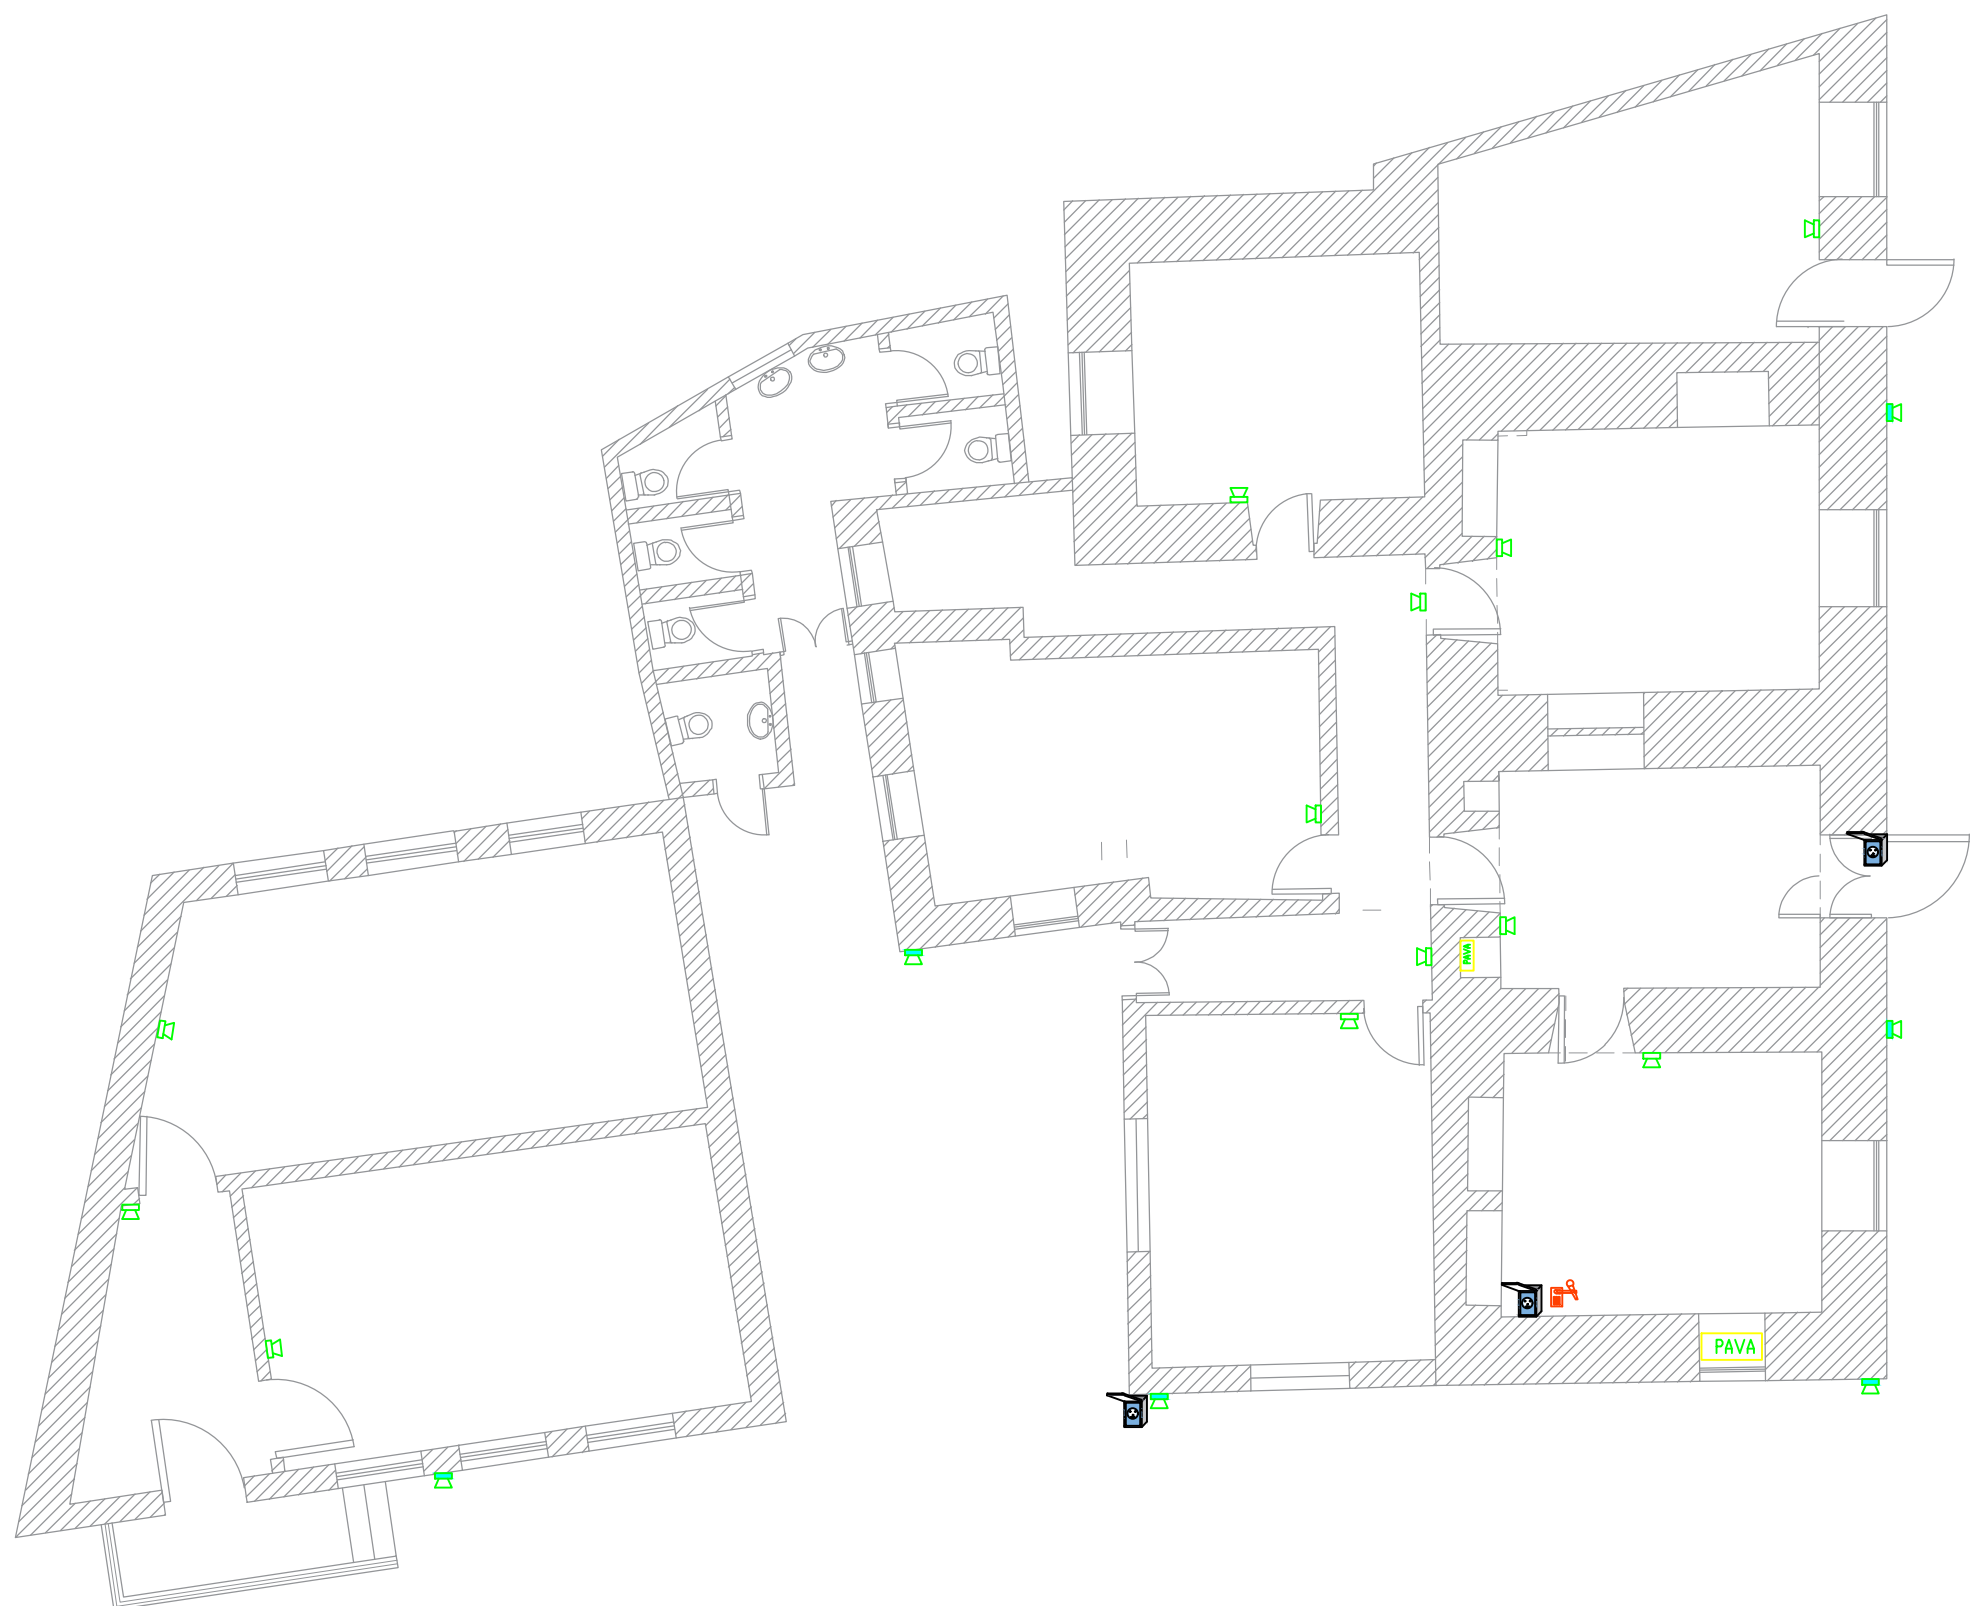

**Scope of Intervention
Building 1 & 2**

Notes

- (1) All Dimensions Are In M.
- (2) All Levels Are In Meter
- (3) Any Missing or Unclear Detail And All Fastening Systems For All Elements Shall be Approved by The Supervisor.

Legend:

REVISIONS

NO.	DRAWINGS	DATE
(1)		
(2)		
(3)		

Contracting Authority:



Funded By:



Project Title:

**“Public Works Contract for the rehabilitation
of 5 schools in East Jerusalem”**

Reference number: PSE22001-10074

**Lot 1: the rehabilitation of Al-Hasan
Al-Thany, Al-Shabbat Al-Shameleh, and
Al-Fata Al-Laji'a schools in Wadi Al-Joz**


**Al-Fata Al-Laji'a A Secondary
Girls' School**

Designed by:



Jerusalem - Sheikh Jarrah- Tobler8
email: mr.wasimhija@gmail.com
Tel. 02-9948344/ 052-8327076
Fax: 02-9948344

Drawing Title	Public address system	Date: 25/3/2025 Scale: 1:100
Designed by:	Eng. Adli Naser Al-Deen	Drawing No:
Checked by:	Eng. Adli Naser Al-Deen	E02
Approved by:		
Coordinate Manager:		

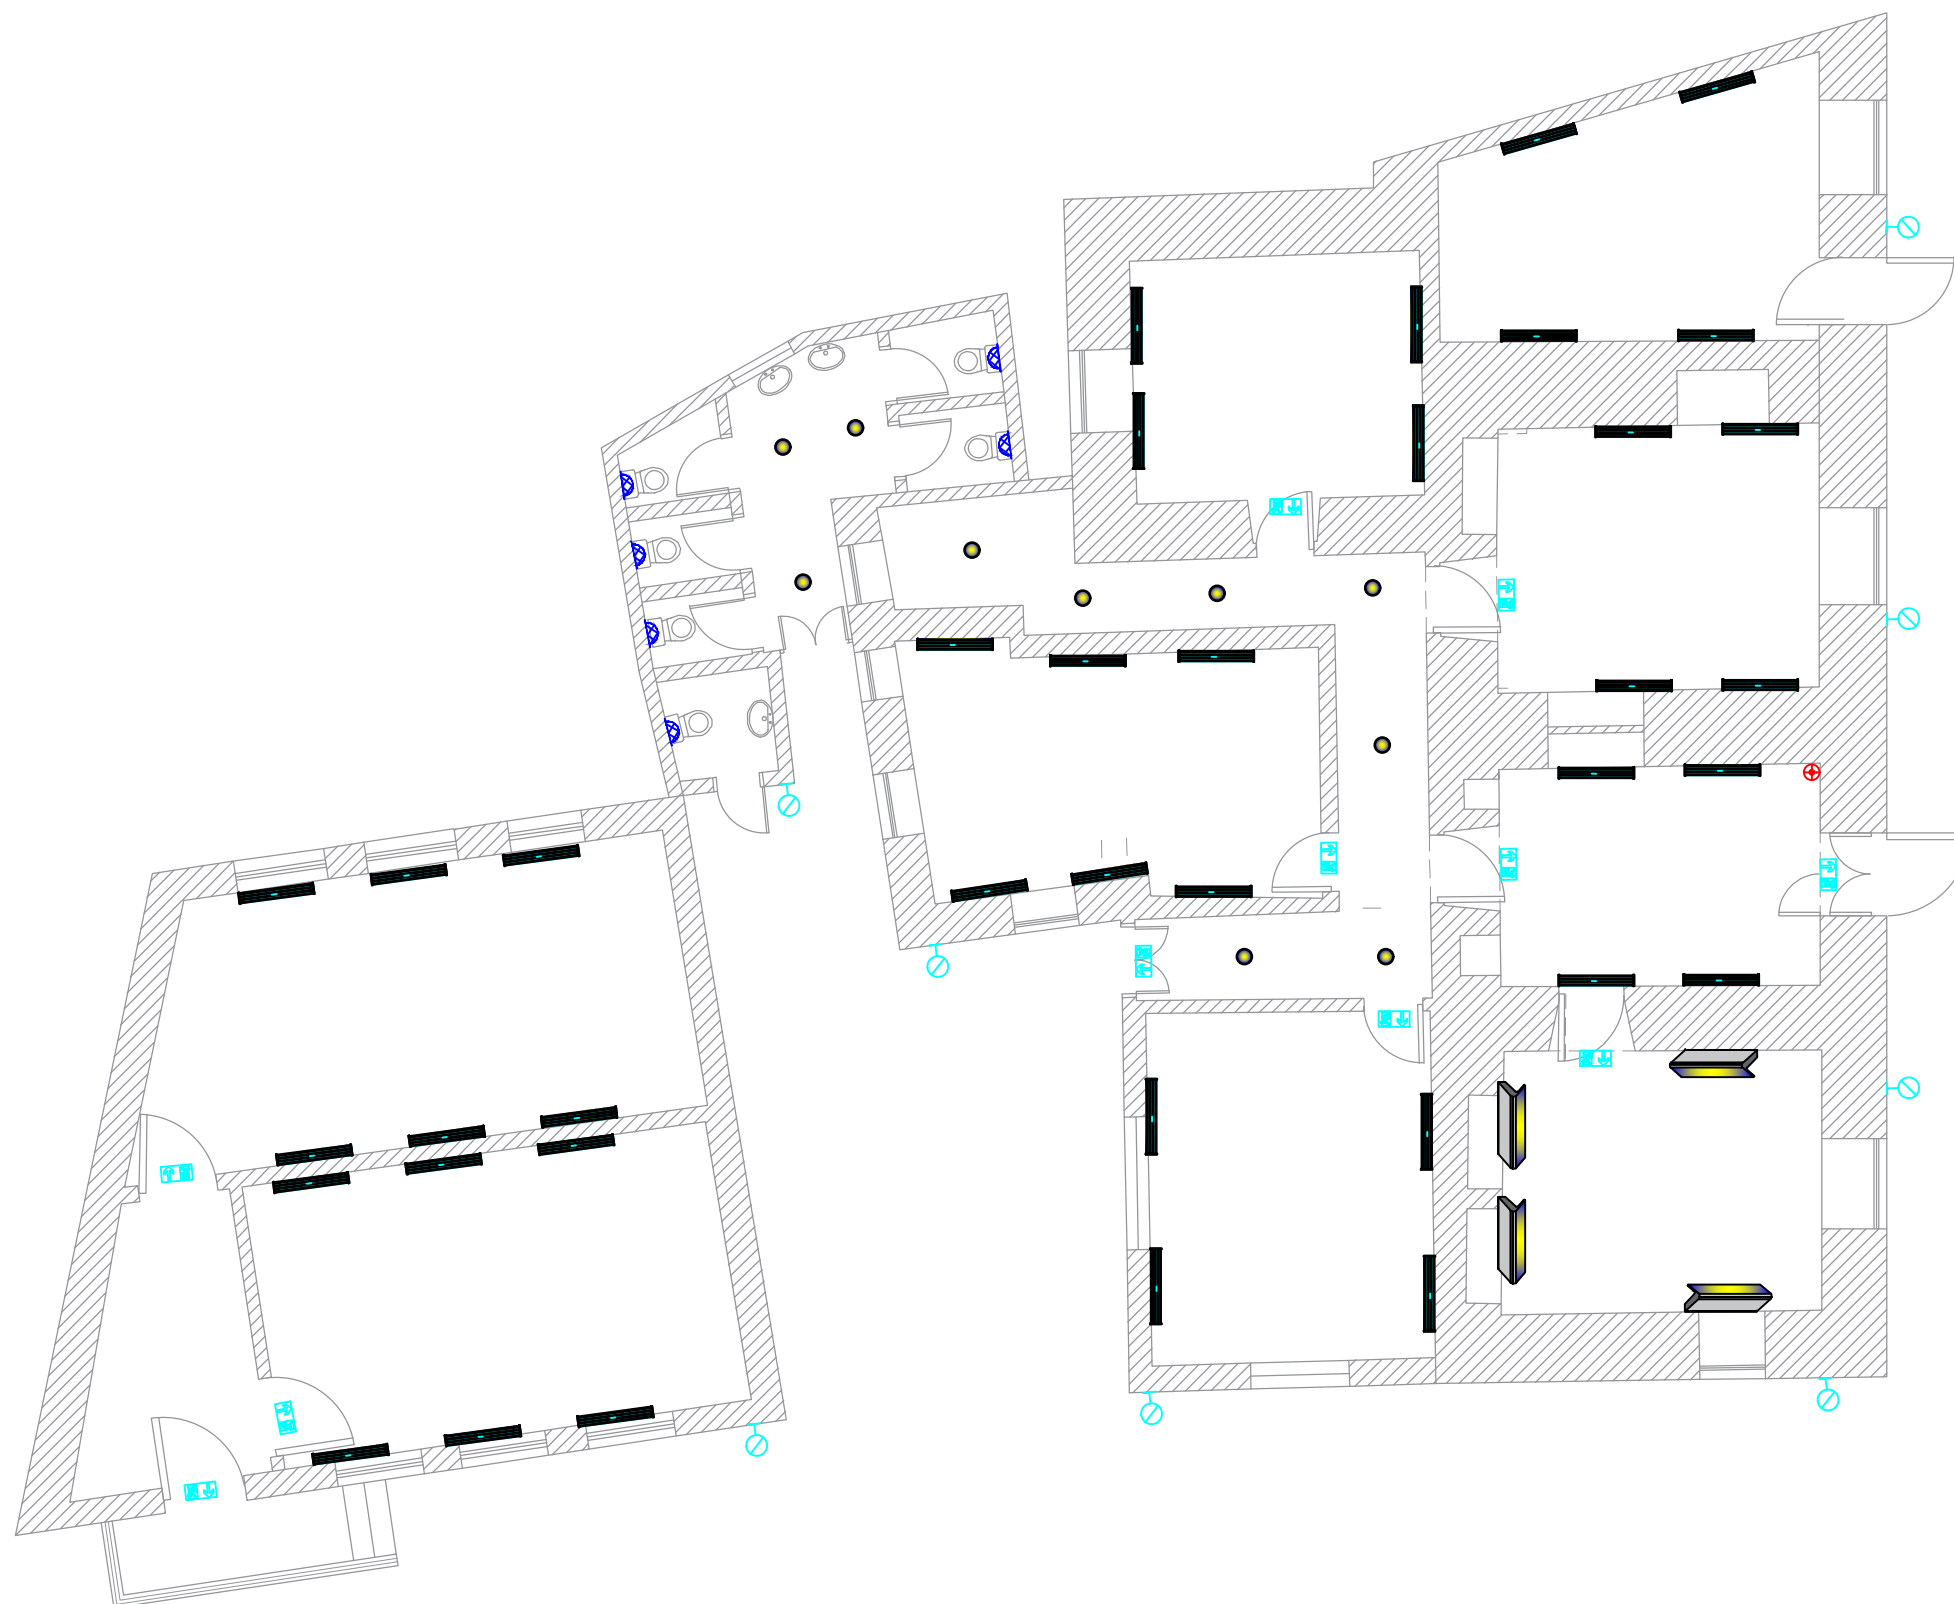

**Scope of Intervention
Building 1 & 2**

Notes

- (1) All Dimensions Are In M.
- (2) All Levels Are In Meter
- (3) Any Missing or Unclear Detail And All Fastening Systems For All Elements Shall be Approved by The Supervisor.

Legend:

REVISIONS

NO.	DRAWINGS	DATE
(1)		
(2)		
(3)		

Contracting Authority:



Funded By:



Project Title:

"Public Works Contract for the rehabilitation of 5 schools in East Jerusalem"

Reference number: PSE22001-10074

Lot 1: the rehabilitation of Al-Hasan Al-Thany, Al-Shabbat Al-Shameleh, and Al-Fata Al-Laji'a schools in Wadi Al-Joz


Al-Fata Al-Laji'a A Secondary Girls' School

Designed by:



Jerusalem - Sheikh Jarrah- Tobler8
email: mr.wasimhija@gmail.com
Tel. 02-9948344/ 052-8327076
Fax: 02-9948344

Drawing Title	Lighting system	Date: 25/3/2025 Scale: 1:100
Designed by:	LIGHTING SYSTEM	Drawing No:
Checked by:	Eng. Adli Naser Al-Deen	E03
Approved by:		
Coordinate Manager:		

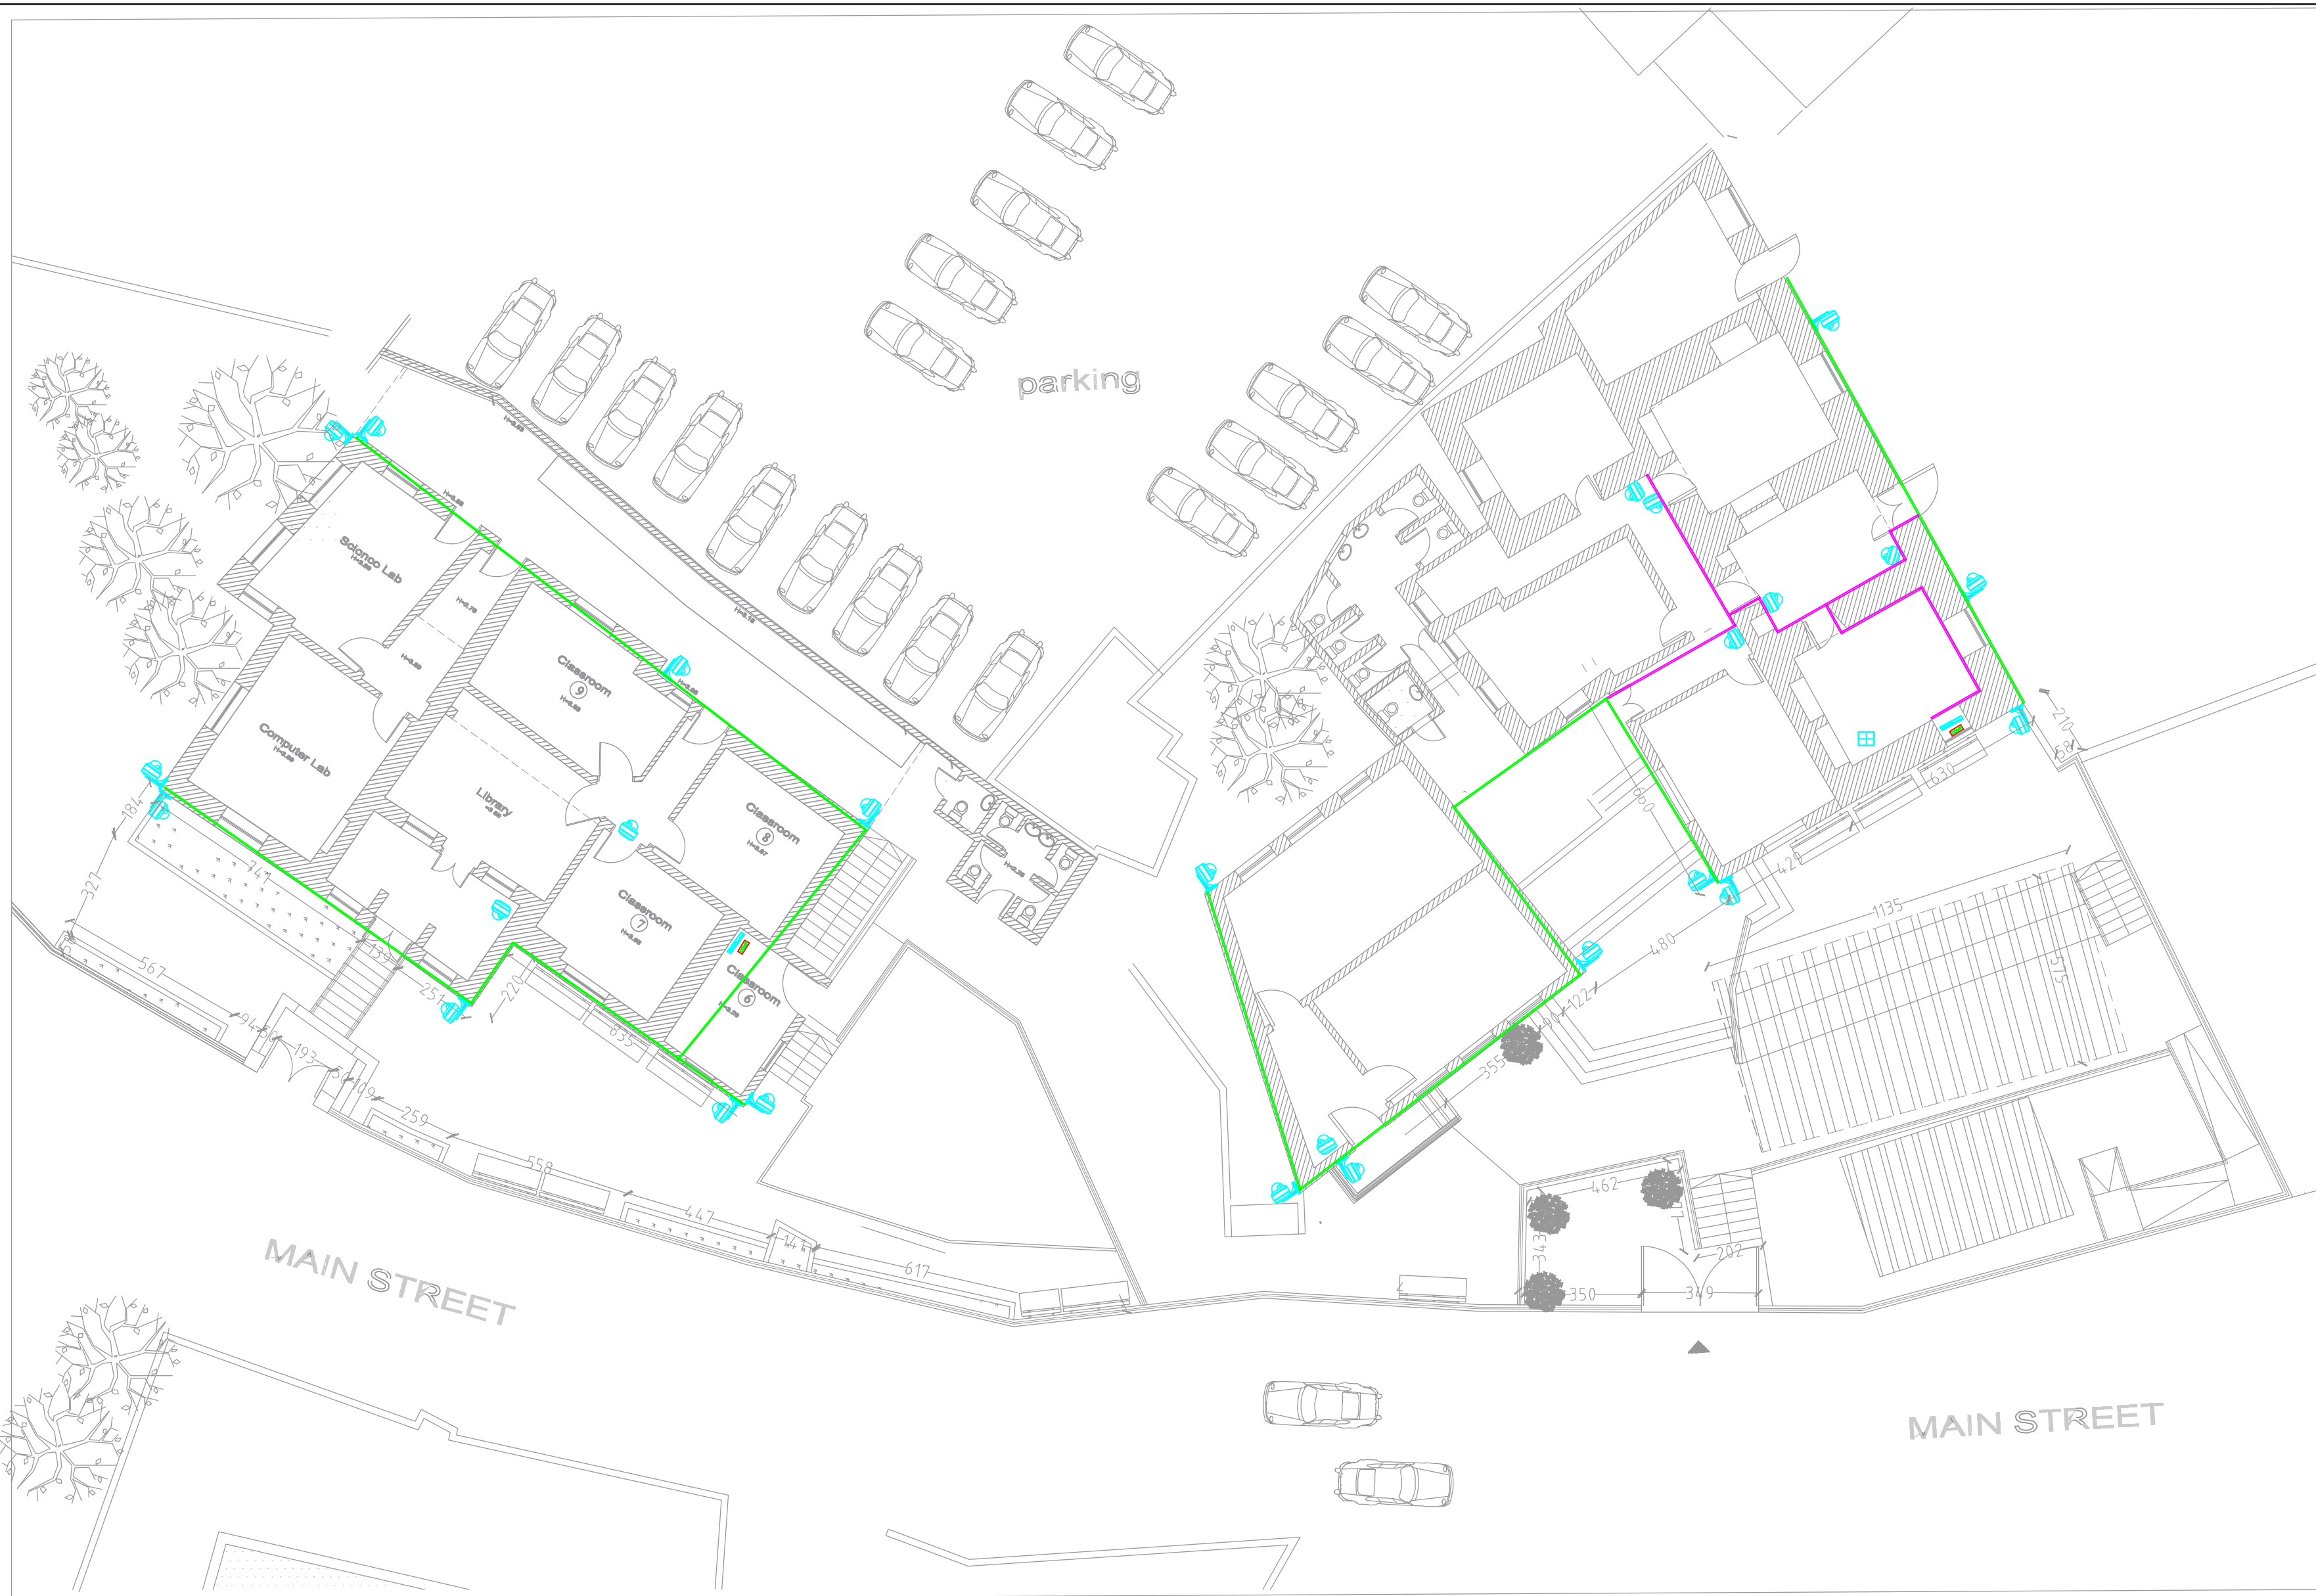

Scope of Intervention Building 1 , 2 & 3

Notes

- (1) All Dimensions Are In M.
- (2) All Levels Are In Meter
- (3) Any Missing or Unclear Detail And All Fastening Systems For All Elements Shall be Approved by The Supervisor.

Legend:

REVISIONS		
NO.	DRAWINGS	DATE
(1)		
(2)		
(3)		

Contracting Authority:



Funded By:



Project Title:

“Public Works Contract for the rehabilitation of 5 schools in East Jerusalem”

Reference number: PSE22001-10074

Lot 1: the rehabilitation of Al-Hasan Al-Thany, Al-Shabbat Al-Shameleh, and Al-Fata Al-Laji'a schools in Wadi Al-Joz




Al-Fata Al-Laji'a A Secondary Girls' School

Designed by:



Jerusalem - Sheikh Jarrah- Tobler8
email: mr.wasimhija@gmail.com
Tel. 02-9948344/ 052-8327076
Fax: 02-9948344

Drawing Title	Scope of Intervention	Date: 25/3/2025 Scale: 1:200
Designed by:	Eng. Adli Naser Al-Deen	Drawing No: E04
Checked by:	Eng. Adli Naser Al-Deen	
Approved by:		
Coordinate Manager:		

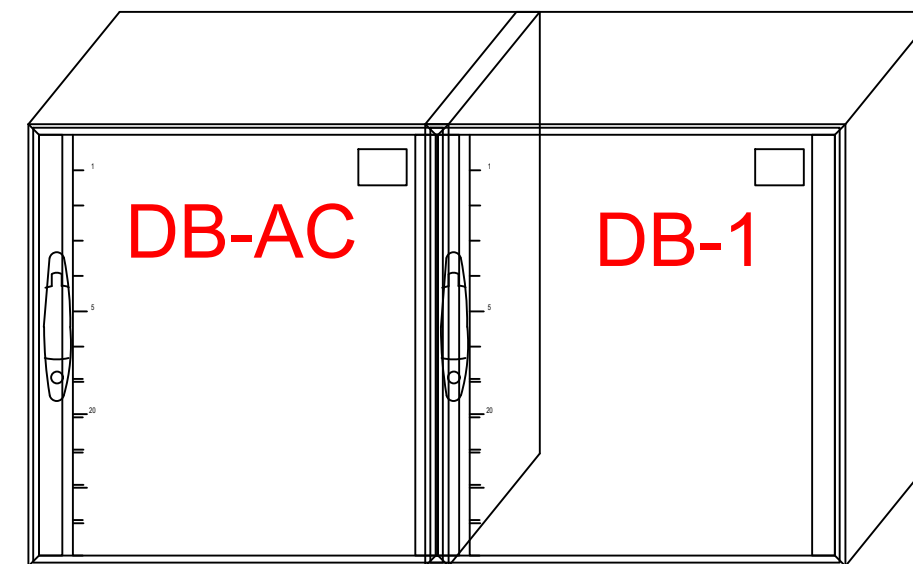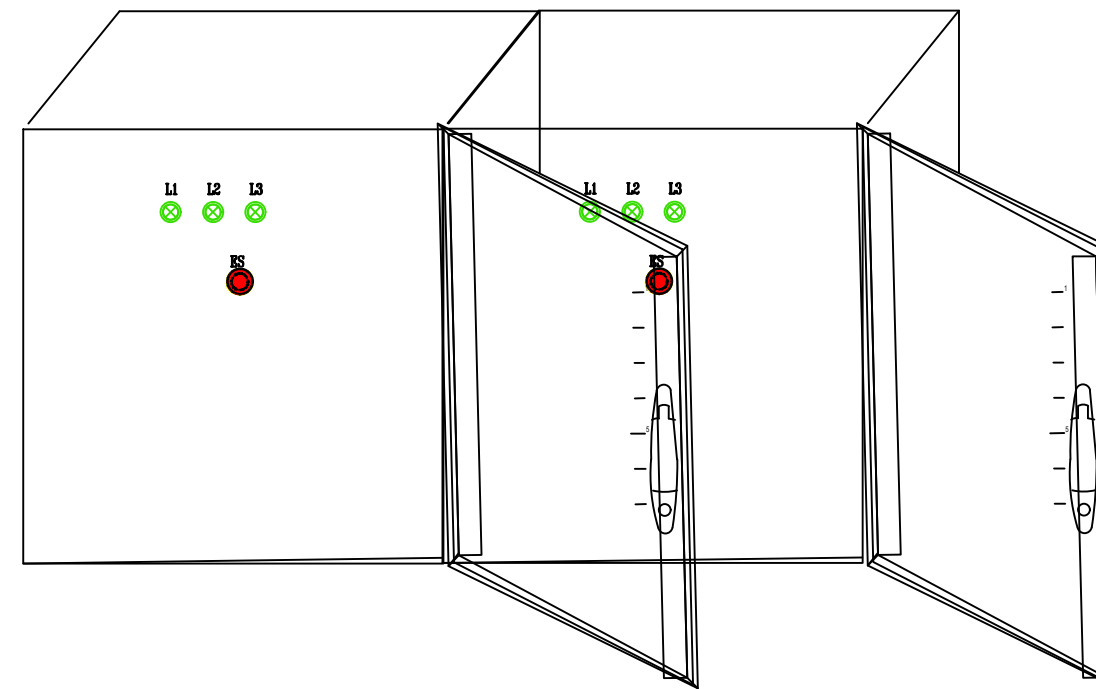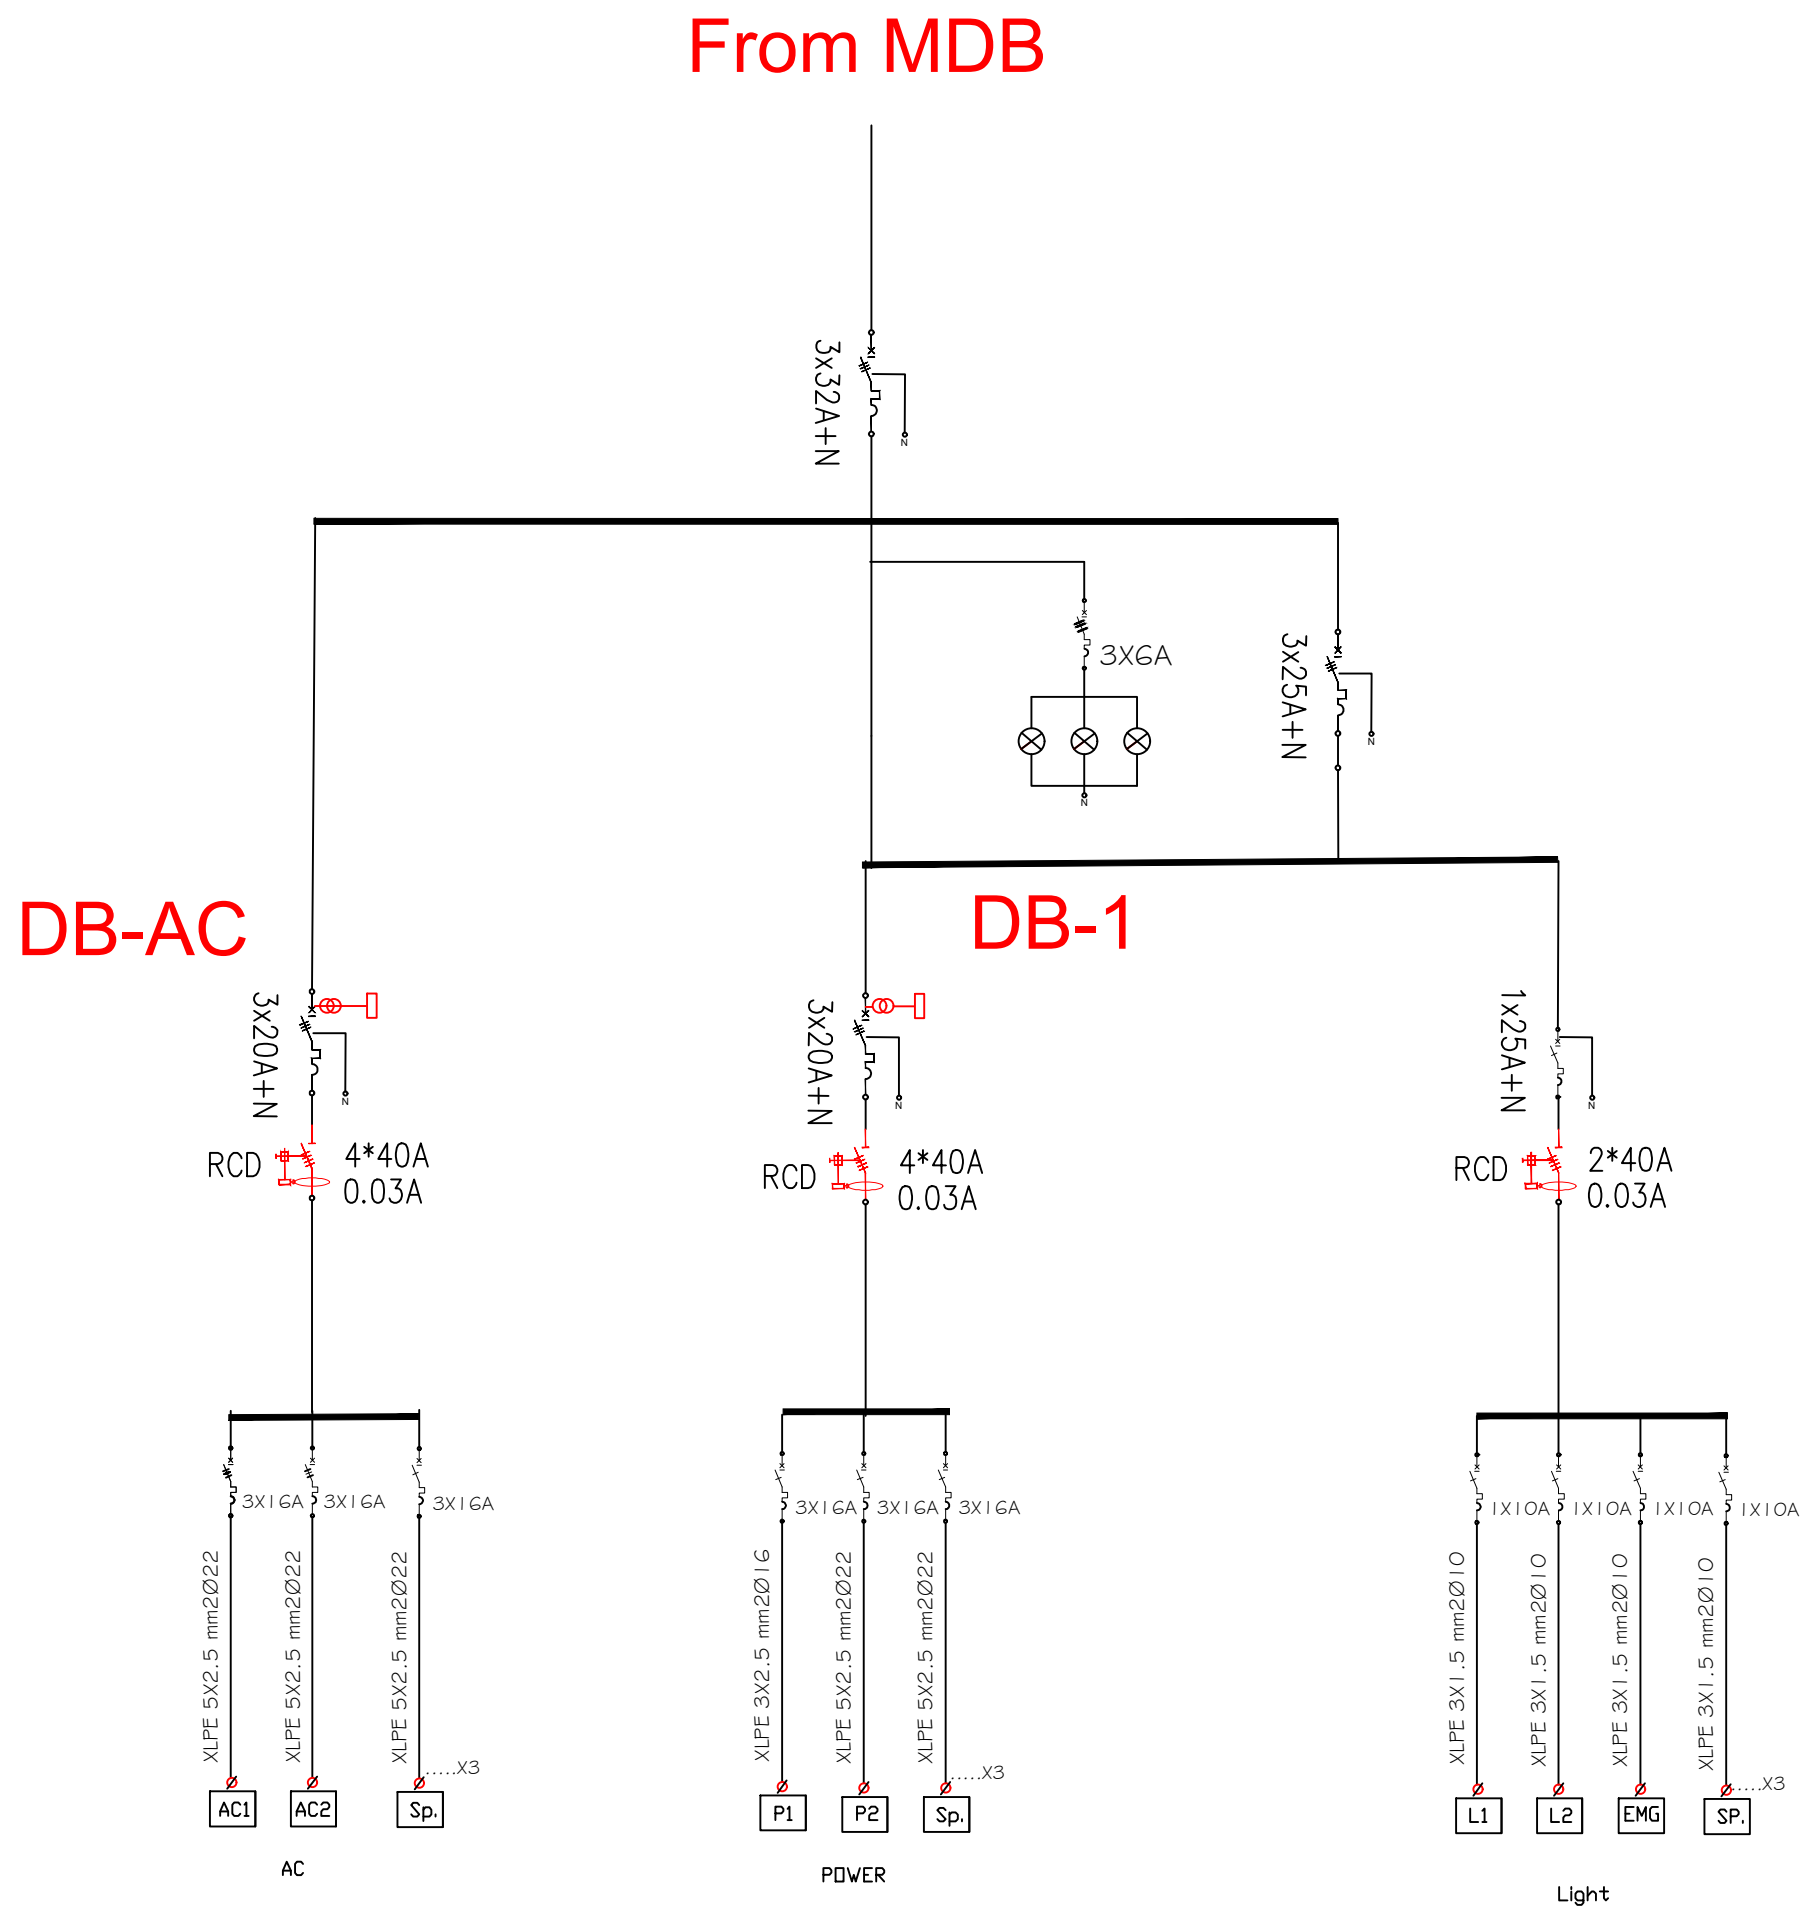

Notes

- (1) All Dimensions Are In M.
- (2) All Levels Are In Meter
- (3) Any Missing or Unclear Detail And All Fastening Systems For All Elements Shall be Approved by The Supervisor.

Legend:

REVISIONS		
NO.	DRAWINGS	DATE
(1)		
(2)		
(3)		

Contracting Authority:



Funded By:



Project Title:


“Public Works Contract for the rehabilitation of 5 schools in East Jerusalem”

Reference number: PSE22001-10074

Lot 1: the rehabilitation of Al-Hasan Al-Thany, Al-Shabbat Al-Shameleh, and Al-Fata Al-Laji'a schools in Wadi Al-Joz

Al-Fata Al-Laji'a A Secondary Girls' School

Designed by:

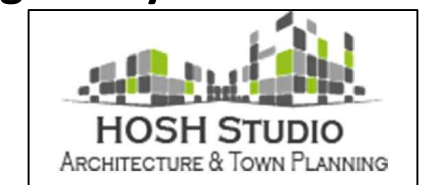

Jerusalem - Sheikh Jarrah- Tobler8
email: mr.wasimhija@gmail.com

Tel. 02-9948344/ 052-8327076
Fax: 02-9948344

Drawing Title	Scope of Intervention	Date: 25/3/2025
		Scale: 1:100
Designed by:	Eng. Adli Naser Al-Deen	Drawing No: E06
Checked by:	Eng. Adli Naser Al-Deen	
Approved by:		
Coordinate Manager:		