

Lot1: Al-Shameleh Secondary Girls' school

ARCHITECTURAL DRAWINGS			
#	SHEET #	SHEET TITLE	SCALE
01	A00	LIST OF DRAWINGS & NOTES ABBREVIATION & SYMBOLS	—
02	A14	ROOF FLOOR PLAN	1:200
03	A15	Scope of Intervention at Basement Floor	1:100
04	A16	Scope of Intervention at Ground Floor	1:100
05	A17	Scope of Intervention at First & Second Floors	1:100
06	A18	Roof Epoxy Flooring	1:100
07	A19	Fence Design	1:100
08	A20	Roof Drainage	1:100

Notes

(1) All Dimensions Are In M.
(2) All Levels Are In Meter
(3) Any Missing or Unclear Detail And All Fastening Systems For All Elements Shall be Approved by The Supervisor.

Legend:

SECTION NUMBER
REFERENCE SHEET NUMBER

ROOM CODE
AREA
ROOM ID

FLOOR FINISH LEVEL (F.F.L.)
REINFORCEMENT CONCRETE LEVEL (R.C.L.)

LEVEL SIGN IN PLAN

STEEL SHEETS
RC CONCRETE FOR COLUMNS
RC CONCRETE FOR WALLS
CONCRETE
STONE WALL
HOLLOW BLOCKS
CEMENT TILE
PORCELAIN TILE
LOCAL MARBLE
Gypsum partition

ENTRANCE
ARTIFICIAL GRASS
PORCELAIN TILES (PARQUET STYLE)
DEMOLISHING AND REMOVAL
NEW INTERVENTION

R.C.L.: REN. CONCRETE LEVEL
F.F.L.: FINISH FLOOR LEVEL
S.L.: SEA LEVEL

REVISIONS

NO.	DRAWINGS	DATE
(1)		
(2)		
(3)		

Contracting Authority:

Enabel

Funded By:

Belgium

partner in development

Project Title:

“Public Works Contract for the rehabilitation of 5 schools in East Jerusalem”

Reference number: PSE22001-10074

Lot 1: the rehabilitation of Al-Hasan Al-Thany, Al-Shabbat Al-Shameleh, and Al-Fata Al-Laji’a schools in Wadi Al-Joz

Al-Shameleh Secondary Girls' school

Designed by:


HOSH STUDIO

ARCHITECTURE & TOWN PLANNING

Jerusalem - Sheikh Jarrah- Tobler8
email: mr.wasimhija@gmail.com

Tel. 02-9948344/ 052-8327076
Fax: 02-9948344

Drawing Title	Table of Drawings	Date: 25/3/2025 Scale: 1:100
Designed by:	Arch. Hiba Al Ayoubi	Drawing No:
Checked by:	Arch. Wasim Abu El-Hija	A00
Approved by:		
Coordinate Manager:		

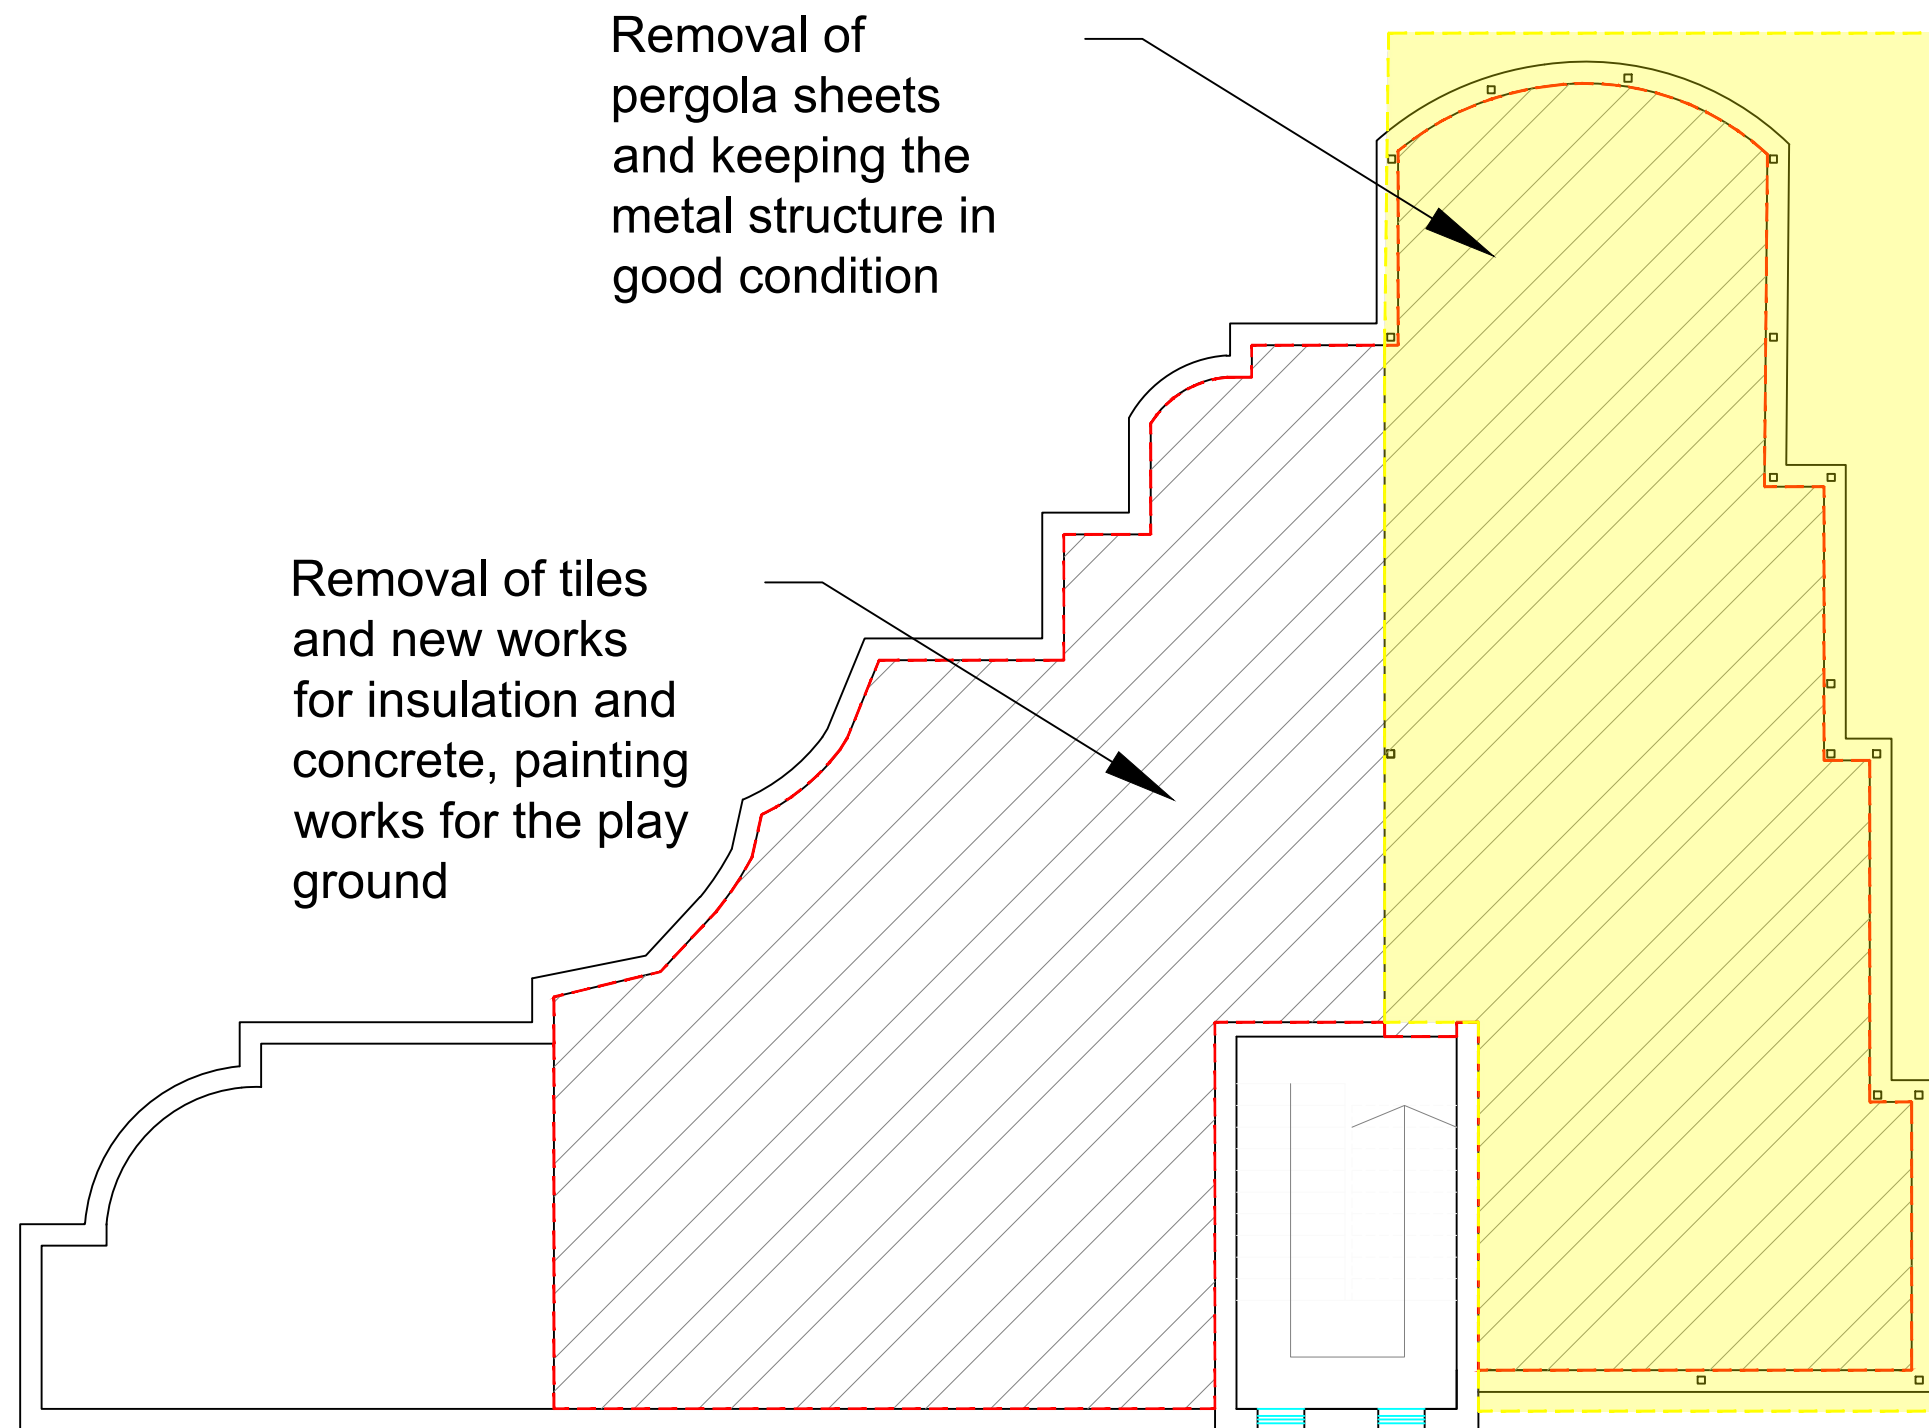

ROOF FLOOR PLAN

Notes

- (1) All Dimensions Are In M.
- (2) All Levels Are In Meter
- (3) Any Missing or Unclear Detail And All Fastening Systems For All Elements Shall be Approved by The Supervisor.

Legend:

	SECTION NUMBER		ROOM CODE		FUNCTION
	REFERENCE SHEET NUMBER		ROOM ID		DOOR NUMBER
	REFERENCE DETAIL SHEET NUMBER		DOOR DETAIL SHEET NUMBER		WINDOW NUMBER
	FLOOR FINISH LEVEL (F.F.L.)		WINDOW DETAIL SHEET NUMBER		DETAILED SECTION AT SHEET No. A09
	REINFORCEMENT CONCRETE LEVEL (R.C.L.)		ENTRANCE		ARTIFICIAL GRASS
	LEVEL SIGN IN PLAN		PORCELAIN TILES (PARQUET STYLE)		DEMOLISHING AND REMOVAL
	STEEL SHEETS		NEW INTERVENTION		
	RC CONCRETE FOR COLUMNS				
	RC CONCRETE FOR WALLS				
	CONCRETE				
	STONE WALL				
	HOLLOW BLOCKS				
	CEMENT TILE				
	PORCELAIN TILE				
	LOCAL MARBLE				
	Gypsum partition				
			R.C.L.: REN. CONCRETE LEVEL		
			F.F.L.: FINISH FLOOR LEVEL		
			S.L.: SEA LEVEL		

REVISIONS

NO.	DRAWINGS	DATE
(1)		
(2)		
(3)		

Contracting Authority:



Funded By:



Project Title:

"Public Works Contract for the rehabilitation of 5 schools in East Jerusalem"

Reference number: PSE22001-10074

Lot 1: the rehabilitation of Al-Hasan Al-Thany, Al-Shabbat Al-Shameleh, and Al-Fata Al-Laji'a schools in Wadi Al-Joz

Al-Shameleh Secondary Girls' school

Designed by:



Jerusalem - Sheikh Jarrah - Tobler8
email: mr.wasimhija@gmail.com
Tel. 02-9948344/ 052-8327076
Fax: 02-9948344

Drawing Title	ROOF FLOOR PLAN	Date: 25/3/2025 Scale: 1:100
Designed by:	Arch. Hiba Al Ayoubi	Drawing No: A14
Checked by:	Arch. Wasim Abu El-Hija	
Approved by:		
Coordinate Manager:		

Painting Works

BASEMENT FLOOR

- Notes
- (1) All Dimensions Are In M.

(2) All Levels Are In Meter

(3) Any Missing or Unclear Detail And All Fastening Systems For All Elements Shall be Approved by The Supervisor.

Legend:

SECTION NUMBER

REFERENCE SHEET NUMBER

REFERENCE DETAIL SHEET NUMBER

FLOOR FINISH LEVEL (F.F.L.)

REINFORCEMENT CONCRETE LEVEL (R.C.L.)

LEVEL SIGN IN PLAN

STEEL SHEETS

RC CONCRETE FOR COLUMNS

RC CONCRETE FOR WALLS

CONCRETE

STONE WALL

HOLLOW BLOCKS

CEMENT TILE

PORCELAIN TILE

LOCAL MARBLE

Gypsum partition

FUNCTION AREA

ROOM ID

DOOR NUMBER

REFERENCE DETAIL SHEET NUMBER

WINDOW NUMBER

REFERENCE DETAIL SHEET NUMBER

ENTRANCE

ARTIFICIAL GRASS

PORCELAIN TILES (PARQUET STYLE)

DEMOLISHING AND REMOVAL

NEW INTERVENTION

R.C.L.:REN. CONCRETE LEVEL

F.F.L.:FINISH FLOOR LEVEL

S.L. : SEA LEVEL

DETAILED SECTION AT SHEET No. A09

REVISIONS

NO.	DRAWINGS	DATE
(1)		
(2)		
(3)		

Contracting Authority:

Enabel

Funded By:

Belgium

partner in development

Project Title:

“Public Works Contract for the rehabilitation of 5 schools in East Jerusalem”

Reference number: PSE22001-10074

Lot 1: the rehabilitation of Al-Hasan Al-Thany, Al-Shabbat Al-Shameleh, and Al-Fata Al-Laji’a schools in Wadi Al-Joz

Al-Shameleh Secondary Girls' school

Designed by:

HOSH STUDIO

ARCHITECTURE & TOWN PLANNING


Jerusalem - Sheikh Jarrah- Tobler8

email: mr.wasimhija@gmail.com

Tel. 02-9948344/ 052-8327076

Fax: 02-9948344

Drawing Title	Scope of Intervention at Basement Floor	Date: 25/3/2025 Scale: 1:100
Designed by:	Arch. Hiba Al Ayoubi	Drawing No: A15
Checked by:	Arch. Wasim Abu El-Hija	
Approved by:		
Coordinate Manager:		

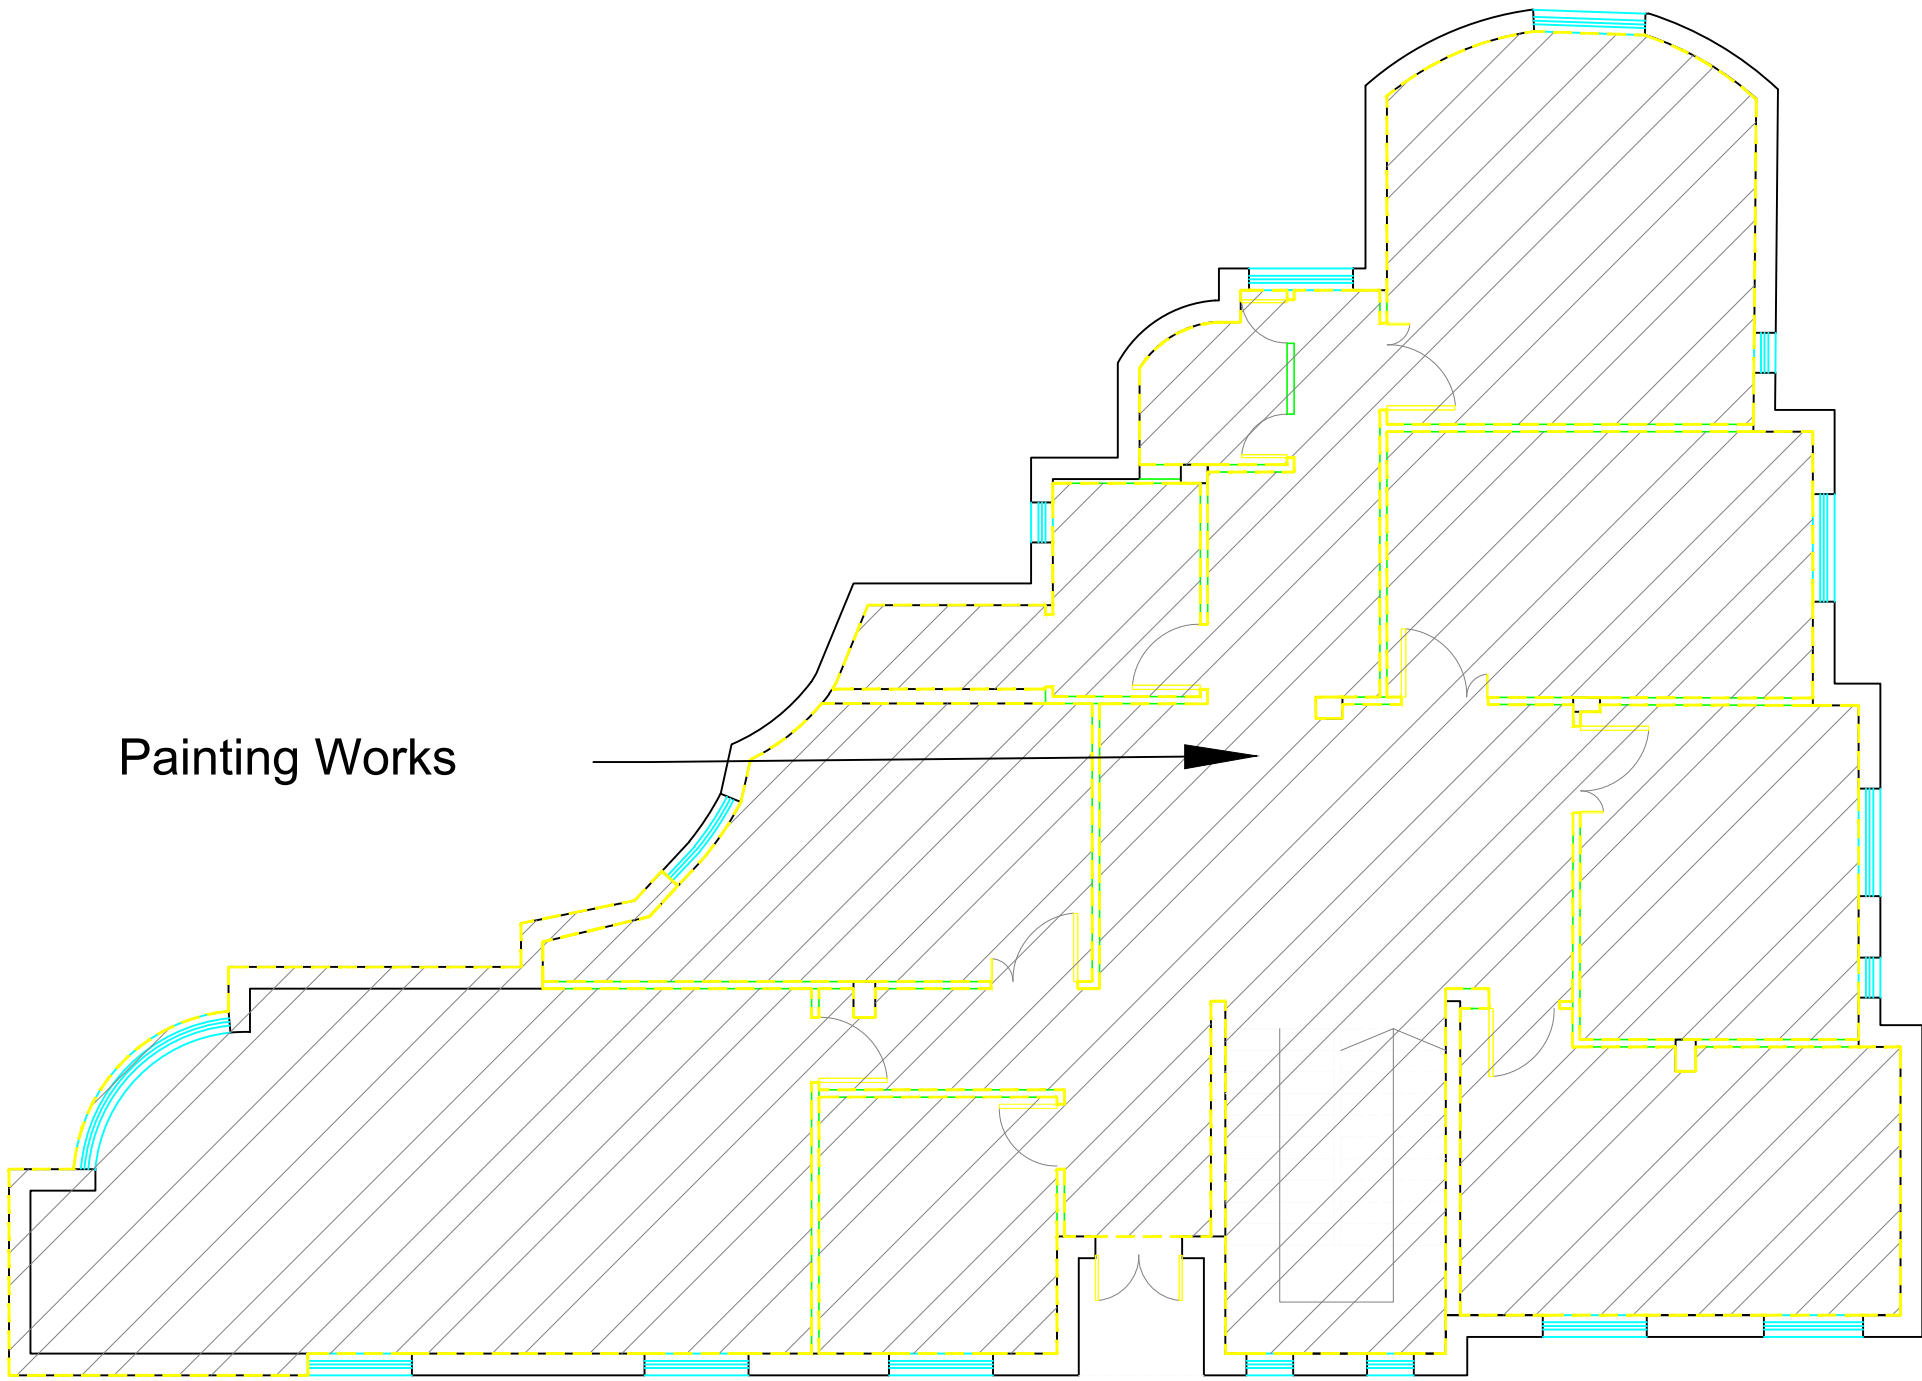

GROUND FLOOR

Notes

- (1) All Dimensions Are In M.
- (2) All Levels Are In Meter
- (3) Any Missing or Unclear Detail And All Fastening Systems For All Elements Shall be Approved by The Supervisor.

Legend:

	SECTION NUMBER		ROOM CODE		FUNCTION AREA
	REFERENCE SHEET NUMBER		ROOM ID		
	DOOR NUMBER		WINDOW NUMBER		
	FLOOR FINISH LEVEL (F.F.L.)		REINFORCEMENT CONCRETE LEVEL (R.C.L.)		
	LEVEL SIGN IN PLAN		DETAILED SECTION AT SHEET No. A09		

	STEEL SHEETS		ENTRANCE
	RC CONCRETE FOR COLUMNS		ARTIFICIAL GRASS
	RC CONCRETE FOR WALLS		PORCELAIN TILES (PARQUET STYLE)
	CONCRETE		DEMOLISHING AND REMOVAL
	STONE WALL		NEW INTERVENTION
	HOLLOW BLOCKS		
	CEMENT TILE		
	PORCELAIN TILE		
	LOCAL MARBLE		
	Gypsum partition		

	R.C.L.: REN. CONCRETE LEVEL
	F.F.L.: FINISH FLOOR LEVEL
	S.L.: SEA LEVEL

REVISIONS

NO.	DRAWINGS	DATE
(1)		
(2)		
(3)		

Contracting Authority:



Funded By:



Project Title:

“Public Works Contract for the rehabilitation of 5 schools in East Jerusalem”

Reference number: PSE22001-10074

Lot 1: the rehabilitation of Al-Hasan Al-Thany, Al-Shabbat Al-Shameleh, and Al-Fata Al-Laji’a schools in Wadi Al-Joz


Al-Shameleh Secondary Girls' school

Designed by:



Jerusalem - Sheikh Jarrah - Tobler8
email: mr.wasimhija@gmail.com
Tel. 02-9948344/ 052-8327076
Fax: 02-9948344

Drawing Title	Scope of Intervention at Ground Floor	Date: 25/3/2025 Scale: 1:100
Designed by:	Arch. Hiba Al Ayoubi	Drawing No: A16
Checked by:	Arch. Wasim Abu El-Hija	
Approved by:		
Coordinate Manager:		

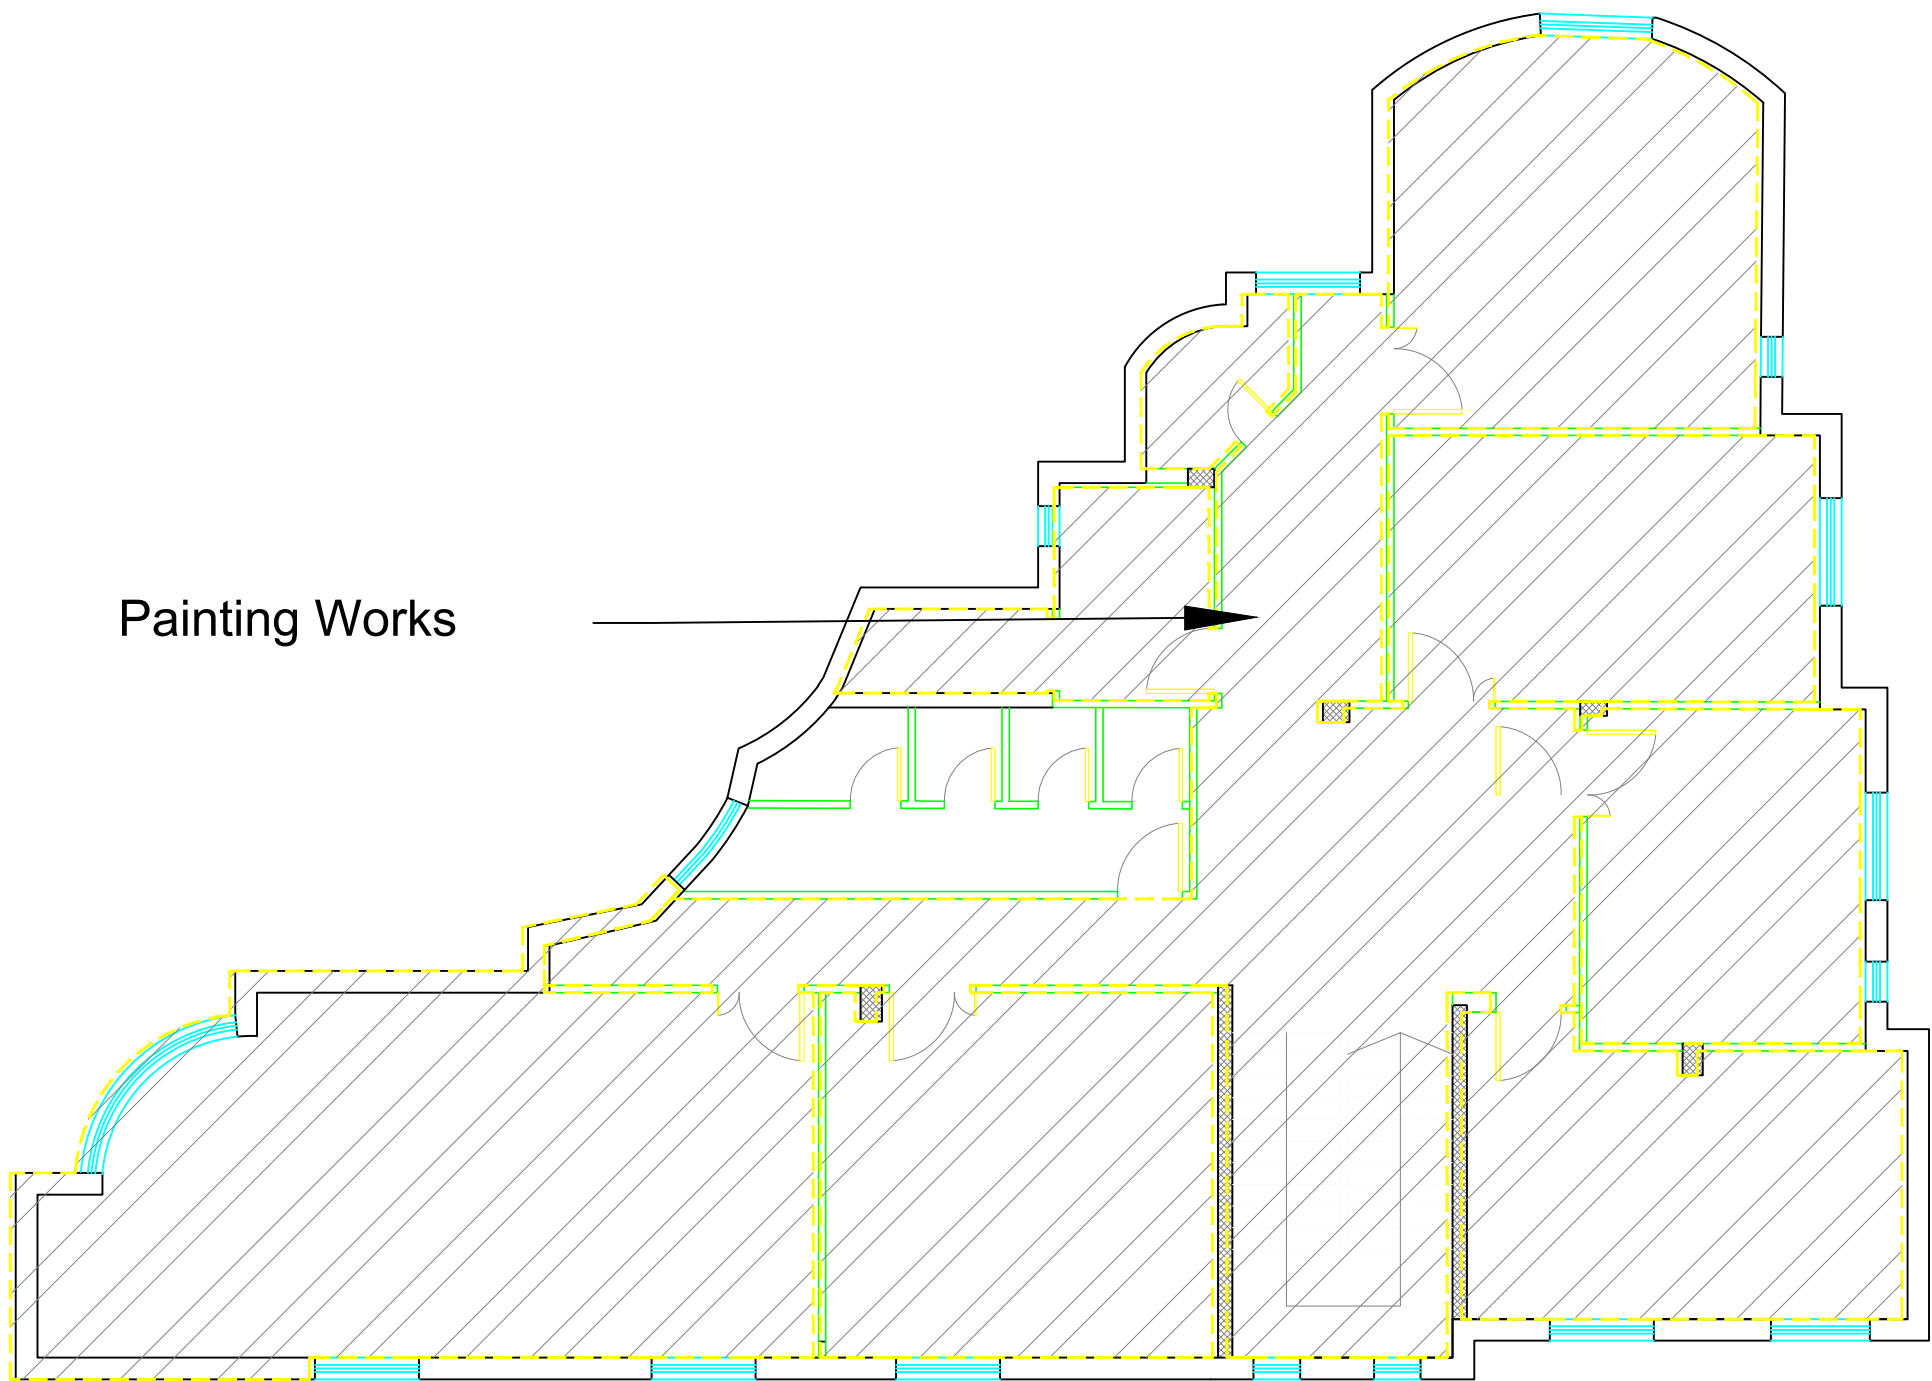

FIRST FLOOR & SECOND FLOOR

Notes

- (1) All Dimensions Are In M.
- (2) All Levels Are In Meter
- (3) Any Missing or Unclear Detail And All Fastening Systems For All Elements Shall be Approved by The Supervisor.

Legend:

SECTION NUMBER
REFERENCE SHEET NUMBER

ROOM CODE
FUNCTION
AREA
ROOM ID

REFERENCE DETAIL SHEET NUMBER

FLOOR FINISH LEVEL (F.F.L.)
REINFORCEMENT CONCRETE LEVEL (R.C.L.)

DOOR NUMBER
REFERENCE DETAIL SHEET NUMBER

LEVEL SIGN IN PLAN

WINDOW NUMBER
REFERENCE DETAIL SHEET NUMBER

DETAILED SECTION AT SHEET No. A09

STEEL SHEETS
RC CONCRETE FOR COLUMNS
RC CONCRETE FOR WALLS
CONCRETE
STONE WALL
HOLLOW BLOCKS
CEMENT TILE
PORCELAIN TILE
LOCAL MARBLE
Gypsum partition

ENTRANCE
ARTIFICIAL GRASS
PORCELAIN TILES (PARQUET STYLE)
DEMOLISHING AND REMOVAL
NEW INTERVENTION

R.C.L.: REN. CONCRETE LEVEL
F.F.L.: FINISH FLOOR LEVEL
S.L.: SEA LEVEL

REVISIONS

NO.	DRAWINGS	DATE
(1)		
(2)		
(3)		

Contracting Authority:



Funded By:


Project Title:

Designed by:



Jerusalem - Sheikh Jarrah- Tobler8
email: mr.wasimhija@gmail.com
Tel. 02-9948344/ 052-8327076
Fax: 02-9948344

Drawing Title	Scope of Intervention at First & Second Floors	Date: 25/3/2025 Scale: 1:100
Designed by:	Arch. Hiba Al Ayoubi	Drawing No: A17
Checked by:	Arch. Wasim Abu El-Hija	
Approved by:		
Coordinate Manager:		

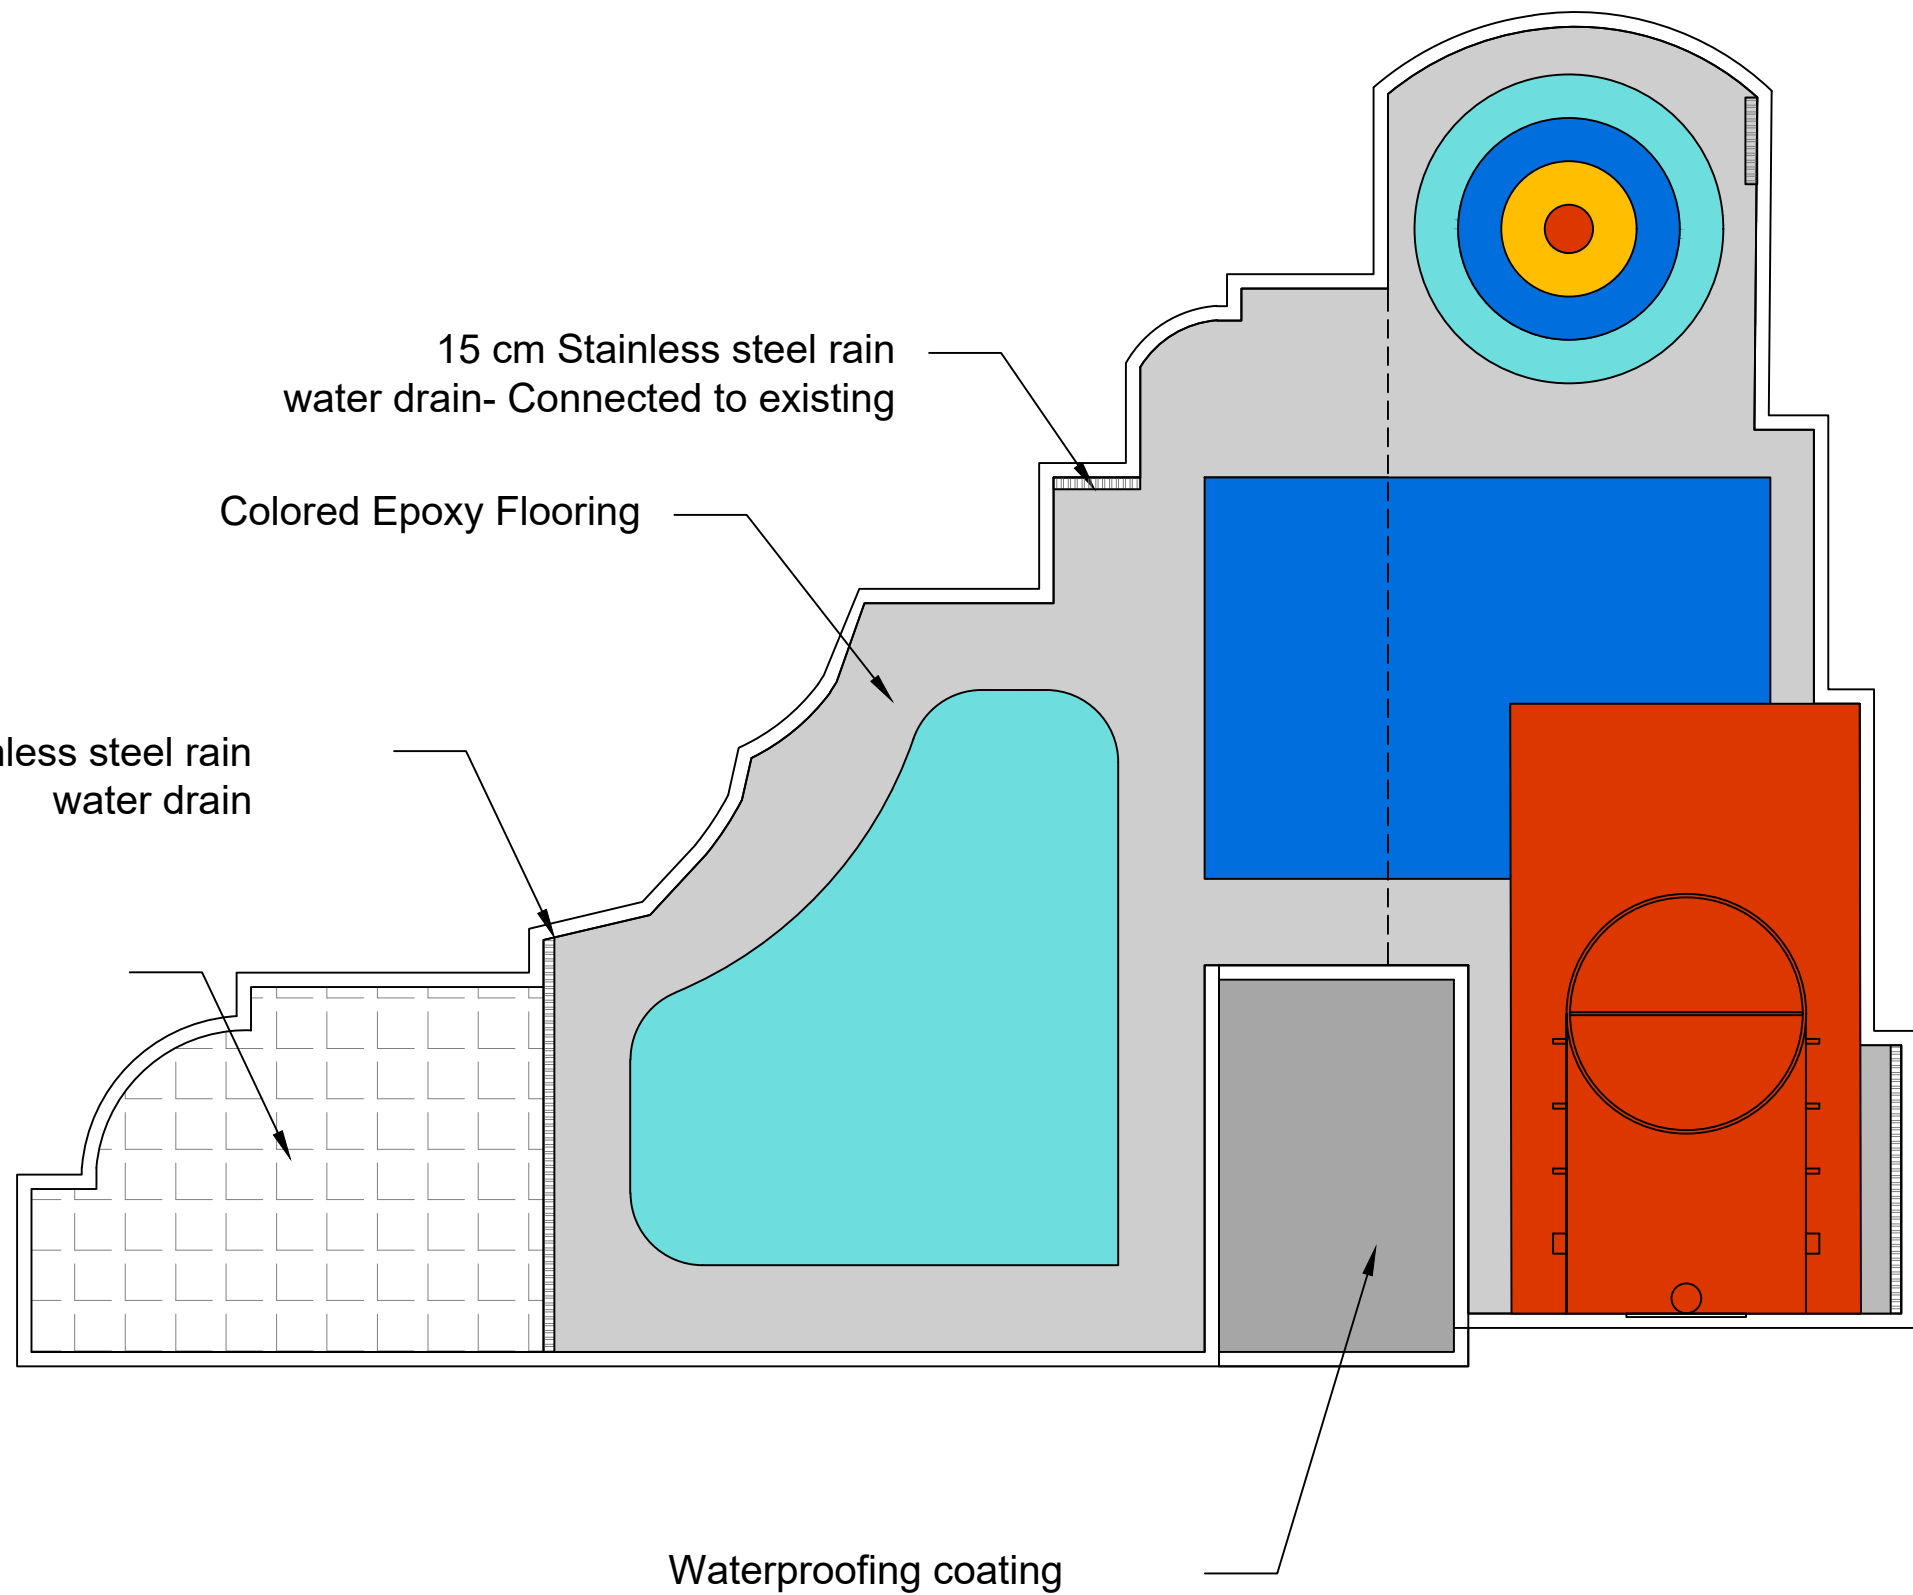

Notes

- (1) All Dimensions Are In M.
- (2) All Levels Are In Meter
- (3) Any Missing or Unclear Detail And All Fastening Systems For All Elements Shall be Approved by The Supervisor.

Legend:

	SECTION NUMBER		ROOM CODE		FUNCTION
	REFERENCE SHEET NUMBER		AREA		ROOM ID
	DOOR NUMBER		REFERENCE DETAIL SHEET NUMBER		WINDOW NUMBER
	FLOOR FINISH LEVEL (F.F.L.)		REINFORCEMENT CONCRETE LEVEL (R.C.L.)		LEVEL SIGN IN PLAN
	STEEL SHEETS		ENTRANCE		ARTIFICIAL GRASS
	RC CONCRETE FOR COLUMNS		PORCELAIN TILES (PARQUET STYLE)		DEMOLISHING AND REMOVAL
	RC CONCRETE FOR WALLS		NEW INTERVENTION		
	CONCRETE				
	STONE WALL				
	HOLLOW BLOCKS				
	CEMENT TILE				
	PORCELAIN TILE				
	LOCAL MARBLE				
	Gypsum partition				
			R.C.L.: REN. CONCRETE LEVEL		F.F.L.: FINISH FLOOR LEVEL
					S.L.: SEA LEVEL

REVISIONS

NO.	DRAWINGS	DATE
(1)		
(2)		
(3)		

Contracting Authority:



Funded By:



Project Title:

“Public Works Contract for the rehabilitation of 5 schools in East Jerusalem”

Reference number: PSE22001-10074

Lot 1: the rehabilitation of Al-Hasan Al-Thany, Al-Shabbat Al-Shameleh, and Al-Fata Al-Laji'a schools in Wadi Al-Joz

Al-Shameleh Secondary Girls' school

Designed by:



Jerusalem - Sheikh Jarrah- Tobler8
email: mr.wasimhija@gmail.com
Tel. 02-9948344/ 052-8327076
Fax: 02-9948344


Drawing Title	Roof Epoxy Flooring	Date: 25/3/2025 Scale: 1:100
Designed by:	Arch. Hiba Al Ayoubi	Drawing No: A18
Checked by:	Arch. Wasim Abu El-Hija	
Approved by:		
Coordinate Manager:		

Hummer tone oil paint-
colors will be chosen by director of work

perforated galvanized Steel
4 mm panels with
round pattern
Height 2 m

4 mm Galvanized Steel
panels with
designed pattern


Existing tubes- to be painted
Existing Metal Mesh 15*5 cm

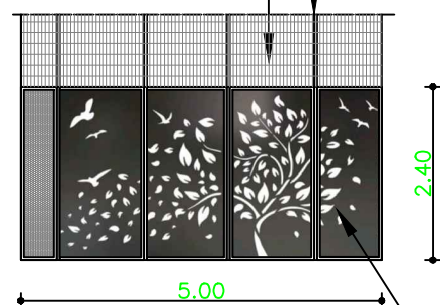


Detailed Section 5-5

4 mm Galvanized Steel
panels with
designed pattern with tube frame 20*20*2 mm

perforated galvanized Steel
4 mm panels with
round pattern
Height 2 m - frame 20*20*2 mm

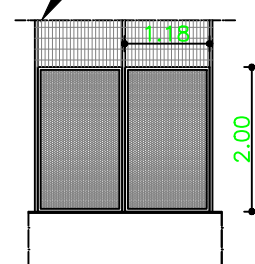

Bee Hive corrugated
polycarbonate sheet,
thickness (2.8 mm)
with slope 1%

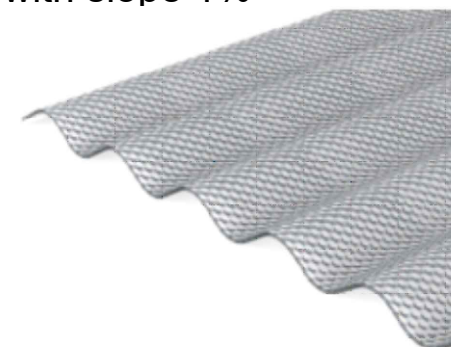


Colored Plaster

Notes

- (1) All Dimensions Are In M.
- (2) All Levels Are In Meter
- (3) Any Missing or Unclear Detail And All Fastening Systems For All Elements Shall be Approved by The Supervisor.

Legend:

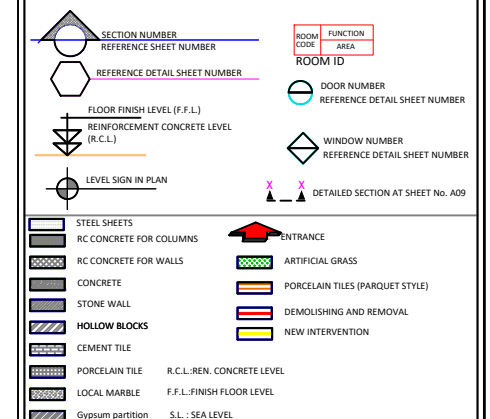

REVISIONS

NO.	DRAWINGS	DATE
(1)		
(2)		
(3)		

Contracting Authority:



Funded By:



Project Title:

"Public Works Contract for the rehabilitation
of 5 schools in East Jerusalem"

Reference number: PSE22001-10074

Lot 1: the rehabilitation of Al-Hasan
Al-Thany, Al-Shabbat Al-Shameleh, and
Al-Fata Al-Laji'a schools in Wadi Al-Joz


Al-Shameleh Secondary
Girls' school

Designed by:



Jerusalem - Sheikh Jarrah- Tobler8
email: mr.wasimhija@gmail.com
Tel. 02-9948344/ 052-8327076
Fax: 02-9948344

Drawing Title	Fence Design	Date: 25/3/2025 Scale: 1:100
Designed by:	Arch. Hiba Al Ayoubi	Drawing No:
Checked by:	Arch. Wasim Abu El-Hija	A19
Approved by:		
Coordinate Manager:		

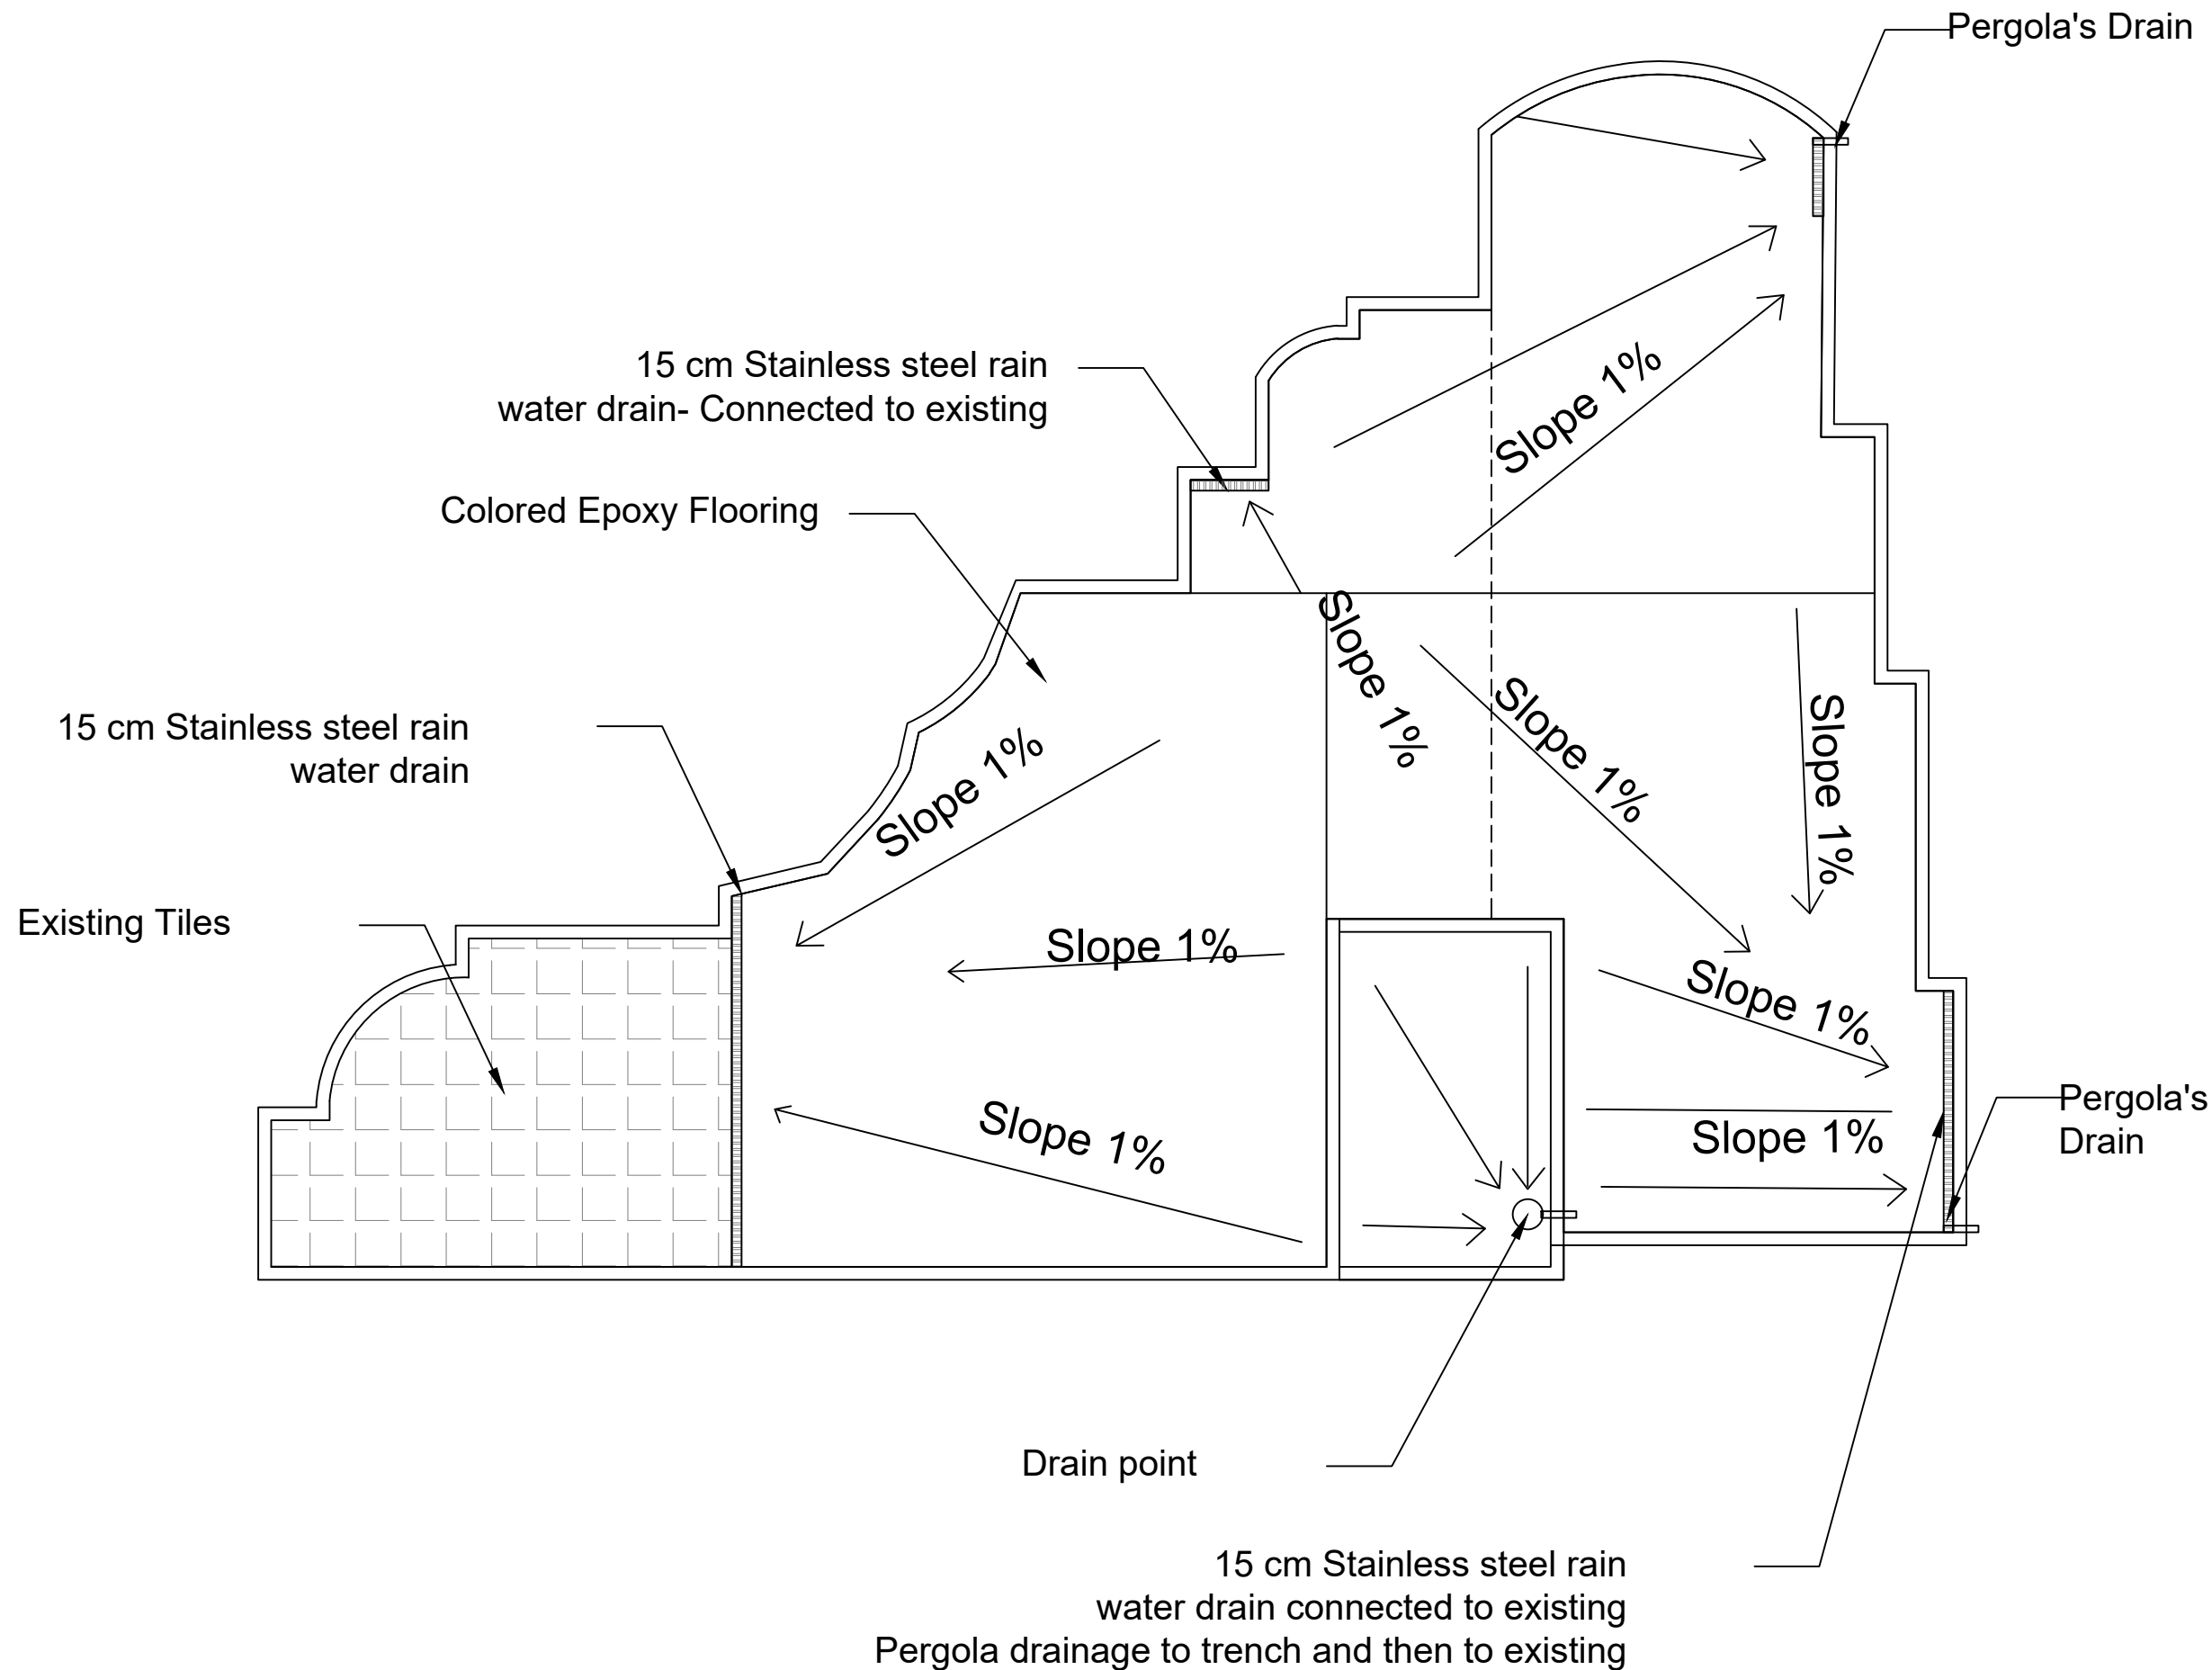

Notes

- (1) All Dimensions Are In M.
- (2) All Levels Are In Meter
- (3) Any Missing or Unclear Detail And All Fastening Systems For All Elements Shall be Approved by The Supervisor.

Legend:

	SECTION NUMBER		ROOM CODE		FUNCTION
	REFERENCE SHEET NUMBER		AREA		ROOM ID
	DOOR NUMBER		DOOR NUMBER		DOOR NUMBER
	WINDOW NUMBER		WINDOW NUMBER		WINDOW NUMBER
	LEVEL SIGN IN PLAN		DETAILED SECTION AT SHEET No. A09		DETAILED SECTION AT SHEET No. A09
	STEEL SHEETS		ENTRANCE		ARTIFICIAL GRASS
	RC CONCRETE FOR COLUMNS		PORCELAIN TILES (PARQUET STYLE)		DEMOLISHING AND REMOVAL
	RC CONCRETE FOR WALLS		NEW INTERVENTION		
	CONCRETE				
	STONE WALL				
	HOLLOW BLOCKS				
	CEMENT TILE				
	PORCELAIN TILE				
	LOCAL MARBLE				
	Gypsum partition				
	R.C.L.: REN. CONCRETE LEVEL				
	F.F.L.: FINISH FLOOR LEVEL				
	S.L.: SEA LEVEL				

REVISIONS

NO.	DRAWINGS	DATE
(1)		
(2)		
(3)		

Contracting Authority:



Funded By:



Project Title:

"Public Works Contract for the rehabilitation of 5 schools in East Jerusalem"

Reference number: PSE22001-10074

Lot 1: the rehabilitation of Al-Hasan Al-Thany, Al-Shabbat Al-Shameleh, and Al-Fata Al-Laji'a schools in Wadi Al-Joz

Al-Shameleh Secondary Girls' school

Designed by:



Jerusalem - Sheikh Jarrah- Tobler8
email: mr.wasimhija@gmail.com
Tel. 02-9948344/ 052-8327076
Fax: 02-9948344

Drawing Title	Roof Drainage	Date: 25/3/2025 Scale: 1:100
Designed by:	Arch. Hiba Al Ayoubi	Drawing No: A20
Checked by:	Arch. Wasim Abu El-Hija	
Approved by:		
Coordinate Manager:		

Lot1: Al-Shameleh Secondary Girls' school

ARCHITECTURAL DRAWINGS

Notes

(1) All Dimensions Are In M.
(2) All Levels Are In Meter
(3) Any Missing or Unclear Detail And All Fastening Systems For All Elements Shall be Approved by The Supervisor.

Legend:

SECTION NUMBER
REFERENCE SHEET NUMBER

REFERENCE DETAIL SHEET NUMBER

FLOOR FINISH LEVEL (F.F.L.)
REINFORCEMENT CONCRETE LEVEL (R.C.L.)

LEVEL SIGN IN PLAN

ROOM CODE
ROOM ID

DOOR NUMBER
REFERENCE DETAIL SHEET NUMBER

WINDOW NUMBER
REFERENCE DETAIL SHEET NUMBER

DETAILED SECTION AT SHEET No. A09

STEEL SHEETS

RC CONCRETE FOR COLUMNS

RC CONCRETE FOR WALLS

CONCRETE

STONE WALL

HOLLOW BLOCKS

CEMENT TILE

PORCELAIN TILE

LOCAL MARBLE

Gypsum partition

ENTRANCE

ARTIFICIAL GRASS

PORCELAIN TILES (PARQUET STYLE)

DEMOLISHING AND REMOVAL

NEW INTERVENTION

R.C.L.: REN. CONCRETE LEVEL
F.F.L.: FINISH FLOOR LEVEL
S.L.: SEA LEVEL

REVISIONS		
NO.	DRAWINGS	DATE
(1)		
(2)		
(3)		

Contracting Authority:



Funded By:



Project Title:

“Public Works Contract for the rehabilitation of 5 schools in East Jerusalem”

Reference number: PSE22001-10074

Lot 1: the rehabilitation of Al-Hasan Al-Thany, Al-Shabbat Al-Shameleh, and Al-Fata Al-Laji’a schools in Wadi Al-Joz

Al-Shameleh Secondary Girls' school

Designed by:




HOSH STUDIO
ARCHITECTURE & TOWN PLANNING

Jerusalem - Sheikh Jarrah- Tobler8
email: mr.wasimhija@gmail.com

Tel. 02-9948344/ 052-8327076
Fax: 02-9948344

Drawing Title	Scope of Intervention	Date: 25/3/2025 Scale: 1:100
Designed by:	Arch. Hiba Al Ayoubi	Drawing No: E00
Checked by:	Arch. Wasim Abu El-Hija	
Approved by:		
Coordinate Manager:		

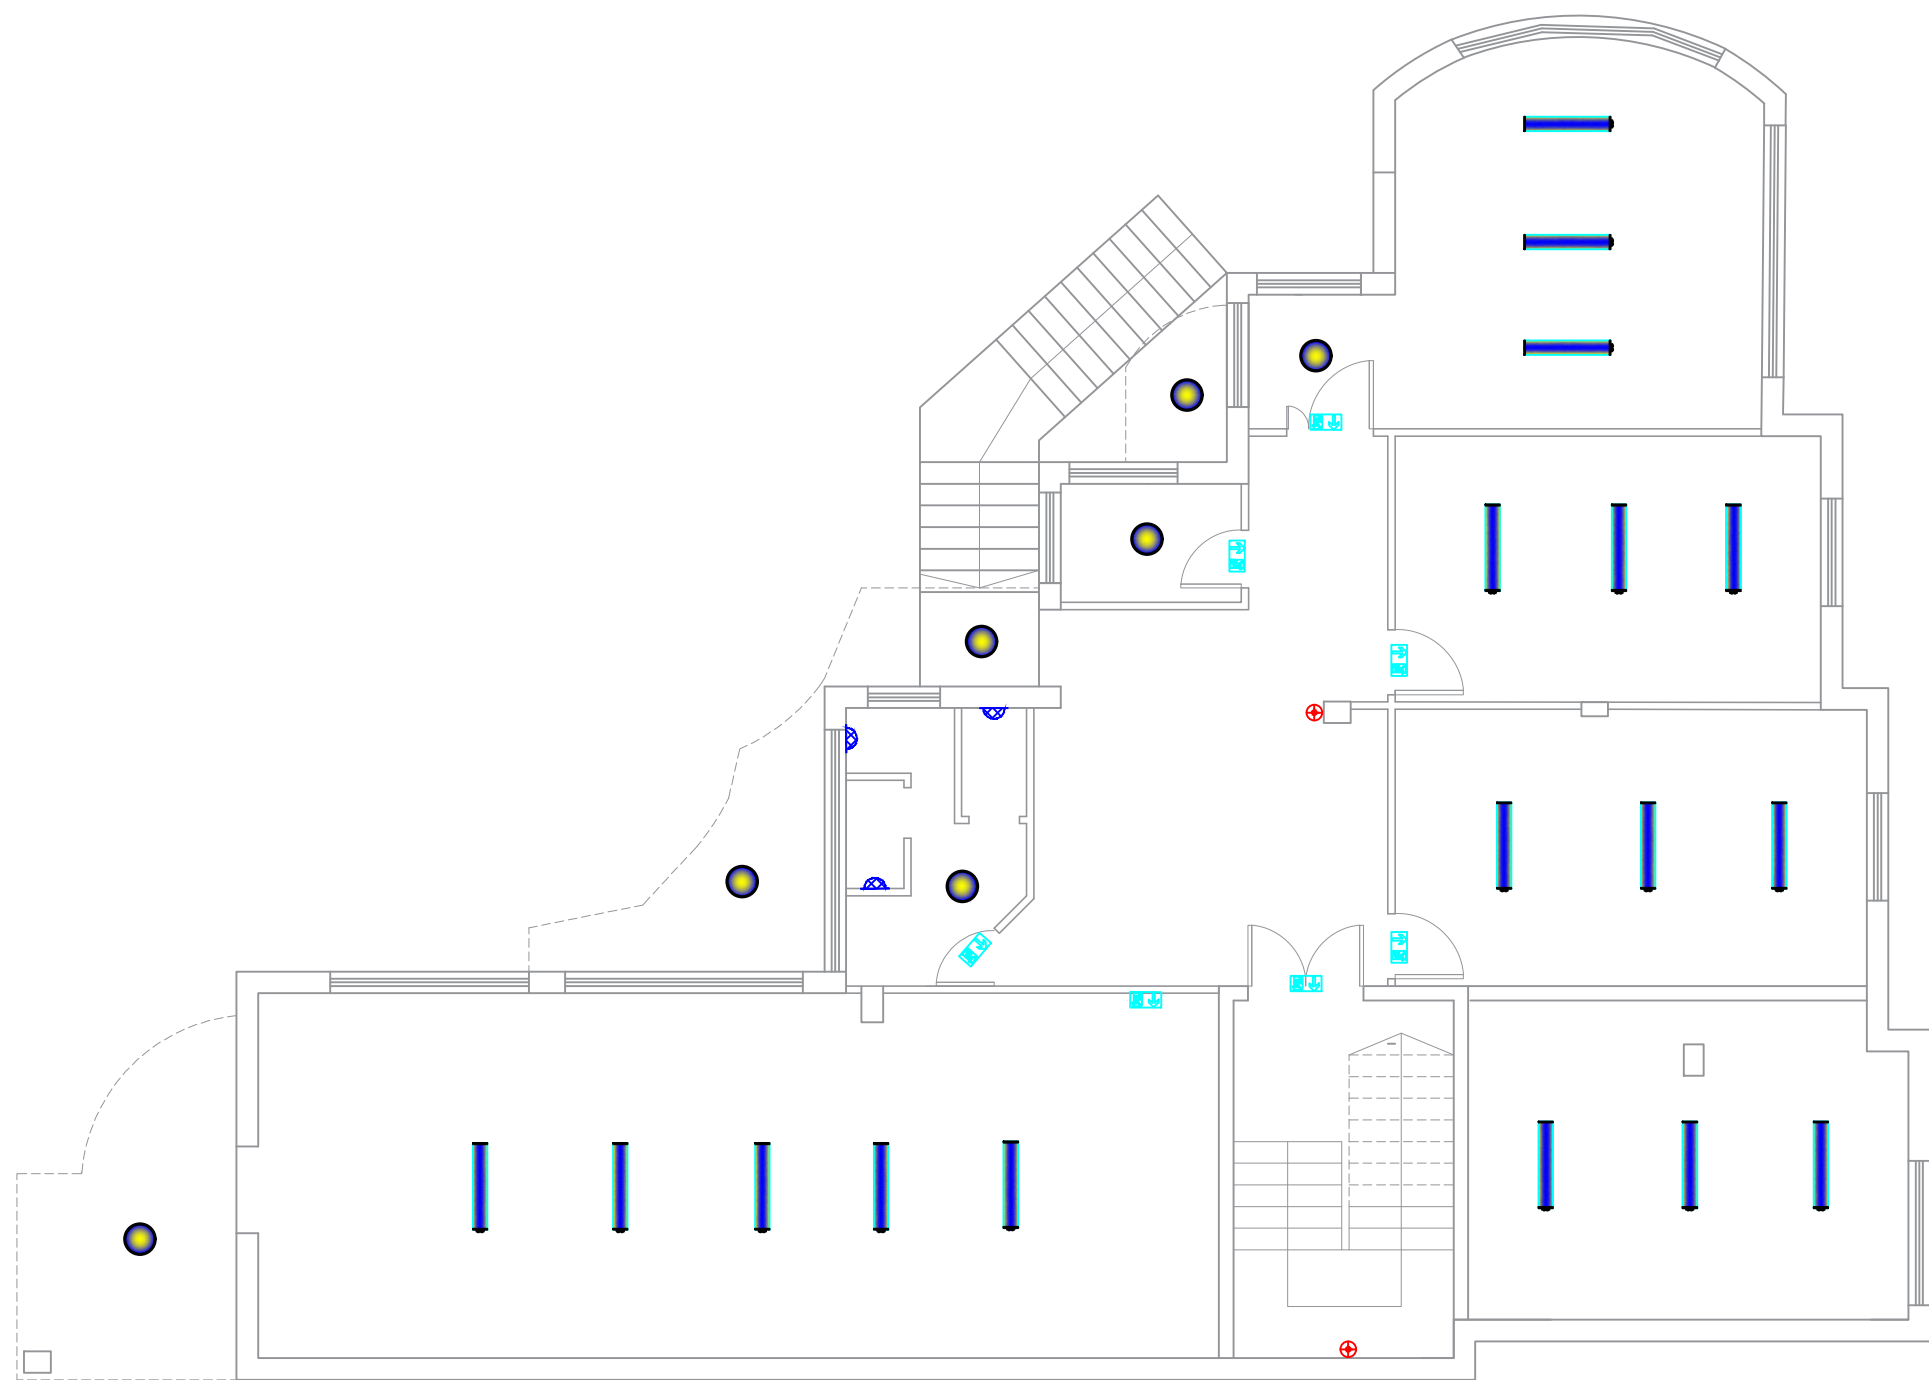

BASEMENT FLOOR

Notes

- (1) All Dimensions Are In M.
- (2) All Levels Are In Meter
- (3) Any Missing or Unclear Detail And All Fastening Systems For All Elements Shall be Approved by The Supervisor.

Legend:

	SECTION NUMBER		ROOM CODE		FUNCTION AREA
	REFERENCE SHEET NUMBER		ROOM ID		
	DOOR NUMBER				
	WINDOW NUMBER				
	FLOOR FINISH LEVEL (F.F.L.)				
	REINFORCEMENT CONCRETE LEVEL (R.C.L.)				
	LEVEL SIGN IN PLAN				
	DETAILED SECTION AT SHEET No. A09				

	STEEL SHEETS		ENTRANCE
	RC CONCRETE FOR COLUMNS		ARTIFICIAL GRASS
	RC CONCRETE FOR WALLS		PORCELAIN TILES (PARQUET STYLE)
	CONCRETE		DEMOLISHING AND REMOVAL
	STONE WALL		NEW INTERVENTION
	HOLLOW BLOCKS		
	CEMENT TILE		
	PORCELAIN TILE		
	LOCAL MARBLE		
	Gypsum partition		

	R.C.L.: REN. CONCRETE LEVEL
	F.F.L.: FINISH FLOOR LEVEL
	S.L.: SEA LEVEL

REVISIONS

NO.	DRAWINGS	DATE
(1)		
(2)		
(3)		

Contracting Authority:



Funded By:



Project Title:

“Public Works Contract for the rehabilitation of 5 schools in East Jerusalem”

Reference number: PSE22001-10074

Lot 1: the rehabilitation of Al-Hasan Al-Thany, Al-Shabbat Al-Shameleh, and Al-Fata Al-Laji’a schools in Wadi Al-Joz


Al-Shameleh Secondary Girls' school

Designed by:



Jerusalem - Sheikh Jarrah- Tobler8
email: mr.wasimhija@gmail.com
Tel. 02-9948344/ 052-8327076
Fax: 02-9948344

Drawing Title	Scope of Intervention	Date: 25/3/2025
	LIGHTING SYSTEM	Scale: 1:100
Designed by:	Arch. Hiba Al Ayoubi	Drawing No:
Checked by:	Arch. Wasim Abu El-Hija	E20
Approved by:		
Coordinate Manager:		

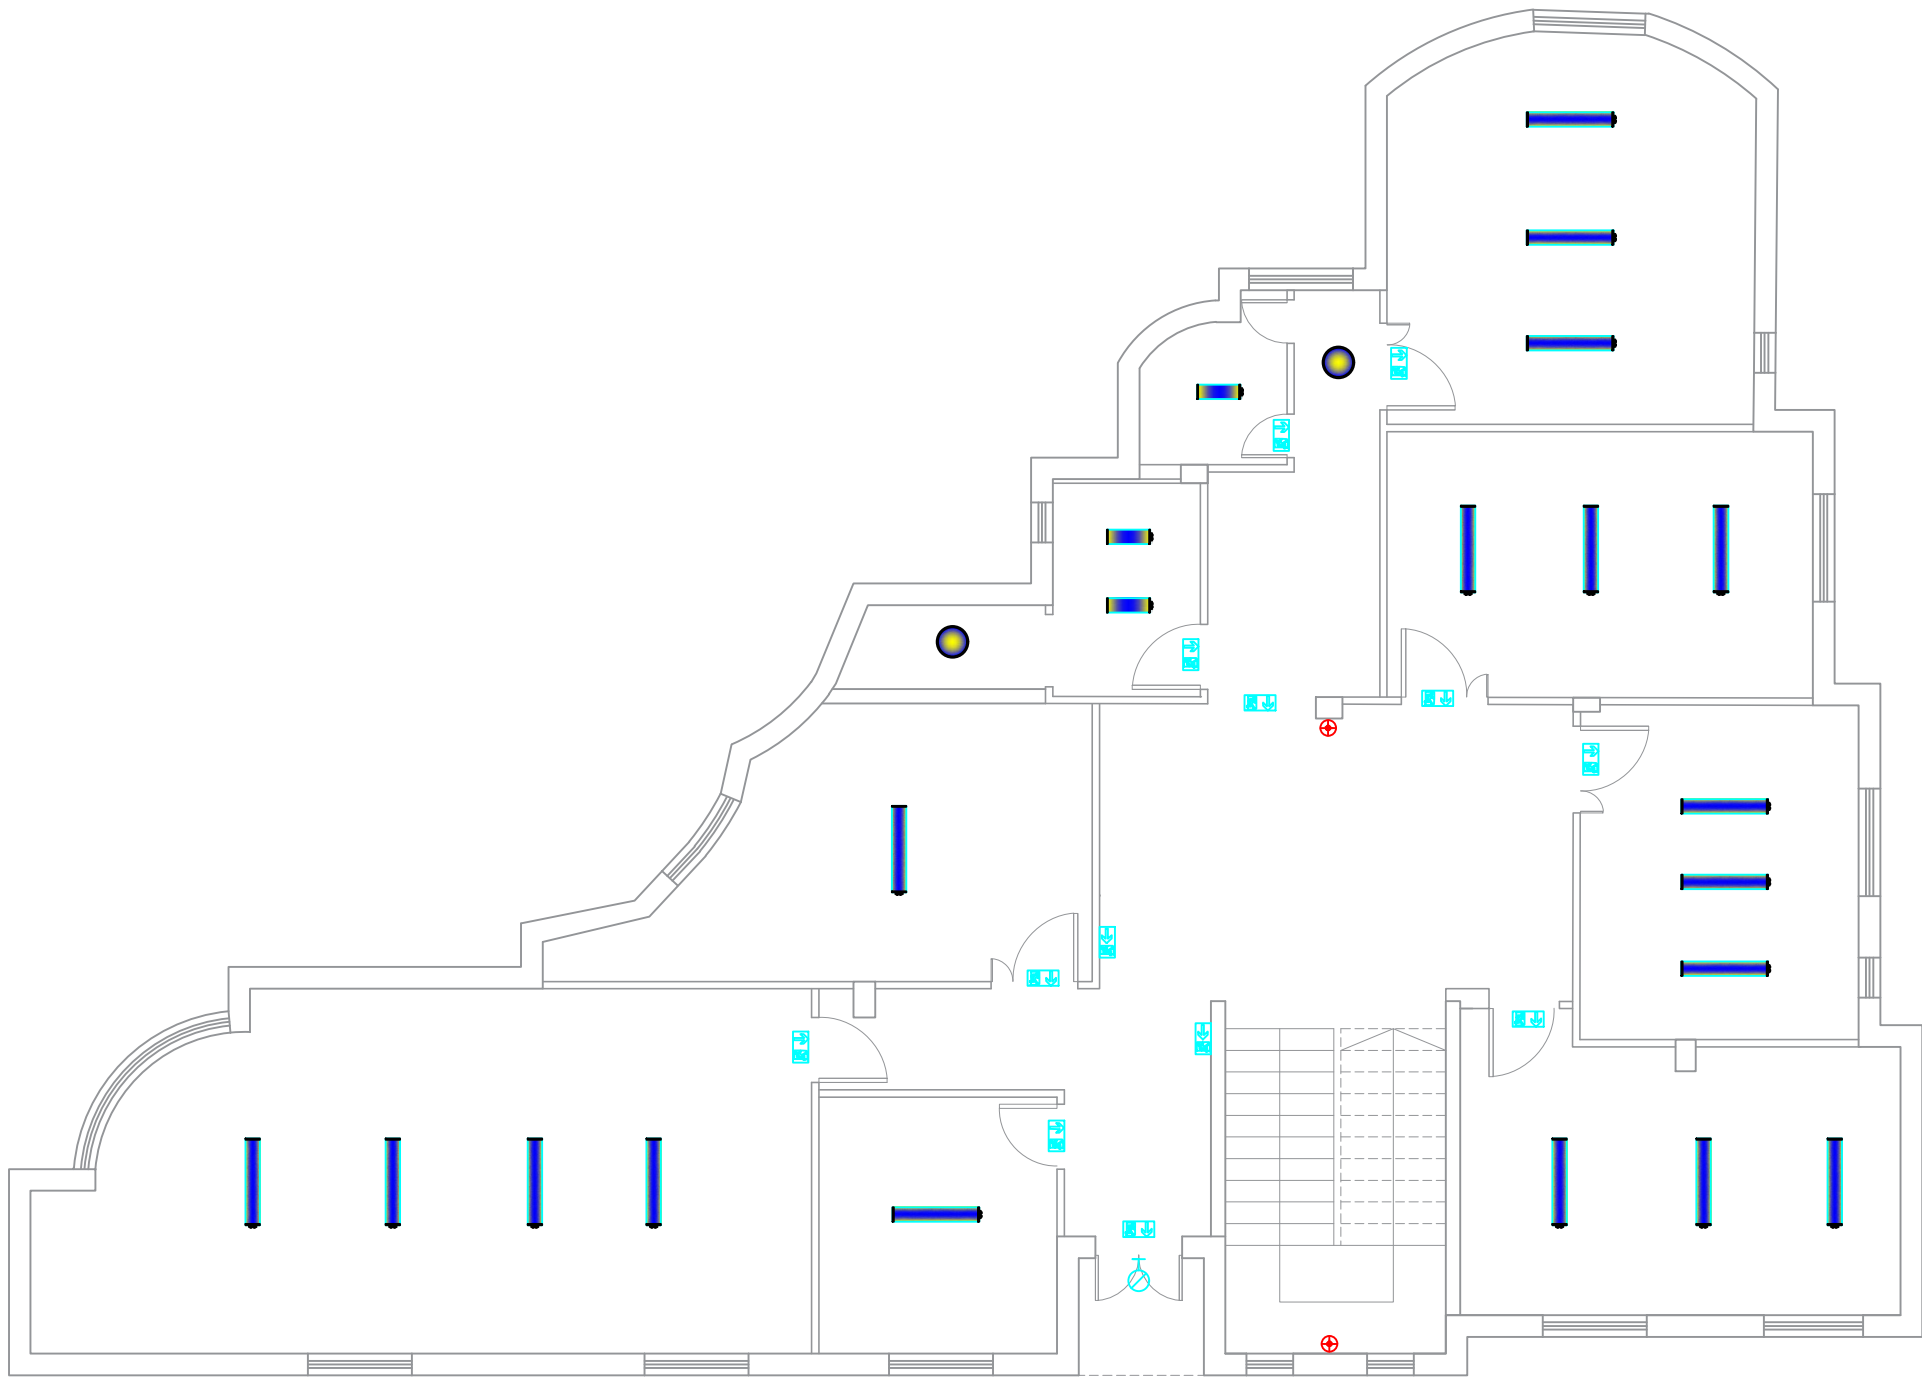

GROUND FLOOR

- Notes
- (1) All Dimensions Are In M.

(2) All Levels Are In Meter

(3) Any Missing or Unclear Detail And All Fastening Systems For All Elements Shall be Approved by The Supervisor.

Legend:

SECTION NUMBER

REFERENCE SHEET NUMBER

REFERENCE DETAIL SHEET NUMBER

FLOOR FINISH LEVEL (F.F.L.)

REINFORCEMENT CONCRETE LEVEL (R.C.L.)

LEVEL SIGN IN PLAN

ROOM CODE

FUNCTION AREA

ROOM ID

DOOR NUMBER

REFERENCE DETAIL SHEET NUMBER

WINDOW NUMBER

REFERENCE DETAIL SHEET NUMBER

ENTRANCE

ARTIFICIAL GRASS

PORCELAIN TILES (PARQUET STYLE)

DEMOLISHING AND REMOVAL

NEW INTERVENTION

STEEL SHEETS

RC CONCRETE FOR COLUMNS

RC CONCRETE FOR WALLS

CONCRETE

STONE WALL

HOLLOW BLOCKS

CEMENT TILE

PORCELAIN TILE

LOCAL MARBLE

Gypsum partition

R.C.L.:REN. CONCRETE LEVEL

F.F.L.:FINISH FLOOR LEVEL

S.L.: SEA LEVEL

REVISIONS

NO.	DRAWINGS	DATE
(1)		
(2)		
(3)		

Contracting Authority:

Funded By:

Project Title:

“Public Works Contract for the rehabilitation of 5 schools in East Jerusalem”

Reference number: PSE22001-10074

Lot 1: the rehabilitation of Al-Hasan Al-Thany, Al-Shabbat Al-Shameleh, and Al-Fata Al-Laji’a schools in Wadi Al-Joz

Al-Shameleh Secondary Girls' school

Designed by:


Jerusalem - Sheikh Jarrah- Tobler8

email: mr.wasimhija@gmail.com

Tel. 02-9948344/ 052-8327076

Fax: 02-9948344

Drawing Title	Scope of Intervention	Date: 25/3/2025
	LIGHTING SYSTEM	Scale: 1:100
Designed by:	Arch. Hiba Al Ayoubi	Drawing No: E21
Checked by:	Arch. Wasim Abu El-Hija	
Approved by:		
Coordinate Manager:		

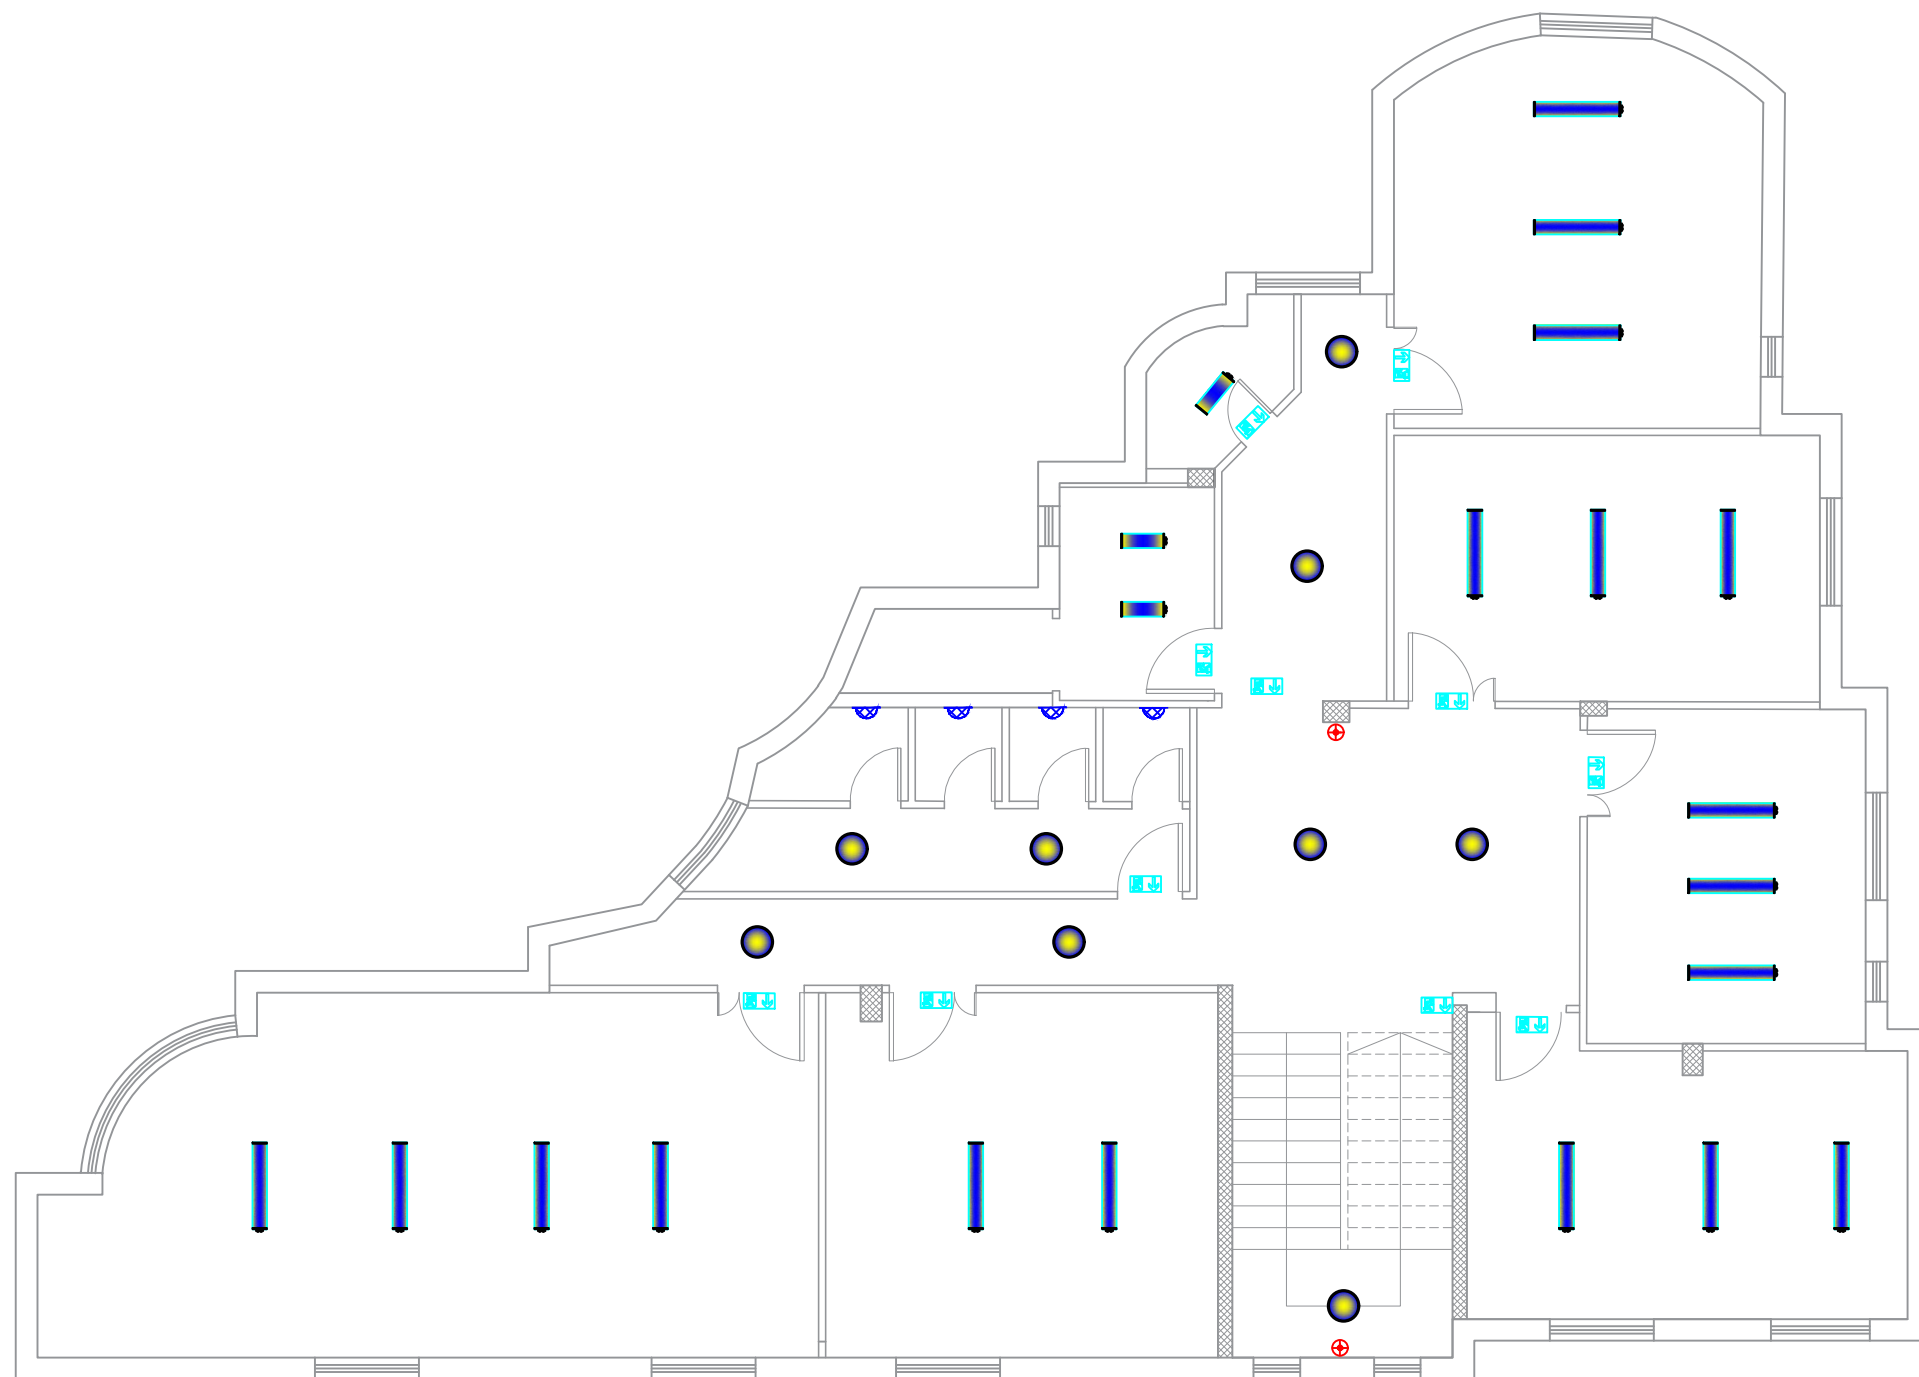

FIRST FLOOR &

Notes

- (1) All Dimensions Are In M.
- (2) All Levels Are In Meter
- (3) Any Missing or Unclear Detail And All Fastening Systems For All Elements Shall be Approved by The Supervisor.

Legend:

SECTION NUMBER
REFERENCE SHEET NUMBER
REFERENCE DETAIL SHEET NUMBER
FLOOR FINISH LEVEL (F.F.L.)
REINFORCEMENT CONCRETE LEVEL (R.C.L.)
LEVEL SIGN IN PLAN

ROOM CODE
FUNCTION AREA
ROOM ID
DOOR NUMBER
REFERENCE DETAIL SHEET NUMBER
WINDOW NUMBER
REFERENCE DETAIL SHEET NUMBER
DETAILED SECTION AT SHEET No. A09

STEEL SHEETS
RC CONCRETE FOR COLUMNS
RC CONCRETE FOR WALLS
CONCRETE
STONE WALL
HOLLOW BLOCKS
CEMENT TILE
PORCELAIN TILE
LOCAL MARBLE
Gypsum partition

ENTRANCE
ARTIFICIAL GRASS
PORCELAIN TILES (PARQUET STYLE)
DEMOLISHING AND REMOVAL
NEW INTERVENTION

R.C.L.: REN. CONCRETE LEVEL
F.F.L.: FINISH FLOOR LEVEL
S.L.: SEA LEVEL

REVISIONS

NO.	DRAWINGS	DATE
(1)		
(2)		
(3)		

Contracting Authority:



Funded By:



Project Title:

“Public Works Contract for the rehabilitation of 5 schools in East Jerusalem”

Reference number: PSE22001-10074

Lot 1: the rehabilitation of Al-Hasan Al-Thany, Al-Shabbat Al-Shameleh, and Al-Fata Al-Laji’a schools in Wadi Al-Joz


Al-Shameleh Secondary Girls' school

Designed by:



Jerusalem - Sheikh Jarrah- Tobler8
email: mr.wasimhija@gmail.com
Tel. 02-9948344/ 052-8327076
Fax: 02-9948344

Drawing Title	Scope of Intervention	Date: 25/3/2025 Scale: 1:100
Designed by:	Arch. Hiba Al Ayoubi	Drawing No: E22
Checked by:	Arch. Wasim Abu El-Hija	
Approved by:		
Coordinate Manager:		

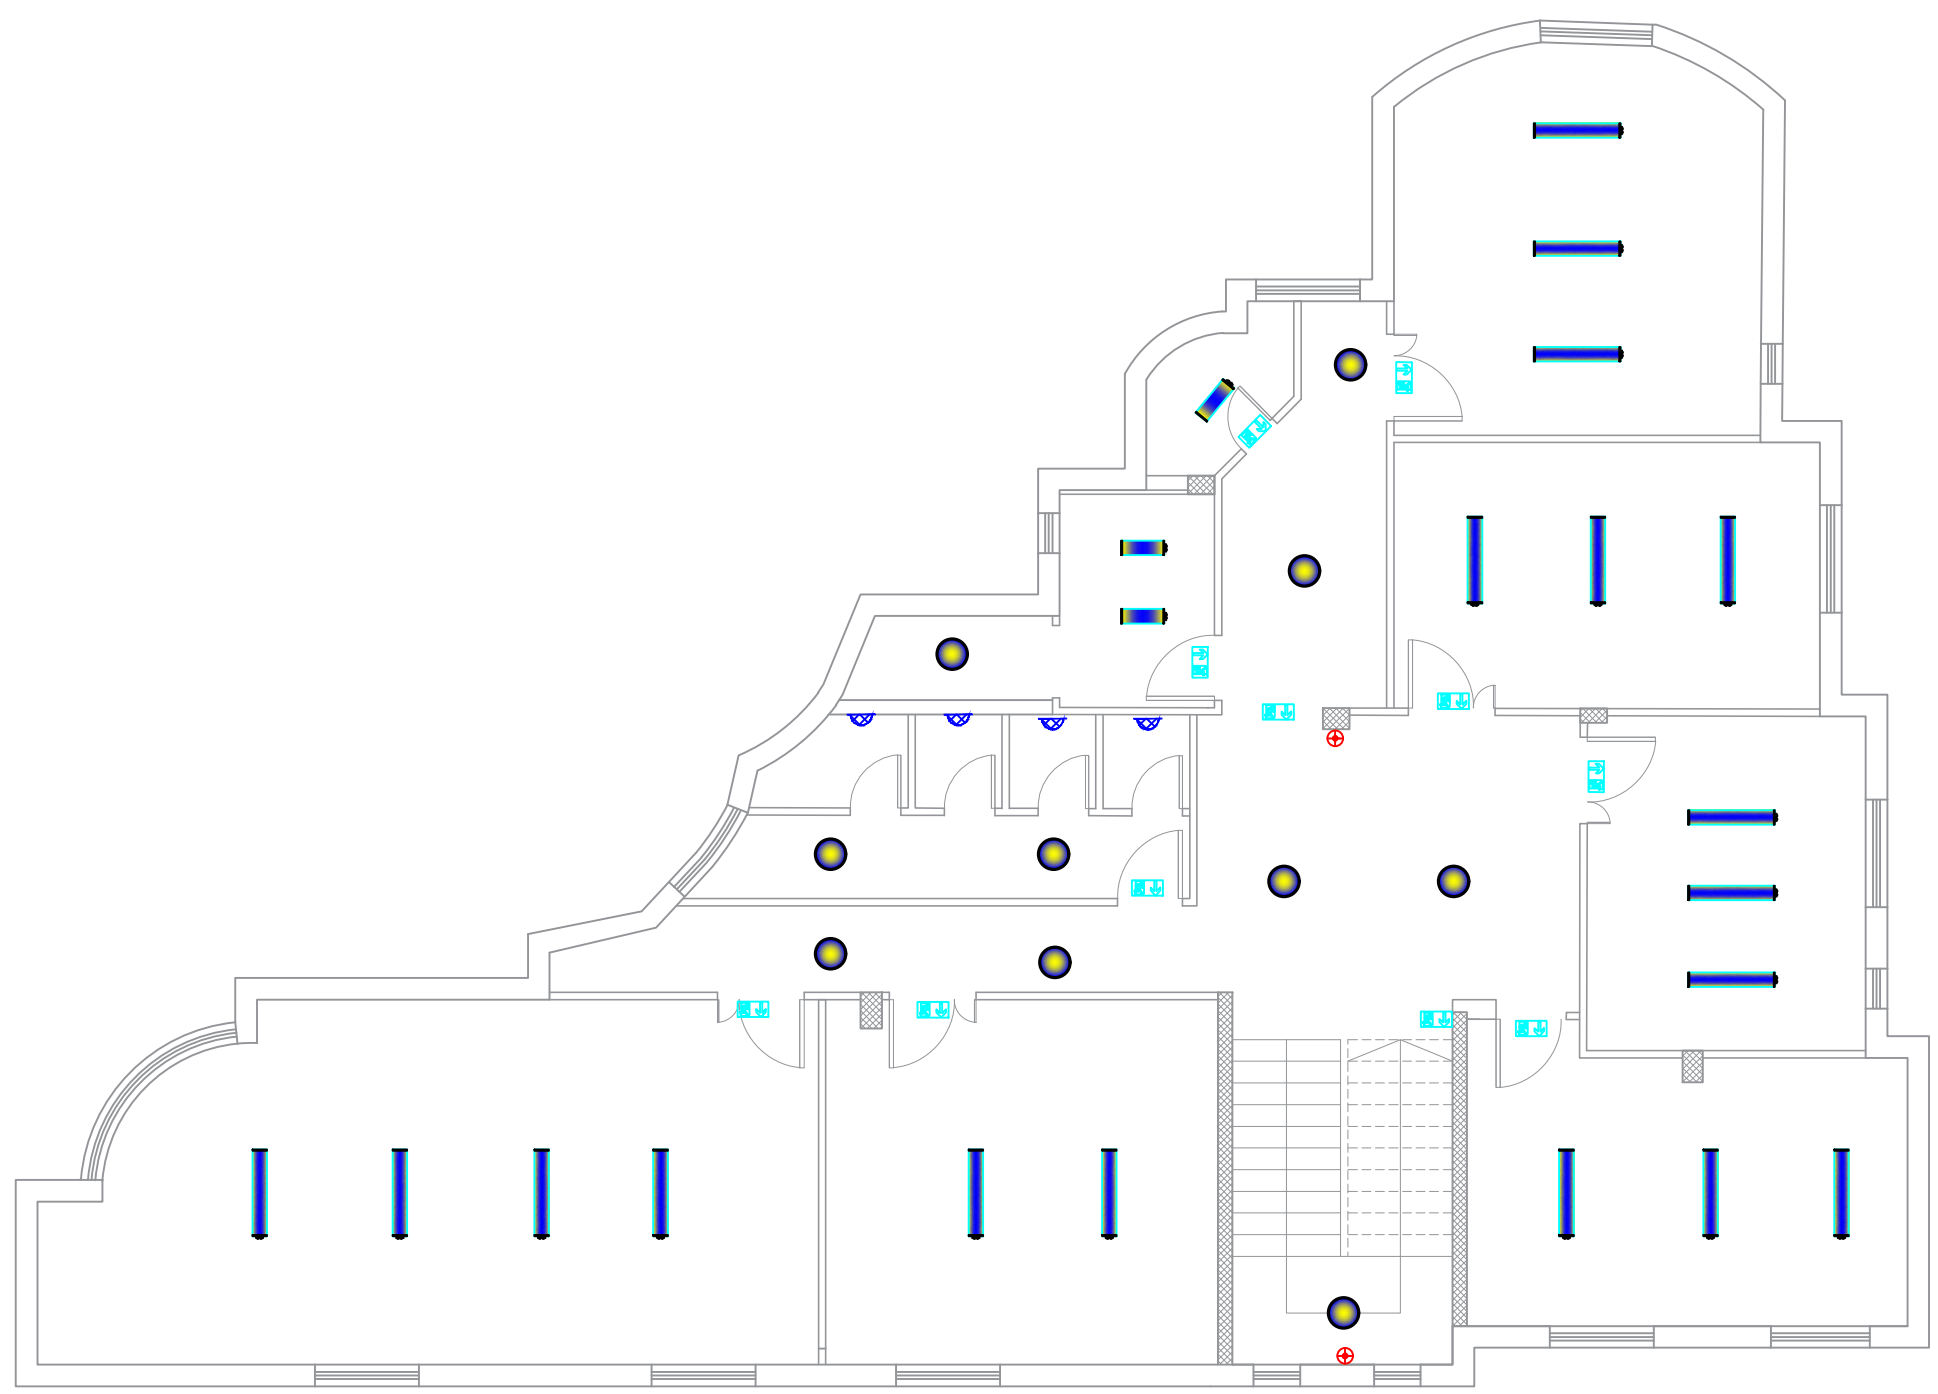

SECOND FLOOR

Notes

(1) All Dimensions Are In M.
(2) All Levels Are In Meter
(3) Any Missing or Unclear Detail And All Fastening Systems For All Elements Shall be Approved by The Supervisor.

Legend:

SECTION NUMBER
REFERENCE SHEET NUMBER

DOOR NUMBER
REFERENCE DETAIL SHEET NUMBER

WINDOW NUMBER
REFERENCE DETAIL SHEET NUMBER

LEVEL SIGN IN PLAN

STEEL SHEETS

RC CONCRETE FOR COLUMNS

RC CONCRETE FOR WALLS

CONCRETE

STONE WALL

HOLLOW BLOCKS

CEMENT TILE

PORCELAIN TILE

LOCAL MARBLE

Gypsum partition

ENTRANCE

ARTIFICIAL GRASS

PORCELAIN TILES (PARQUET STYLE)

DEMOLISHING AND REMOVAL

NEW INTERVENTION

R.C.L.:REN. CONCRETE LEVEL

F.F.L.:FINISH FLOOR LEVEL

S.L. : SEA LEVEL

REVISIONS		
NO.	DRAWINGS	DATE
(1)		
(2)		
(3)		

Contracting Authority:

Funded By:

Project Title:

“Public Works Contract for the rehabilitation of 5 schools in East Jerusalem”

Reference number: PSE22001-10074

Lot 1: the rehabilitation of Al-Hasan Al-Thany, Al-Shabbat Al-Shameleh, and Al-Fata Al-Laji’a schools in Wadi Al-Joz


Al-Shameleh Secondary Girls' school

Designed by:

Jerusalem - Sheikh Jarrah- Tobler8
email: mr.wasimhija@gmail.com

Tel. 02-9948344/ 052-8327076
Fax: 02-9948344

Drawing Title	Scope of Intervention	Date: 25/3/2025 Scale: 1:100
Designed by:	Arch. Hiba Al Ayoubi	Drawing No: E23
Checked by:	Arch. Wasim Abu El-Hija	
Approved by:		
Coordinate Manager:		

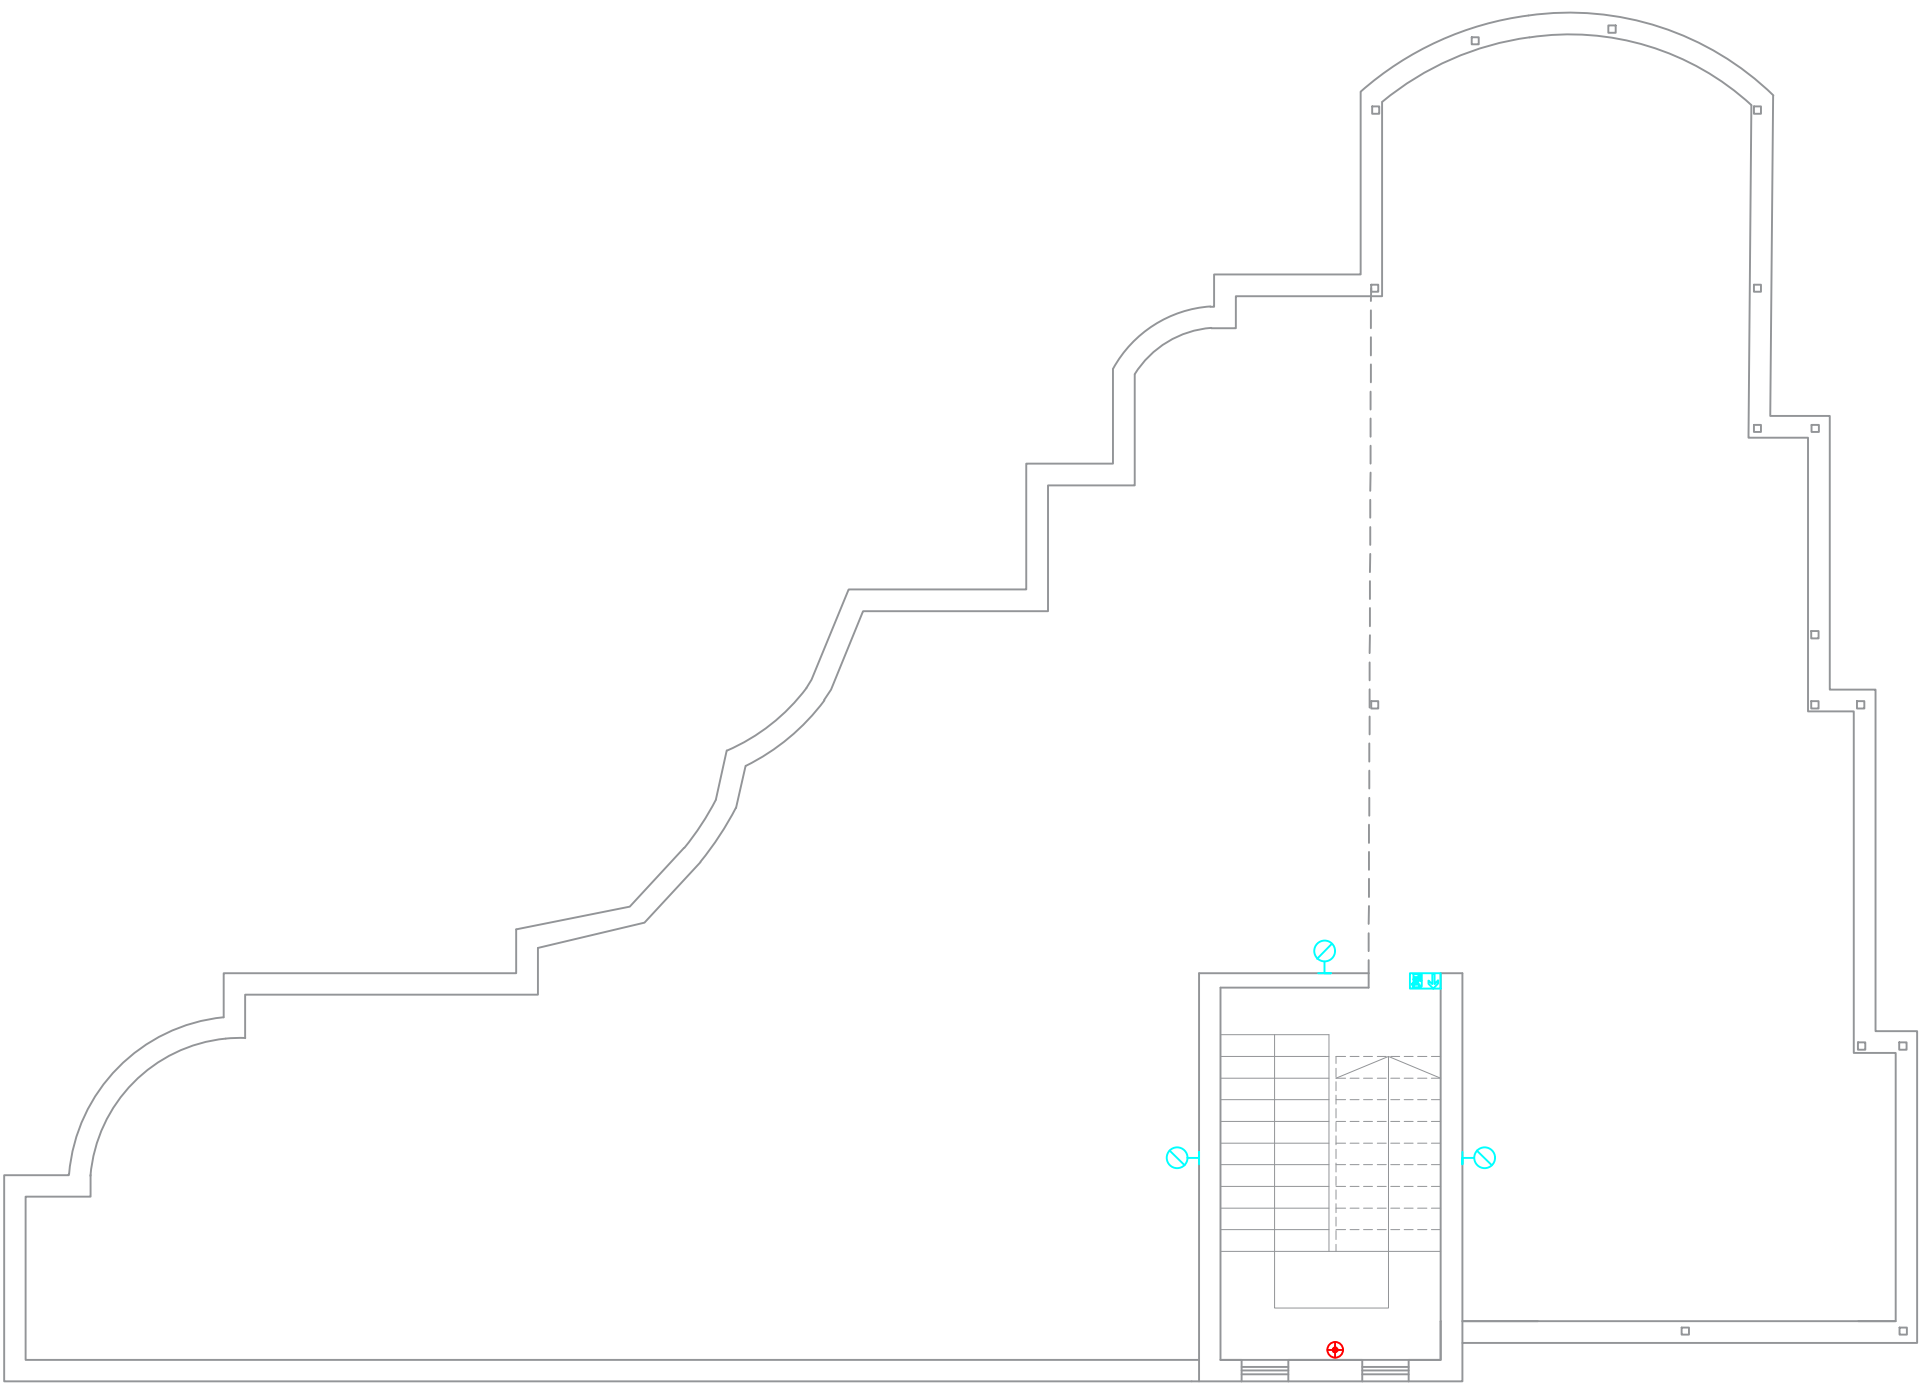

ROOF FLOOR PLAN

Notes

(1) All Dimensions Are In M.
(2) All Levels Are In Meter
(3) Any Missing or Unclear Detail And All Fastening Systems For All Elements Shall be Approved by The Supervisor.

Legend:

SECTION NUMBER
REFERENCE SHEET NUMBER

REFERENCE DETAIL SHEET NUMBER

FLOOR FINISH LEVEL (F.F.L.)
REINFORCEMENT CONCRETE LEVEL (R.C.L.)

LEVEL SIGN IN PLAN

ROOM CODE
FUNCTION
AREA
ROOM ID

DOOR NUMBER
REFERENCE DETAIL SHEET NUMBER

WINDOW NUMBER
REFERENCE DETAIL SHEET NUMBER

DETAILED SECTION AT SHEET No. A09

STEEL SHEETS

RC CONCRETE FOR COLUMNS

RC CONCRETE FOR WALLS

CONCRETE

STONE WALL

HOLLOW BLOCKS

CEMENT TILE

PORCELAIN TILE

LOCAL MARBLE

Gypsum partition

ENTRANCE

ARTIFICIAL GRASS

PORCELAIN TILES (PARQUET STYLE)

DEMOLISHING AND REMOVAL

NEW INTERVENTION

R.C.L.:REN. CONCRETE LEVEL

F.F.L.:FINISH FLOOR LEVEL

S.L. : SEA LEVEL

REVISIONS		
NO.	DRAWINGS	DATE
(1)		
(2)		
(3)		

Contracting Authority:

Funded By:

Belgium
partner in development

Project Title:

“Public Works Contract for the rehabilitation of 5 schools in East Jerusalem”

Reference number: PSE22001-10074

Lot 1: the rehabilitation of Al-Hasan Al-Thany, Al-Shabbat Al-Shameleh, and Al-Fata Al-Laji’a schools in Wadi Al-Joz

Al-Shameleh Secondary Girls' school


Designed by:

HOSH STUDIO
ARCHITECTURE & TOWN PLANNING

Jerusalem - Sheikh Jarrah- Tobler8
email: mr.wasimhija@gmail.com

Tel. 02-9948344/ 052-8327076
Fax: 02-9948344

Drawing Title	Scope of Intervention LIGHTING SYSTEM	Date: 25/3/2025 Scale: 1:100
Designed by:	Arch. Hiba Al Ayoubi	Drawing No: E24
Checked by:	Arch. Wasim Abu El-Hija	
Approved by:		
Coordinate Manager:		

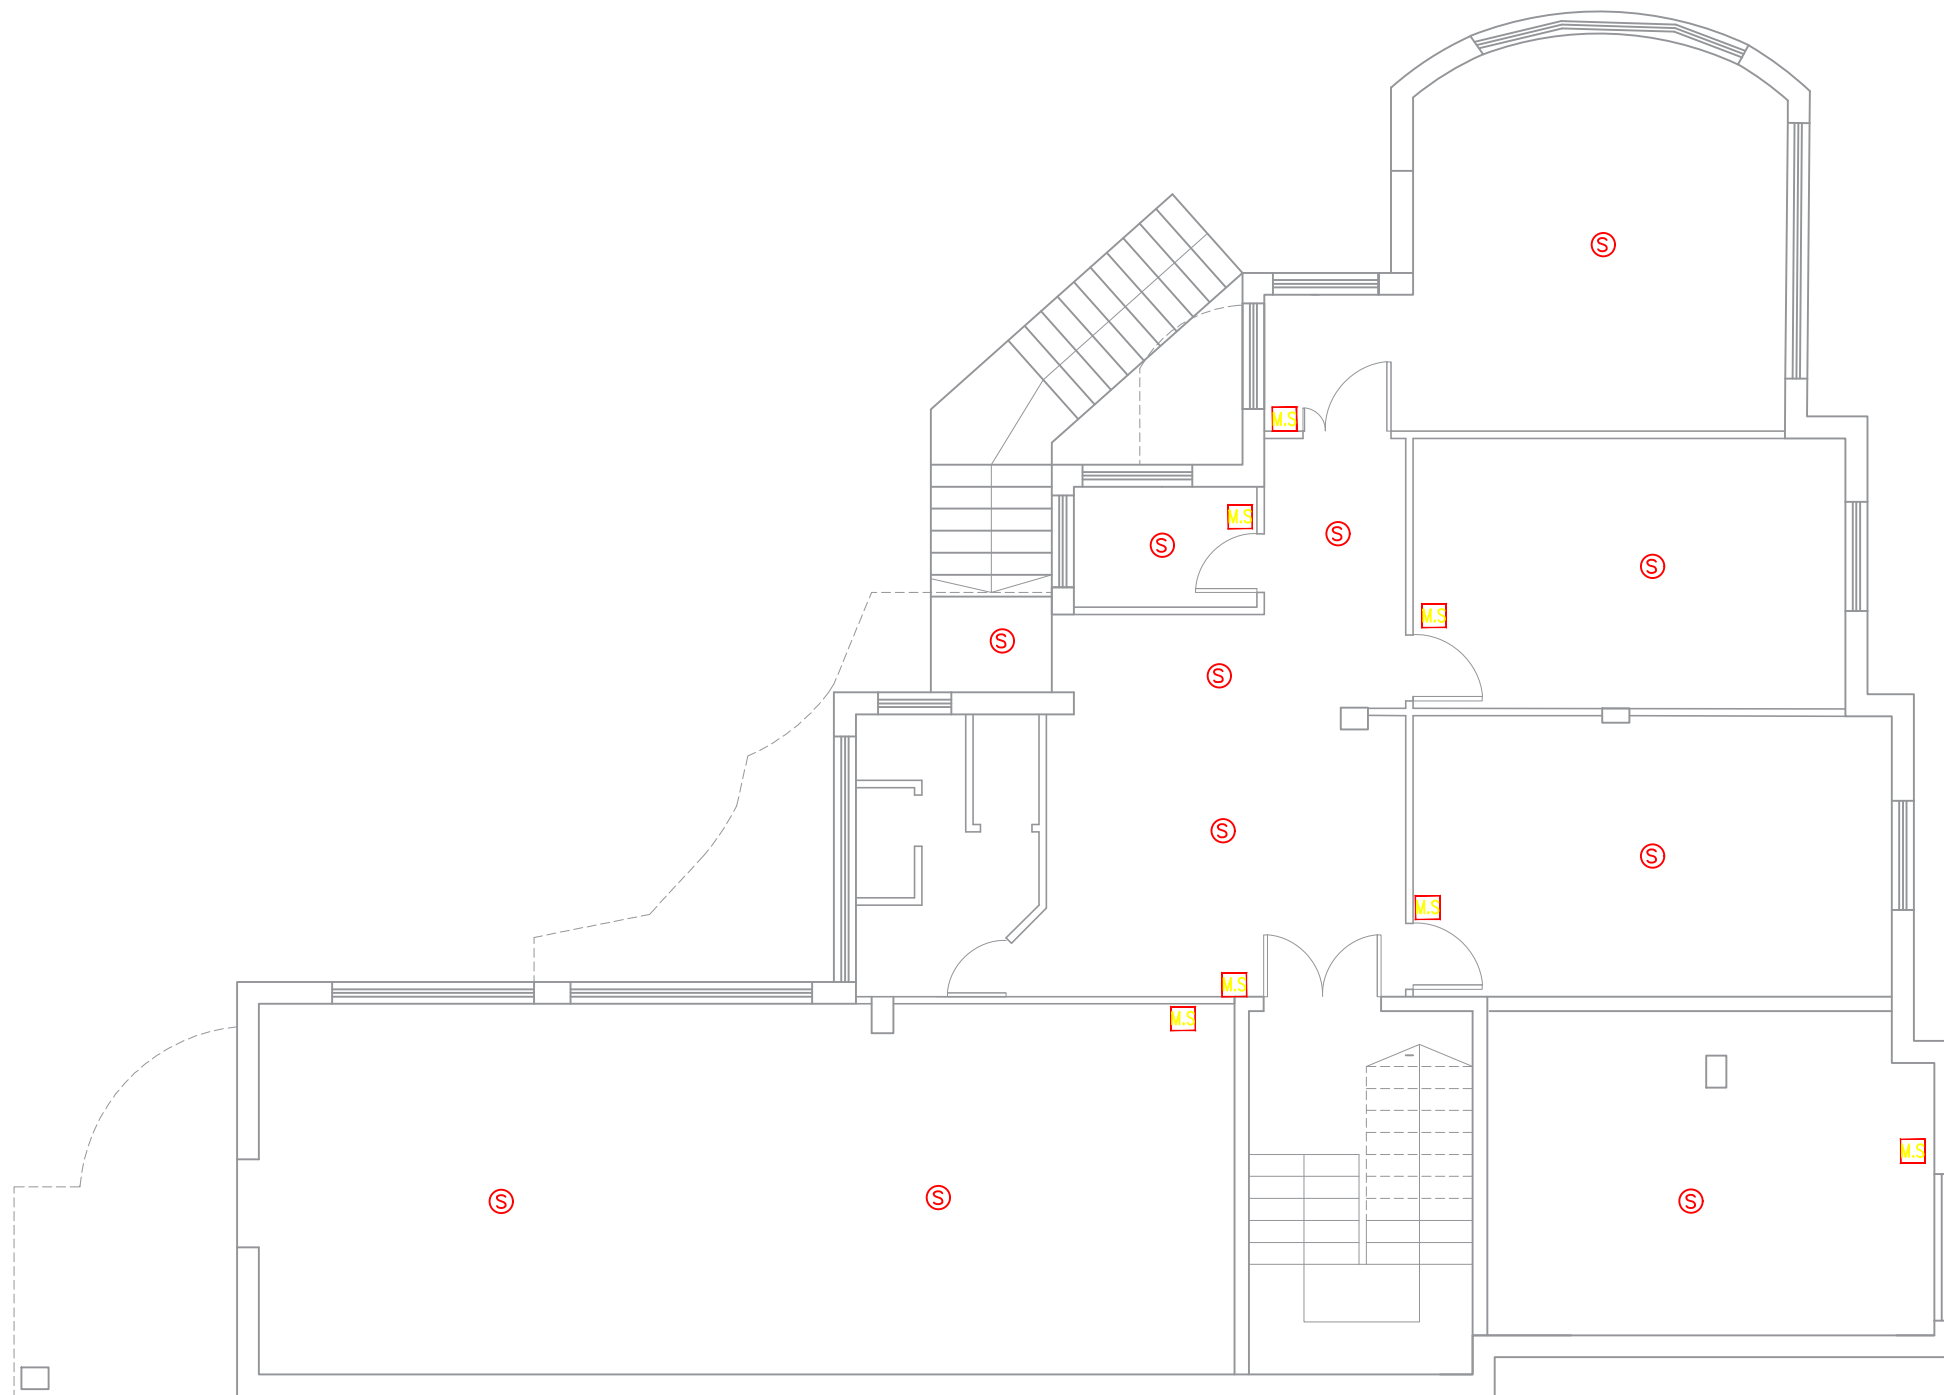

BASEMENT FLOOR

Notes

(1) All Dimensions Are In M.
(2) All Levels Are In Meter
(3) Any Missing or Unclear Detail And All Fastening Systems For All Elements Shall be Approved by The Supervisor.

Legend:

SECTION NUMBER

REFERENCE SHEET NUMBER

REFERENCE DETAIL SHEET NUMBER

FLOOR FINISH LEVEL (F.F.L.)

REINFORCEMENT CONCRETE LEVEL (R.C.L.)

LEVEL SIGN IN PLAN

ROOM

FUNCTION

ROOM ID

DOOR NUMBER

REFERENCE DETAIL SHEET NUMBER

WINDOW NUMBER

REFERENCE DETAIL SHEET NUMBER

DETAILED SECTION AT SHEET No. A09

STEEL SHEETS

RC CONCRETE FOR COLUMNS

RC CONCRETE FOR WALLS

CONCRETE

STONE WALL

HOLLOW BLOCKS

CEMENT TILE

PORCELAIN TILE

LOCAL MARBLE

Gypsum partition

ENTRANCE

ARTIFICIAL GRASS

PORCELAIN TILES (PARQUET STYLE)

DEMOLISHING AND REMOVAL

NEW INTERVENTION

R.C.L.:REN. CONCRETE LEVEL

F.F.L.:FINISH FLOOR LEVEL

S.L. : SEA LEVEL

REVISIONS		
NO.	DRAWINGS	DATE
(1)		
(2)		
(3)		

Contracting Authority:

Funded By:

Project Title:

“Public Works Contract for the rehabilitation of 5 schools in East Jerusalem”

Reference number: PSE22001-10074

Lot 1: the rehabilitation of Al-Hasan Al-Thany, Al-Shabbat Al-Shameleh, and Al-Fata Al-Laji’a schools in Wadi Al-Joz

Al-Shameleh Secondary Girls' school


Designed by:

HOSH STUDIO
ARCHITECTURE & TOWN PLANNING

Jerusalem - Sheikh Jarrah- Tobler8
email: mr.wasimhija@gmail.com

Tel. 02-9948344/ 052-8327076
Fax: 02-9948344

Drawing Title	Scope of Intervention	Date: 25/3/2025 Scale: 1:100
Designed by:	Arch. Hiba Al Ayoubi	Drawing No:
Checked by:	Arch. Wasim Abu El-Hija	E25
Approved by:		
Coordinate Manager:		

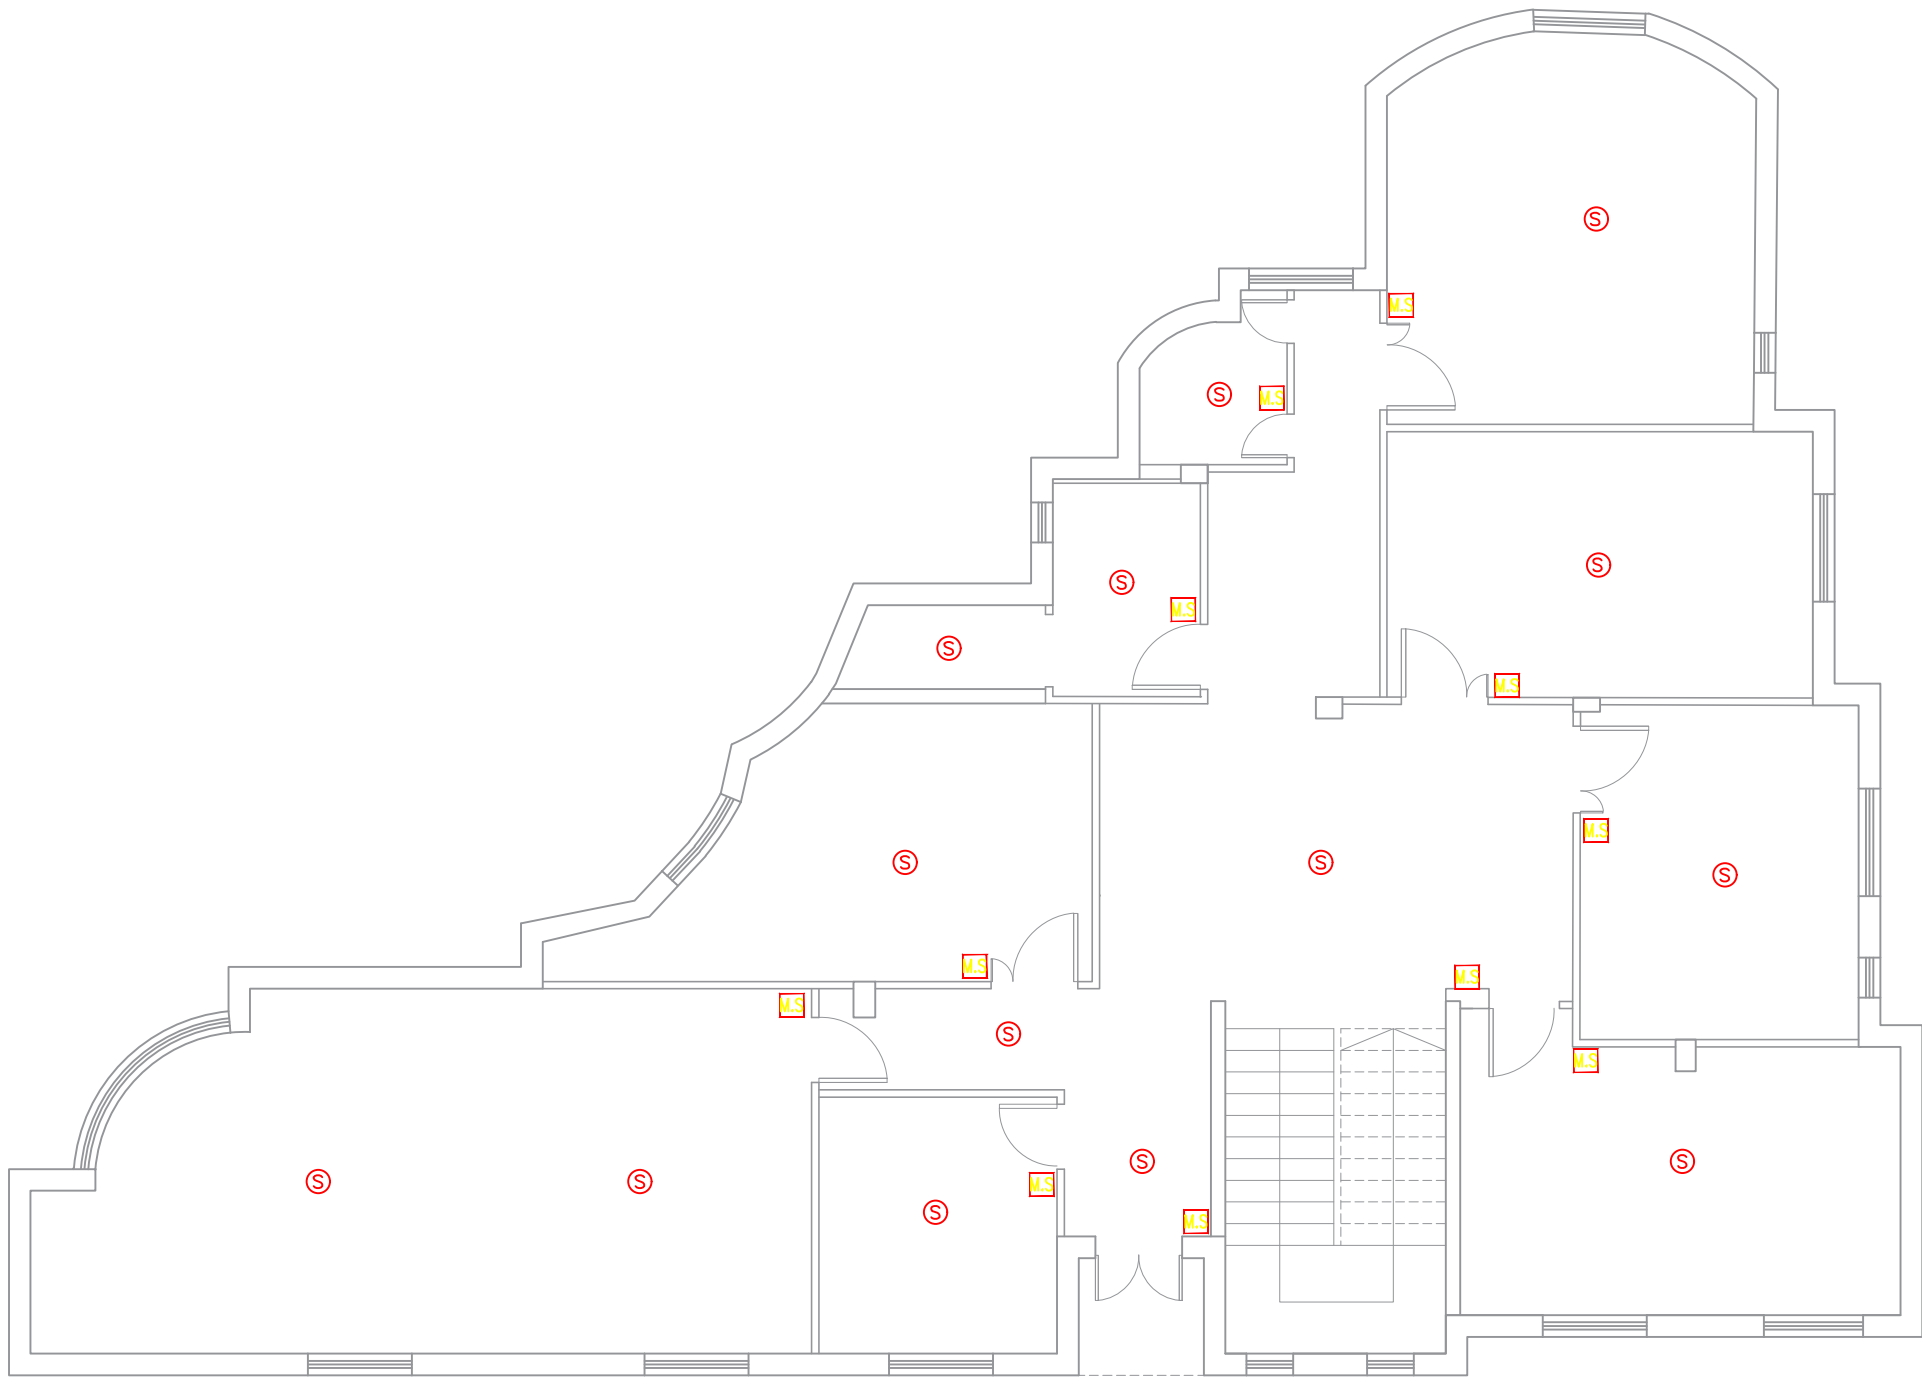

GROUND FLOOR

Notes

(1) All Dimensions Are In M.
(2) All Levels Are In Meter
(3) Any Missing or Unclear Detail And All Fastening Systems For All Elements Shall be Approved by The Supervisor.

Legend:

SECTION NUMBER
REFERENCE SHEET NUMBER

REFERENCE DETAIL SHEET NUMBER

FLOOR FINISH LEVEL (F.F.L.)
REINFORCEMENT CONCRETE LEVEL (R.C.L.)

LEVEL SIGN IN PLAN

STEEL SHEETS

RC CONCRETE FOR COLUMNS

RC CONCRETE FOR WALLS

CONCRETE

STONE WALL

HOLLOW BLOCKS

CEMENT TILE

PORCELAIN TILE

LOCAL MARBLE

Gypsum partition

ENTRANCE

ARTIFICIAL GRASS

PORCELAIN TILES (PARQUET STYLE)

DEMOLISHING AND REMOVAL

NEW INTERVENTION

DOOR NUMBER
REFERENCE DETAIL SHEET NUMBER

WINDOW NUMBER
REFERENCE DETAIL SHEET NUMBER

DETAILED SECTION AT SHEET No. A09

ROOM CODE
ROOM ID

FUNCTION AREA

R.C.L. REN. CONCRETE LEVEL

F.F.L. FINISH FLOOR LEVEL

S.L. : SEA LEVEL

REVISIONS		
NO.	DRAWINGS	DATE
(1)		
(2)		
(3)		

Contracting Authority:

Funded By:

Project Title:

“Public Works Contract for the rehabilitation of 5 schools in East Jerusalem”

Reference number: PSE22001-10074

Lot 1: the rehabilitation of Al-Hasan Al-Thany, Al-Shabbat Al-Shameleh, and Al-Fata Al-Laji’a schools in Wadi Al-Joz

Al-Shameleh Secondary Girls' school


Designed by:

HOSH STUDIO
ARCHITECTURE & TOWN PLANNING

Jerusalem - Sheikh Jarrah- Tobler8
email: mr.wasimhija@gmail.com

Tel. 02-9948344/ 052-8327076
Fax: 02-9948344

Drawing Title	Scope of Intervention	Date: 25/3/2025 Scale: 1:100
Designed by:	Arch. Hiba Al Ayoubi	Drawing No: E26
Checked by:	Arch. Wasim Abu El-Hija	
Approved by:		
Coordinate Manager:		

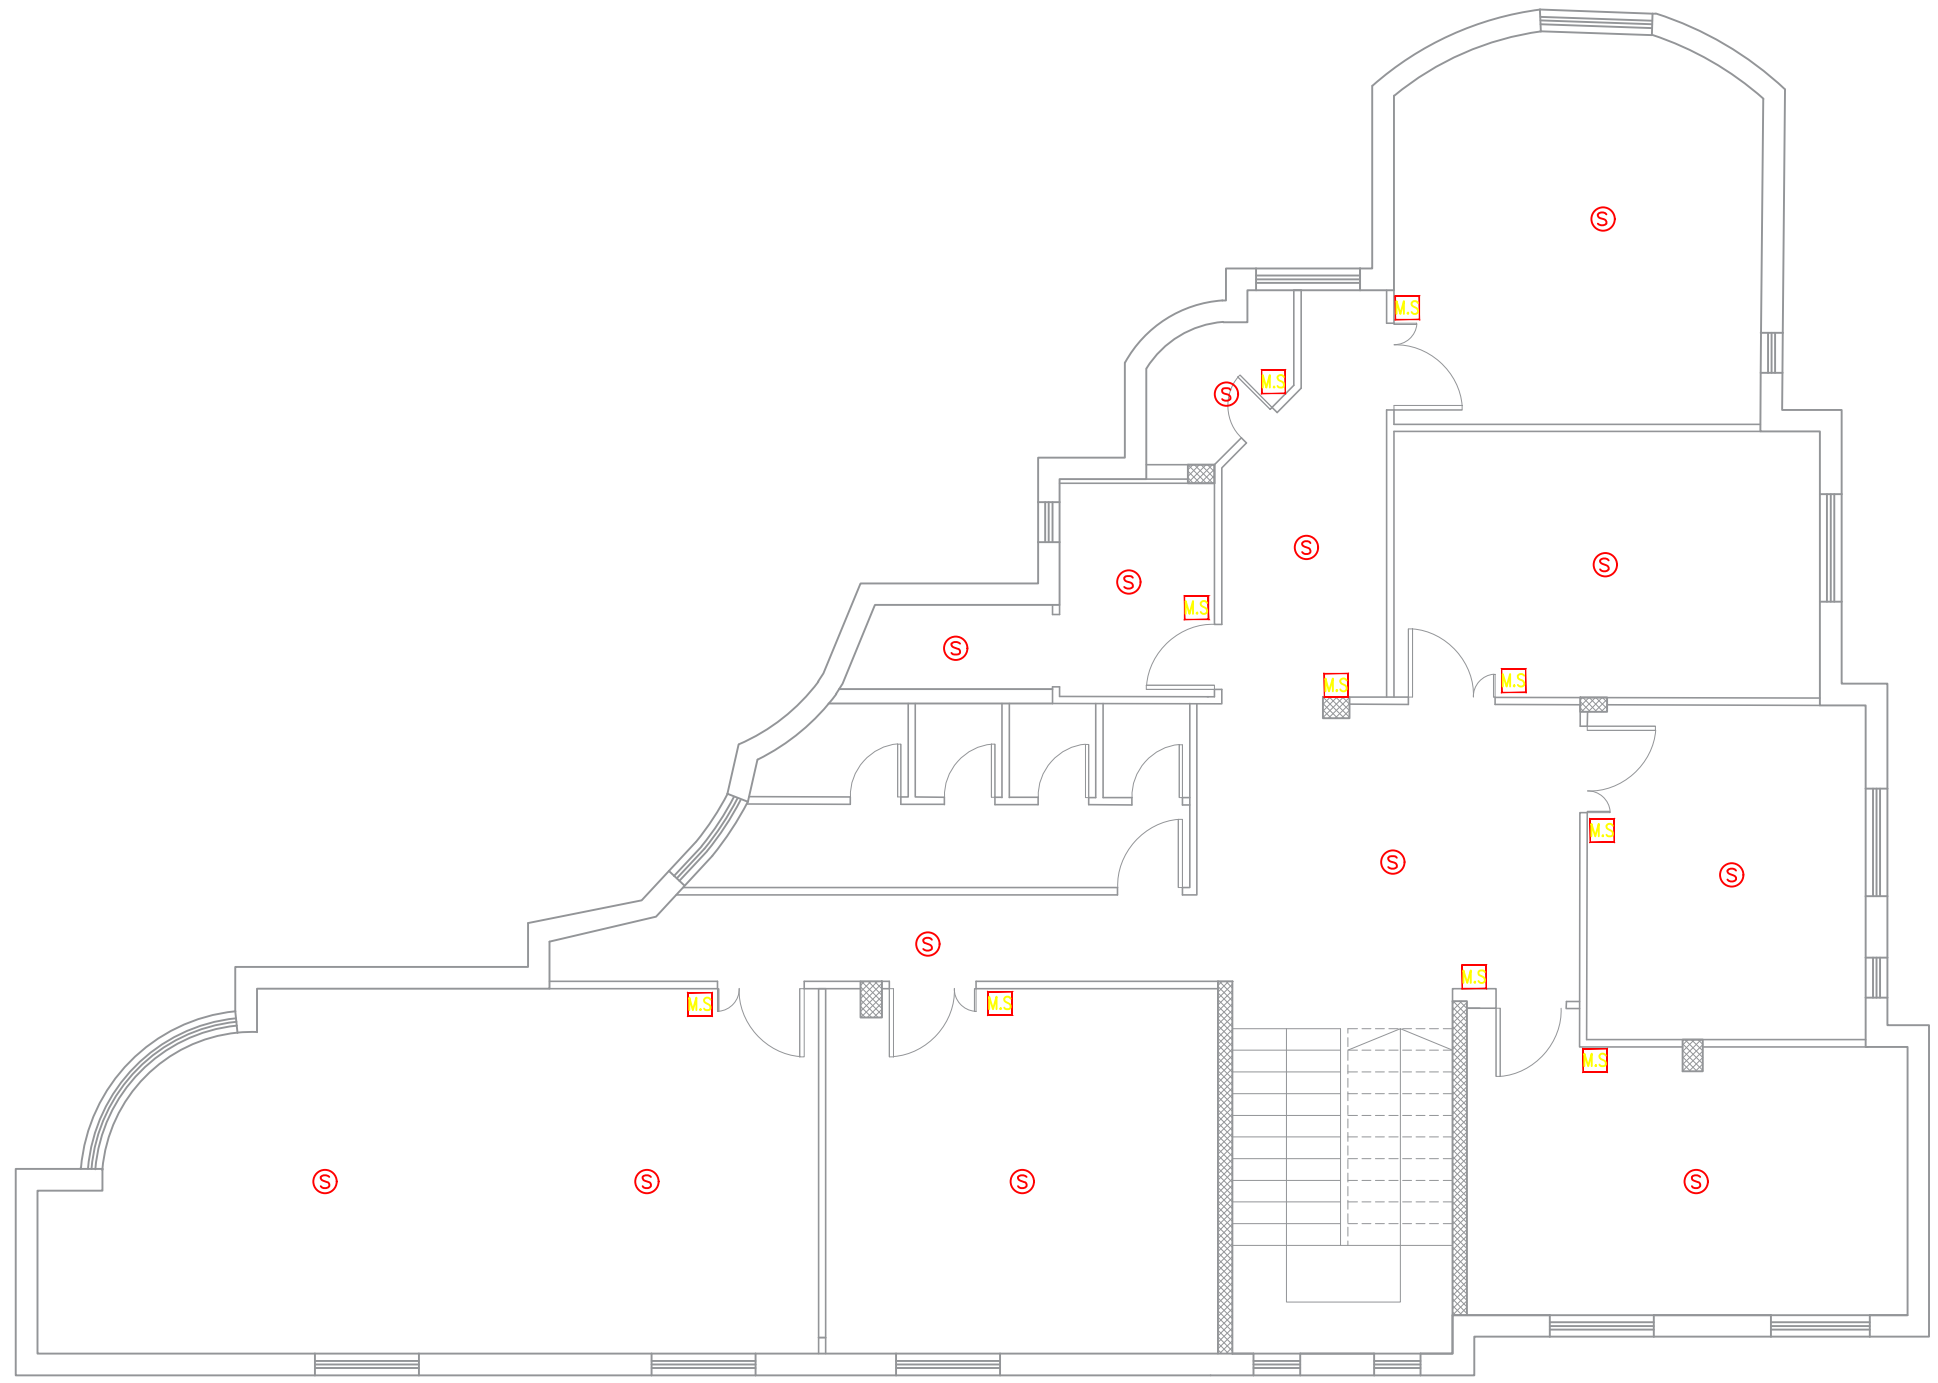

FIRST FLOOR &

Notes

(1) All Dimensions Are In M.
(2) All Levels Are In Meter
(3) Any Missing or Unclear Detail And All Fastening Systems For All Elements Shall be Approved by The Supervisor.

Legend:

SECTION NUMBER
REFERENCE SHEET NUMBER

REFERENCE DETAIL SHEET NUMBER

FLOOR FINISH LEVEL (F.F.L.)
REINFORCEMENT CONCRETE LEVEL (R.C.L.)

LEVEL SIGN IN PLAN

STEEL SHEETS

RC CONCRETE FOR COLUMNS

RC CONCRETE FOR WALLS

CONCRETE

STONE WALL

HOLLOW BLOCKS

CEMENT TILE

PORCELAIN TILE

LOCAL MARBLE

Gypsum partition

ENTRANCE

ARTIFICIAL GRASS

PORCELAIN TILES (PARQUET STYLE)

DEMOLISHING AND REMOVAL

NEW INTERVENTION

DOOR NUMBER
REFERENCE DETAIL SHEET NUMBER

WINDOW NUMBER
REFERENCE DETAIL SHEET NUMBER

DETAILED SECTION AT SHEET No. A09

R.C.L.: REN. CONCRETE LEVEL

F.F.L.: FINISH FLOOR LEVEL

S.L.: SEA LEVEL

REVISIONS		
NO.	DRAWINGS	DATE
(1)		
(2)		
(3)		

Contracting Authority:

Funded By:

Project Title:

“Public Works Contract for the rehabilitation of 5 schools in East Jerusalem”

Reference number: PSE22001-10074

Lot 1: the rehabilitation of Al-Hasan Al-Thany, Al-Shabbat Al-Shameleh, and Al-Fata Al-Laji’a schools in Wadi Al-Joz

Al-Shameleh Secondary Girls' school


Designed by:

HOSH STUDIO
ARCHITECTURE & TOWN PLANNING

Jerusalem - Sheikh Jarrah- Tobler8
email: mr.wasimhija@gmail.com

Tel. 02-9948344/ 052-8327076
Fax: 02-9948344

Drawing Title	Scope of Intervention	Date: 25/3/2025 Scale: 1:100
Designed by:	Arch. Hiba Al Ayoubi	Drawing No: E27
Checked by:	Arch. Wasim Abu El-Hija	
Approved by:		
Coordinate Manager:		

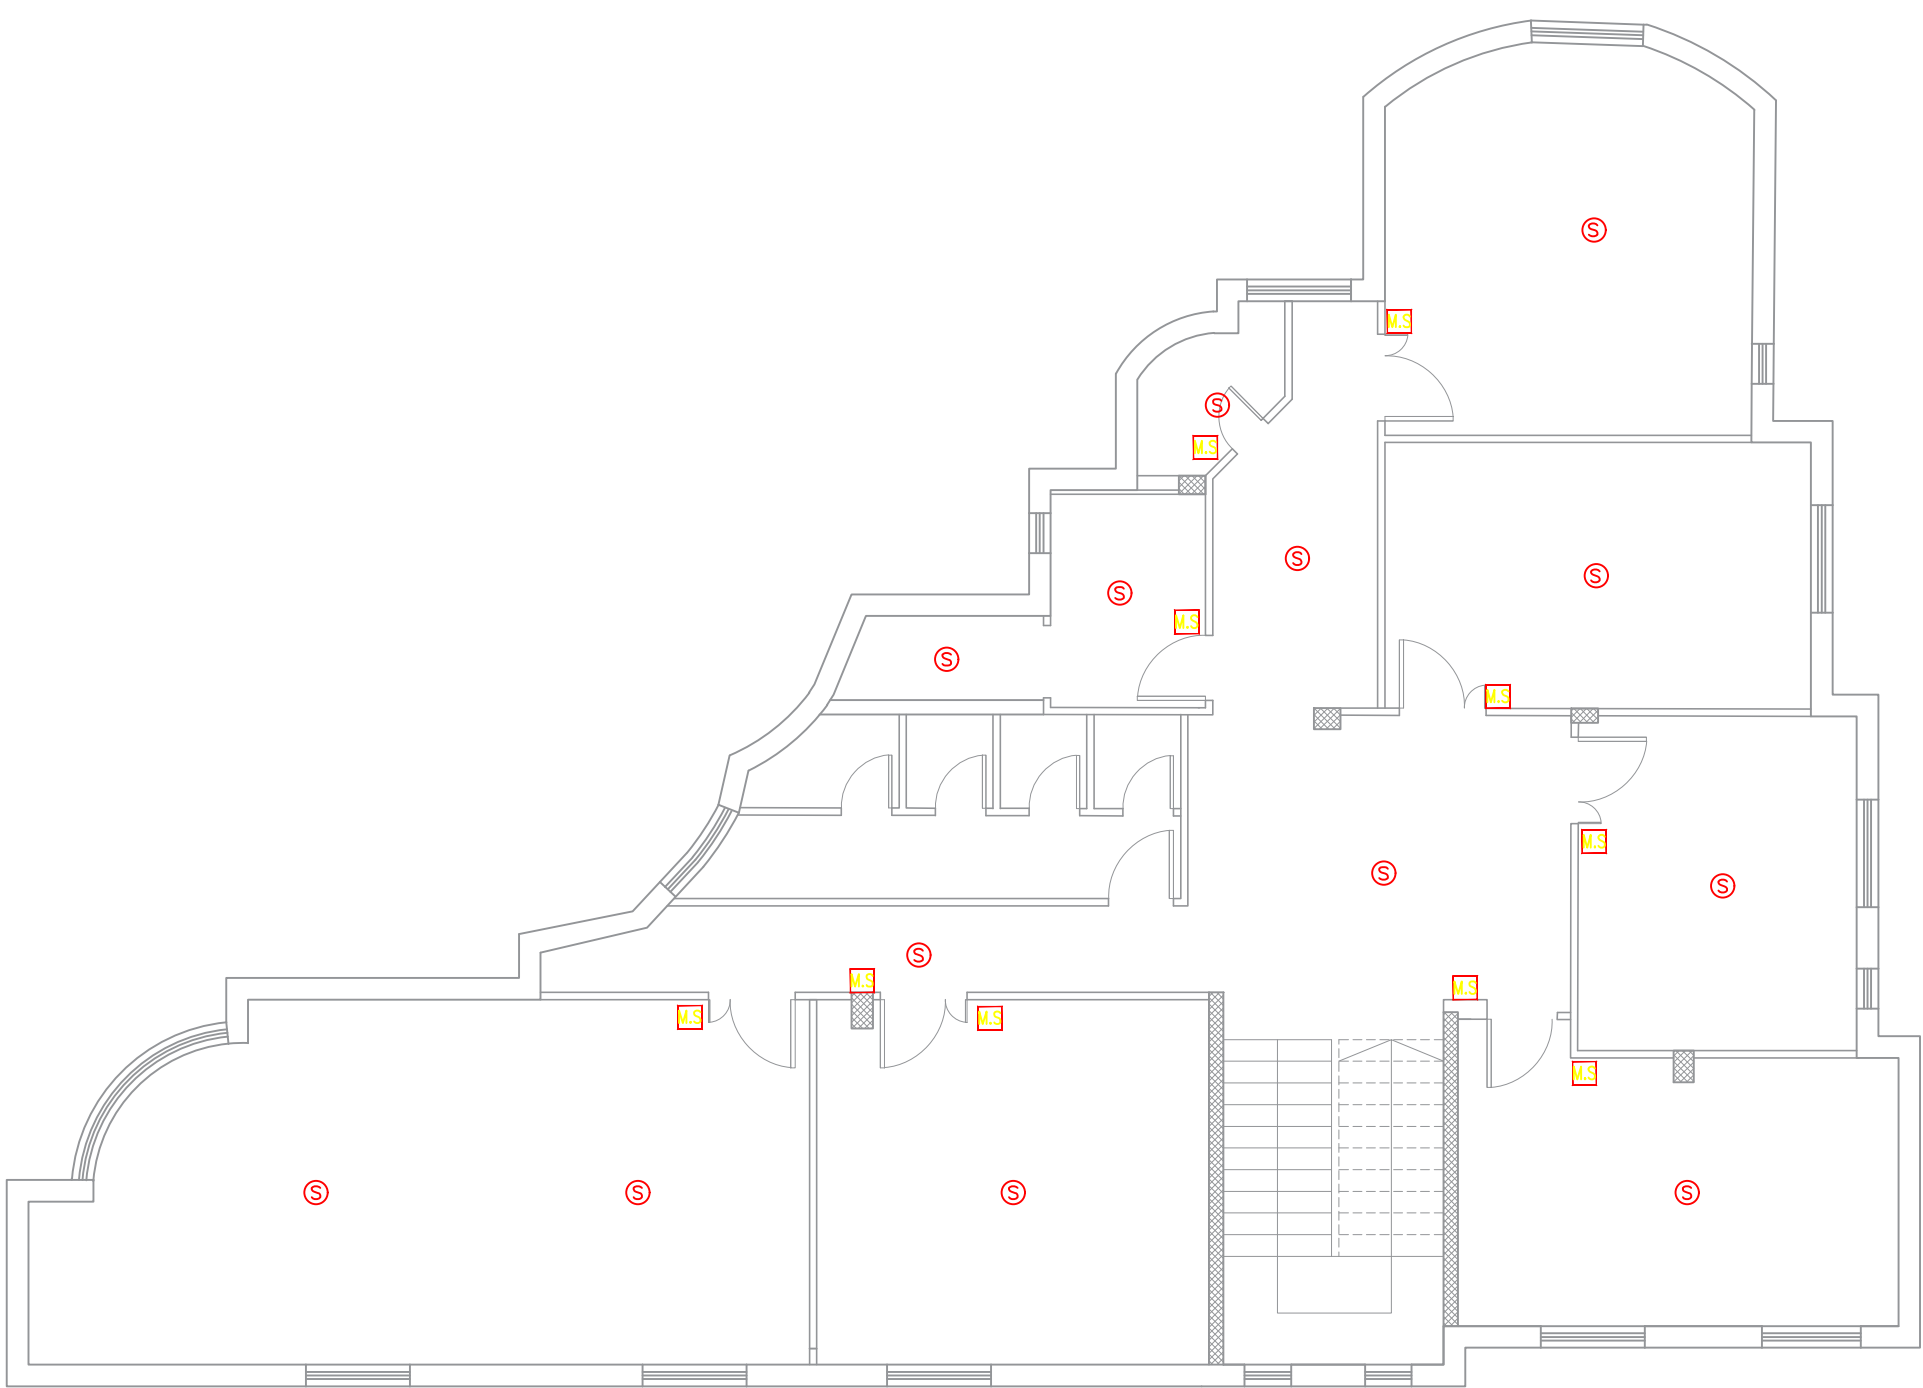

SECOND FLOOR

Notes

(1) All Dimensions Are In M.
(2) All Levels Are In Meter
(3) Any Missing or Unclear Detail And All Fastening Systems For All Elements Shall be Approved by The Supervisor.

Legend:

SECTION NUMBER
REFERENCE SHEET NUMBER

REFERENCE DETAIL SHEET NUMBER

FLOOR FINISH LEVEL (F.F.L.)
REINFORCEMENT CONCRETE LEVEL (R.C.L.)

LEVEL SIGN IN PLAN

STEEL SHEETS

R.C. CONCRETE FOR COLUMNS

R.C. CONCRETE FOR WALLS

CONCRETE

STONE WALL

HOLLOW BLOCKS

CEMENT TILE

PORCELAIN TILE

LOCAL MARBLE

Gypsum partition

ENTRANCE

ARTIFICIAL GRASS

PORCELAIN TILES (PARQUET STYLE)

DEMOLISHING AND REMOVAL

NEW INTERVENTION

DOOR NUMBER
REFERENCE DETAIL SHEET NUMBER

WINDOW NUMBER
REFERENCE DETAIL SHEET NUMBER

DETAILED SECTION AT SHEET No. A09

R.C.L.: REN. CONCRETE LEVEL

F.F.L.: FINISH FLOOR LEVEL

S.L.: SEA LEVEL

REVISIONS		
NO.	DRAWINGS	DATE
(1)		
(2)		
(3)		

Contracting Authority:

Funded By:

Project Title:

“Public Works Contract for the rehabilitation of 5 schools in East Jerusalem”

Reference number: PSE22001-10074

Lot 1: the rehabilitation of Al-Hasan Al-Thany, Al-Shabbat Al-Shameleh, and Al-Fata Al-Laji’a schools in Wadi Al-Joz

Al-Shameleh Secondary Girls' school


Designed by:

HOSH STUDIO
ARCHITECTURE & TOWN PLANNING

Jerusalem - Sheikh Jarrah- Tobler8
email: mr.wasimhija@gmail.com

Tel. 02-9948344/ 052-8327076
Fax: 02-9948344

Drawing Title	Scope of Intervention	Date: 25/3/2025 Scale: 1:100
Designed by:	Arch. Hiba Al Ayoubi	Drawing No: E28
Checked by:	Arch. Wasim Abu El-Hija	
Approved by:		
Coordinate Manager:		

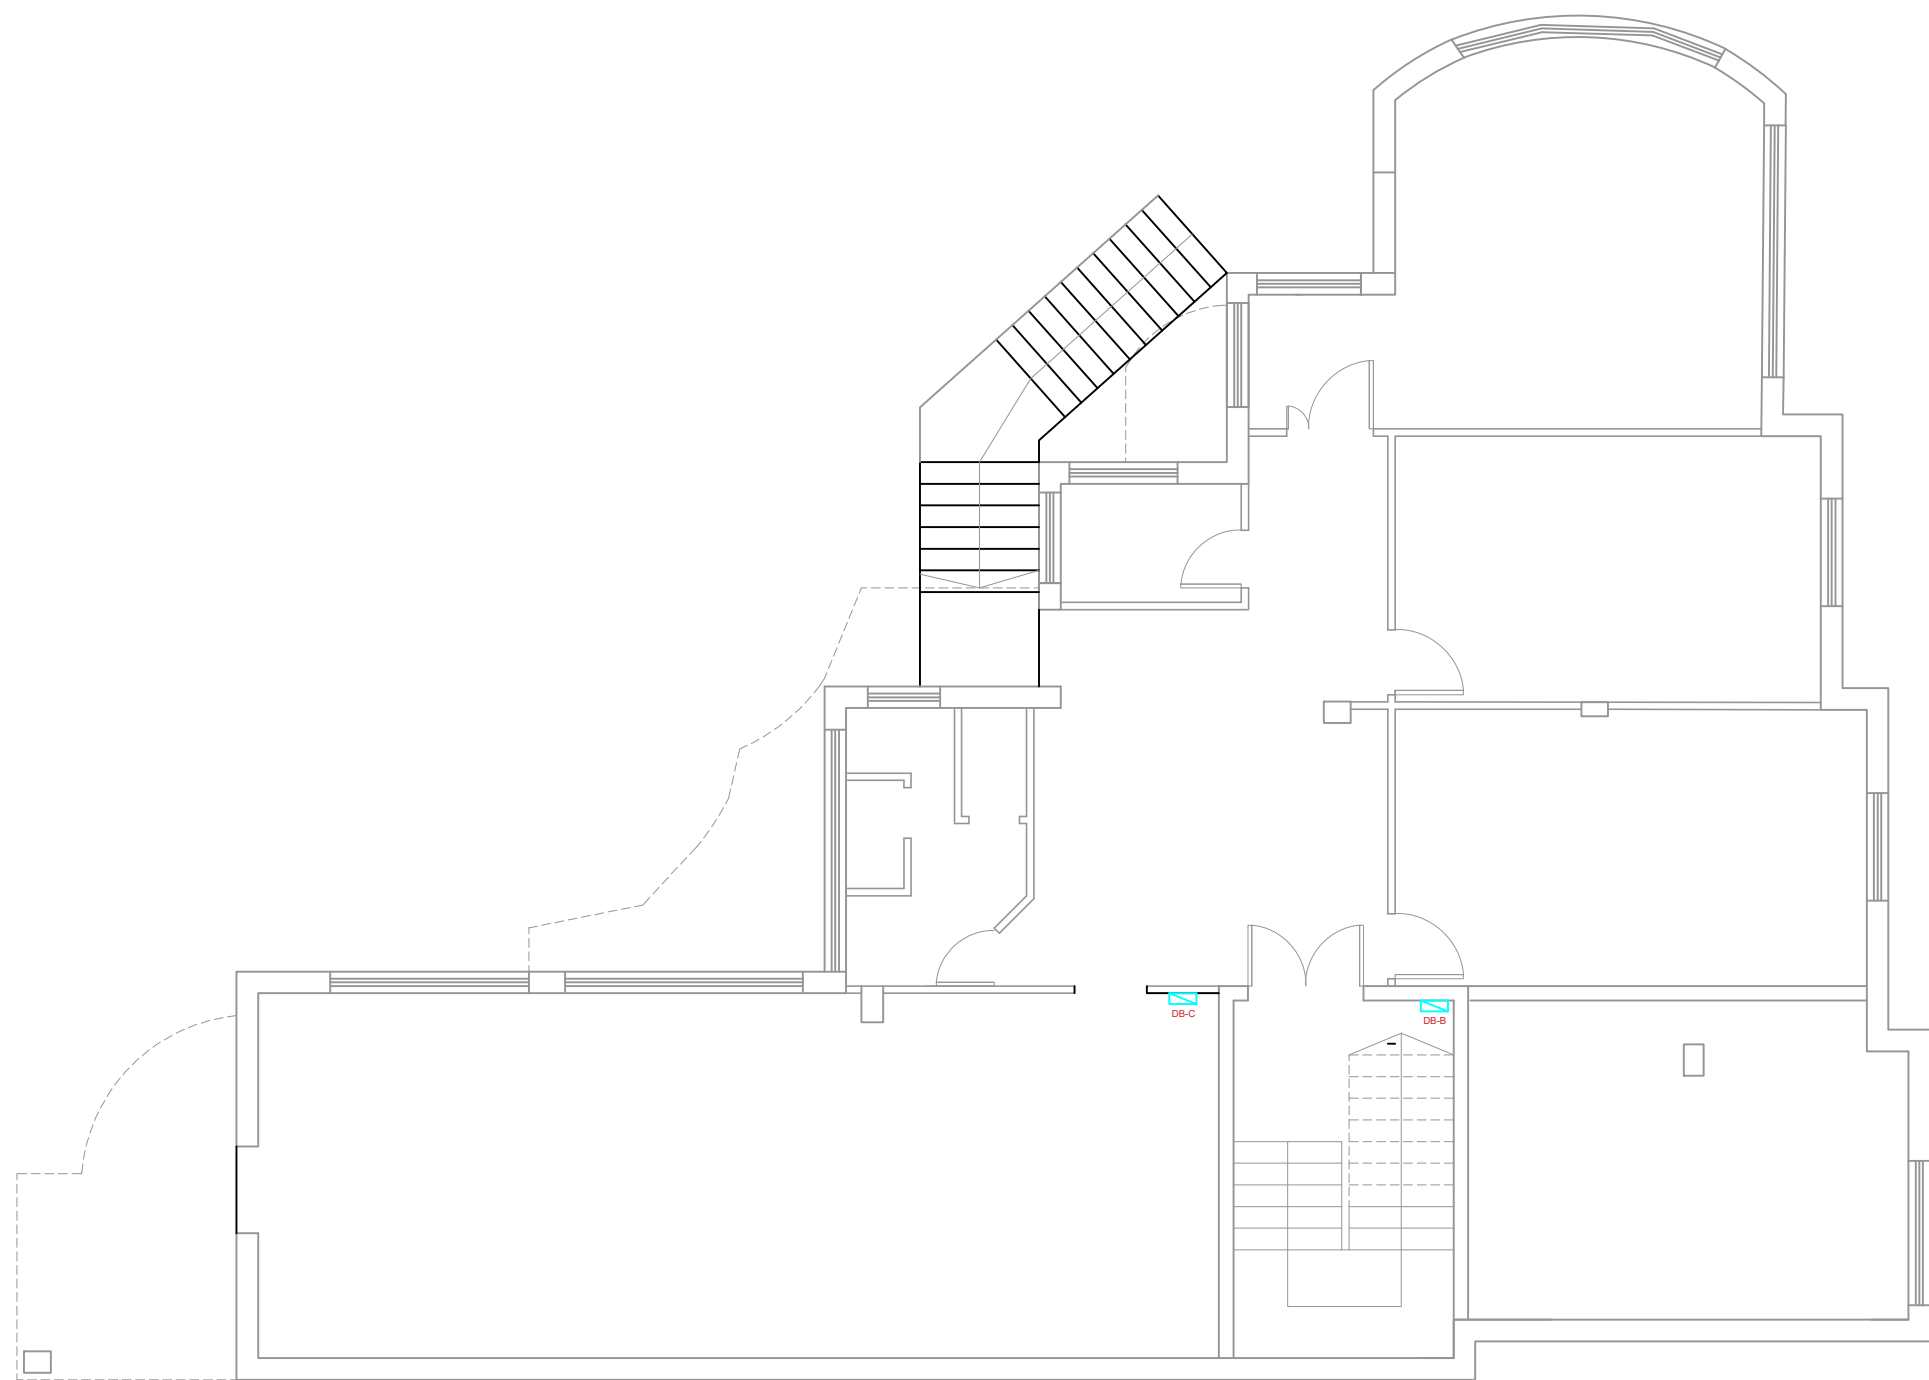

BASEMENT FLOOR

Notes

- (1) All Dimensions Are In M.
- (2) All Levels Are In Meter
- (3) Any Missing or Unclear Detail And All Fastening Systems For All Elements Shall be Approved by The Supervisor.

Legend:

SECTION NUMBER
REFERENCE SHEET NUMBER

DOOR NUMBER
REFERENCE DETAIL SHEET NUMBER

FLOOR FINISH LEVEL (F.F.L.)
REINFORCEMENT CONCRETE LEVEL (R.C.L.)

LEVEL SIGN IN PLAN

ROOM CODE
FUNCTION
AREA
ROOM ID

DOOR NUMBER
REFERENCE DETAIL SHEET NUMBER

WINDOW NUMBER
REFERENCE DETAIL SHEET NUMBER

DETAILED SECTION AT SHEET No. A09

STEEL SHEETS
RC CONCRETE FOR COLUMNS
RC CONCRETE FOR WALLS
STONE WALL
HOLLOW BLOCKS
CEMENT TILE
PORCELAIN TILE
LOCAL MARBLE
Gypsum partition

ENTRANCE
ARTIFICIAL GRASS
PORCELAIN TILES (PARQUET STYLE)
DEMOLISHING AND REMOVAL
NEW INTERVENTION

R.C.L.: REN. CONCRETE LEVEL
F.F.L.: FINISH FLOOR LEVEL
S.L.: SEA LEVEL

REVISIONS

NO.	DRAWINGS	DATE
(1)		
(2)		
(3)		

Contracting Authority:



Funded By:



Project Title:

“Public Works Contract for the rehabilitation of 5 schools in East Jerusalem”

Reference number: PSE22001-10074

Lot 1: the rehabilitation of Al-Hasan Al-Thany, Al-Shabbat Al-Shameleh, and Al-Fata Al-Laji’a schools in Wadi Al-Joz

Al-Shameleh Secondary Girls' school

Designed by:



Jerusalem - Sheikh Jarrah- Tobler8
email: mr.wasimhija@gmail.com
Tel. 02-9948344/ 052-8327076
Fax: 02-9948344

Drawing Title	Scope of Intervention	Date: 25/3/2025 Scale: 1:100
Designed by:	Arch. Hiba Al Ayoubi	Drawing No: E29
Checked by:	Arch. Wasim Abu El-Hija	
Approved by:		
Coordinate Manager:		



GROUND FLOOR

Notes

(1) All Dimensions Are In M.
(2) All Levels Are In Meter
(3) Any Missing or Unclear Detail And All Fastening Systems For All Elements Shall be Approved by The Supervisor.

Legend:

SECTION NUMBER
REFERENCE SHEET NUMBER

REFERENCE DETAIL SHEET NUMBER

FLOOR FINISH LEVEL (F.F.L.)

REINFORCEMENT CONCRETE LEVEL (R.C.L.)

LEVEL SIGN IN PLAN

STEEL SHEETS

RC CONCRETE FOR COLUMNS

RC CONCRETE FOR WALLS

CONCRETE

STONE WALL

HOLLOW BLOCKS

CEMENT TILE

PORCELAIN TILE

LOCAL MARBLE

Gypsum partition

ENTRANCE

ARTIFICIAL GRASS

PORCELAIN TILES (PARQUET STYLE)

DEMOLISHING AND REMOVAL

NEW INTERVENTION

DOOR NUMBER
REFERENCE DETAIL SHEET NUMBER

WINDOW NUMBER
REFERENCE DETAIL SHEET NUMBER

DETAILED SECTION AT SHEET No. A09

ROOM CODE
ROOM ID

FUNCTION AREA

R.C.L.:REN. CONCRETE LEVEL

F.F.L.:FINISH FLOOR LEVEL

S.L. : SEA LEVEL

REVISIONS		
NO.	DRAWINGS	DATE
(1)		
(2)		
(3)		

Contracting Authority:

Funded By:

Project Title:

“Public Works Contract for the rehabilitation of 5 schools in East Jerusalem”

Reference number: PSE22001-10074

Lot 1: the rehabilitation of Al-Hasan Al-Thany, Al-Shabbat Al-Shameleh, and Al-Fata Al-Laji’a schools in Wadi Al-Joz

Al-Shameleh Secondary Girls' school


Designed by:

HOSH STUDIO
ARCHITECTURE & TOWN PLANNING

Jerusalem - Sheikh Jarrah- Tobler8
email: mr.wasimhija@gmail.com

Tel. 02-9948344/ 052-8327076
Fax: 02-9948344

Drawing Title	Scope of Intervention	Date: 25/3/2025 Scale: 1:100
Designed by:	Arch. Hiba Al Ayoubi	Drawing No: E30
Checked by:	Arch. Wasim Abu El-Hija	
Approved by:		
Coordinate Manager:		

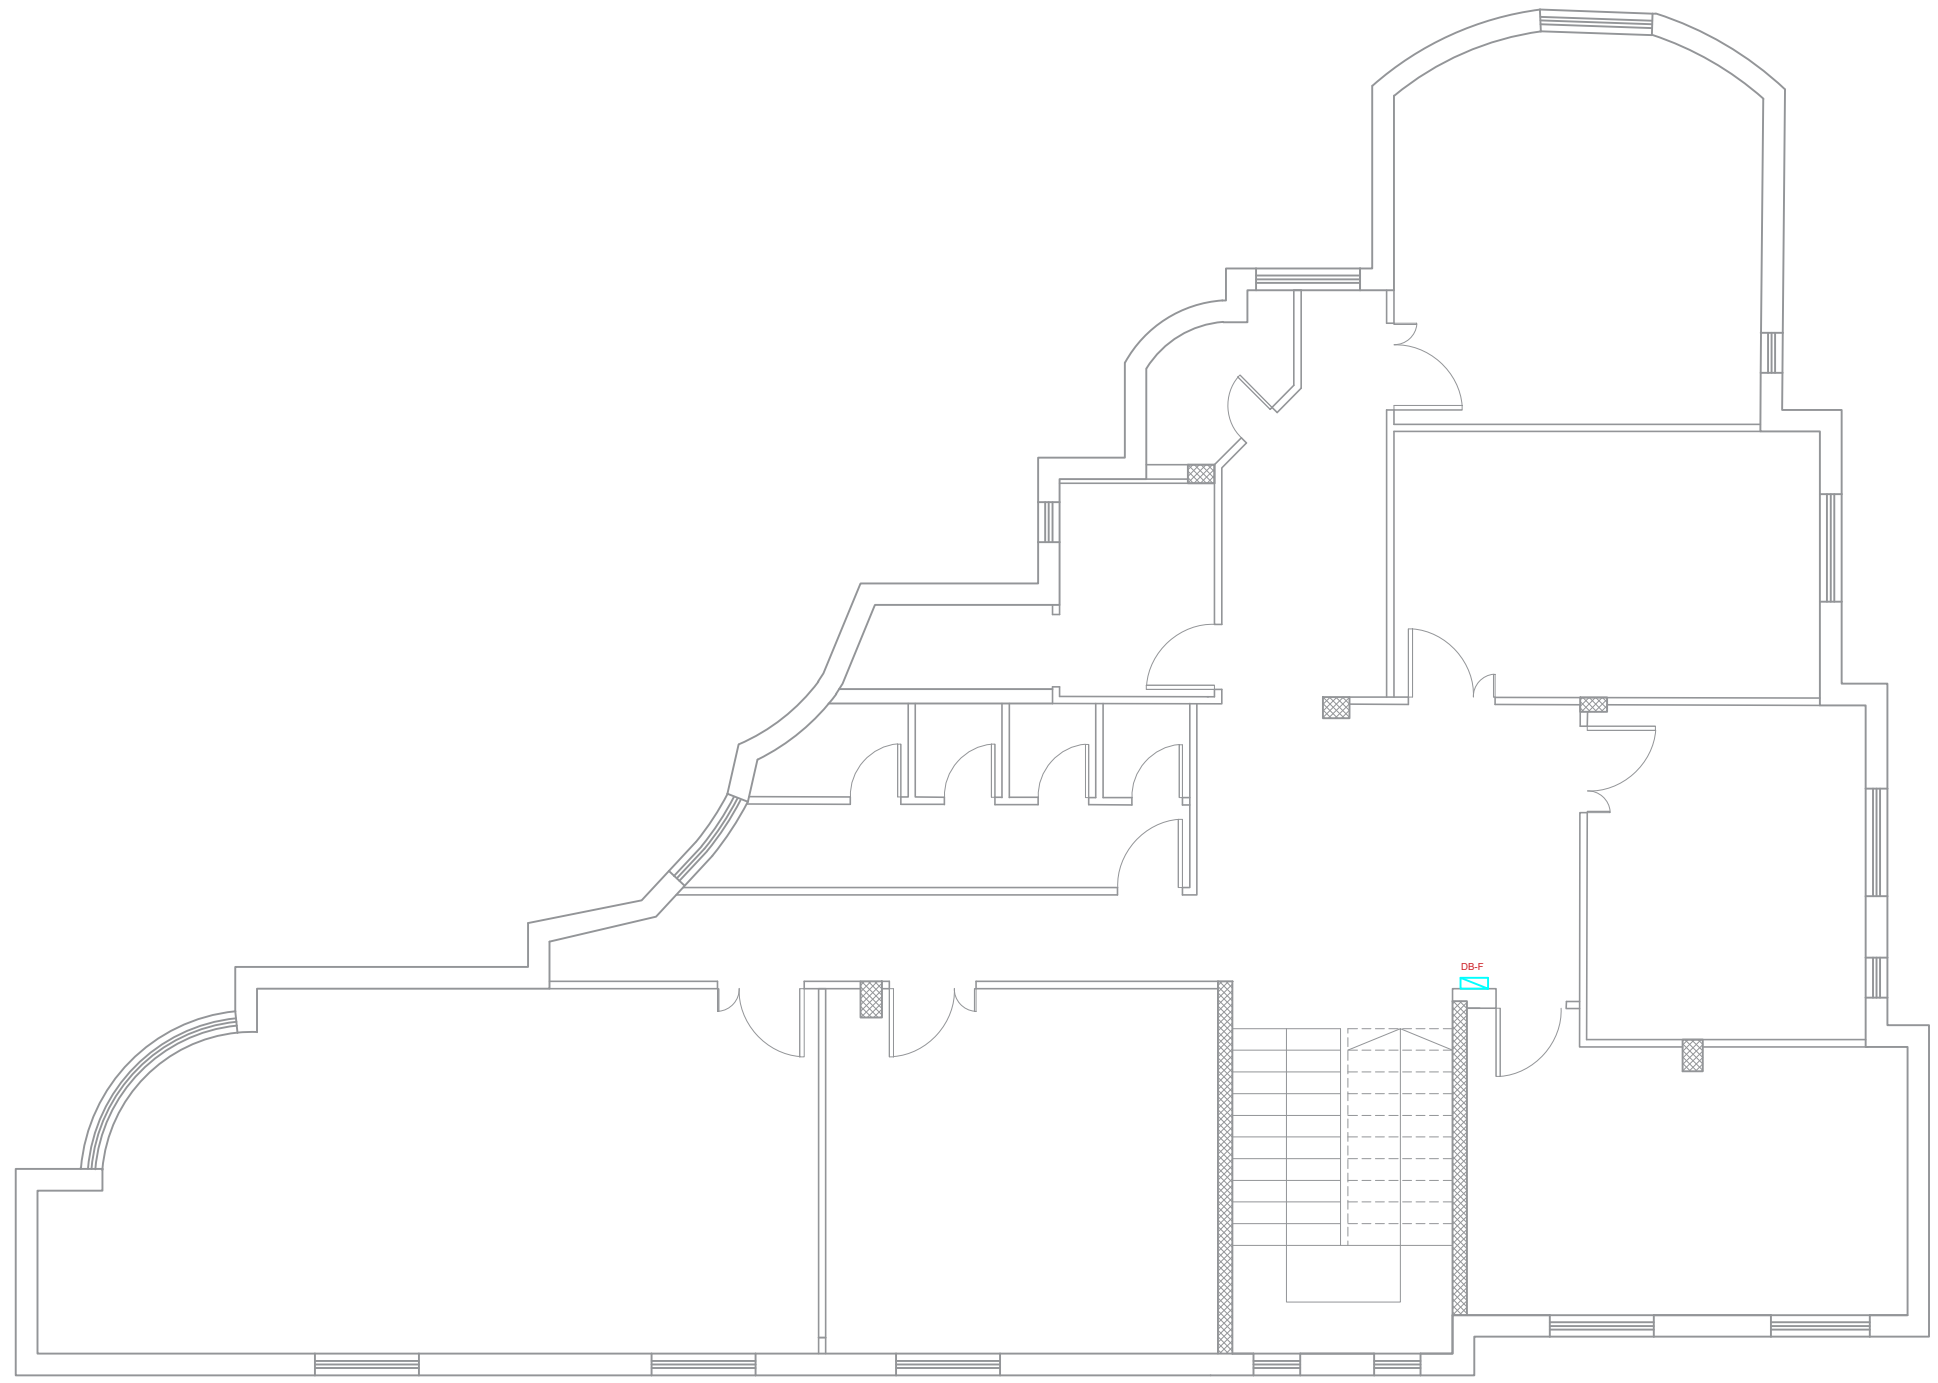

FIRST FLOOR &

Notes

- (1) All Dimensions Are In M.
- (2) All Levels Are In Meter
- (3) Any Missing or Unclear Detail And All Fastening Systems For All Elements Shall be Approved by The Supervisor.

Legend:

SECTION NUMBER
REFERENCE SHEET NUMBER

REFERENCE DETAIL SHEET NUMBER

FLOOR FINISH LEVEL (F.F.L.)

REINFORCEMENT CONCRETE LEVEL (R.C.L.)

LEVEL SIGN IN PLAN

STEEL SHEETS

RC CONCRETE FOR COLUMNS

RC CONCRETE FOR WALLS

CONCRETE

STONE WALL

HOLLOW BLOCKS

CEMENT TILE

PORCELAIN TILE

LOCAL MARBLE

Gypsum partition

ENTRANCE

ARTIFICIAL GRASS

PORCELAIN TILES (PARQUET STYLE)

DEMOLISHING AND REMOVAL

NEW INTERVENTION

ROOM CODE
ROOM ID

DOOR NUMBER
REFERENCE DETAIL SHEET NUMBER

WINDOW NUMBER
REFERENCE DETAIL SHEET NUMBER

DETAILED SECTION AT SHEET No. A09

R.C.L.: REN. CONCRETE LEVEL

F.F.L.: FINISH FLOOR LEVEL

S.L.: SEA LEVEL

REVISIONS

NO.	DRAWINGS	DATE
(1)		
(2)		
(3)		

Contracting Authority:



Funded By:



Project Title:

“Public Works Contract for the rehabilitation of 5 schools in East Jerusalem”

Reference number: PSE22001-10074

Lot 1: the rehabilitation of Al-Hasan Al-Thany, Al-Shabbat Al-Shameleh, and Al-Fata Al-Laji’a schools in Wadi Al-Joz


Al-Shameleh Secondary Girls' school

Designed by:



Jerusalem - Sheikh Jarrah- Tobler8
email: mr.wasimhija@gmail.com
Tel. 02-9948344/ 052-8327076
Fax: 02-9948344

Drawing Title	Scope of Intervention	Date: 25/3/2025 Scale: 1:100
Designed by:	Arch. Hiba Al Ayoubi	Drawing No: E31
Checked by:	Arch. Wasim Abu El-Hija	
Approved by:		
Coordinate Manager:		

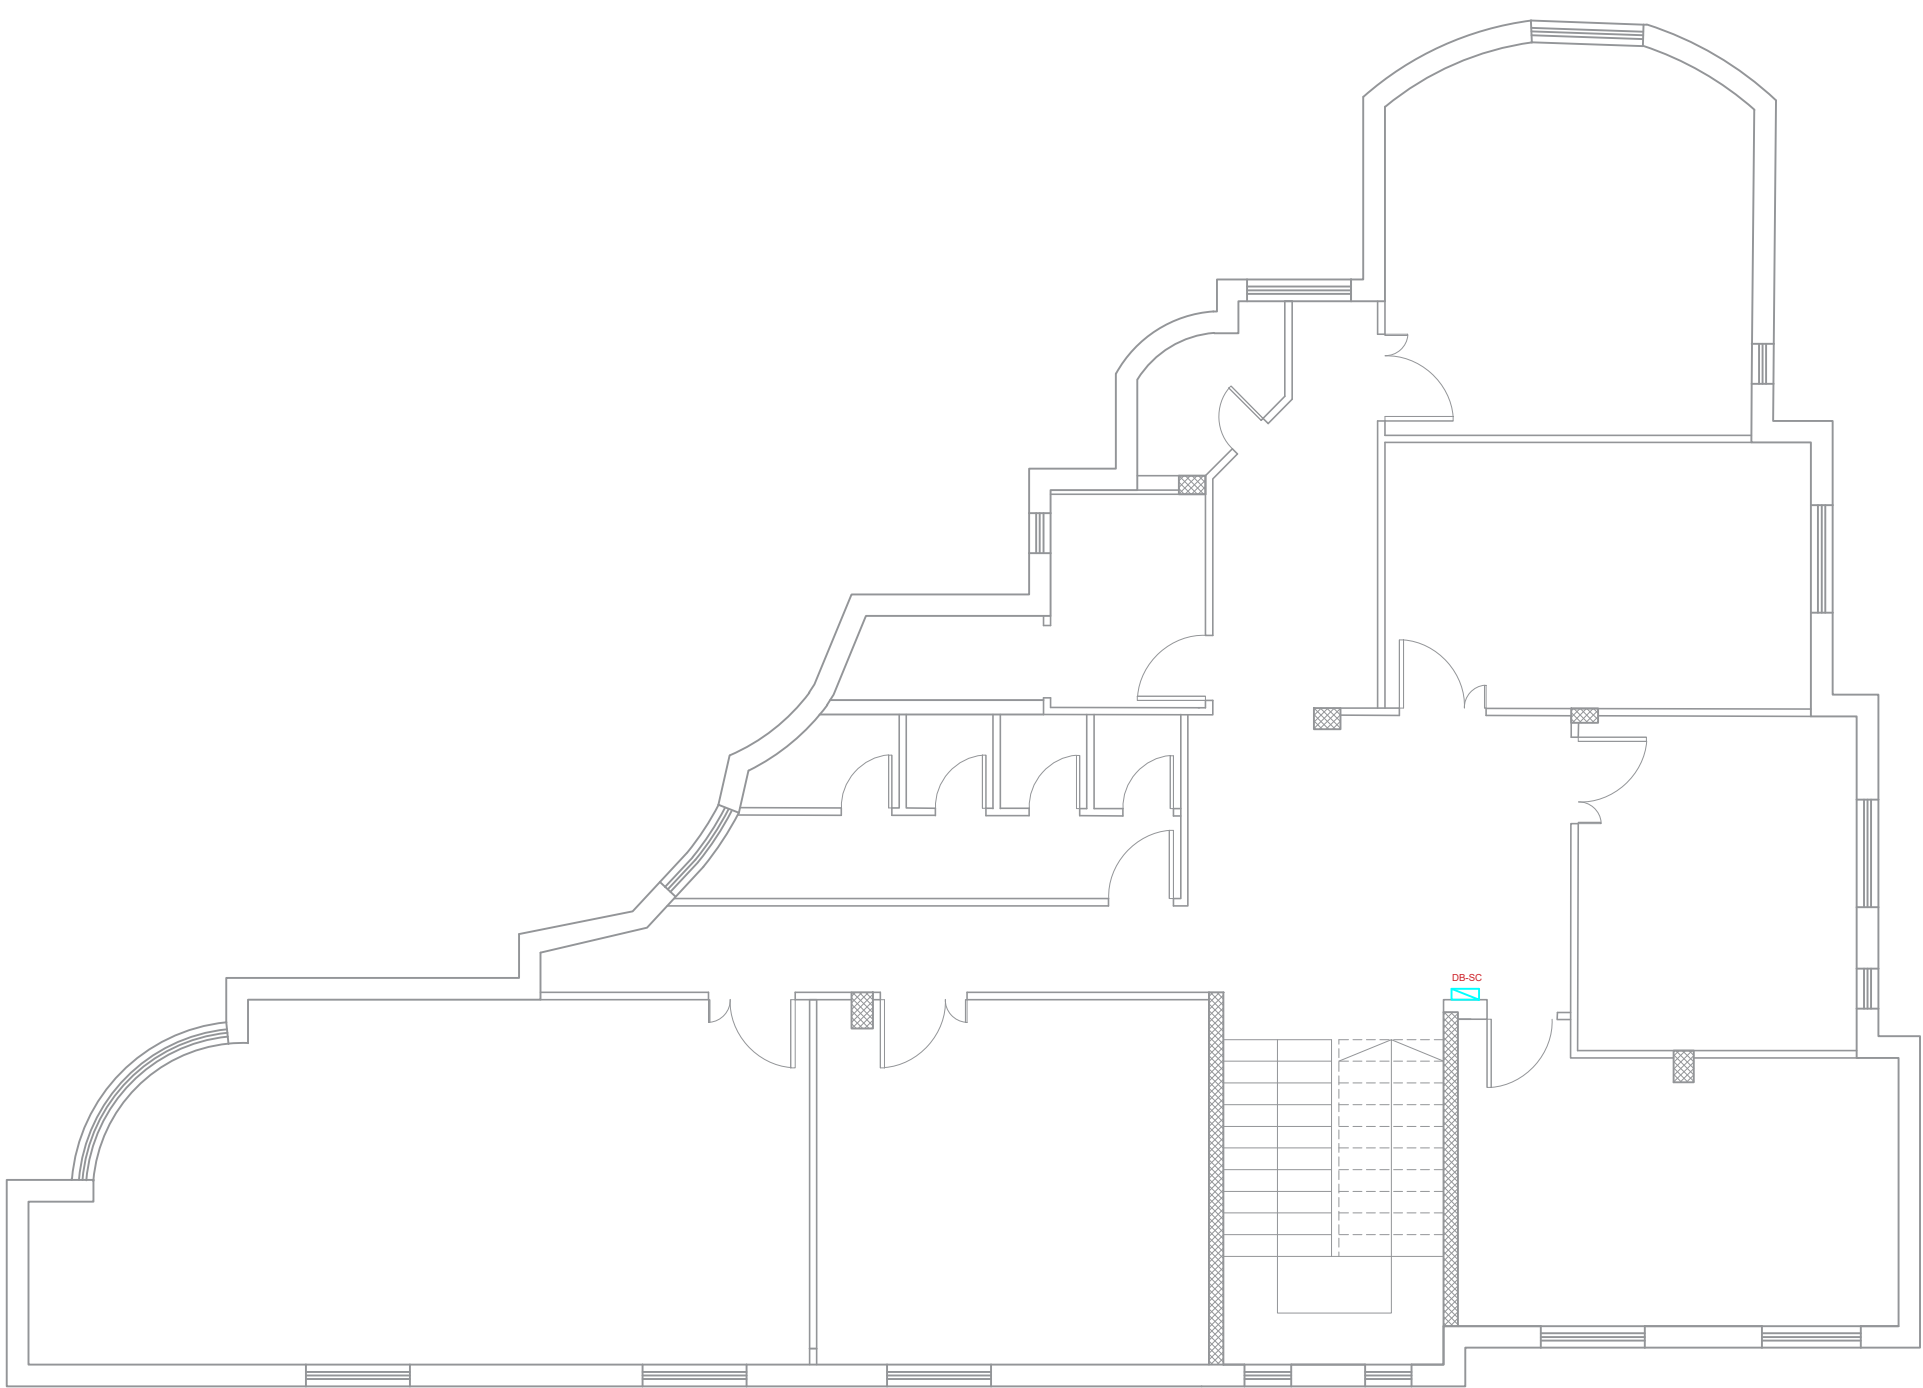

SECOND FLOOR

Notes

(1) All Dimensions Are In M.
(2) All Levels Are In Meter
(3) Any Missing or Unclear Detail And All Fastening Systems For All Elements Shall be Approved by The Supervisor.

Legend:

SECTION NUMBER
REFERENCE SHEET NUMBER

REFERENCE DETAIL SHEET NUMBER

FLOOR FINISH LEVEL (F.F.L.)

REINFORCEMENT CONCRETE LEVEL (R.C.L.)

LEVEL SIGN IN PLAN

STEEL SHEETS

RC CONCRETE FOR COLUMNS

RC CONCRETE FOR WALLS

CONCRETE

STONE WALL

HOLLOW BLOCKS

CEMENT TILE

PORCELAIN TILE

LOCAL MARBLE

Gypsum partition

ENTRANCE

ARTIFICIAL GRASS

PORCELAIN TILES (PARQUET STYLE)

DEMOLISHING AND REMOVAL

NEW INTERVENTION

DOOR NUMBER
REFERENCE DETAIL SHEET NUMBER

WINDOW NUMBER
REFERENCE DETAIL SHEET NUMBER

DETAILED SECTION AT SHEET No. A09

R.C.L.:REN. CONCRETE LEVEL

F.F.L.:FINISH FLOOR LEVEL

S.L. : SEA LEVEL

REVISIONS		
NO.	DRAWINGS	DATE
(1)		
(2)		
(3)		

Contracting Authority:

Funded By:

Project Title:

“Public Works Contract for the rehabilitation of 5 schools in East Jerusalem”

Reference number: PSE22001-10074

Lot 1: the rehabilitation of Al-Hasan Al-Thany, Al-Shabbat Al-Shameleh, and Al-Fata Al-Laji’a schools in Wadi Al-Joz


Al-Shameleh Secondary Girls' school

Designed by:

Jerusalem - Sheikh Jarrah- Tobler8
email: mr.wasimhija@gmail.com

Tel. 02-9948344/ 052-8327076
Fax: 02-9948344

Drawing Title	Scope of Intervention	Date: 25/3/2025 Scale: 1:100
Designed by:	Arch. Hiba Al Ayoubi	Drawing No: E32
Checked by:	Arch. Wasim Abu El-Hija	
Approved by:		
Coordinate Manager:		

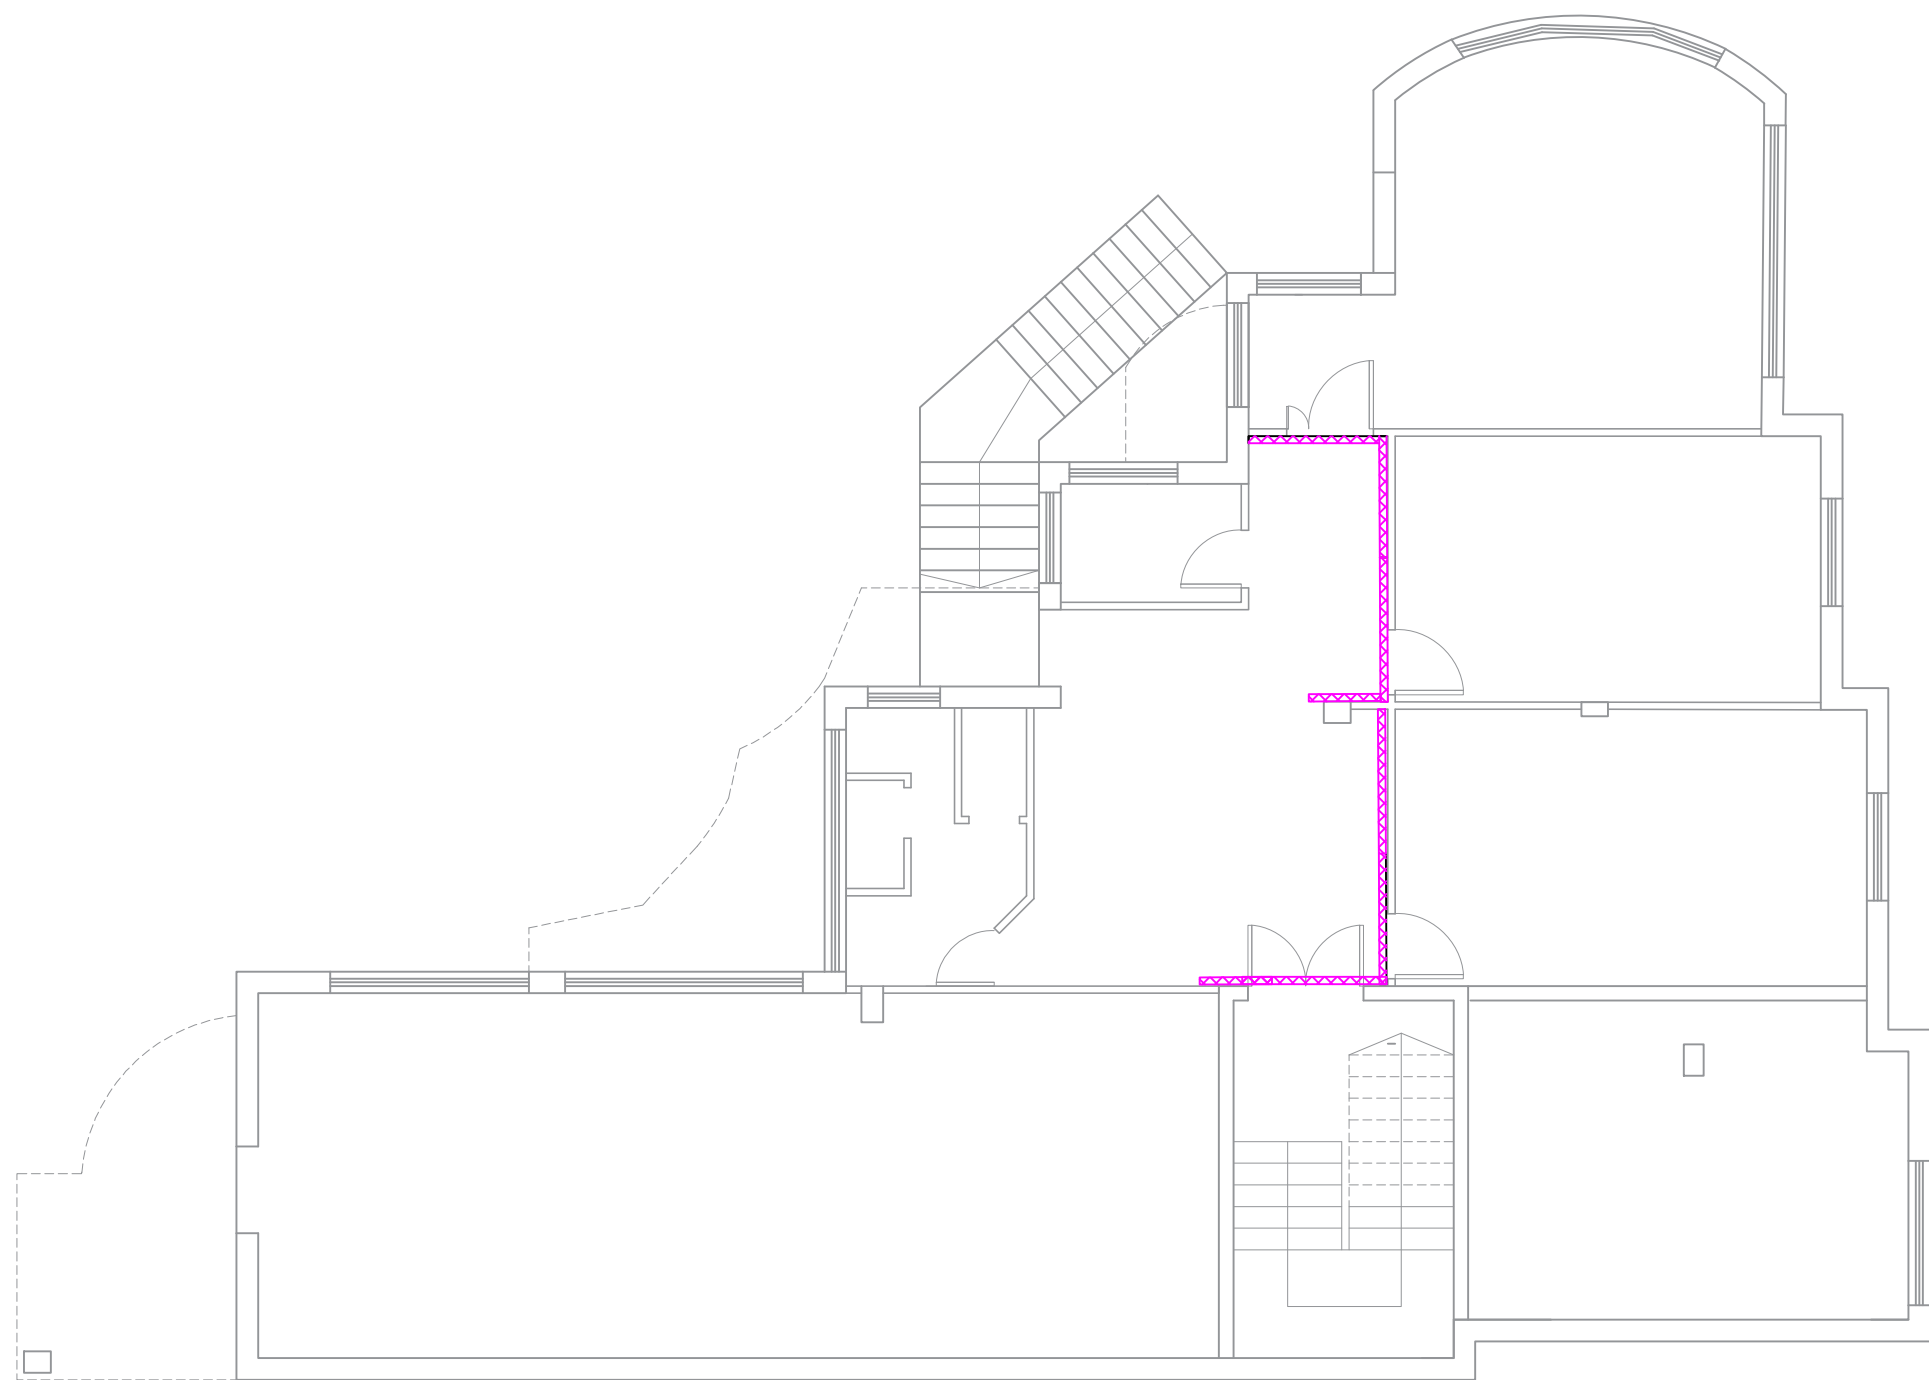

BASEMENT FLOOR

Notes

- (1) All Dimensions Are In M.
- (2) All Levels Are In Meter
- (3) Any Missing or Unclear Detail And All Fastening Systems For All Elements Shall be Approved by The Supervisor.

Legend:

SECTION NUMBER
REFERENCE SHEET NUMBER

REFERENCE DETAIL SHEET NUMBER

FLOOR FINISH LEVEL (F.F.L.)
REINFORCEMENT CONCRETE LEVEL (R.C.L.)

LEVEL SIGN IN PLAN

ROOM CODE
FUNCTION
AREA
ROOM ID

DOOR NUMBER
REFERENCE DETAIL SHEET NUMBER

WINDOW NUMBER
REFERENCE DETAIL SHEET NUMBER

DETAILED SECTION AT SHEET No. A09

STEEL SHEETS
RC CONCRETE FOR COLUMNS
RC CONCRETE FOR WALLS
CONCRETE
STONE WALL
HOLLOW BLOCKS
CEMENT TILE
PORCELAIN TILE
LOCAL MARBLE
Gypsum partition

ENTRANCE
ARTIFICIAL GRASS
PORCELAIN TILES (PARQUET STYLE)
DEMOLISHING AND REMOVAL
NEW INTERVENTION

R.C.L.: REN. CONCRETE LEVEL
F.F.L.: FINISH FLOOR LEVEL
S.L.: SEA LEVEL

REVISIONS

NO.	DRAWINGS	DATE
(1)		
(2)		
(3)		

Contracting Authority:



Funded By:



Project Title:

“Public Works Contract for the rehabilitation of 5 schools in East Jerusalem”

Reference number: PSE22001-10074

Lot 1: the rehabilitation of Al-Hasan Al-Thany, Al-Shabbat Al-Shameleh, and Al-Fata Al-Laji’a schools in Wadi Al-Joz


Al-Shameleh Secondary Girls' school

Designed by:



Jerusalem - Sheikh Jarrah- Tobler8
email: mr.wasimhija@gmail.com
Tel. 02-9948344/ 052-8327076
Fax: 02-9948344

Drawing Title	Scope of Intervention	Date: 25/3/2025 Scale: 1:100
Designed by:	Arch. Hiba Al Ayoubi	Drawing No: E33
Checked by:	Arch. Wasim Abu El-Hija	
Approved by:		
Coordinate Manager:		

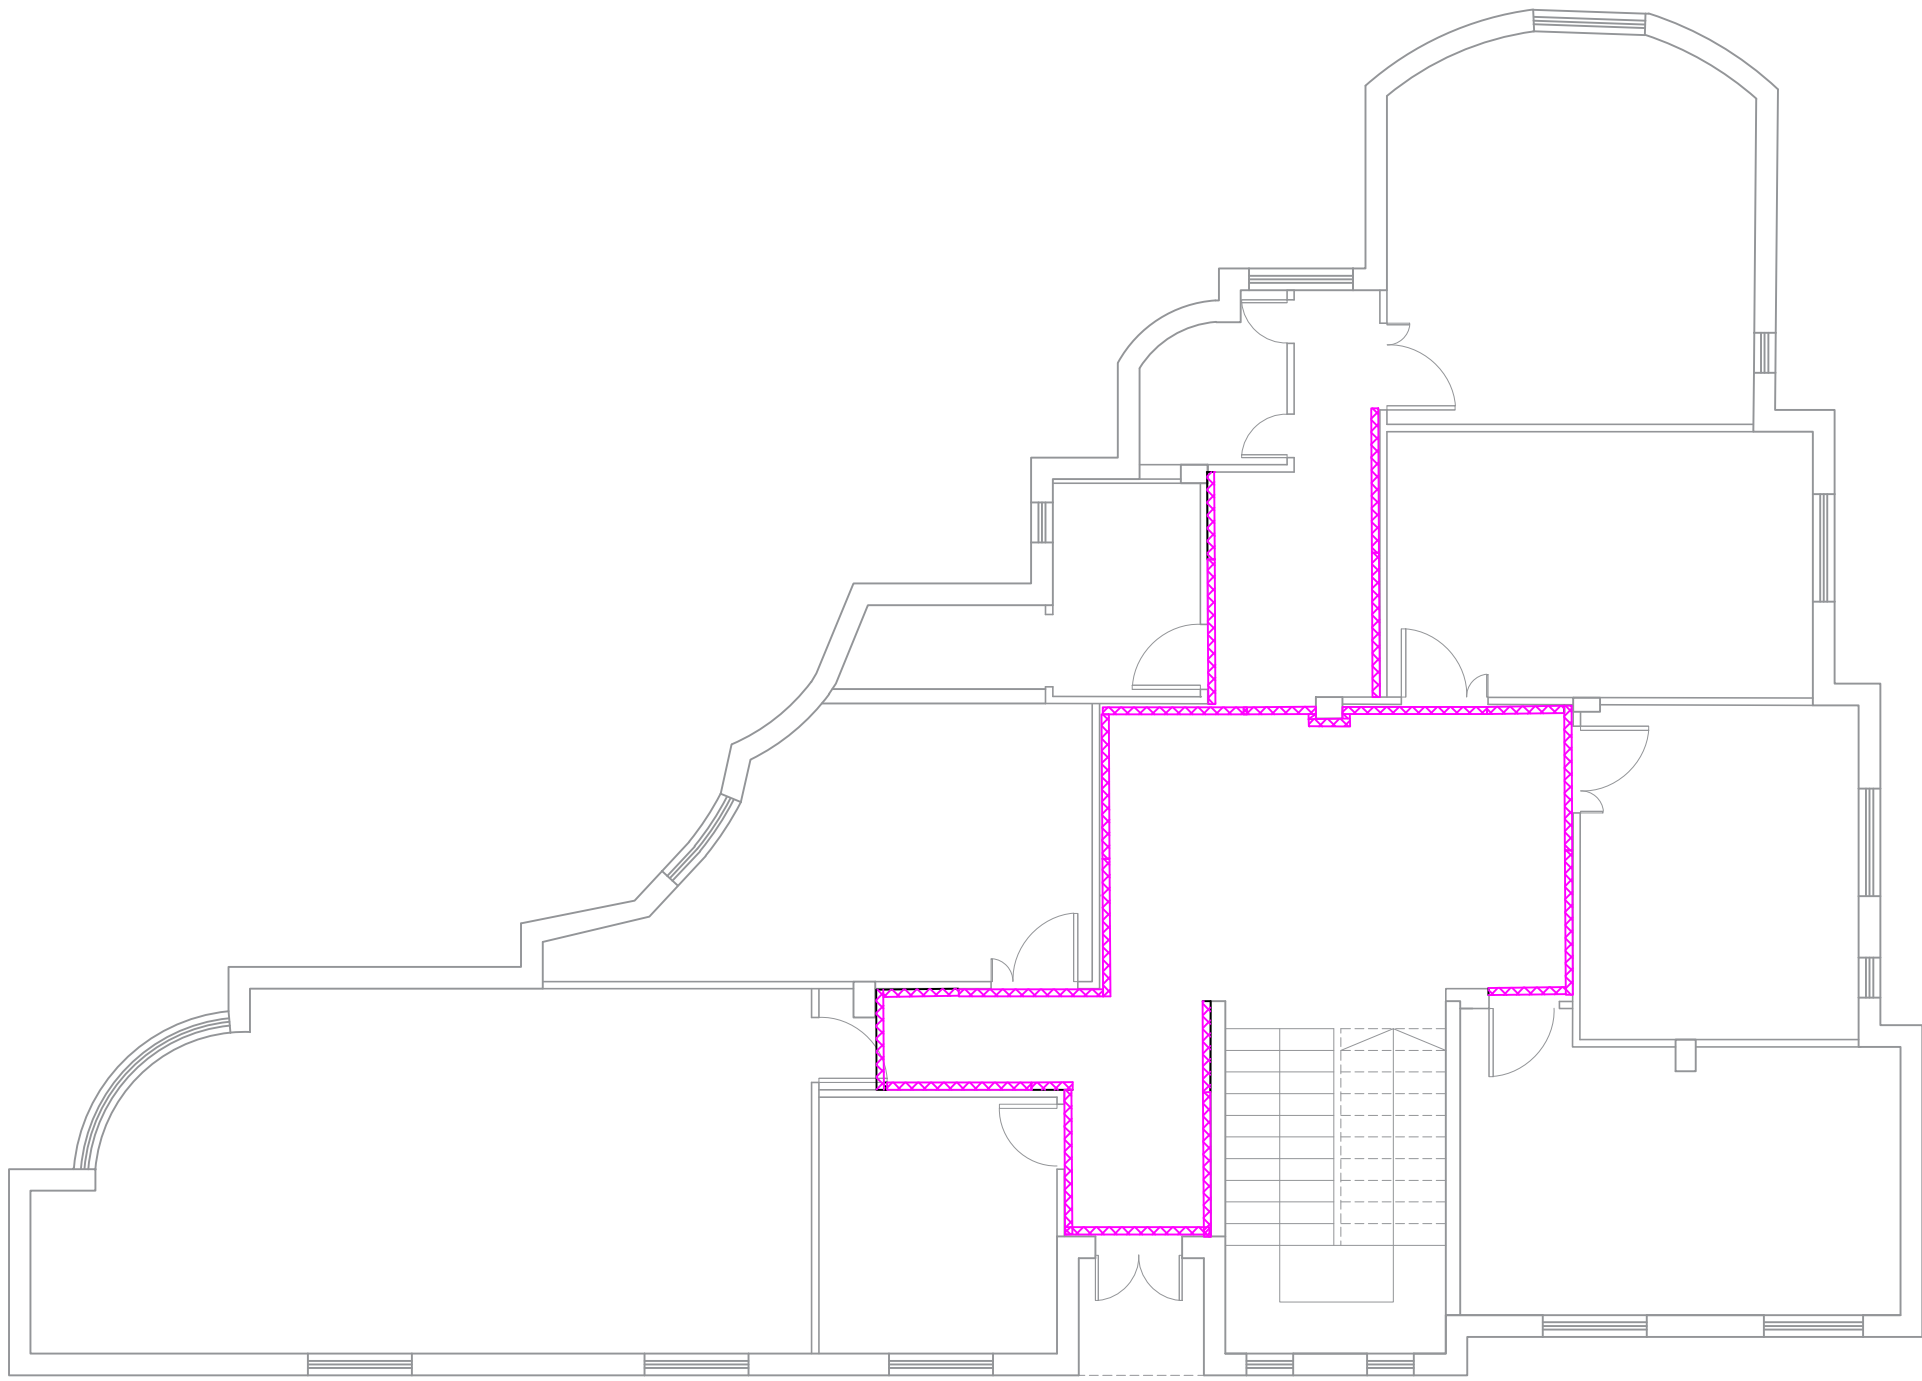

GROUND FLOOR

Notes

(1) All Dimensions Are In M.
(2) All Levels Are In Meter
(3) Any Missing or Unclear Detail And All Fastening Systems For All Elements Shall be Approved by The Supervisor.

Legend:

SECTION NUMBER
REFERENCE SHEET NUMBER

REFERENCE DETAIL SHEET NUMBER

FLOOR FINISH LEVEL (F.F.L.)

REINFORCEMENT CONCRETE LEVEL (R.C.L.)

LEVEL SIGN IN PLAN

STEEL SHEETS

RC CONCRETE FOR COLUMNS

RC CONCRETE FOR WALLS

CONCRETE

STONE WALL

HOLLOW BLOCKS

CEMENT TILE

PORCELAIN TILE

LOCAL MARBLE

Gypsum partition

ENTRANCE

ARTIFICIAL GRASS

PORCELAIN TILES (PARQUET STYLE)

DEMOLISHING AND REMOVAL

NEW INTERVENTION

DOOR NUMBER
REFERENCE DETAIL SHEET NUMBER

WINDOW NUMBER
REFERENCE DETAIL SHEET NUMBER

DETAILED SECTION AT SHEET No. A09

R.C.L.:REN. CONCRETE LEVEL

F.F.L.:FINISH FLOOR LEVEL

S.L.: SEA LEVEL

REVISIONS		
NO.	DRAWINGS	DATE
(1)		
(2)		
(3)		

Contracting Authority:

Funded By:

Project Title:

“Public Works Contract for the rehabilitation of 5 schools in East Jerusalem”

Reference number: PSE22001-10074

Lot 1: the rehabilitation of Al-Hasan Al-Thany, Al-Shabbat Al-Shameleh, and Al-Fata Al-Laji’a schools in Wadi Al-Joz

Al-Shameleh Secondary Girls' school


Designed by:

HOSH STUDIO
ARCHITECTURE & TOWN PLANNING

Jerusalem - Sheikh Jarrah- Tobler8
email: mr.wasimhija@gmail.com

Tel. 02-9948344/ 052-8327076
Fax: 02-9948344

Drawing Title	Scope of Intervention	Date: 25/3/2025 Scale: 1:100
Designed by:	Arch. Hiba Al Ayoubi	Drawing No: E34
Checked by:	Arch. Wasim Abu El-Hija	
Approved by:		
Coordinate Manager:		

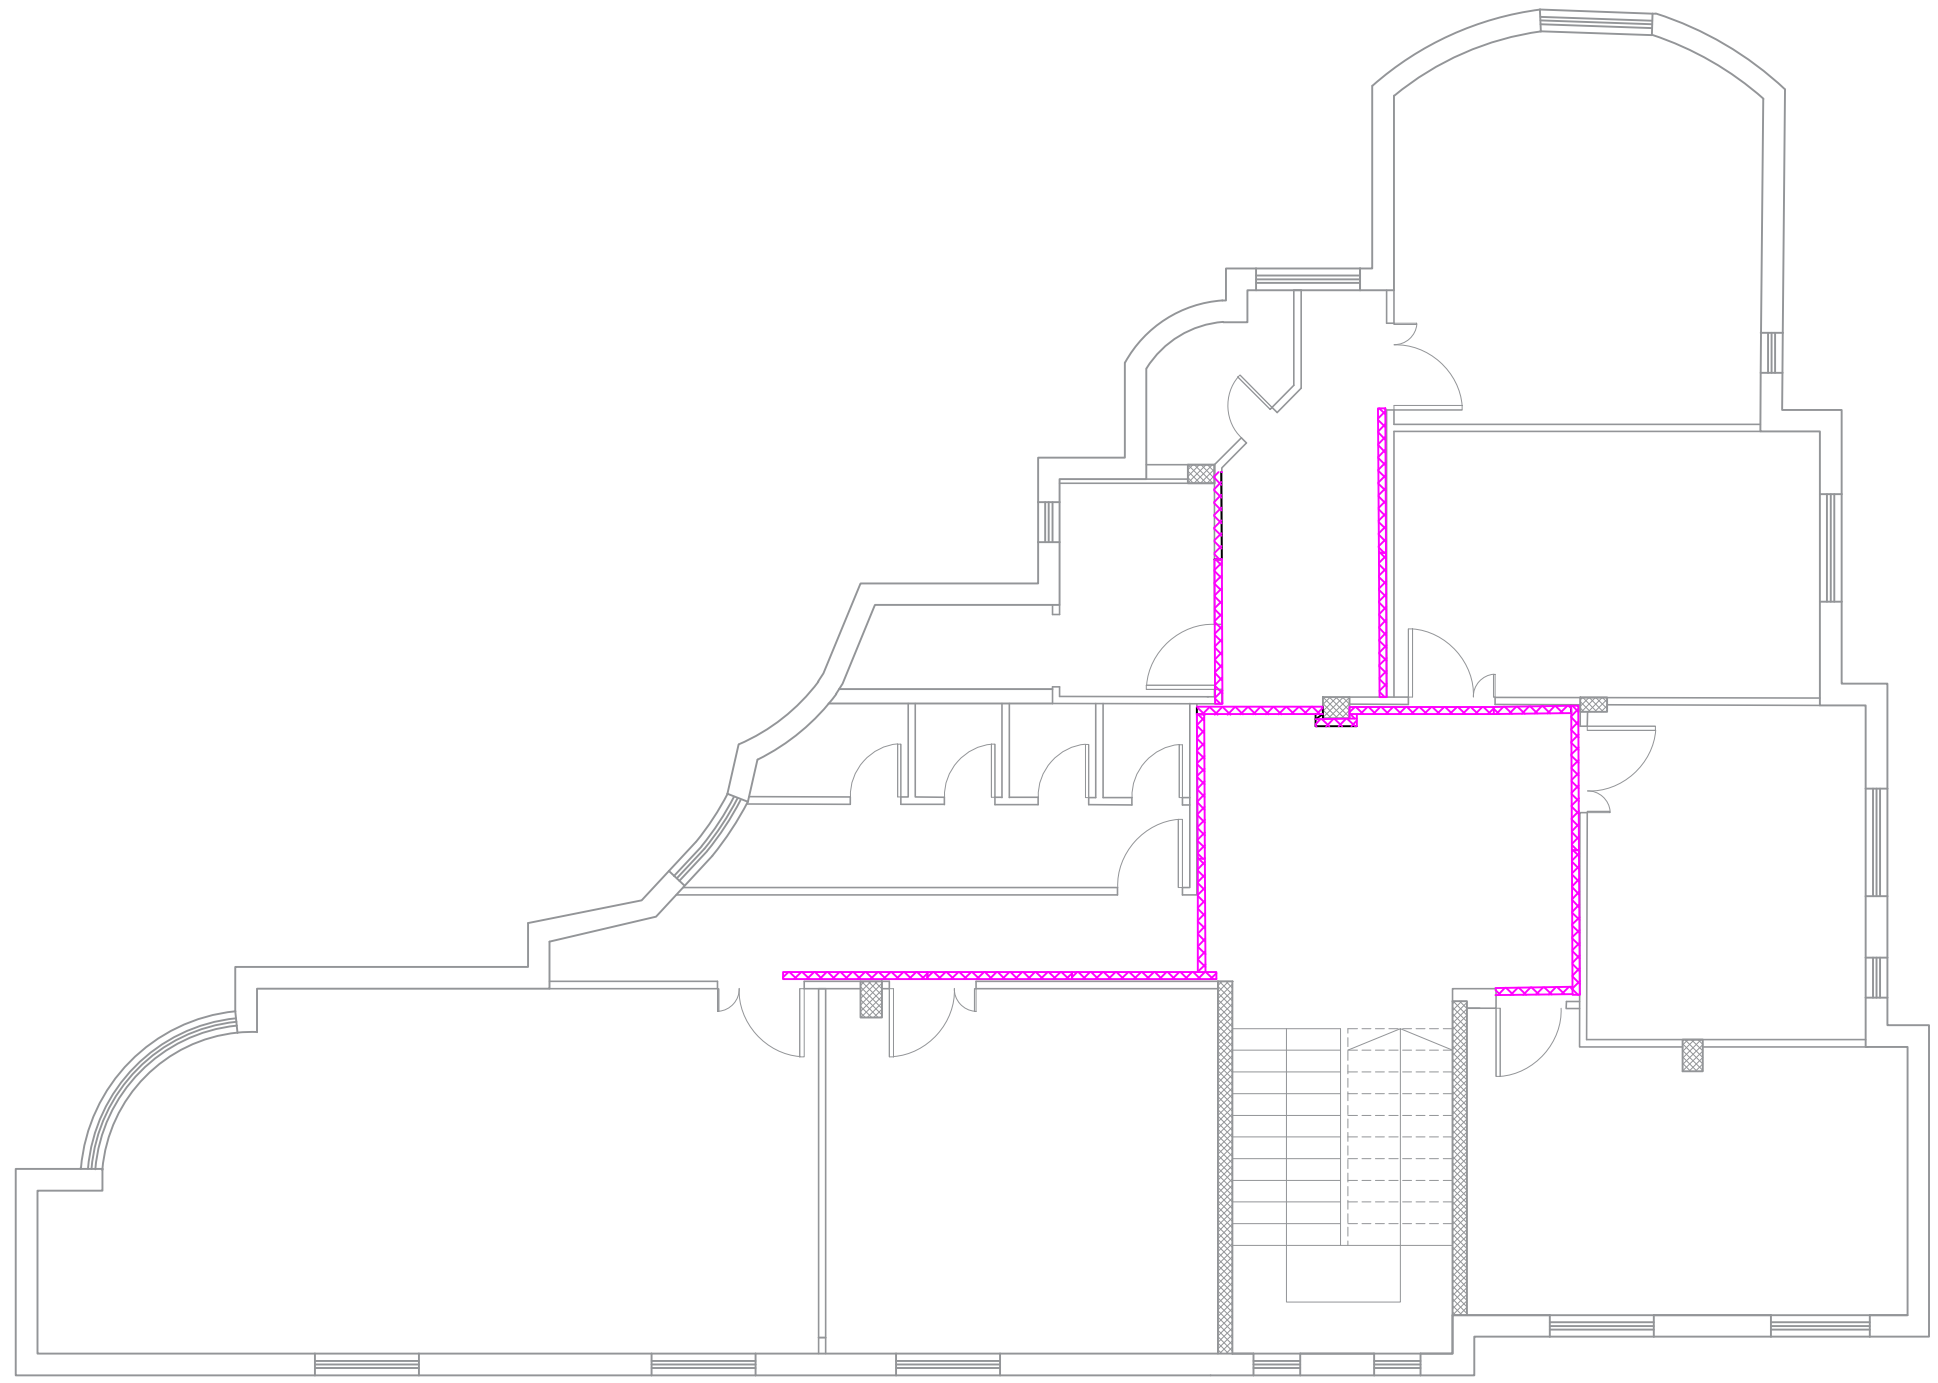

FIRST FLOOR &

Notes

- (1) All Dimensions Are In M.
- (2) All Levels Are In Meter
- (3) Any Missing or Unclear Detail And All Fastening Systems For All Elements Shall be Approved by The Supervisor.

Legend:

SECTION NUMBER
REFERENCE SHEET NUMBER

REFERENCE DETAIL SHEET NUMBER

FLOOR FINISH LEVEL (F.F.L.)

REINFORCEMENT CONCRETE LEVEL (R.C.L.)

LEVEL SIGN IN PLAN

STEEL SHEETS

RC CONCRETE FOR COLUMNS

RC CONCRETE FOR WALLS

STONE WALL

HOLLOW BLOCKS

CEMENT TILE

PORCELAIN TILE

LOCAL MARBLE

Gypsum partition

ENTRANCE

ARTIFICIAL GRASS

PORCELAIN TILES (PARQUET STYLE)

DEMOLISHING AND REMOVAL

NEW INTERVENTION

DOOR NUMBER
REFERENCE DETAIL SHEET NUMBER

WINDOW NUMBER
REFERENCE DETAIL SHEET NUMBER

ROOM CODE
AREA
ROOM ID

DETAILED SECTION AT SHEET No. A09

R.C.L.: REN. CONCRETE LEVEL

F.F.L.: FINISH FLOOR LEVEL

S.L.: SEA LEVEL

REVISIONS

NO.	DRAWINGS	DATE
(1)		
(2)		
(3)		

Contracting Authority:



Funded By:



Project Title:

“Public Works Contract for the rehabilitation of 5 schools in East Jerusalem”

Reference number: PSE22001-10074

Lot 1: the rehabilitation of Al-Hasan Al-Thany, Al-Shabbat Al-Shameleh, and Al-Fata Al-Laji’a schools in Wadi Al-Joz


Al-Shameleh Secondary Girls' school

Designed by:



Jerusalem - Sheikh Jarrah- Tobler8
email: mr.wasimhija@gmail.com
Tel. 02-9948344/ 052-8327076
Fax: 02-9948344

Drawing Title	Scope of Intervention	Date: 25/3/2025 Scale: 1:100
Designed by:	Arch. Hiba Al Ayoubi	Drawing No: E35
Checked by:	Arch. Wasim Abu El-Hija	
Approved by:		
Coordinate Manager:		

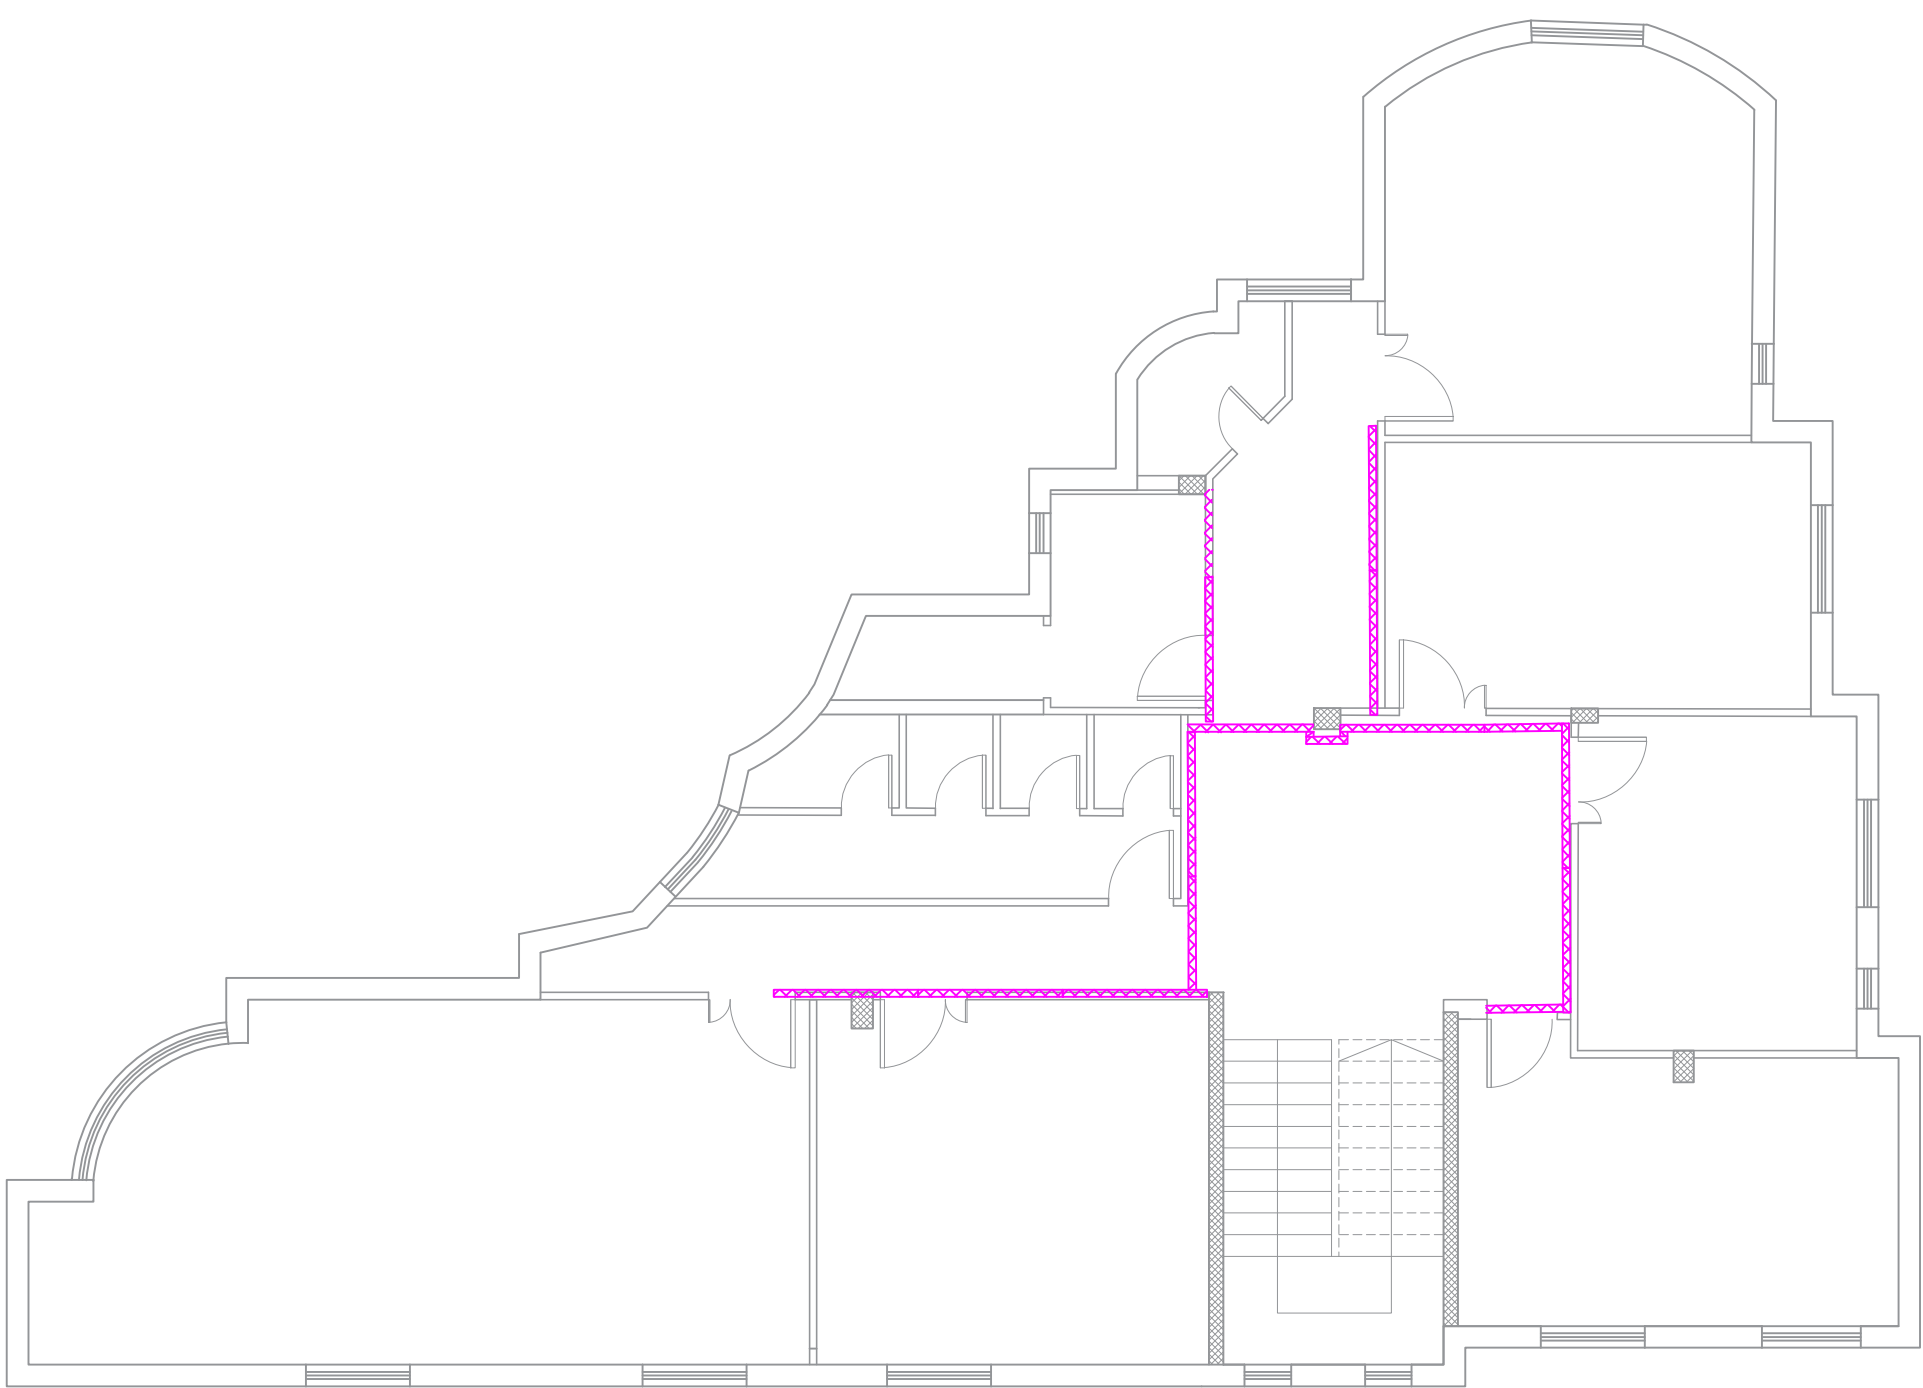

SECOND FLOOR

Notes

(1) All Dimensions Are In M.

(2) All Levels Are In Meter

(3) Any Missing or Unclear Detail And All Fastening Systems For All Elements Shall be Approved by The Supervisor.

Legend:

SECTION NUMBER
REFERENCE SHEET NUMBER

REFERENCE DETAIL SHEET NUMBER

FLOOR FINISH LEVEL (F.F.L.)
REINFORCEMENT CONCRETE LEVEL (R.C.L.)

LEVEL SIGN IN PLAN

ROOM CODE
FUNCTION AREA
ROOM ID

DOOR NUMBER
REFERENCE DETAIL SHEET NUMBER

WINDOW NUMBER
REFERENCE DETAIL SHEET NUMBER

X X
DETAILED SECTION AT SHEET No. A09

STEEL SHEETS

RC CONCRETE FOR COLUMNS

RC CONCRETE FOR WALLS

CONCRETE

STONE WALL

HOLLOW BLOCKS

CEMENT TILE

PORCELAIN TILE

LOCAL MARBLE

Gypsum partition

ENTRANCE

ARTIFICIAL GRASS

PORCELAIN TILES (PARQUET STYLE)

DEMOLISHING AND REMOVAL

NEW INTERVENTION

R.C.L.: REN. CONCRETE LEVEL

F.F.L.: FINISH FLOOR LEVEL

S.L.: SEA LEVEL

REVISIONS		
NO.	DRAWINGS	DATE
(1)		
(2)		
(3)		

Contracting Authority:

Funded By:

Project Title:

“Public Works Contract for the rehabilitation of 5 schools in East Jerusalem”

Reference number: PSE22001-10074

Lot 1: the rehabilitation of Al-Hasan Al-Thany, Al-Shabbat Al-Shameleh, and Al-Fata Al-Laji’a schools in Wadi Al-Joz

Al-Shameleh Secondary Girls' school


Designed by:

HOSH STUDIO
ARCHITECTURE & TOWN PLANNING

Jerusalem - Sheikh Jarrah- Tobler8
email: mr.wasimhija@gmail.com

Tel. 02-9948344/ 052-8327076
Fax: 02-9948344

Drawing Title	Scope of Intervention	Date: 25/3/2025 Scale: 1:100
Designed by:	Arch. Hiba Al Ayoubi	Drawing No: E36
Checked by:	Arch. Wasim Abu El-Hija	
Approved by:		
Coordinate Manager:		

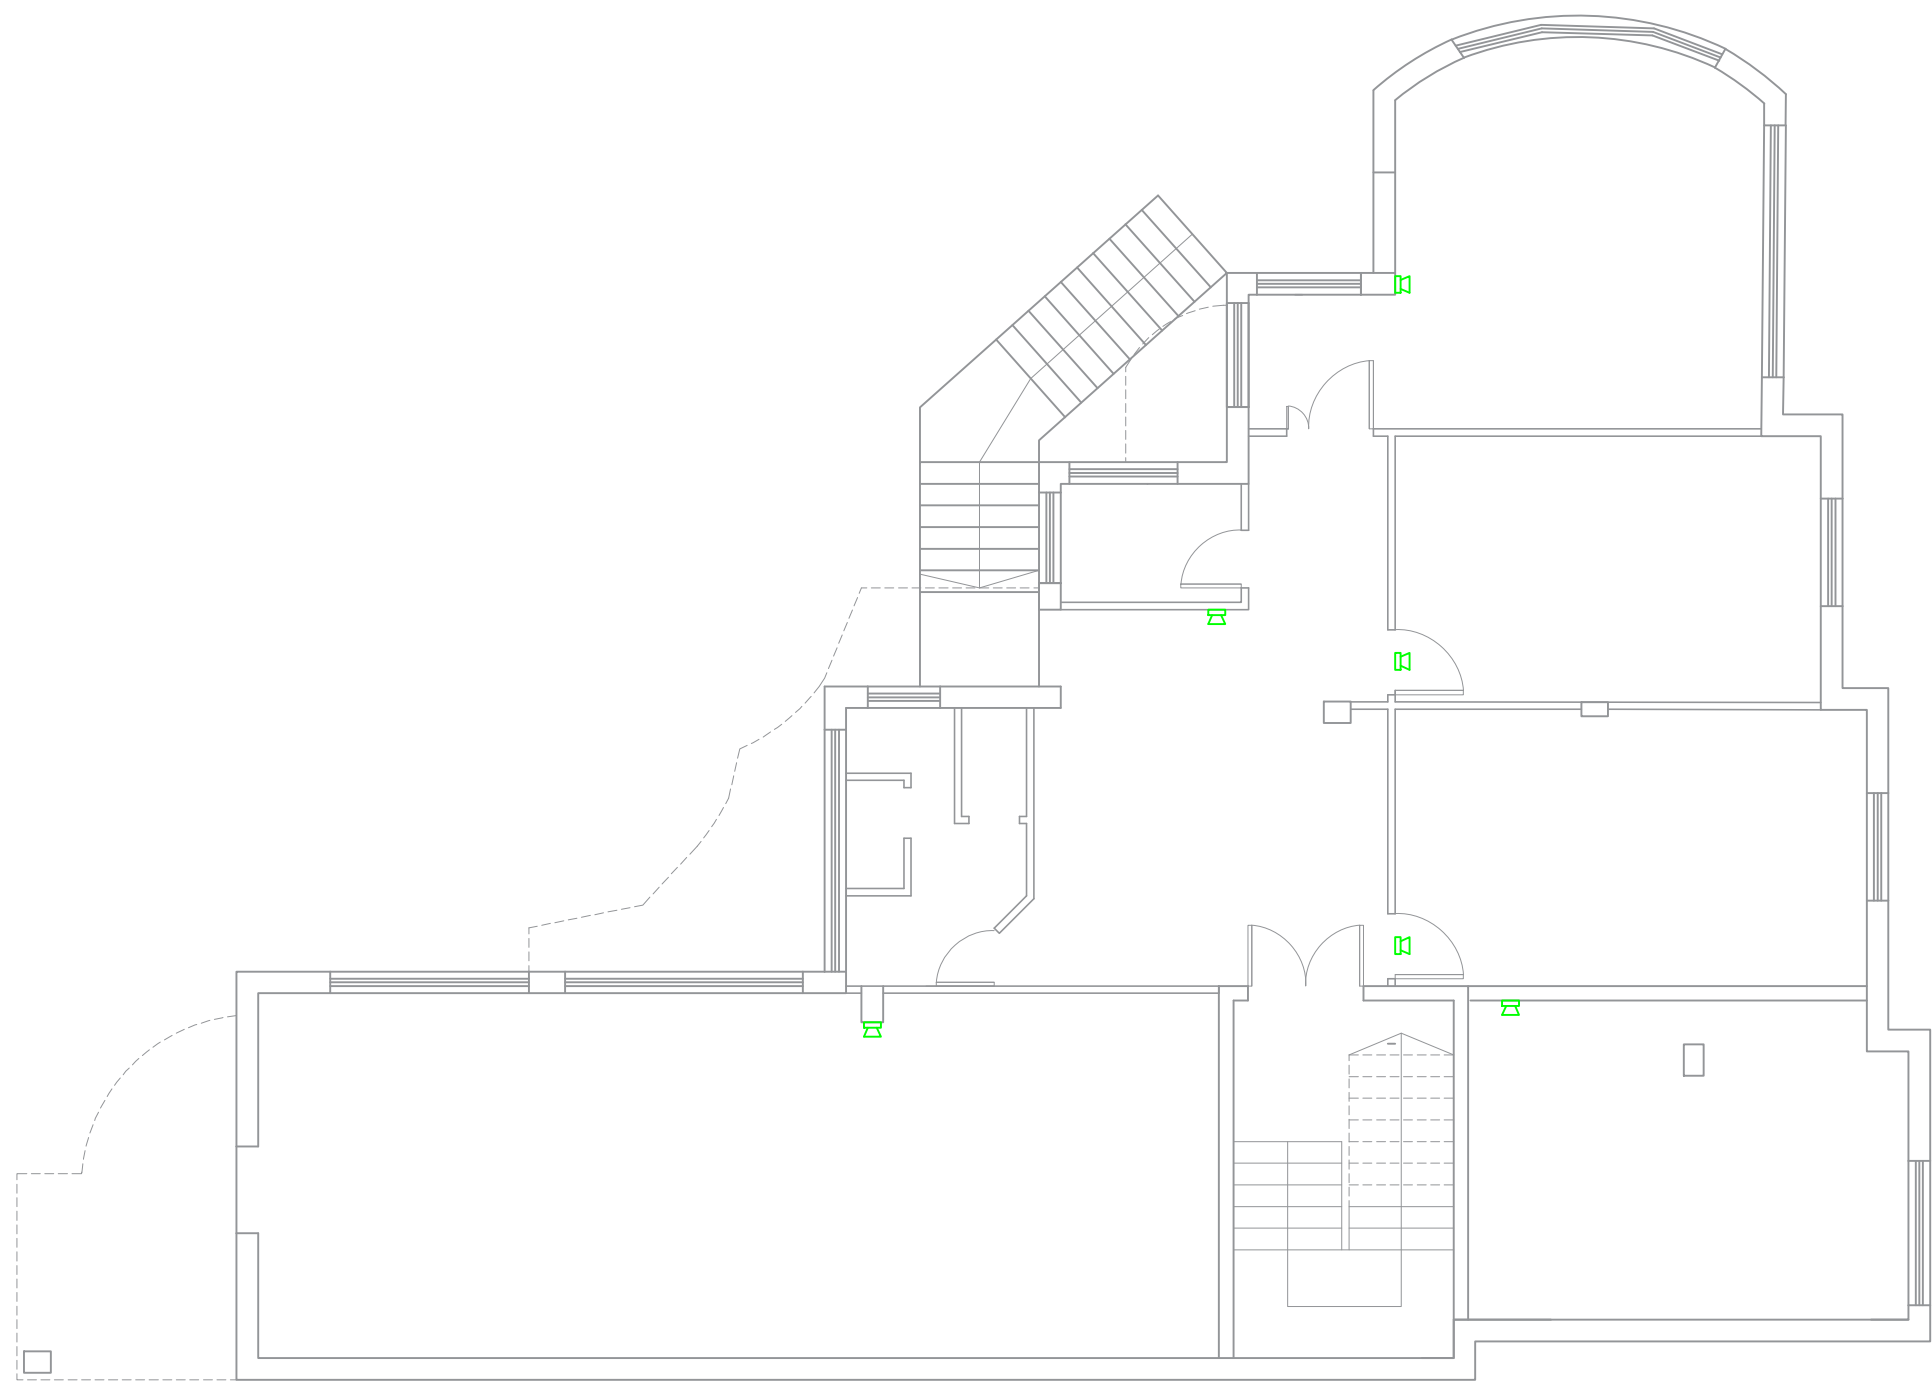

BASEMENT FLOOR

Notes

(1) All Dimensions Are In M.
(2) All Levels Are In Meter
(3) Any Missing or Unclear Detail And All Fastening Systems For All Elements Shall be Approved by The Supervisor.

Legend:

SECTION NUMBER
REFERENCE SHEET NUMBER

REFERENCE DETAIL SHEET NUMBER

FLOOR FINISH LEVEL (F.F.L.)
REINFORCEMENT CONCRETE LEVEL (R.C.L.)

LEVEL SIGN IN PLAN

STEEL SHEETS

RC CONCRETE FOR COLUMNS

RC CONCRETE FOR WALLS

STONE WALL

HOLLOW BLOCKS

CEMENT TILE

PORCELAIN TILE

LOCAL MARBLE

Gypsum partition

ROOM CODE
FUNCTION
AREA
ROOM ID

DOOR NUMBER
REFERENCE DETAIL SHEET NUMBER

WINDOW NUMBER
REFERENCE DETAIL SHEET NUMBER

ENTRANCE

ARTIFICIAL GRASS

PORCELAIN TILES (PARQUET STYLE)

DEMOLISHING AND REMOVAL

NEW INTERVENTION

R.C.L.:REN. CONCRETE LEVEL

F.F.L.:FINISH FLOOR LEVEL

S.L. : SEA LEVEL

DETAILED SECTION AT SHEET No. A09

REVISIONS

NO.	DRAWINGS	DATE
(1)		
(2)		
(3)		

Contracting Authority:

Enabel

Funded By:

Belgium

partner in development

Project Title:

“Public Works Contract for the rehabilitation of 5 schools in East Jerusalem”

Reference number: PSE22001-10074

Lot 1: the rehabilitation of Al-Hasan Al-Thany, Al-Shabbat Al-Shameleh, and Al-Fata Al-Laji’a schools in Wadi Al-Joz

Al-Shameleh Secondary Girls' school

Designed by:


HOSH STUDIO

ARCHITECTURE & TOWN PLANNING

Jerusalem - Sheikh Jarrah- Tobler8
email: mr.wasimhija@gmail.com

Tel. 02-9948344/ 052-8327076
Fax: 02-9948344

Drawing Title	Scope of Intervention public Address System	Date: 25/3/2025 Scale: 1:100
Designed by:	Arch. Hiba Al Ayoubi	Drawing No:
Checked by:	Arch. Wasim Abu El-Hija	E37
Approved by:		
Coordinate Manager:		

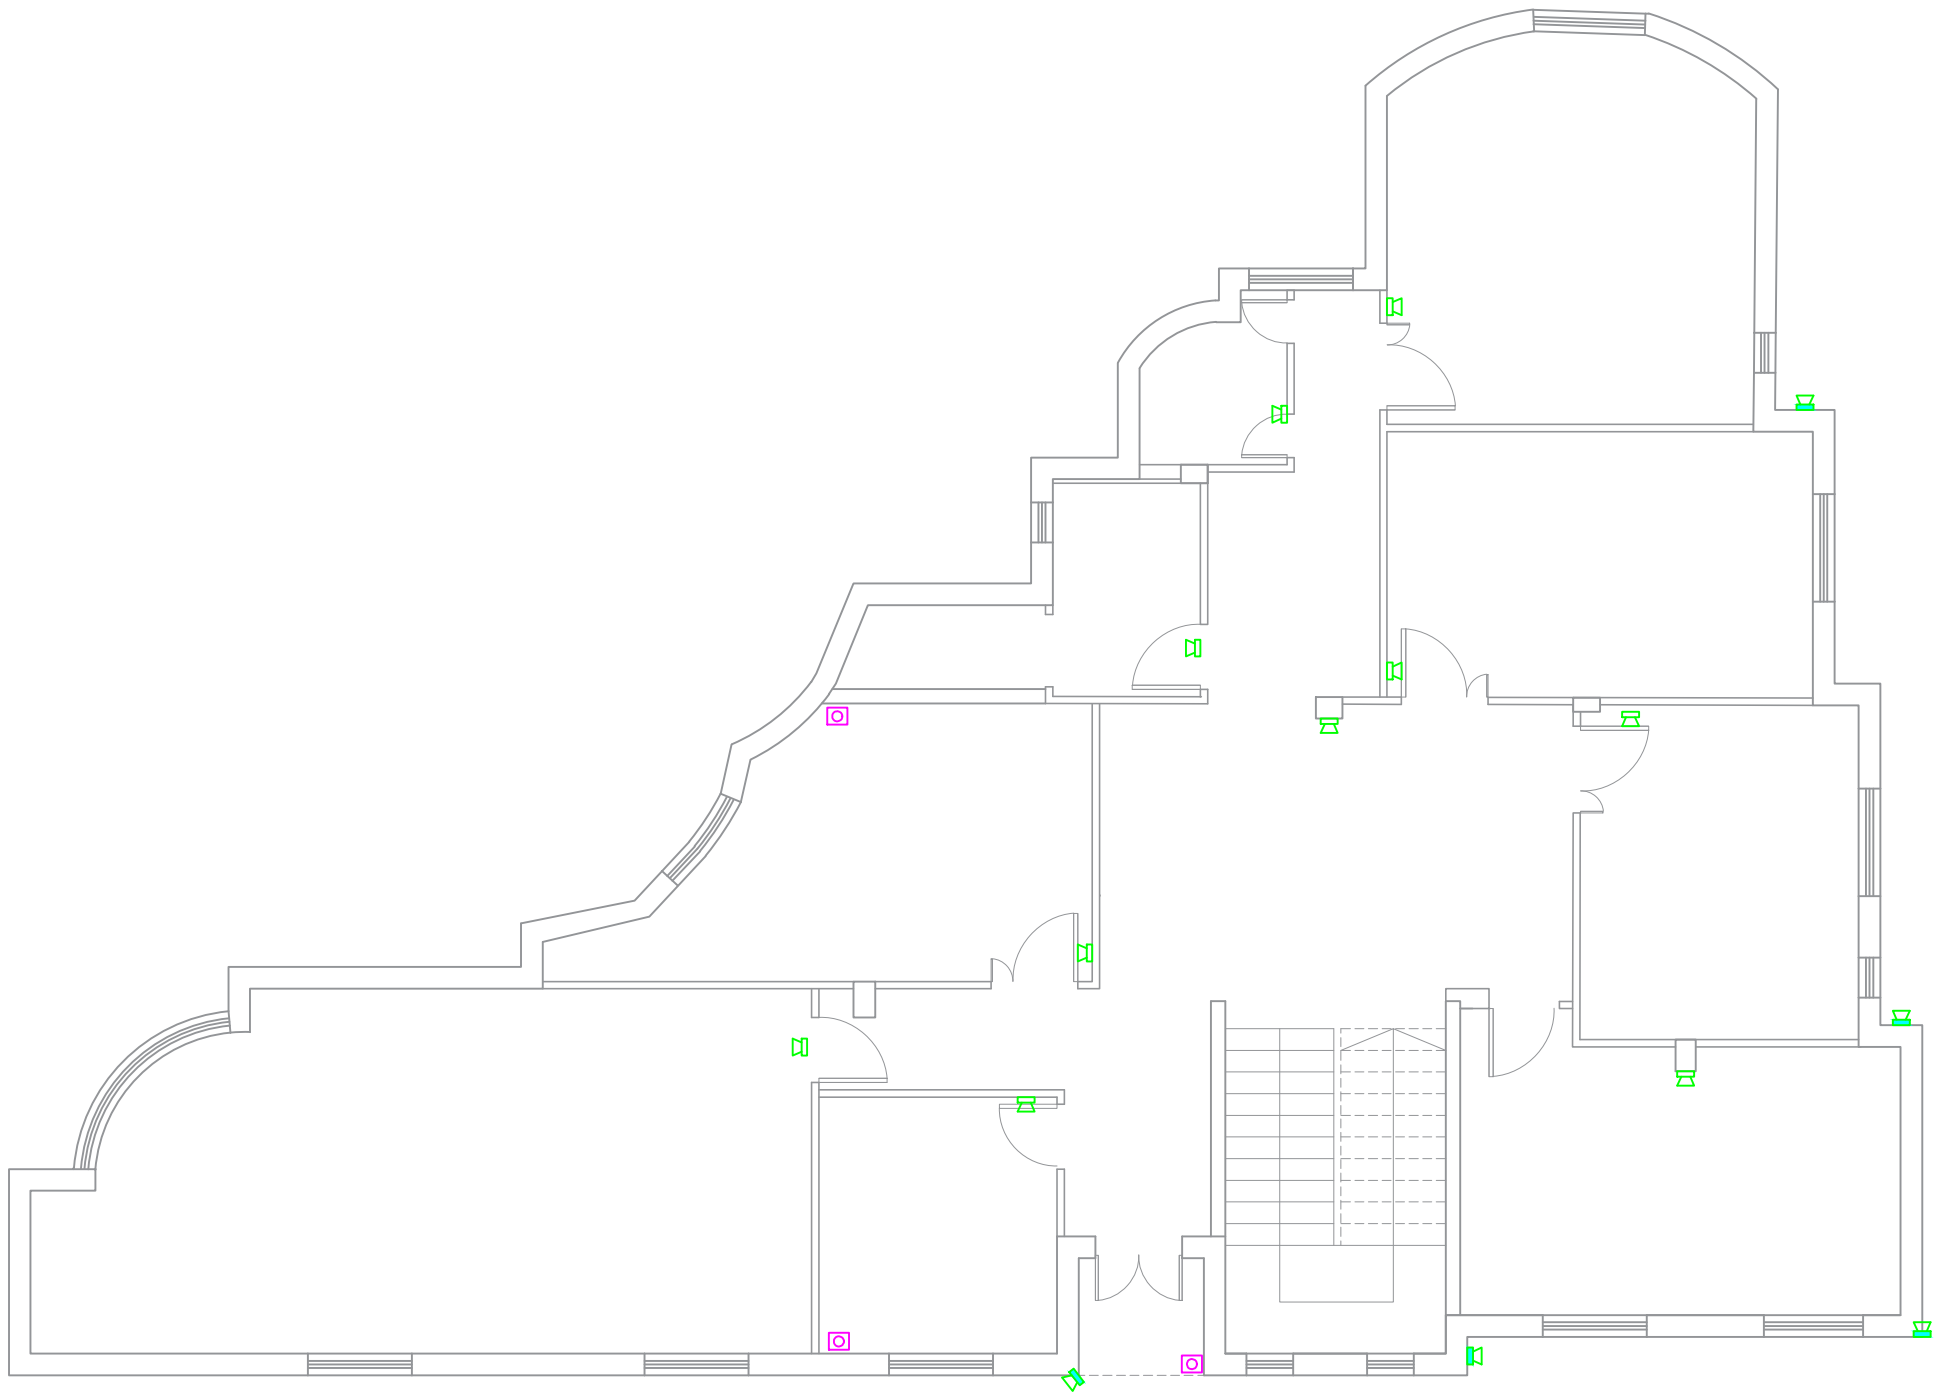

GROUND FLOOR

Notes

(1) All Dimensions Are In M.
(2) All Levels Are In Meter
(3) Any Missing or Unclear Detail And All Fastening Systems For All Elements Shall be Approved by The Supervisor.

Legend:

SECTION NUMBER
REFERENCE SHEET NUMBER

REFERENCE DETAIL SHEET NUMBER

FLOOR FINISH LEVEL (F.F.L.)
REINFORCEMENT CONCRETE LEVEL (R.C.L.)

LEVEL SIGN IN PLAN

STEEL SHEETS

RC CONCRETE FOR COLUMNS

RC CONCRETE FOR WALLS

CONCRETE

STONE WALL

HOLLOW BLOCKS

CEMENT TILE

PORCELAIN TILE

LOCAL MARBLE

Gypsum partition

ENTRANCE

ARTIFICIAL GRASS

PORCELAIN TILES (PARQUET STYLE)

DEMOLISHING AND REMOVAL

NEW INTERVENTION

DOOR NUMBER
REFERENCE DETAIL SHEET NUMBER

WINDOW NUMBER
REFERENCE DETAIL SHEET NUMBER

DETAILED SECTION AT SHEET No. A09

ROOM CODE
ROOM ID

FUNCTION AREA

R.C.L.: REN. CONCRETE LEVEL

F.F.L.: FINISH FLOOR LEVEL

S.L.: SEA LEVEL

REVISIONS		
NO.	DRAWINGS	DATE
(1)		
(2)		
(3)		

Contracting Authority:

Funded By:

Project Title:

“Public Works Contract for the rehabilitation of 5 schools in East Jerusalem”

Reference number: PSE22001-10074

Lot 1: the rehabilitation of Al-Hasan Al-Thany, Al-Shabbat Al-Shameleh, and Al-Fata Al-Laji’a schools in Wadi Al-Joz

Al-Shameleh Secondary Girls' school

Designed by:

HOSH STUDIO
ARCHITECTURE & TOWN PLANNING

Jerusalem - Sheikh Jarrah- Tobler8
email: mr.wasimhija@gmail.com

Tel. 02-9948344/ 052-8327076
Fax: 02-9948344

Drawing Title	Scope of Intervention	Date: 25/3/2025 Scale: 1:100
Designed by:	Arch. Hiba Al Ayoubi	Drawing No: E38
Checked by:	Arch. Wasim Abu El-Hija	
Approved by:		
Coordinate Manager:		



FIRST FLOOR &

Notes

- (1) All Dimensions Are In M.
- (2) All Levels Are In Meter
- (3) Any Missing or Unclear Detail And All Fastening Systems For All Elements Shall be Approved by The Supervisor.

Legend:

	SECTION NUMBER		ROOM CODE		FUNCTION AREA
	REFERENCE SHEET NUMBER		ROOM ID		
	DOOR NUMBER		WINDOW NUMBER		
	FLOOR FINISH LEVEL (F.F.L.)		REINFORCEMENT CONCRETE LEVEL (R.C.L.)		
	LEVEL SIGN IN PLAN		DETAILED SECTION AT SHEET No. A09		

	STEEL SHEETS		ENTRANCE
	RC CONCRETE FOR COLUMNS		ARTIFICIAL GRASS
	RC CONCRETE FOR WALLS		PORCELAIN TILES (PARQUET STYLE)
	CONCRETE		DEMOLISHING AND REMOVAL
	STONE WALL		NEW INTERVENTION
	HOLLOW BLOCKS		
	CEMENT TILE		
	PORCELAIN TILE		
	LOCAL MARBLE		
	Gypsum partition		

	R.C.L.: REN. CONCRETE LEVEL
	F.F.L.: FINISH FLOOR LEVEL
	S.L.: SEA LEVEL

REVISIONS

NO.	DRAWINGS	DATE
(1)		
(2)		
(3)		

Contracting Authority:



Funded By:



Project Title:

“Public Works Contract for the rehabilitation of 5 schools in East Jerusalem”

Reference number: PSE22001-10074

Lot 1: the rehabilitation of Al-Hasan Al-Thany, Al-Shabbat Al-Shameleh, and Al-Fata Al-Laji’a schools in Wadi Al-Joz

Al-Shameleh Secondary Girls' school

Designed by:



Jerusalem - Sheikh Jarrah- Tobler8
email: mr.wasimhija@gmail.com
Tel. 02-9948344/ 052-8327076
Fax: 02-9948344

Drawing Title	Scope of Intervention public Address System	Date: 25/3/2025 Scale: 1:100
Designed by:	Arch. Hiba Al Ayoubi	Drawing No:
Checked by:	Arch. Wasim Abu El-Hija	E39
Approved by:		
Coordinate Manager:		



SECOND FLOOR

Notes

- (1) All Dimensions Are In M.
- (2) All Levels Are In Meter
- (3) Any Missing or Unclear Detail And All Fastening Systems For All Elements Shall be Approved by The Supervisor.

Legend:

SECTION NUMBER
REFERENCE SHEET NUMBER

REFERENCE DETAIL SHEET NUMBER

FLOOR FINISH LEVEL (F.F.L.)

REINFORCEMENT CONCRETE LEVEL (R.C.L.)

LEVEL SIGN IN PLAN

STEEL SHEETS

RC CONCRETE FOR COLUMNS

RC CONCRETE FOR WALLS

CONCRETE

STONE WALL

HOLLOW BLOCKS

CEMENT TILE

PORCELAIN TILE

LOCAL MARBLE

Gypsum partition

ENTRANCE

ARTIFICIAL GRASS

PORCELAIN TILES (PARQUET STYLE)

DEMOLISHING AND REMOVAL

NEW INTERVENTION

DOOR NUMBER
REFERENCE DETAIL SHEET NUMBER

WINDOW NUMBER
REFERENCE DETAIL SHEET NUMBER

DETAILED SECTION AT SHEET No. A09

R.C.L.:REN. CONCRETE LEVEL

F.F.L.:FINISH FLOOR LEVEL

S.L. : SEA LEVEL

REVISIONS

NO.	DRAWINGS	DATE
(1)		
(2)		
(3)		

Contracting Authority:



Funded By:



Project Title:

“Public Works Contract for the rehabilitation of 5 schools in East Jerusalem”

Reference number: PSE22001-10074

Lot 1: the rehabilitation of Al-Hasan Al-Thany, Al-Shabbat Al-Shameleh, and Al-Fata Al-Laji’a schools in Wadi Al-Joz


Al-Shameleh Secondary Girls' school

Designed by:



Jerusalem - Sheikh Jarrah- Tobler8
email: mr.wasimhija@gmail.com
Tel. 02-9948344/ 052-8327076
Fax: 02-9948344

Drawing Title	Scope of Intervention	Date: 25/3/2025 Scale: 1:100
Designed by:	Arch. Hiba Al Ayoubi	Drawing No:
Checked by:	Arch. Wasim Abu El-Hija	E40
Approved by:		
Coordinate Manager:		

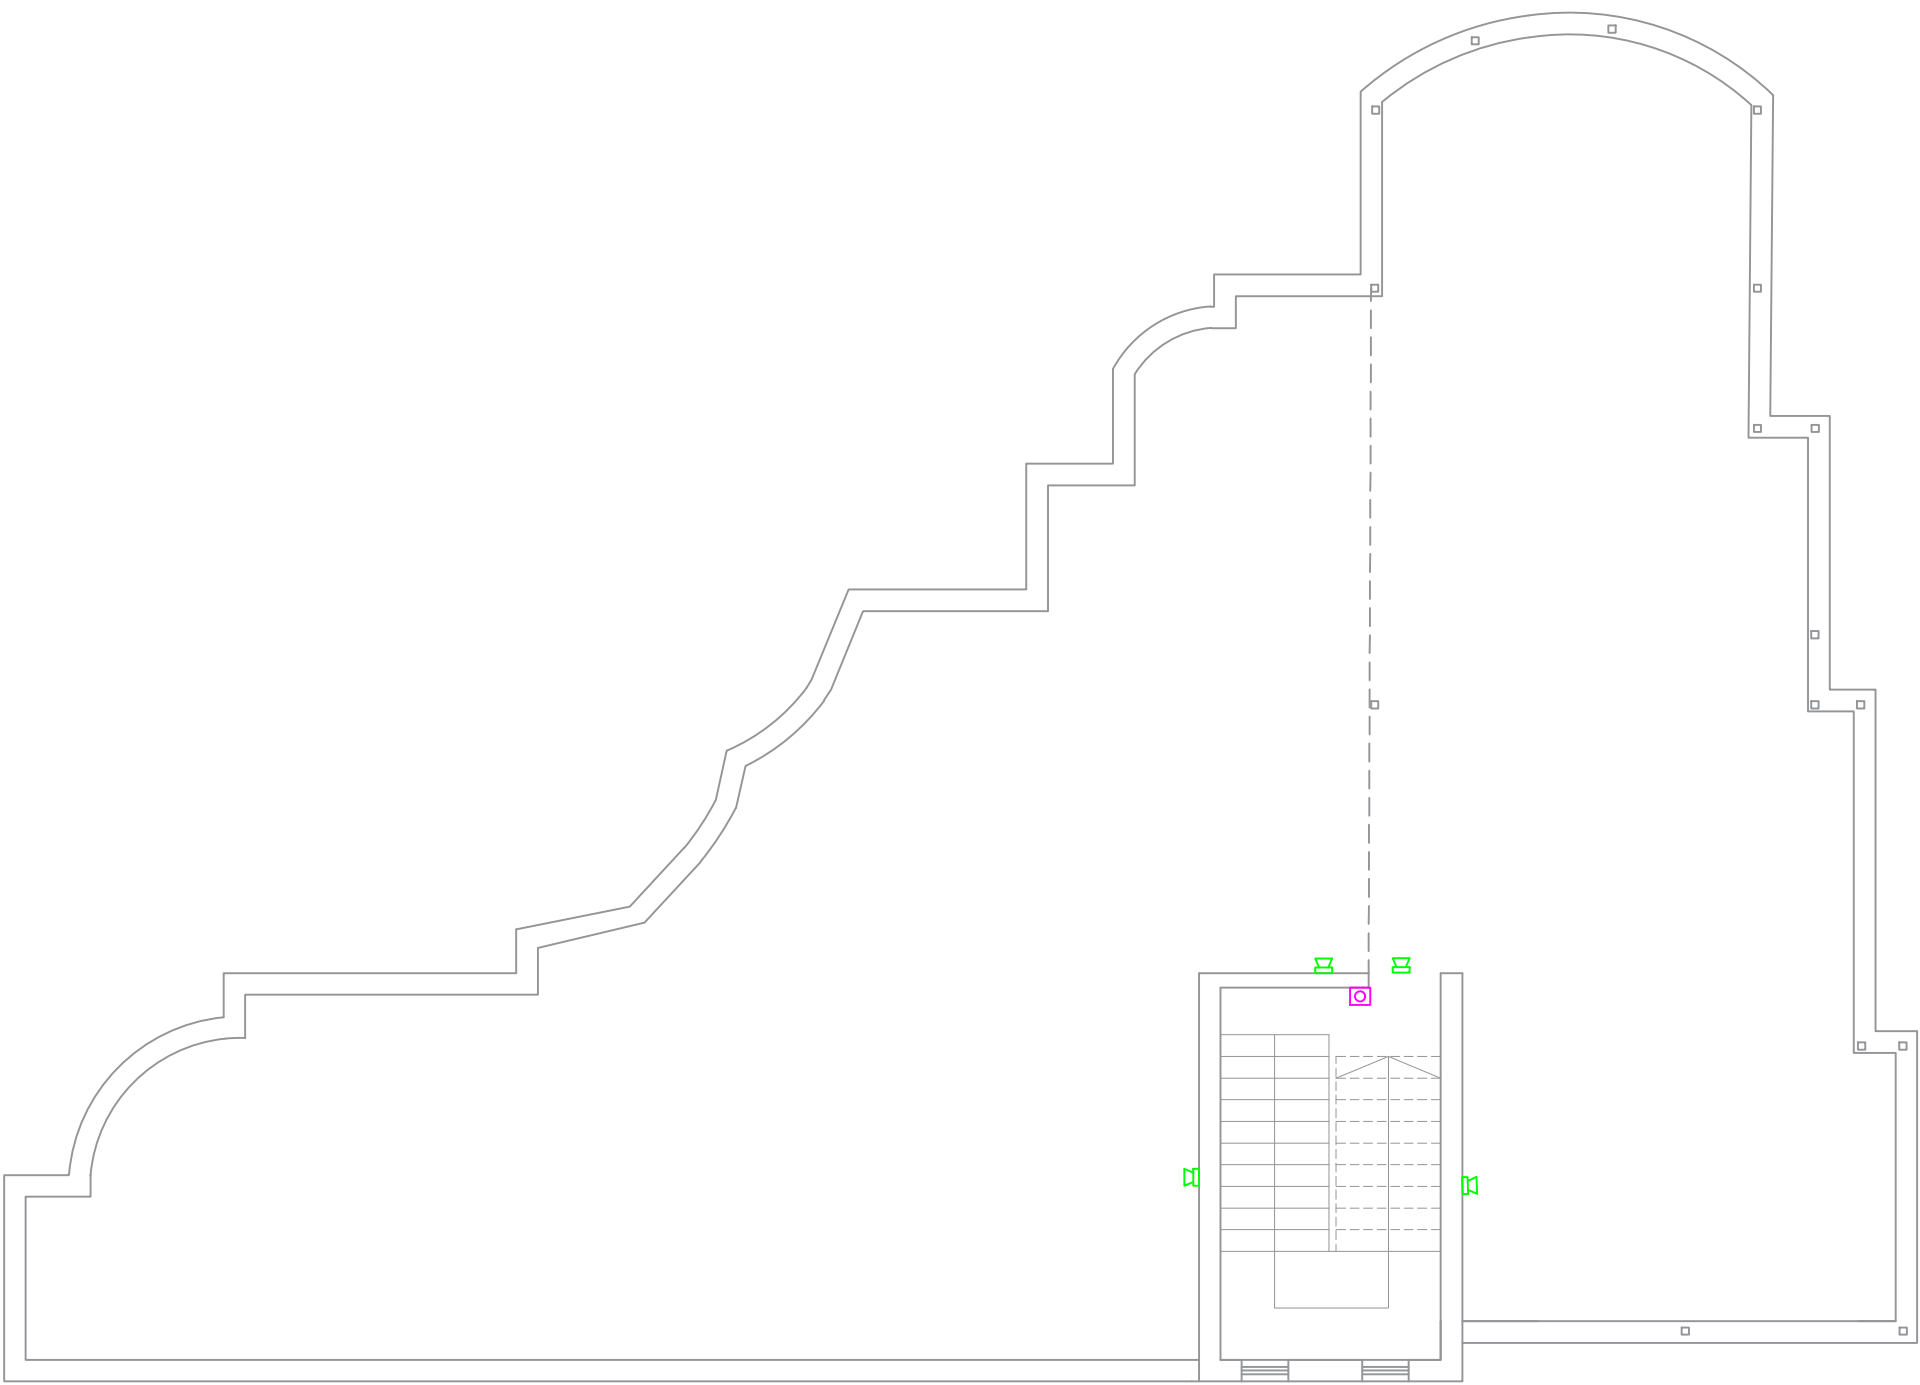

ROOF FLOOR PLAN

Notes

(1) All Dimensions Are In M.
(2) All Levels Are In Meter
(3) Any Missing or Unclear Detail And All Fastening Systems For All Elements Shall be Approved by The Supervisor.

Legend:

SECTION NUMBER
REFERENCE SHEET NUMBER

REFERENCE DETAIL SHEET NUMBER

FLOOR FINISH LEVEL (F.F.L.)
REINFORCEMENT CONCRETE LEVEL (R.C.L.)

LEVEL SIGN IN PLAN

ROOM CODE
FUNCTION
AREA
ROOM ID

DOOR NUMBER
REFERENCE DETAIL SHEET NUMBER

WINDOW NUMBER
REFERENCE DETAIL SHEET NUMBER

DETAILED SECTION AT SHEET No. A09

STEEL SHEETS

RC CONCRETE FOR COLUMNS

RC CONCRETE FOR WALLS

STONE WALL

HOLLOW BLOCKS

CEMENT TILE

PORCELAIN TILE

LOCAL MARBLE

Gypsum partition

ENTRANCE

ARTIFICIAL GRASS

PORCELAIN TILES (PARQUET STYLE)

DEMOLISHING AND REMOVAL

NEW INTERVENTION

R.C.L.: REN. CONCRETE LEVEL

F.F.L.: FINISH FLOOR LEVEL

S.L. : SEA LEVEL

REVISIONS		
NO.	DRAWINGS	DATE
(1)		
(2)		
(3)		

Contracting Authority:

Funded By:

Project Title:

“Public Works Contract for the rehabilitation of 5 schools in East Jerusalem”

Reference number: PSE22001-10074

Lot 1: the rehabilitation of Al-Hasan Al-Thany, Al-Shabbat Al-Shameleh, and Al-Fata Al-Laji’a schools in Wadi Al-Joz

Al-Shameleh Secondary Girls' school

Designed by:

HOSH STUDIO
ARCHITECTURE & TOWN PLANNING

Jerusalem - Sheikh Jarrah- Tobler8
email: mr.wasimhija@gmail.com

Tel. 02-9948344/ 052-8327076
Fax: 02-9948344

Drawing Title	Scope of Intervention Public Address System	Date: 25/3/2025 Scale: 1:100
Designed by:	Arch. Hiba Al Ayoubi	Drawing No: E41
Checked by:	Arch. Wasim Abu El-Hija	
Approved by:		
Coordinate Manager:		

From JEDCO



MDB

DB G - AC

DB G

MDB

KWH

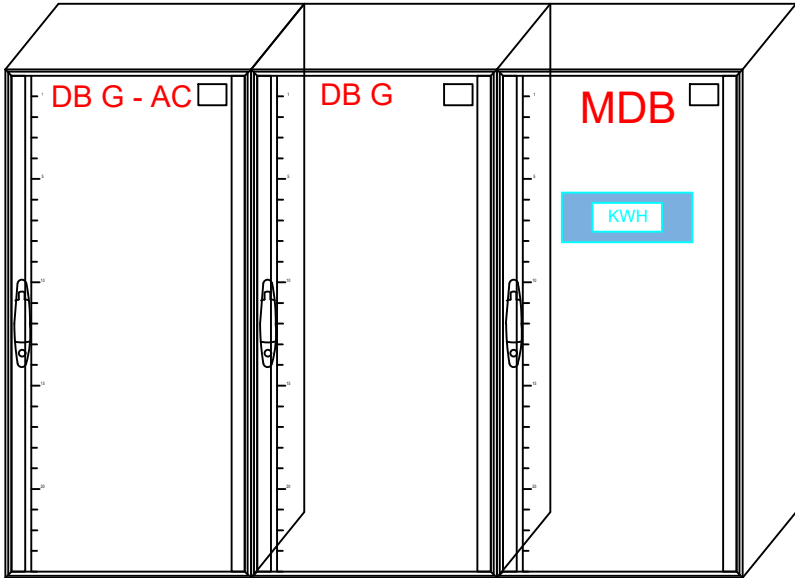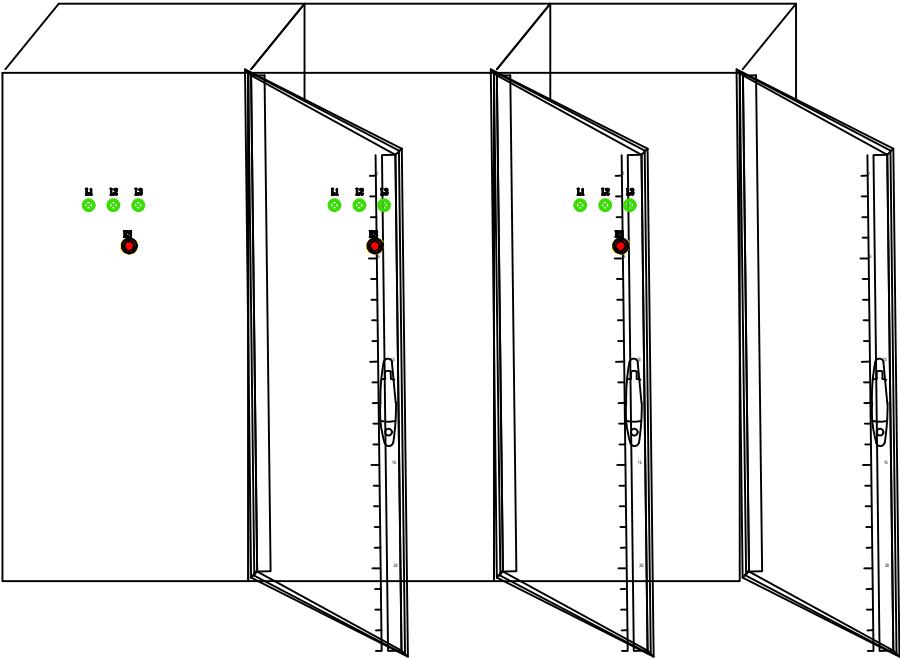

Notes

- (1) All Dimensions Are In M.
(2) All Levels Are In Meter
(3) Any Missing or Unclear Detail And All Fastening Systems For All Elements Shall be Approved by The Supervisor.

Legend:

REVISIONS		
NO.	DRAWINGS	DATE
(1)		
(2)		
(3)		

Contracting Authority:



Funded By:



Project Title:

"Public Works Contract for the rehabilitation of 5 schools in East Jerusalem"

Reference number: PSE22001-10074

Lot 1: the rehabilitation of Al-Hasan Al-Thany, Al-Shabbat Al-Shameleh, and Al-Fata Al-Laji'a schools in Wadi Al-Joz




Al-Shameleh Secondary Girls' school

Designed by:



Jerusalem - Sheikh Jarrah - Tobler8
email: mr.wasimhija@gmail.com
Tel. 02-9948344/ 052-8327076
Fax: 02-9948344

Drawing Title	Scope of Intervention	Date: 25/3/2025
		Scale: 1:100
Designed by:	Eng. Adli Naser Al-Deen	Drawing No: E42
Checked by:	Eng. Adli Naser Al-Deen	
Approved by:		
Coordinate Manager:		

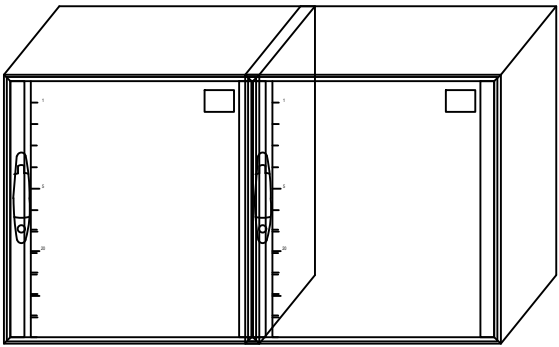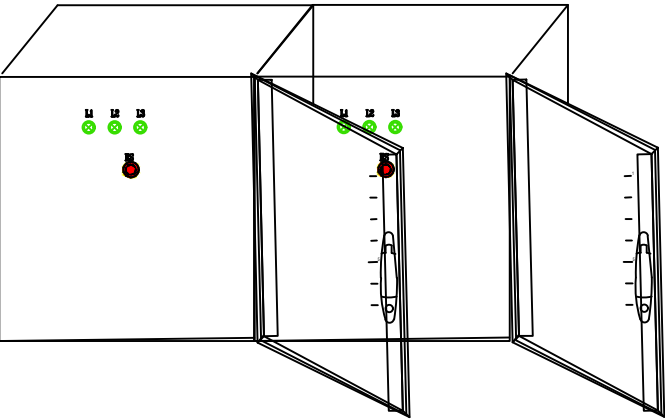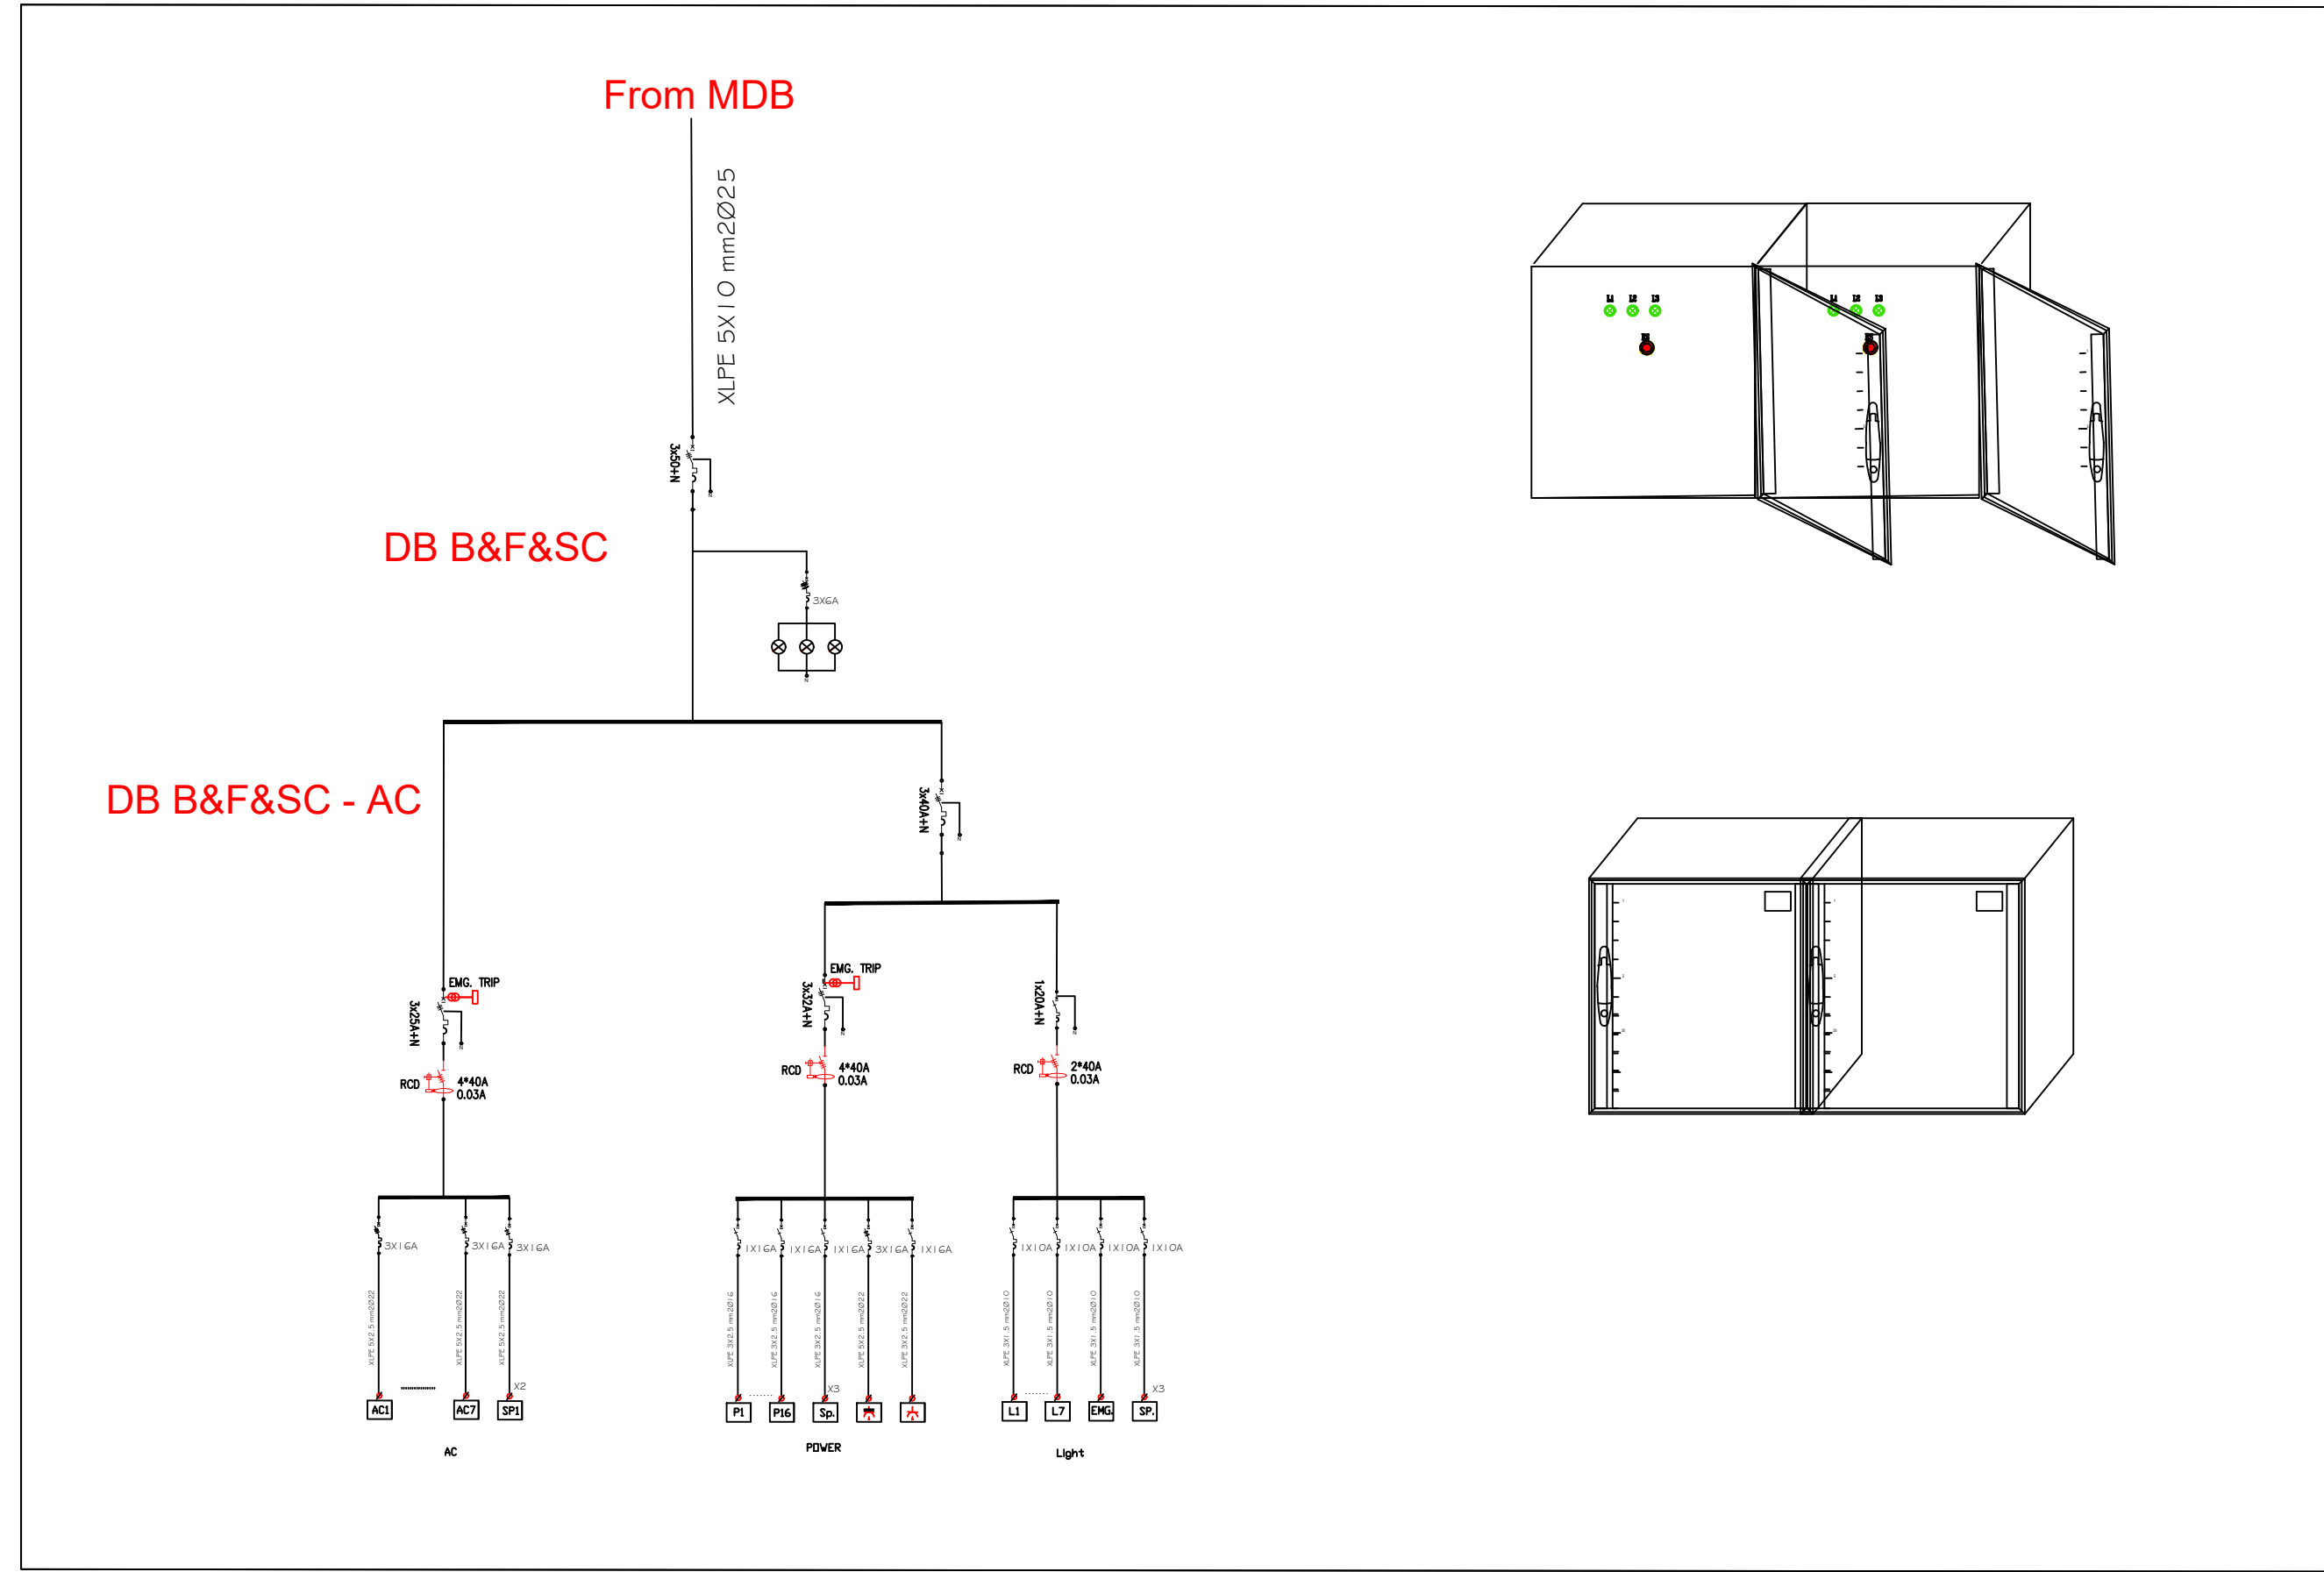

Notes

(1) All Dimensions Are In M.
(2) All Levels Are In Meter
(3) Any Missing or Unclear Detail And All Fastening Systems For All Elements Shall be Approved by The Supervisor.

Legend:

REVISIONS		
NO.	DRAWINGS	DATE
(1)		
(2)		
(3)		

Contracting Authority:

Enabel

Funded By:

Belgium
partner in development

Project Title:

“Public Works Contract for the rehabilitation of 5 schools in East Jerusalem”

Reference number: PSE22001-10074

Lot 1: the rehabilitation of Al-Hasan Al-Thany, Al-Shabbat Al-Shameleh, and Al-Fata Al-Laji’a schools in Wadi Al-Joz

Al-Shameleh Secondary Girls' school

Designed by:

HOSH STUDIO
ARCHITECTURE & TOWN PLANNING

Jerusalem - Sheikh Jarrah- Tobler8
email: mr.wasimhija@gmail.com
Tel. 02-9948344/ 052-8327076
Fax: 02-9948344

Drawing Title	Scope of Intervention	Date: 25/3/2025
	Sub Distribution Board	Scale: 1:100
Designed by:	Eng. Adli Naser Al-Deen	Drawing No:
Checked by:	Eng. Adli Naser Al-Deen	E43
Approved by:		
Coordinate Manager:		

Lot1: Hasan Al Thani school

ARCHITECTURAL DRAWINGS				
#	SHETT	#	SHEET TITLE	SCALE
01	A00		LIST OF DRAWINGS & NOTES ABBREVIATION & SYMBOLS	—
02	A08		Scope of Intervention in the Site Plan	1:200
03	A09		Caravan Detail	1:100
Structural DRAWINGS				
01	S01		Caravan Structural Details	
MECHANICAL DRAWINGS				
#	SHETT	#	SHEET TITLE	SCALE
01	M02		Mechanical works	1:50

Notes

(1) All Dimensions Are In M.
(2) All Levels Are In Meter
(3) Any Missing or Unclear Detail And All Fastening Systems For All Elements Shall be Approved by The Supervisor.

Legend:

SECTION NUMBER

REFERENCE SHEET NUMBER

ROOM CODE

AREA

ROOM ID

FLOOR FINISH LEVEL (F.F.L.)

REINFORCEMENT CONCRETE LEVEL (R.C.L.)

LEVEL SIGN IN PLAN

DOOR NUMBER

REFERENCE DETAIL SHEET NUMBER

WINDOW NUMBER

REFERENCE DETAIL SHEET NUMBER

X

X

DETAILED SECTION AT SHEET No. A09

STEEL SHEETS

RC CONCRETE FOR COLUMNS

RC CONCRETE FOR WALLS

CONCRETE

STONE WALL

HOLLOW BLOCKS

CEMENT TILE

PORCELAIN TILE

LOCAL MARBLE

Gypsum partition

ENTRANCE

ARTIFICIAL GRASS

PORCELAIN TILES (PARQUET STYLE)

DEMOLISHING AND REMOVAL

NEW INTERVENTION

R.C.L.:REN. CONCRETE LEVEL

F.F.L.:FINISH FLOOR LEVEL

S.L. : SEA LEVEL

REVISIONS

NO.	DRAWINGS	DATE
(1)		
(2)		
(3)		

Contracting Authority:

Enabel

Funded By:

Belgium

partner in development

“Public Works Contract for the rehabilitation of 5 schools in East Jerusalem”

Reference number: PSE22001-10074

Lot 1: the rehabilitation of Al-Hasan Al-Thany, Al-Shabbat Al-Shameleh, and Al-Fata Al-Laji’a schools in Wadi Al-Joz

Hasan Al Thani school

Designed by:

HOSH STUDIO

ARCHITECTURE & TOWN PLANNING


Jerusalem - Sheikh Jarrah- Tobler8

email: mr.wasimhija@gmail.com

Tel. 02-9948344/ 052-8327076

Fax: 02-9948344

Drawing Title	Table of Drawings	Date: 25/3/2025 Scale: 1:100
Designed by:	Arch. Hiba Al Ayoubi	Drawing No:
Checked by:	Arch. Wasim Abu El-Hija	A00
Approved by:		
Coordinate Manager:		

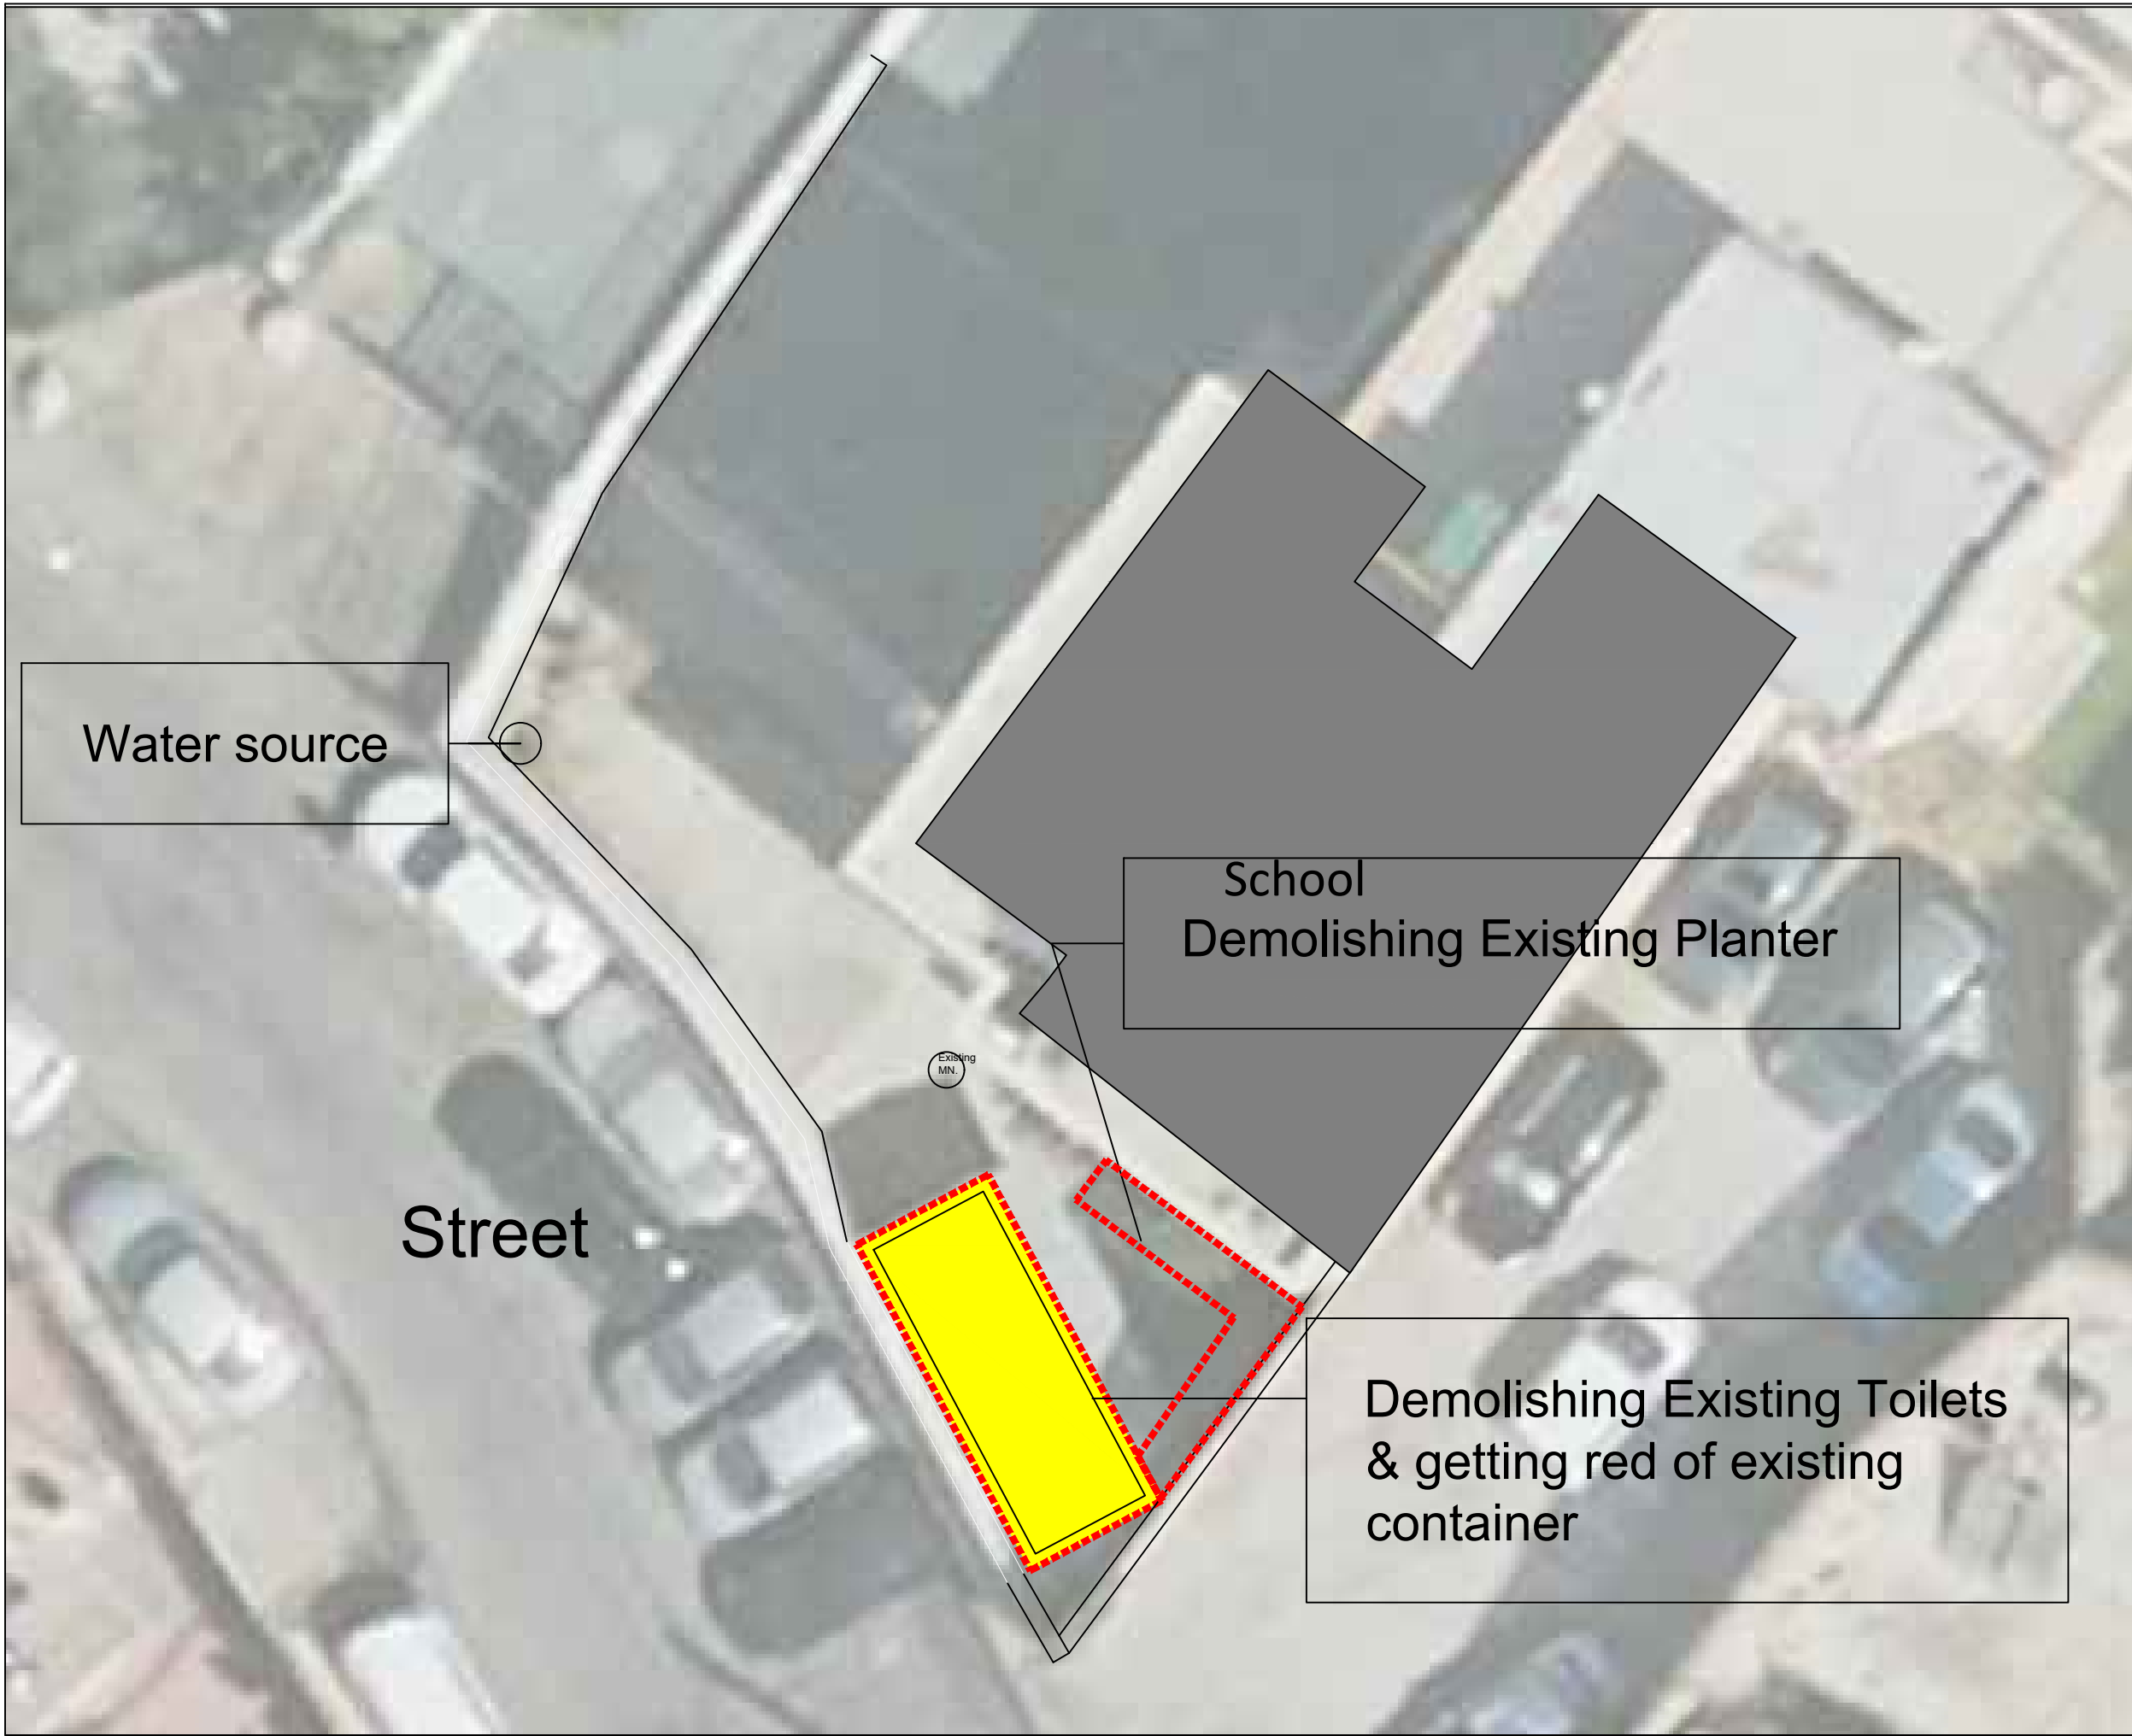

Notes

- (1) All Dimensions Are In M.
- (2) All Levels Are In Meter
- (3) Any Missing or Unclear Detail And All Fastening Systems For All Elements Shall be Approved by The Supervisor.

Legend:

SECTION NUMBER
REFERENCE SHEET NUMBER

REFERENCE DETAIL SHEET NUMBER

FLOOR FINISH LEVEL (F.F.L.)
REINFORCEMENT CONCRETE LEVEL (R.C.L.)

LEVEL SIGN IN PLAN

ROOM CODE
FUNCTION
AREA
ROOM ID

DOOR NUMBER
REFERENCE DETAIL SHEET NUMBER

WINDOW NUMBER
REFERENCE DETAIL SHEET NUMBER

DETAILED SECTION AT SHEET No. A09

STEEL SHEETS

RC CONCRETE FOR COLUMNS

RC CONCRETE FOR WALLS

CONCRETE

STONE WALL

HOLLOW BLOCKS

CEMENT TILE

PORCELAIN TILE

LOCAL MARBLE

Gypsum partition

ENTRANCE

ARTIFICIAL GRASS

PORCELAIN TILES (PARQUET STYLE)

DEMOLISHING AND REMOVAL

NEW INTERVENTION

R.C.L.: REN. CONCRETE LEVEL

F.F.L.: FINISH FLOOR LEVEL

S.L.: SEA LEVEL

REVISIONS

NO.	DRAWINGS	DATE
(1)		
(2)		
(3)		

Contracting Authority:

Enabel

Funded By:



“Public Works Contract for the rehabilitation of 5 schools in East Jerusalem”

Reference number: PSE22001-10074

Lot 1: the rehabilitation of Al-Hasan Al-Thany, Al-Shabbat Al-Shameleh, and Al-Fata Al-Laji’a schools in Wadi Al-Joz

Hasan Al Thani school

Designed by:



Jerusalem - Sheikh Jarrah- Tobler8
email: mr.wasimhija@gmail.com
Tel. 02-9948344/ 052-8327076
Fax: 02-9948344

Drawing Title

Scope of Intervention

Date: 25/3/2025

Scale: 1:100

Designed by:

Arch. Hiba Al Ayoubi

Drawing No:

Checked by:


Arch. Wasim Abu El-Hija

A08


Approved by:

Coordinate Manager:

Removal the
existing concrete
or asphalt flooring

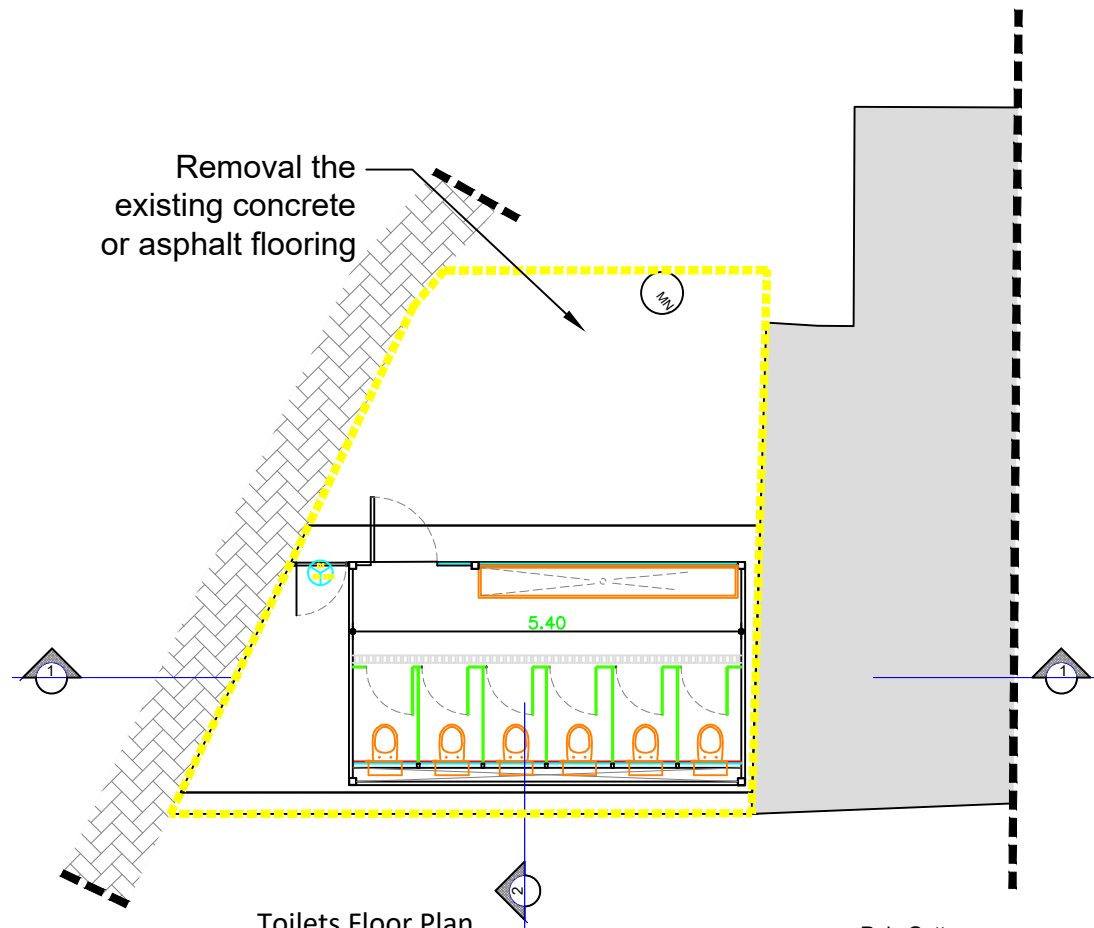

Toilets Floor Plan
Scale 1:100

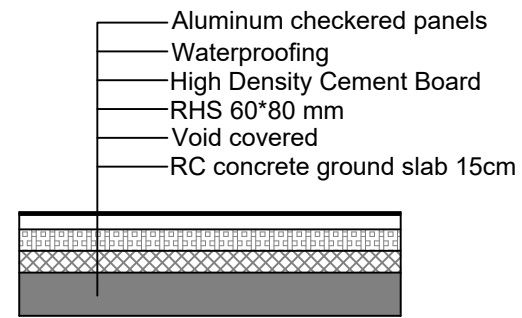

Toilets Floor main components




Cement Board



Aluminum Patterned Plate




Long Floor Drain

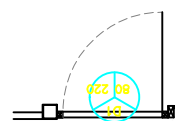


- 40 mm *40 mm*2mm Galvanized Steel Square Tubes
- Galvanized perforated panels—4 mm oil painted
- 40 mm *80 mm*2.6 mm Galvanized Steel Square Tubes
- External handle, lock, ironmongery, hardware, jack
- 4 cm space for safety by using hinge of 4.5 cm space
- 40 mm *40 mm*2mm Galvanized Steel Square Tubes
- Metal Plate 100*100*8mm


D1 Detail
Scale 1:50

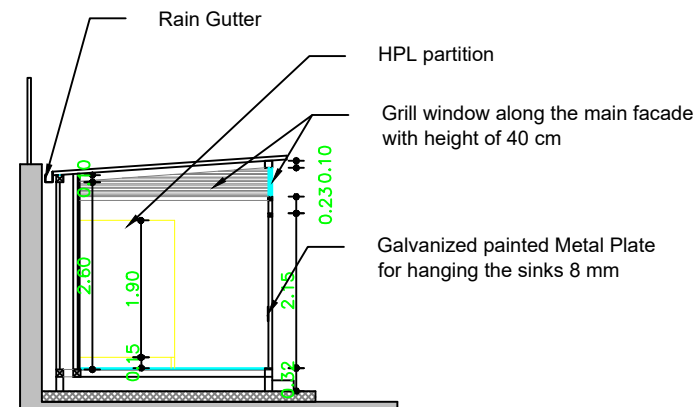


Section 2-2

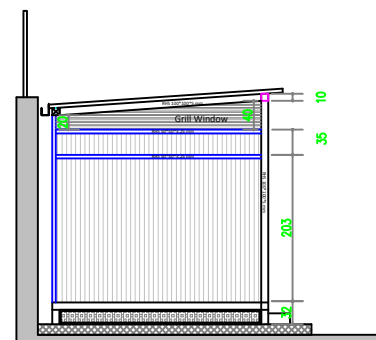

Side elevations

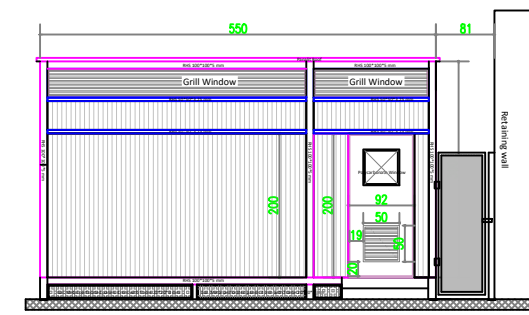

Main elevation

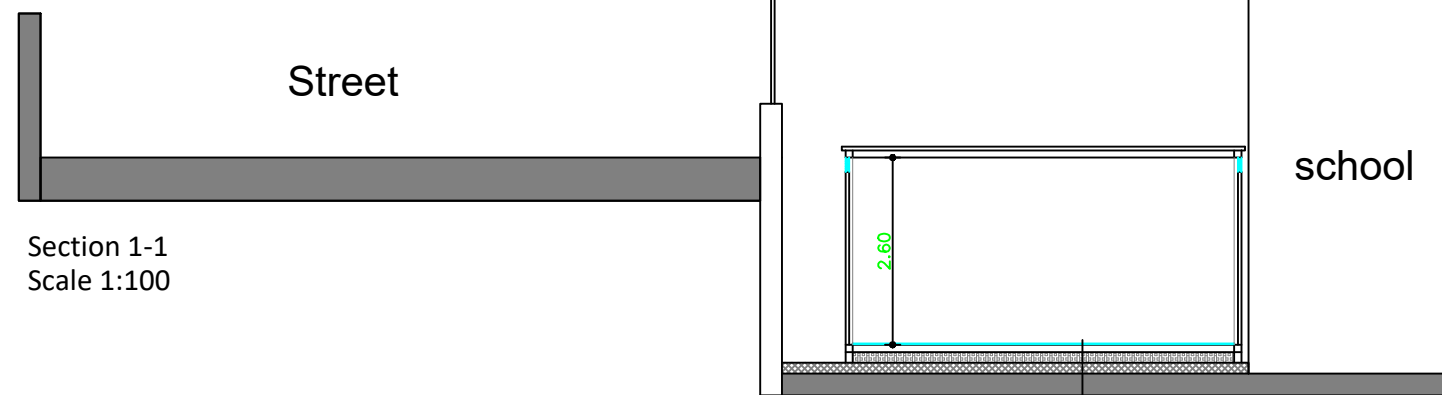


Section 1-1
Scale 1:100

- Aluminum checkered panels
- Waterproofing
- High Density Cement Board
- RHS 60*80 mm
- Void covered
- RC concrete ground slab 15cm

Notes

- (1) All Dimensions Are In M.
- (2) All Levels Are In Meter
- (3) Any Missing or Unclear Detail And All Fastening Systems For All Elements Shall be Approved by The Supervisor.

Legend:

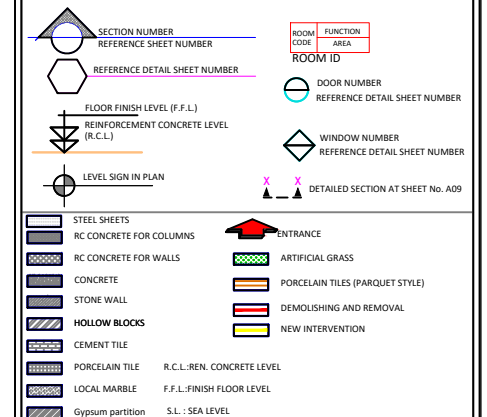

REVISIONS

NO.	DRAWINGS	DATE
(1)		
(2)		
(3)		

Contracting Authority:



Funded By:



“Public Works Contract for the rehabilitation
of 5 schools in East Jerusalem”

Reference number: PSE22001-10074

Lot 1: the rehabilitation of Al-Hasan
Al-Thany, Al-Shabbat Al-Shameleh, and
Al-Fata Al-Laji'a schools in Wadi Al-Joz


Hasan Al Thani school

Designed by:




Jerusalem - Sheikh Jarrah- Tobler8
email: mr.wasimhija@gmail.com
Tel. 02-9948344/ 052-8327076
Fax: 02-9948344


Drawing Title	Caravan Detail	Date: 25/3/2025 Scale: 1:100
Designed by:	Arch. Hiba Al Ayoubi	Drawing No:
Checked by:	Arch. Wasim Abu El-Hija	A09
Approved by:		
Coordinate Manager:		

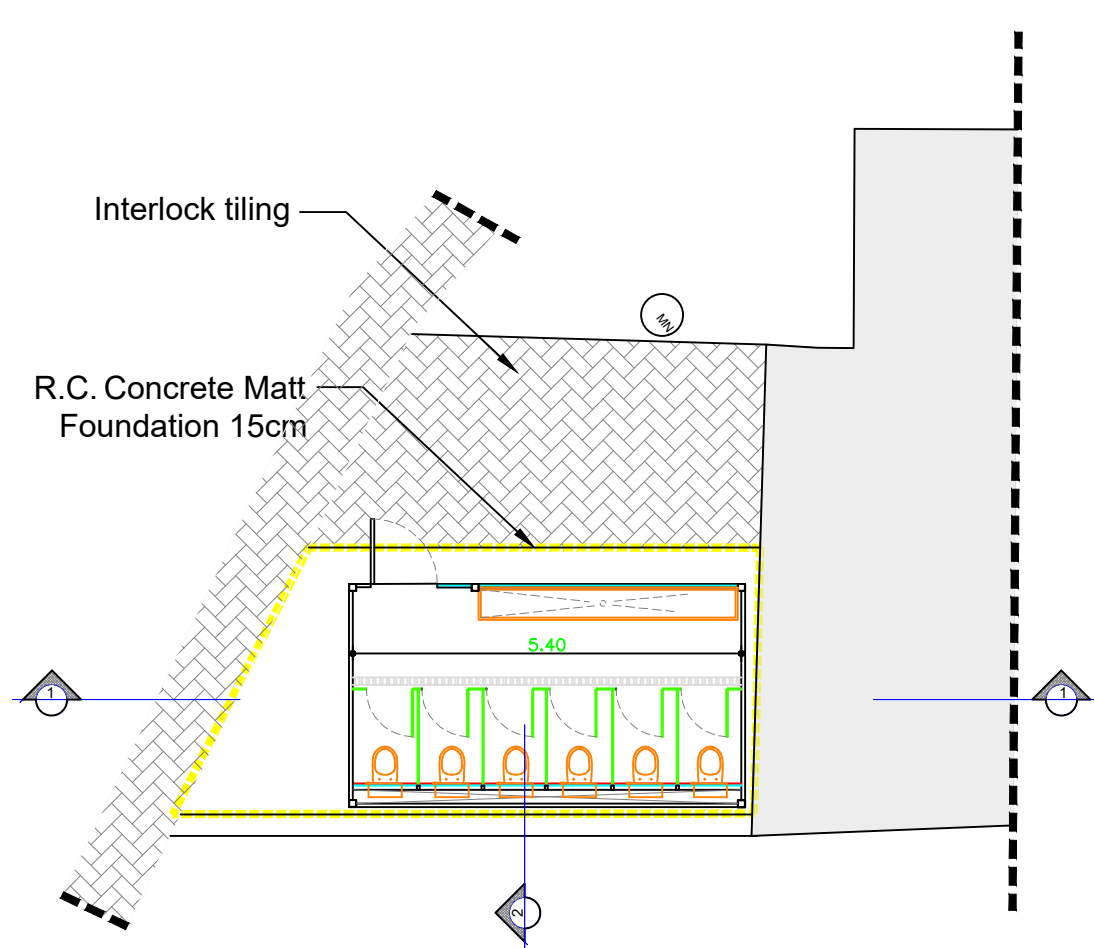


Toilets Floor Plan
Scale 1:100

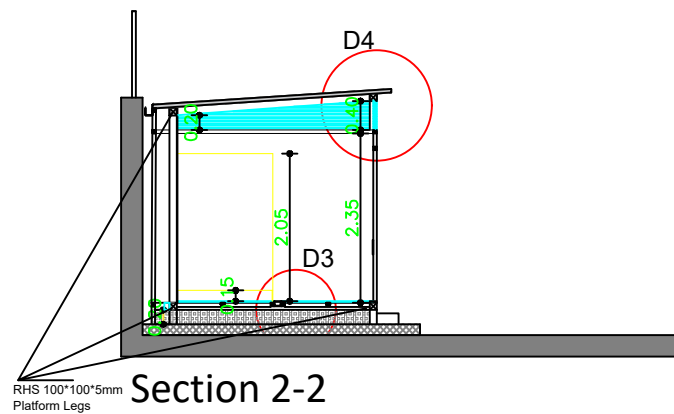


Section 2-2

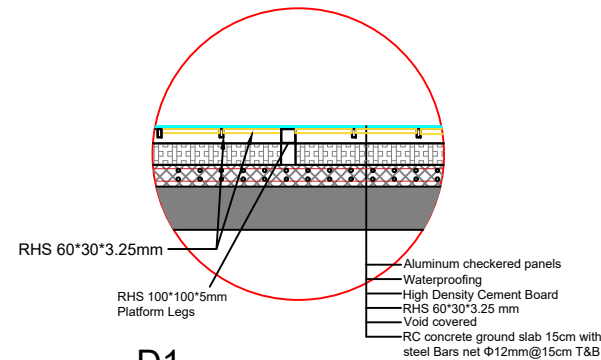


D1
Scale 1:50

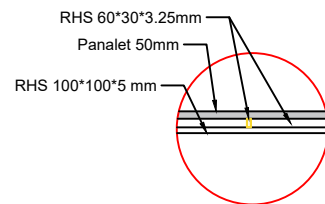


D2
Scale 1:50

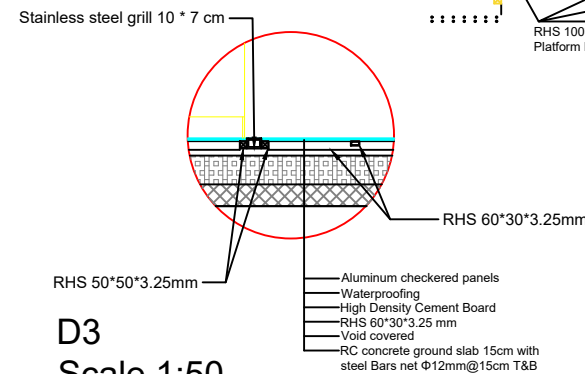


D3
Scale 1:50

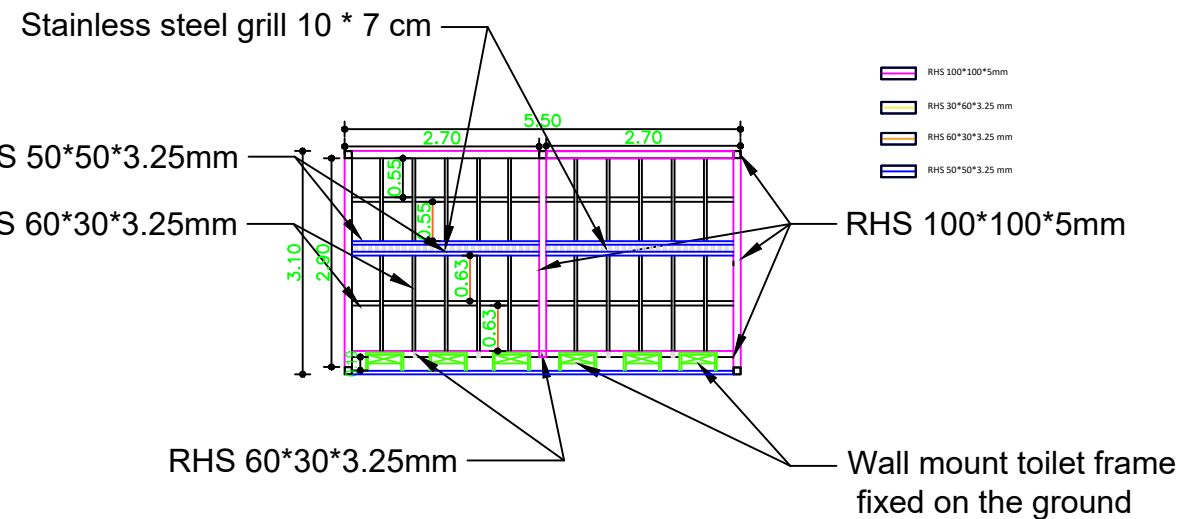

Steel Floor Platform Detail

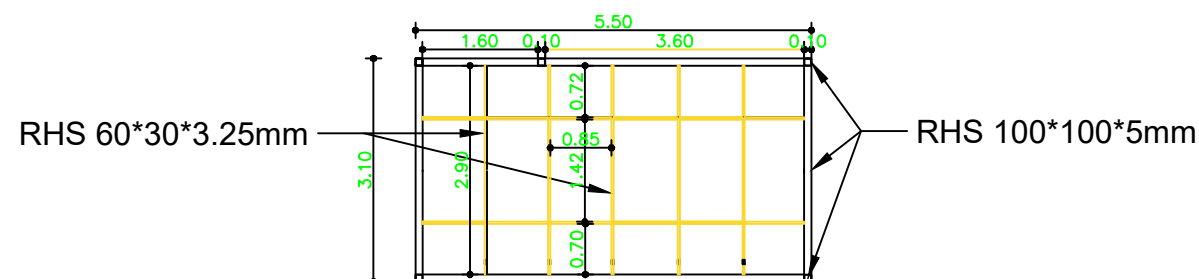

Roof Steel Detail

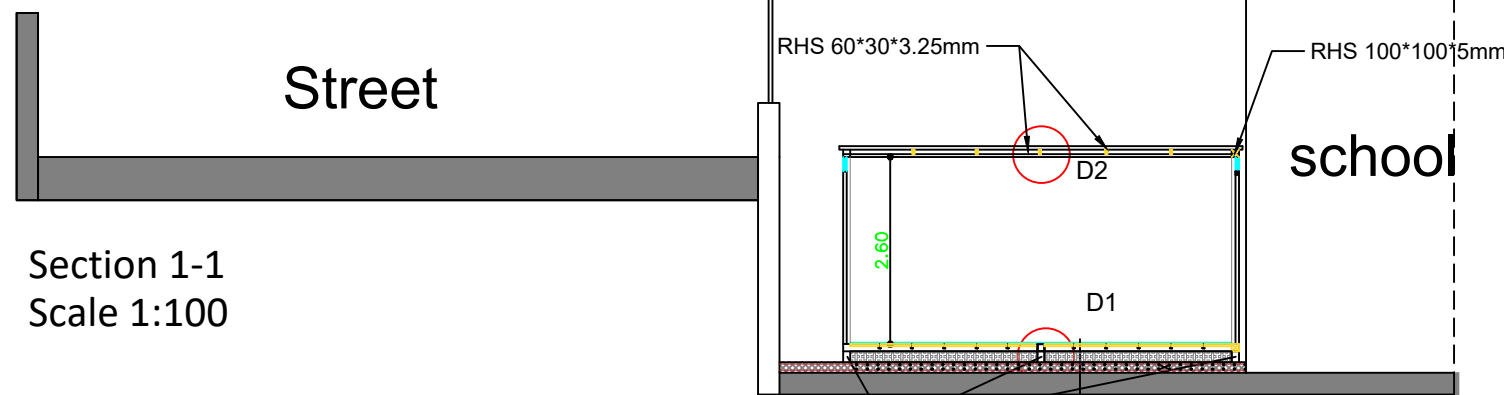

Section 1-1
Scale 1:100

Notes

- (1) All Dimensions Are In M.
- (2) All Levels Are In Meter
- (3) Any Missing or Unclear Detail And All Fastening Systems For All Elements Shall be Approved by The Supervisor.

Legend:

SECTION NUMBER	ROOM CODE	FUNCTION AREA	ROOM ID
REFERENCE SHEET NUMBER	DOOR NUMBER	REFERENCE DETAIL SHEET NUMBER	WINDOW NUMBER
REFERENCE DETAIL SHEET NUMBER	FLOOR FINISH LEVEL (F.F.L.)	REINFORCEMENT CONCRETE LEVEL (R.C.L.)	LEVEL SIGN IN PLAN
STEEL SHEETS	RC CONCRETE FOR COLUMNS	RC CONCRETE FOR WALLS	CONCRETE
STONE WALL	HOLLOW BLOCKS	CEMENT TILE	PORCELAIN TILE
LOCAL MARBLE	Gypsum partition	R.C.L.:REN. CONCRETE LEVEL	F.F.L.:FINISH FLOOR LEVEL
S.L.: SEA LEVEL	ENTRANCE	ARTIFICIAL GRASS	PORCELAIN TILES (PARQUET STYLE)
DEMOLISHING AND REMOVAL	NEW INTERVENTION		

REVISIONS

NO.	DRAWINGS	DATE
(1)		
(2)		
(3)		

Contracting Authority:

Enabel

Funded By:

Belgium
partner in development

"Public Works Contract for the rehabilitation of 5 schools in East Jerusalem"

Reference number: PSE22001-10074

Lot 1: the rehabilitation of Al-Hasan Al-Thany, Al-Shabbat Al-Shameleh, and Al-Fata Al-Laji'a schools in Wadi Al-Joz

Hasan Al Thani school



Designed by:

HOSH STUDIO
ARCHITECTURE & TOWN PLANNING

Jerusalem - Sheikh Jarrah- Tobler8
email: mr.wasimhija@gmail.com


Tel. 02-9948344/ 052-8327076
Fax: 02-9948344

Drawing Title	Scope of Intervention	Date: 25/3/2025
Designed by:	Eng. Saba Ameereh	Scale: 1:100
Checked by:	Arch. Wasim Abu El-Hija	Drawing No: S01
Approved by:		
Coordinate Manager:		

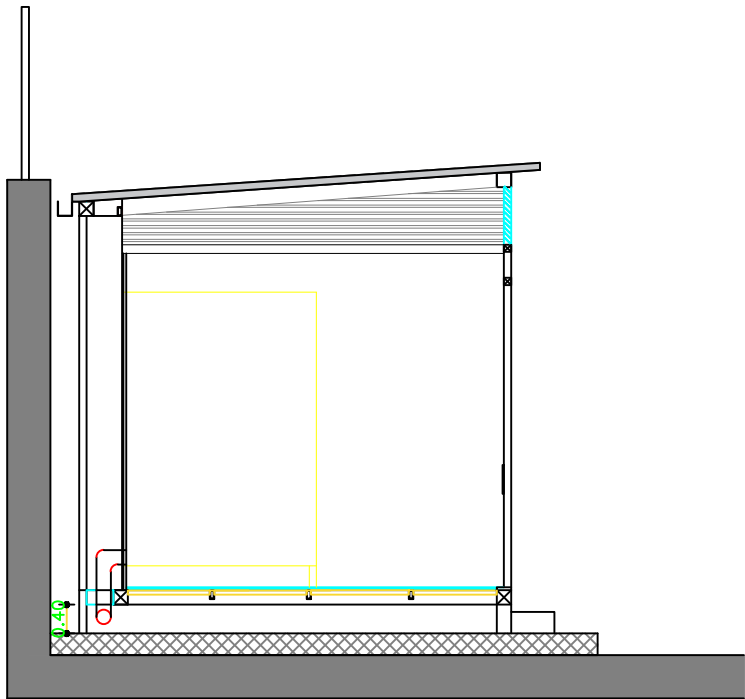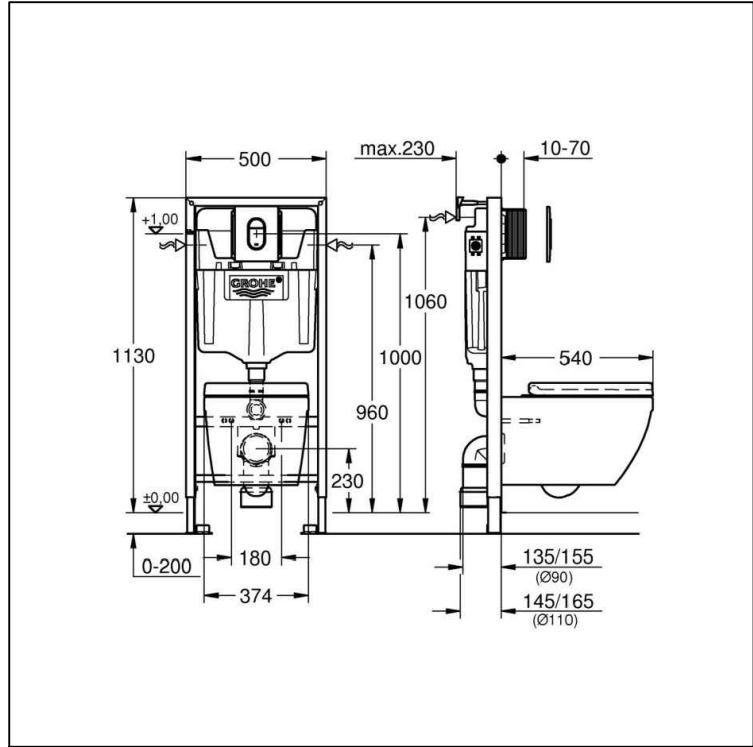

Section 2-2

Replacing the
existing manhole

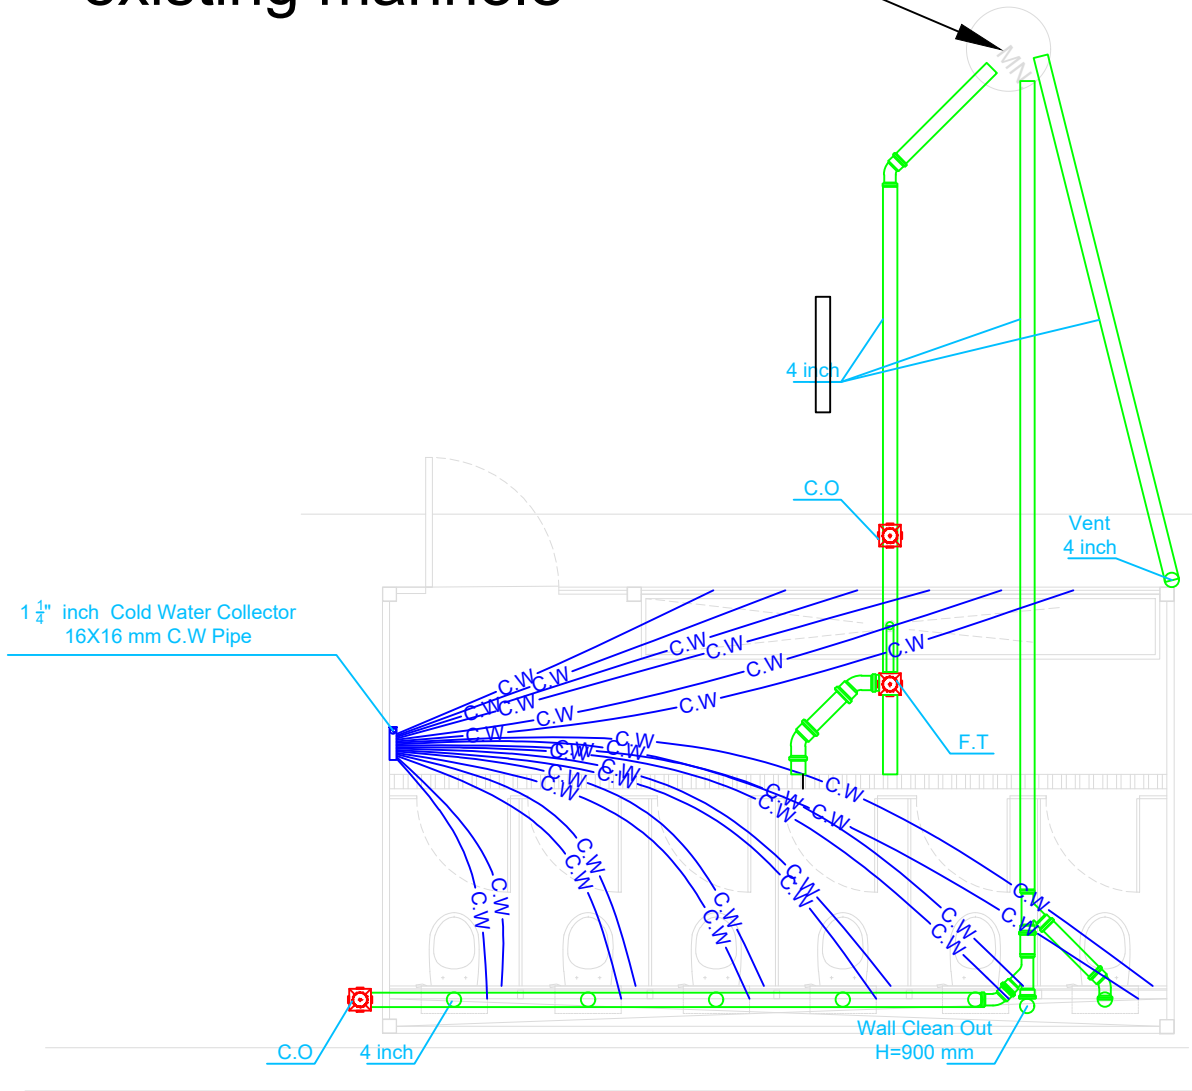

- Notes**
- (1) All Dimensions Are In M.
 - (2) All Levels Are In Meter
 - (3) Any Missing or Unclear Detail And All Fastening Systems For All Elements Shall be Approved by The Supervisor.

Legend:

- SECTION NUMBER
- REFERENCE SHEET NUMBER
- REFERENCE DETAIL SHEET NUMBER
- FLOOR FINISH LEVEL (F.F.L.)
- REINFORCEMENT CONCRETE LEVEL (R.C.L.)
- LEVEL SIGN IN PLAN
- STEEL SHEETS
- RC CONCRETE FOR COLUMNS
- RC CONCRETE FOR WALLS
- CONCRETE
- STONE WALL
- HOLLOW BLOCKS
- CEMENT TILE
- PORCELAIN TILE
- LOCAL MARBLE
- Gypsum partition
- ENTRANCE
- ARTIFICIAL GRASS
- PORCELAIN TILES (PARQUET STYLE)
- DEMOLISHING AND REMOVAL
- NEW INTERVENTION
- ROOM CODE
- FUNCTION AREA
- ROOM ID
- DOOR NUMBER
- REFERENCE DETAIL SHEET NUMBER
- WINDOW NUMBER
- REFERENCE DETAIL SHEET NUMBER
- R.C.L.:REN. CONCRETE LEVEL
- F.F.L.:FINISH FLOOR LEVEL
- S.L.: SEA LEVEL

REVISIONS		
NO.	DRAWINGS	DATE
(1)		
(2)		
(3)		

Contracting Authority:

Enabel

Funded By:

Belgium
partner in development

"Public Works Contract for the rehabilitation of 5 schools in East Jerusalem"

Reference number: PSE22001-10074

Lot 1: the rehabilitation of Al-Hasan Al-Thany, Al-Shabbat Al-Shameleh, and Al-Fata Al-Lajji'a schools in Wadi Al-Joz

Hasan Al Thani school


Designed by:

HOSH STUDIO
ARCHITECTURE & TOWN PLANNING


Jerusalem - Sheikh Jarrah- Tobler8
email: mr.wasimhija@gmail.com

Tel. 02-9948344/ 052-8327076
Fax: 02-9948344

Drawing Title	Mechanical works	Date: 25/3/2025 Scale: 1:50
Designed by:	Arch. Hiba Al Ayoubi	Drawing No:
Checked by:	Arch. Wasim Abu El-Hija	M02
Approved by:		
Coordinate Manager:		

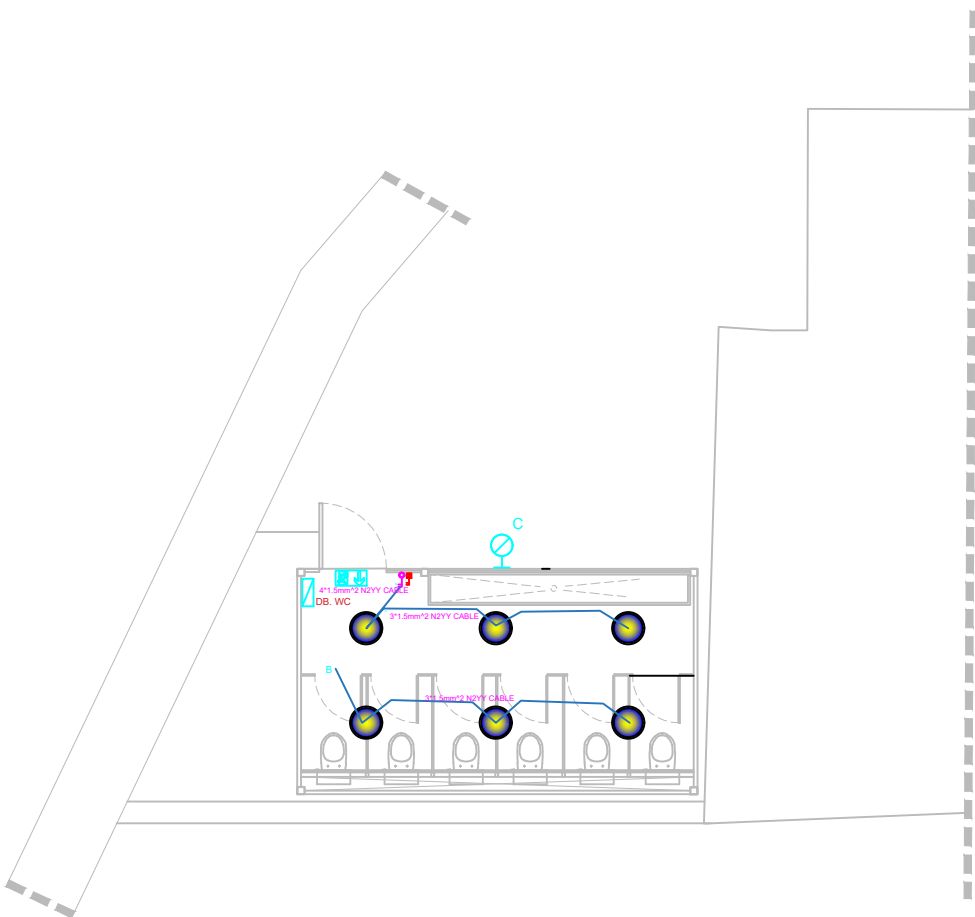

Lighting System

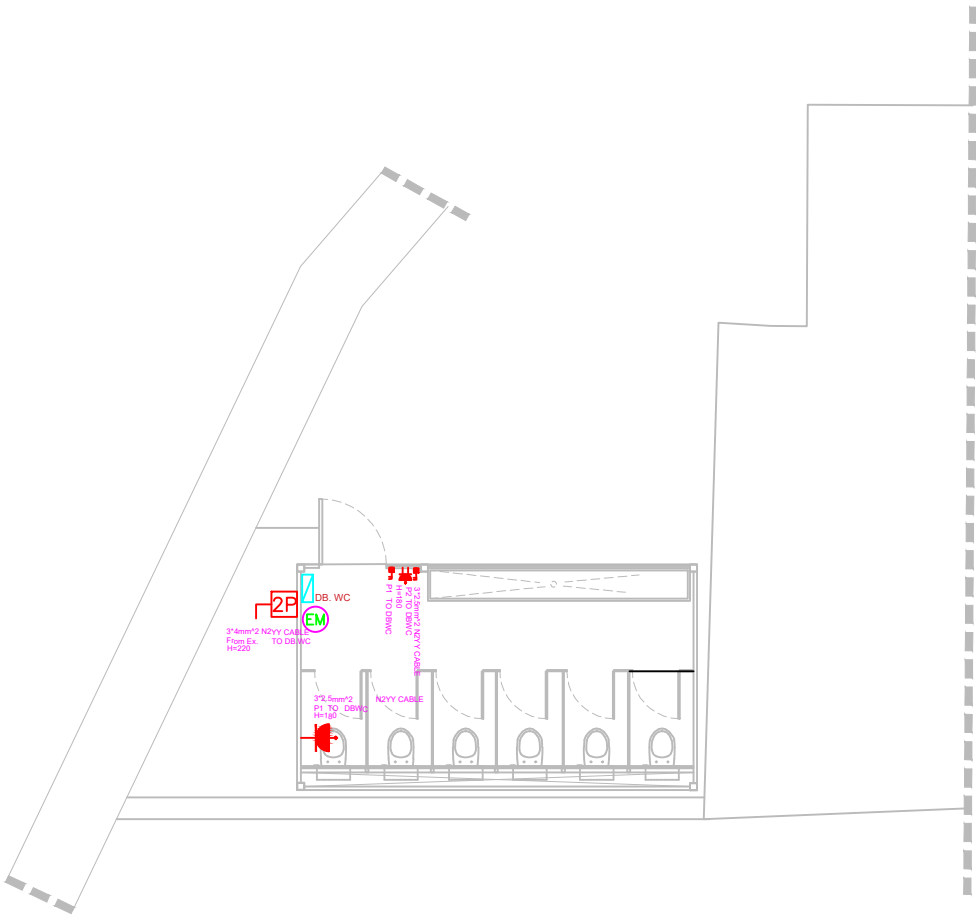

Power System

Notes

(1) All Dimensions Are In M.
(2) All Levels Are In Meter
(3) Any Missing or Unclear Detail And All Fastening Systems For All Elements Shall be Approved by The Supervisor.

Legend:

REVISIONS		
NO.	DRAWINGS	DATE
(1)		
(2)		
(3)		

Contracting Authority:

Funded By:

“Public Works Contract for the rehabilitation of 5 schools in East Jerusalem”

Reference number: PSE22001-10074

Lot 1: the rehabilitation of Al-Hasan Al-Thany, Al-Shabbat Al-Shameleh, and Al-Fata Al-Laji’a schools in Wadi Al-Joz


Hasan Al Thani school

Designed by:

HOSH STUDIO
ARCHITECTURE & TOWN PLANNING

Jerusalem - Sheikh Jarrah- Tobler8 Tel. 02-9948344/ 052-8327076
email: mr.wasimhija@gmail.com Fax: 02-9948344

Drawing Title	Electrical Plans	Date: 25/3/2025 Scale: 1:100
Designed by:	Eng. Adli Naser Al-Deen	Drawing No:
Checked by:	Eng. Adli Naser Al-Deen	E01
Approved by:		
Coordinate Manager:		

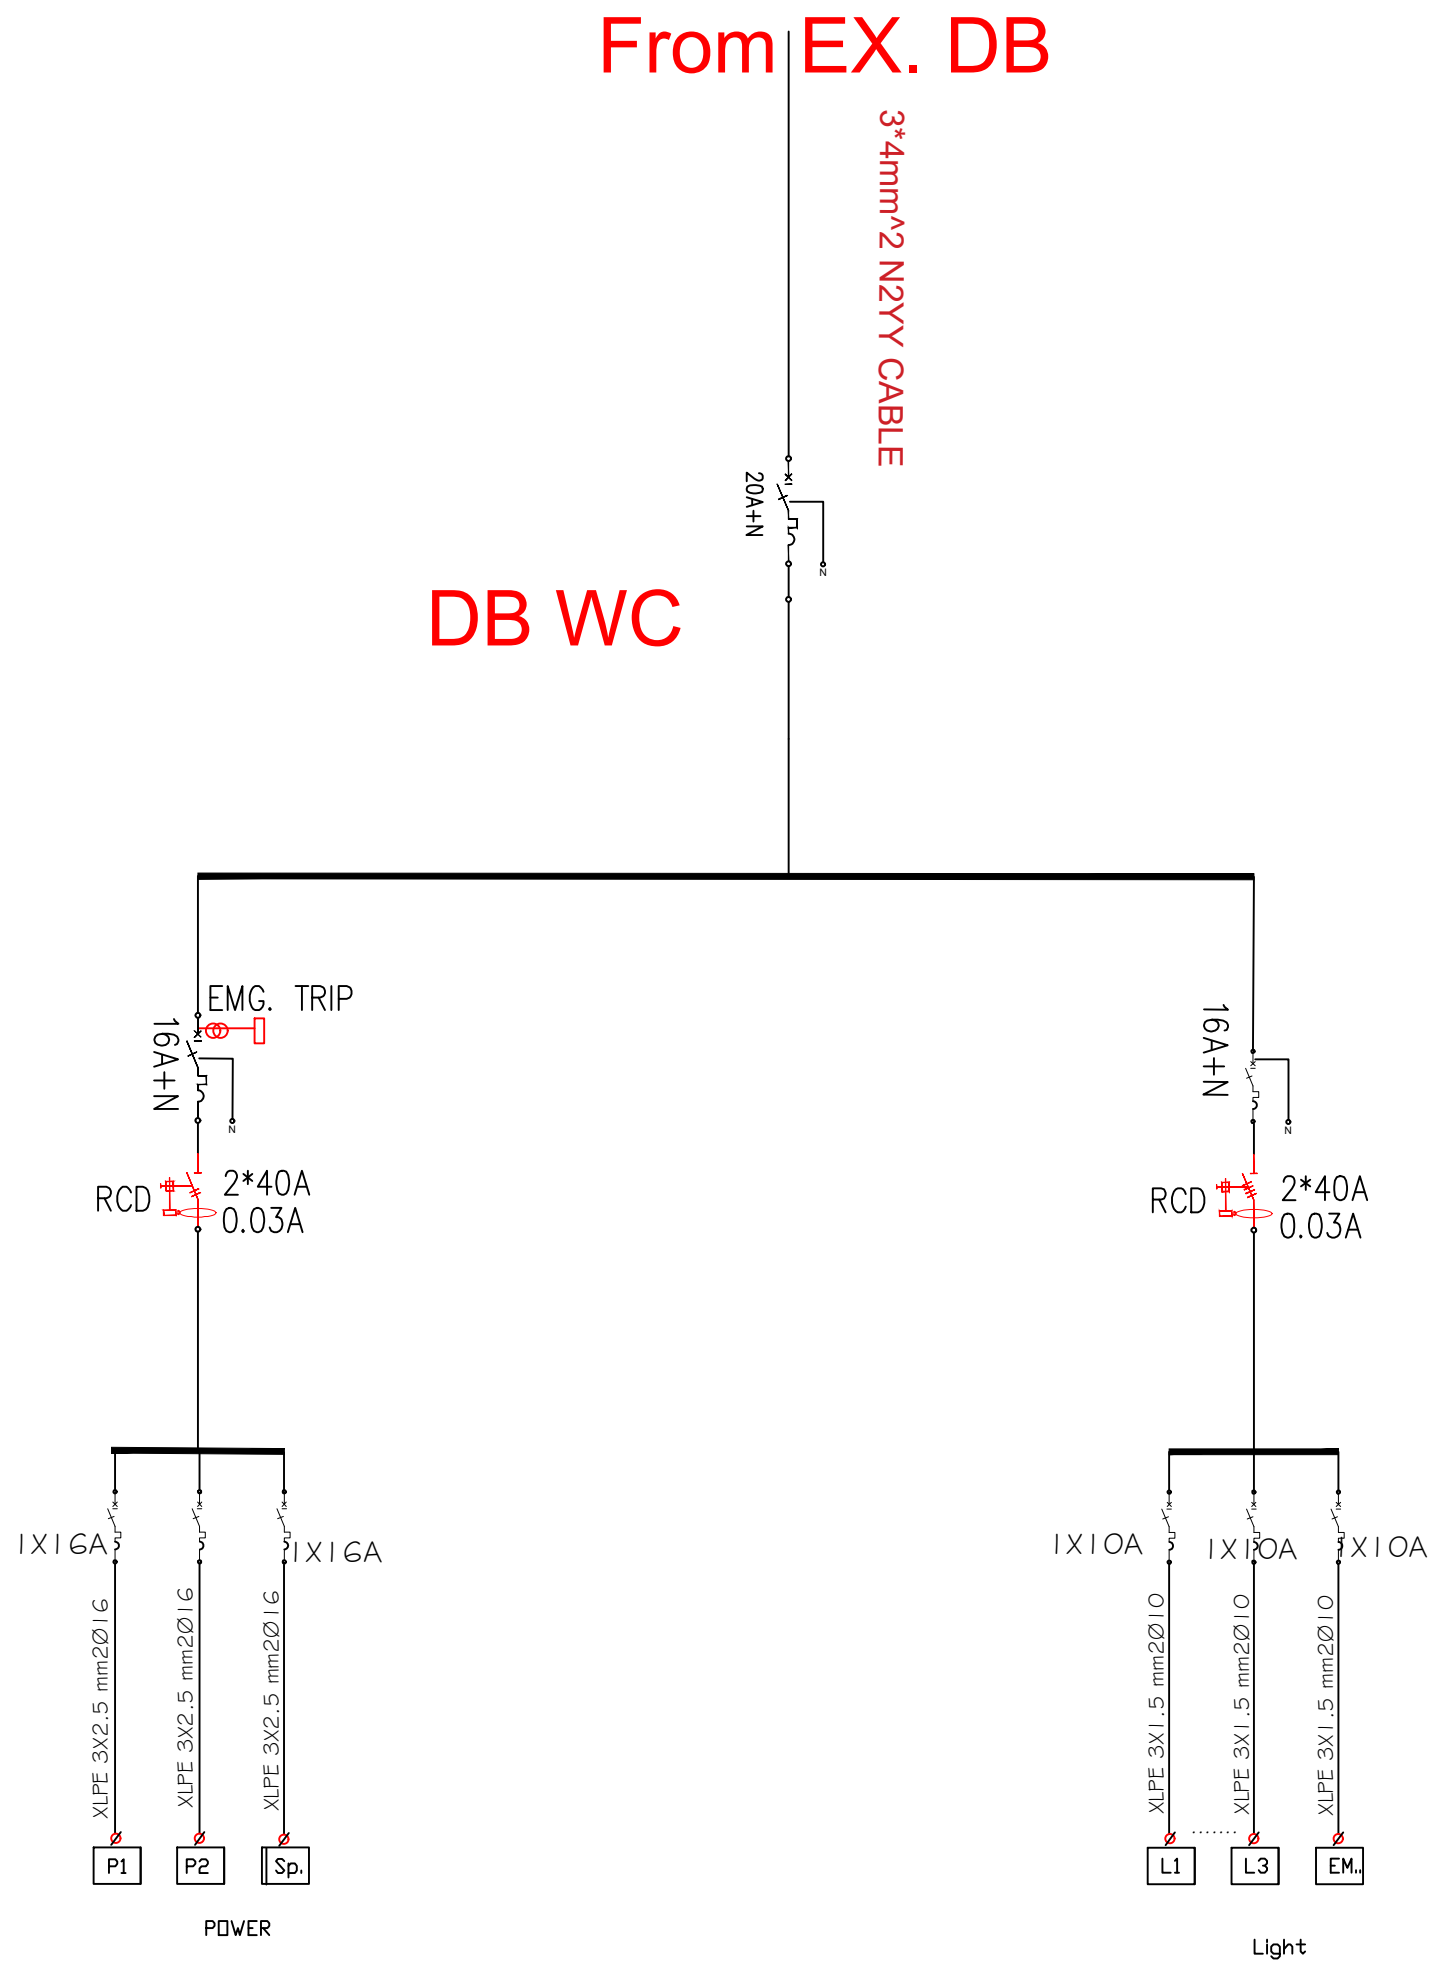

Notes

- (1) All Dimensions Are In M.
- (2) All Levels Are In Meter
- (3) Any Missing or Unclear Detail And All Fastening Systems For All Elements Shall be Approved by The Supervisor.

Legend:

REVISIONS		
NO.	DRAWINGS	DATE
(1)		
(2)		
(3)		

Contracting Authority:



Funded By:



“Public Works Contract for the rehabilitation of 5 schools in East Jerusalem”

Reference number: PSE22001-10074

Lot 1: the rehabilitation of Al-Hasan Al-Thany, Al-Shabbat Al-Shameleh, and Al-Fata Al-Laji'a schools in Wadi Al-Joz

Hasan Al Thani school

Designed by:



Jerusalem - Sheikh Jarrah- Tobler8
email: mr.wasimhija@gmail.com

Tel. 02-9948344/ 052-8327076
Fax: 02-9948344

Drawing Title	Electrical Distribution Board	Date: 25/3/2025 Scale: 1:100
Designed by:	Eng. Adli Naser Al-Deen	Drawing No:
Checked by:	Eng. Adli Naser Al-Deen	E02
Approved by:		
Coordinate Manager:		

Enabel - Belgian Development Agency



Public Works Contract for the rehabilitation of 5 schools in East Jerusalem”


Reference number: PSE22001-10074

Lot 1: the rehabilitation of Al-Hasan Al-Thany, Al-Shabbat Al-Shameleh, and Al-Fata Al-Laji’a schools in Wadi Al-Joz

Funded By

June 2025

Designed by

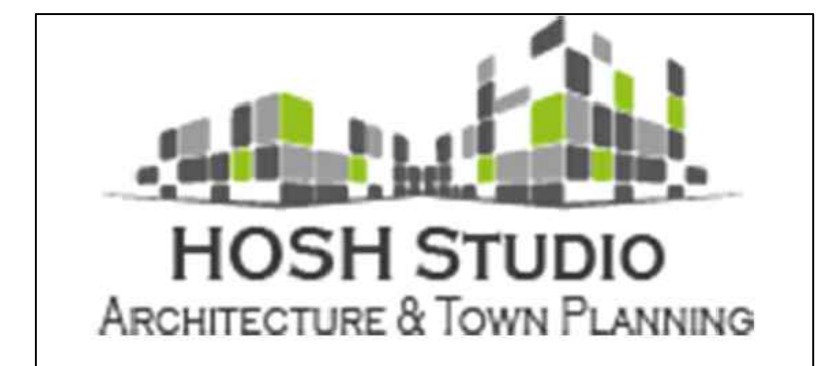

Jerusalem - Sheikh Jarrah- Tobler8

Lot1 : Al-Fata Al-Laji'a A Secondary Girls' School

ARCHITECTURAL DRAWINGS			
#	SHETT #	SHEET TITLE	SCALE
01	A00	LIST OF DRAWINGS & NOTES ABBREVIATION & SYMBOLS	—
02	A10	Scope of Intervention on site level	1:200
03	A11	Scope of Intervention in Building 1&2	1:100
04	A12	Scope of Intervention in Building 3	1:100
05	A13	Pergola Design	1:100
Structural DRAWINGS			
01	S02	Pergola Structural Details	1:100

Notes

(1) All Dimensions Are In M.
(2) All Levels Are In Meter
(3) Any Missing or Unclear Detail And All Fastening Systems For All Elements Shall be Approved by The Supervisor.

Legend:

SECTION NUMBER
REFERENCE SHEET NUMBER

REFERENCE DETAIL SHEET NUMBER

FLOOR FINISH LEVEL (F.F.L.)
REINFORCEMENT CONCRETE LEVEL (R.C.L.)

LEVEL SIGN IN PLAN

ROOM CODE
FUNCTION
AREA
ROOM ID

DOOR NUMBER
REFERENCE DETAIL SHEET NUMBER

WINDOW NUMBER
REFERENCE DETAIL SHEET NUMBER

DETAILED SECTION AT SHEET No. A09

STEEL SHEETS
RC CONCRETE FOR COLUMNS
RC CONCRETE FOR WALLS
CONCRETE
STONE WALL
HOLLOW BLOCKS
CEMENT TILE
PORCELAIN TILE
LOCAL MARBLE
Gypsum partition

ENTRANCE

WPC

R.C.L.:REN. CONCRETE LEVEL
F.F.L.:FINISH FLOOR LEVEL
S.L. : SEA LEVEL

REVISIONS

NO.	DRAWINGS	DATE
(1)		
(2)		
(3)		

Contracting Authority:

Enabel

Funded By:

Belgium
partner in development

Project Title:

“Public Works Contract for the rehabilitation of 5 schools in East Jerusalem”

Reference number: PSE22001-10074

Lot 1: the rehabilitation of Al-Hasan Al-Thany, Al-Shabbat Al-Shameleh, and Al-Fata Al-Laji’a schools in Wadi Al-Joz

Al-Fata Al-Laji'a A Secondary Girls' School


Designed by:

HOSH STUDIO
ARCHITECTURE & TOWN PLANNING

Jerusalem - Sheikh Jarrah- Tobler8
email: mr.wasimhija@gmail.com

Tel. 02-9948344/ 052-8327076
Fax: 02-9948344

Drawing Title	Scope of Intervention on site level	Date: 25/3/2025 Scale:
Designed by:	Arch. Hiba Al Ayoubi	Drawing No:
Checked by:	Arch. Wasim Abu El-Hija	A00
Approved by:		
Coordinate Manager:		

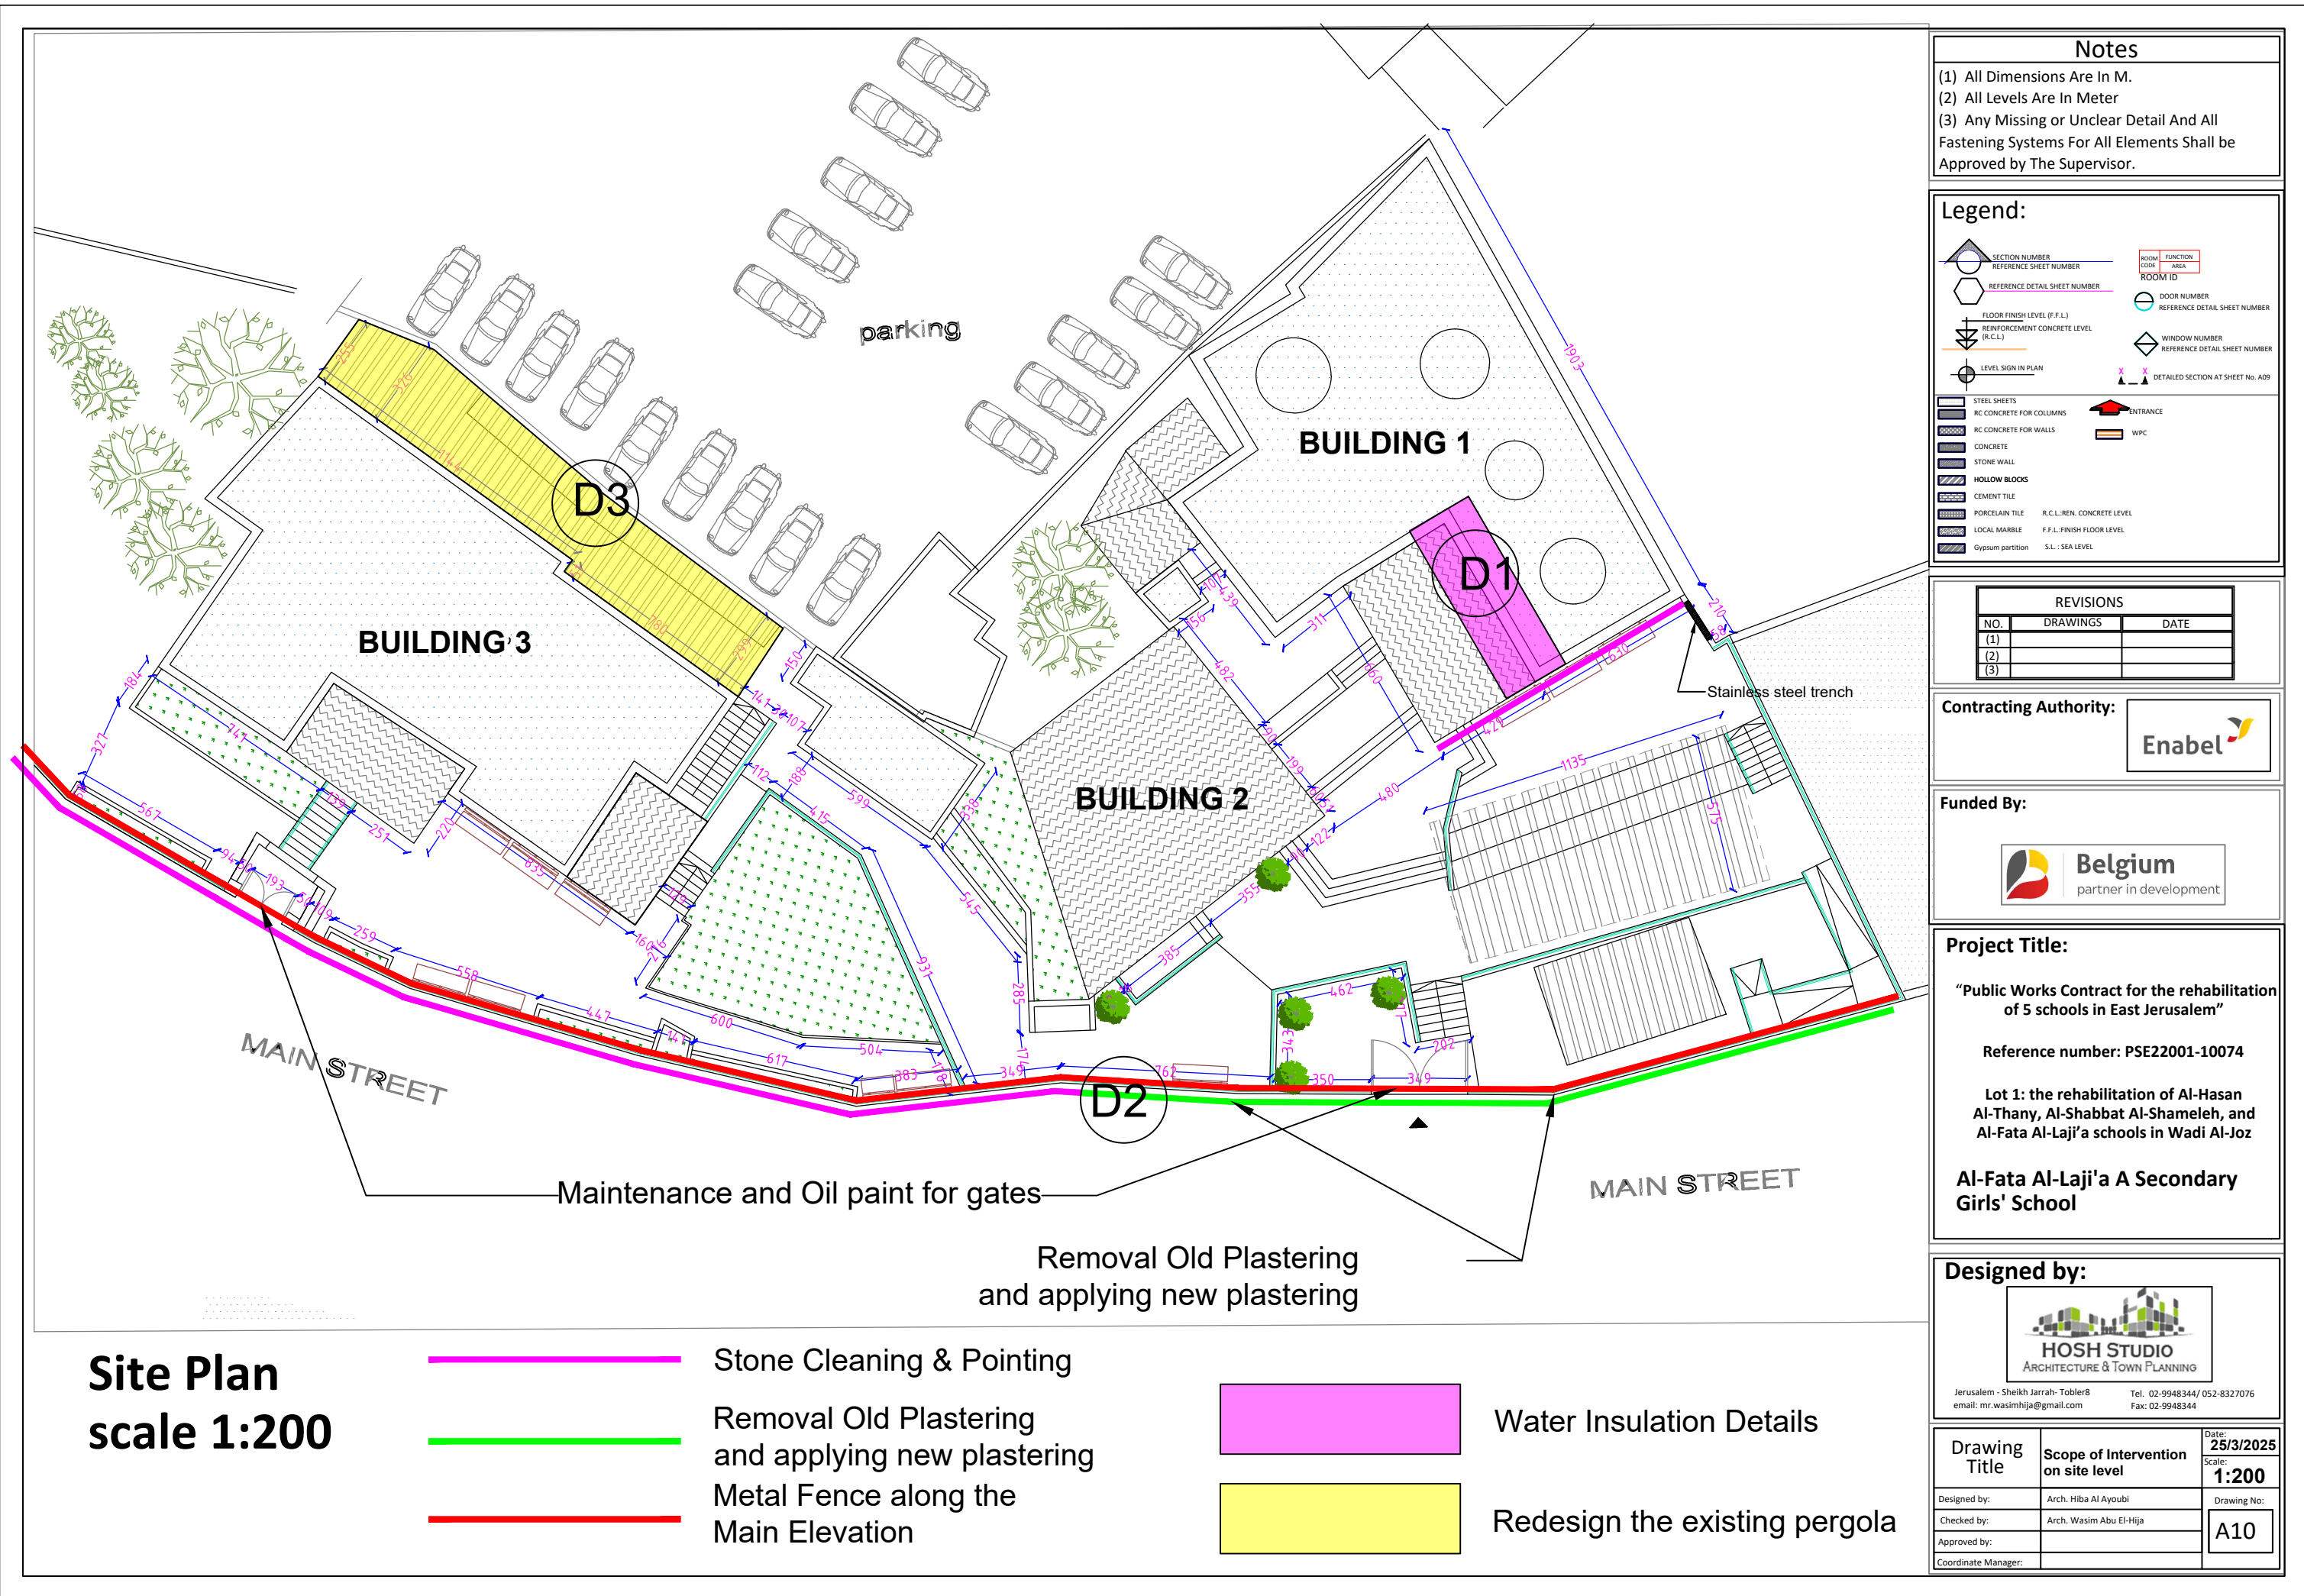

Rehabilitation works in Building 1:

- Electrical works
- Water insulation of the roof
- Plastering works for administration room and adjacent classroom
- Painting Works


Rehabilitation works in Building 2:

- Replacing Doors and fixing walls next to the doors
- Painting Works
- Removal of Existing doors and replacing with new wooden doors in building 2

Painting of Metal Doors



Fixing wall and painting of wooden doors

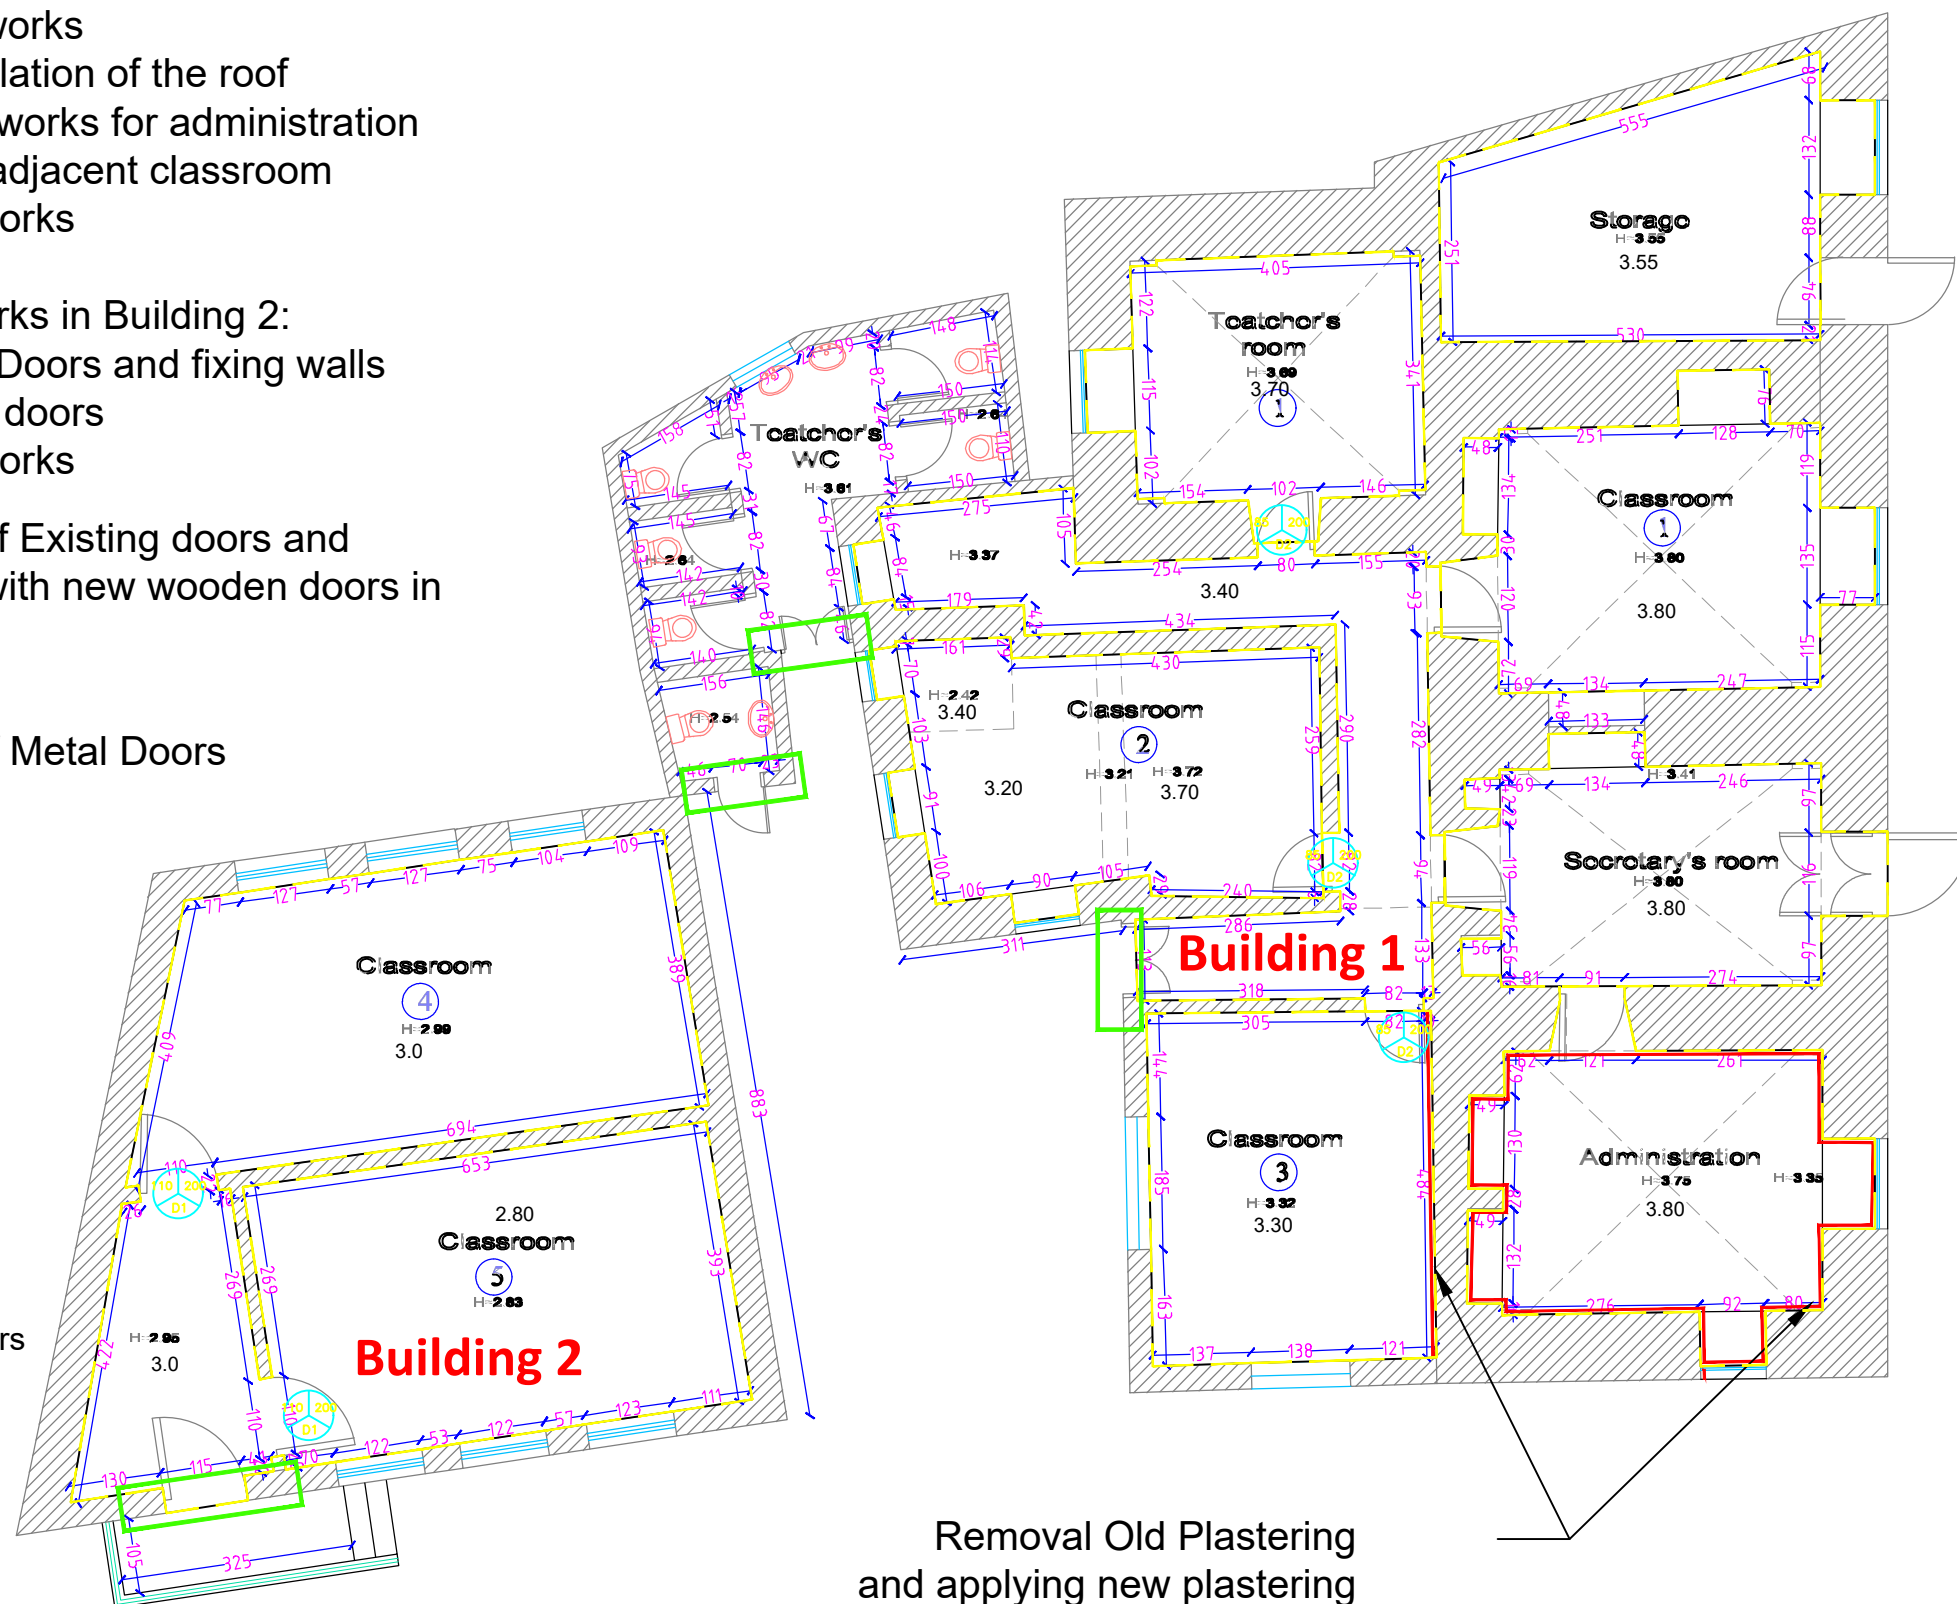

Removal Old Plastering and applying new plastering

Notes

- (1) All Dimensions Are In M.
- (2) All Levels Are In Meter
- (3) Any Missing or Unclear Detail And All Fastening Systems For All Elements Shall be Approved by The Supervisor.

Legend:

SECTION NUMBER
REFERENCE SHEET NUMBER

REFERENCE DETAIL SHEET NUMBER

FLOOR FINISH LEVEL (F.F.L.)
REINFORCEMENT CONCRETE LEVEL (R.C.L.)
LEVEL SIGN IN PLAN

ROOM CODE
FUNCTION
AREA
ROOM ID

DOOR NUMBER
REFERENCE DETAIL SHEET NUMBER

WINDOW NUMBER
REFERENCE DETAIL SHEET NUMBER

DETAILED SECTION AT SHEET No. A09

STEEL SHEETS
RC CONCRETE FOR COLUMNS
RC CONCRETE FOR WALLS
CONCRETE
STONE WALL
HOLLOW BLOCKS
CEMENT TILE
PORCELAIN TILE
LOCAL MARBLE
Gypsum partition

ENTRANCE
ARTIFICIAL GRASS
PORCELAIN TILES (PARQUET STYLE)
DEMOLISHING AND REMOVAL
NEW INTERVENTION

R.C.L.: REN. CONCRETE LEVEL
F.F.L.: FINISH FLOOR LEVEL
S.L.: SEA LEVEL

REVISIONS

NO.	DRAWINGS	DATE
(1)		
(2)		
(3)		

Contracting Authority:



Funded By:



Project Title:

"Public Works Contract for the rehabilitation of 5 schools in East Jerusalem"

Reference number: PSE22001-10074

Lot 1: the rehabilitation of Al-Hasan Al-Thany, Al-Shabbat Al-Shameleh, and Al-Fata Al-Laji'a schools in Wadi Al-Joz

Al-Fata Al-Laji'a A Secondary Girls' School

Designed by:




Jerusalem - Sheikh Jarrah- Tobler8
email: mr.wasimhija@gmail.com

Tel. 02-9948344/ 052-8327076
Fax: 02-9948344

Drawing Title	Scope of Intervention in Building 1&2	Date: 25/3/2025 Scale: 1:100
Designed by:	Arch. Hiba Al Ayoubi	Drawing No:
Checked by:	Arch. Wasim Abu El-Hija	A11
Approved by:		
Coordinate Manager:		

Ground Floor Plan- scale 1:100

Removal Old Plastering
and applying new colored plastering

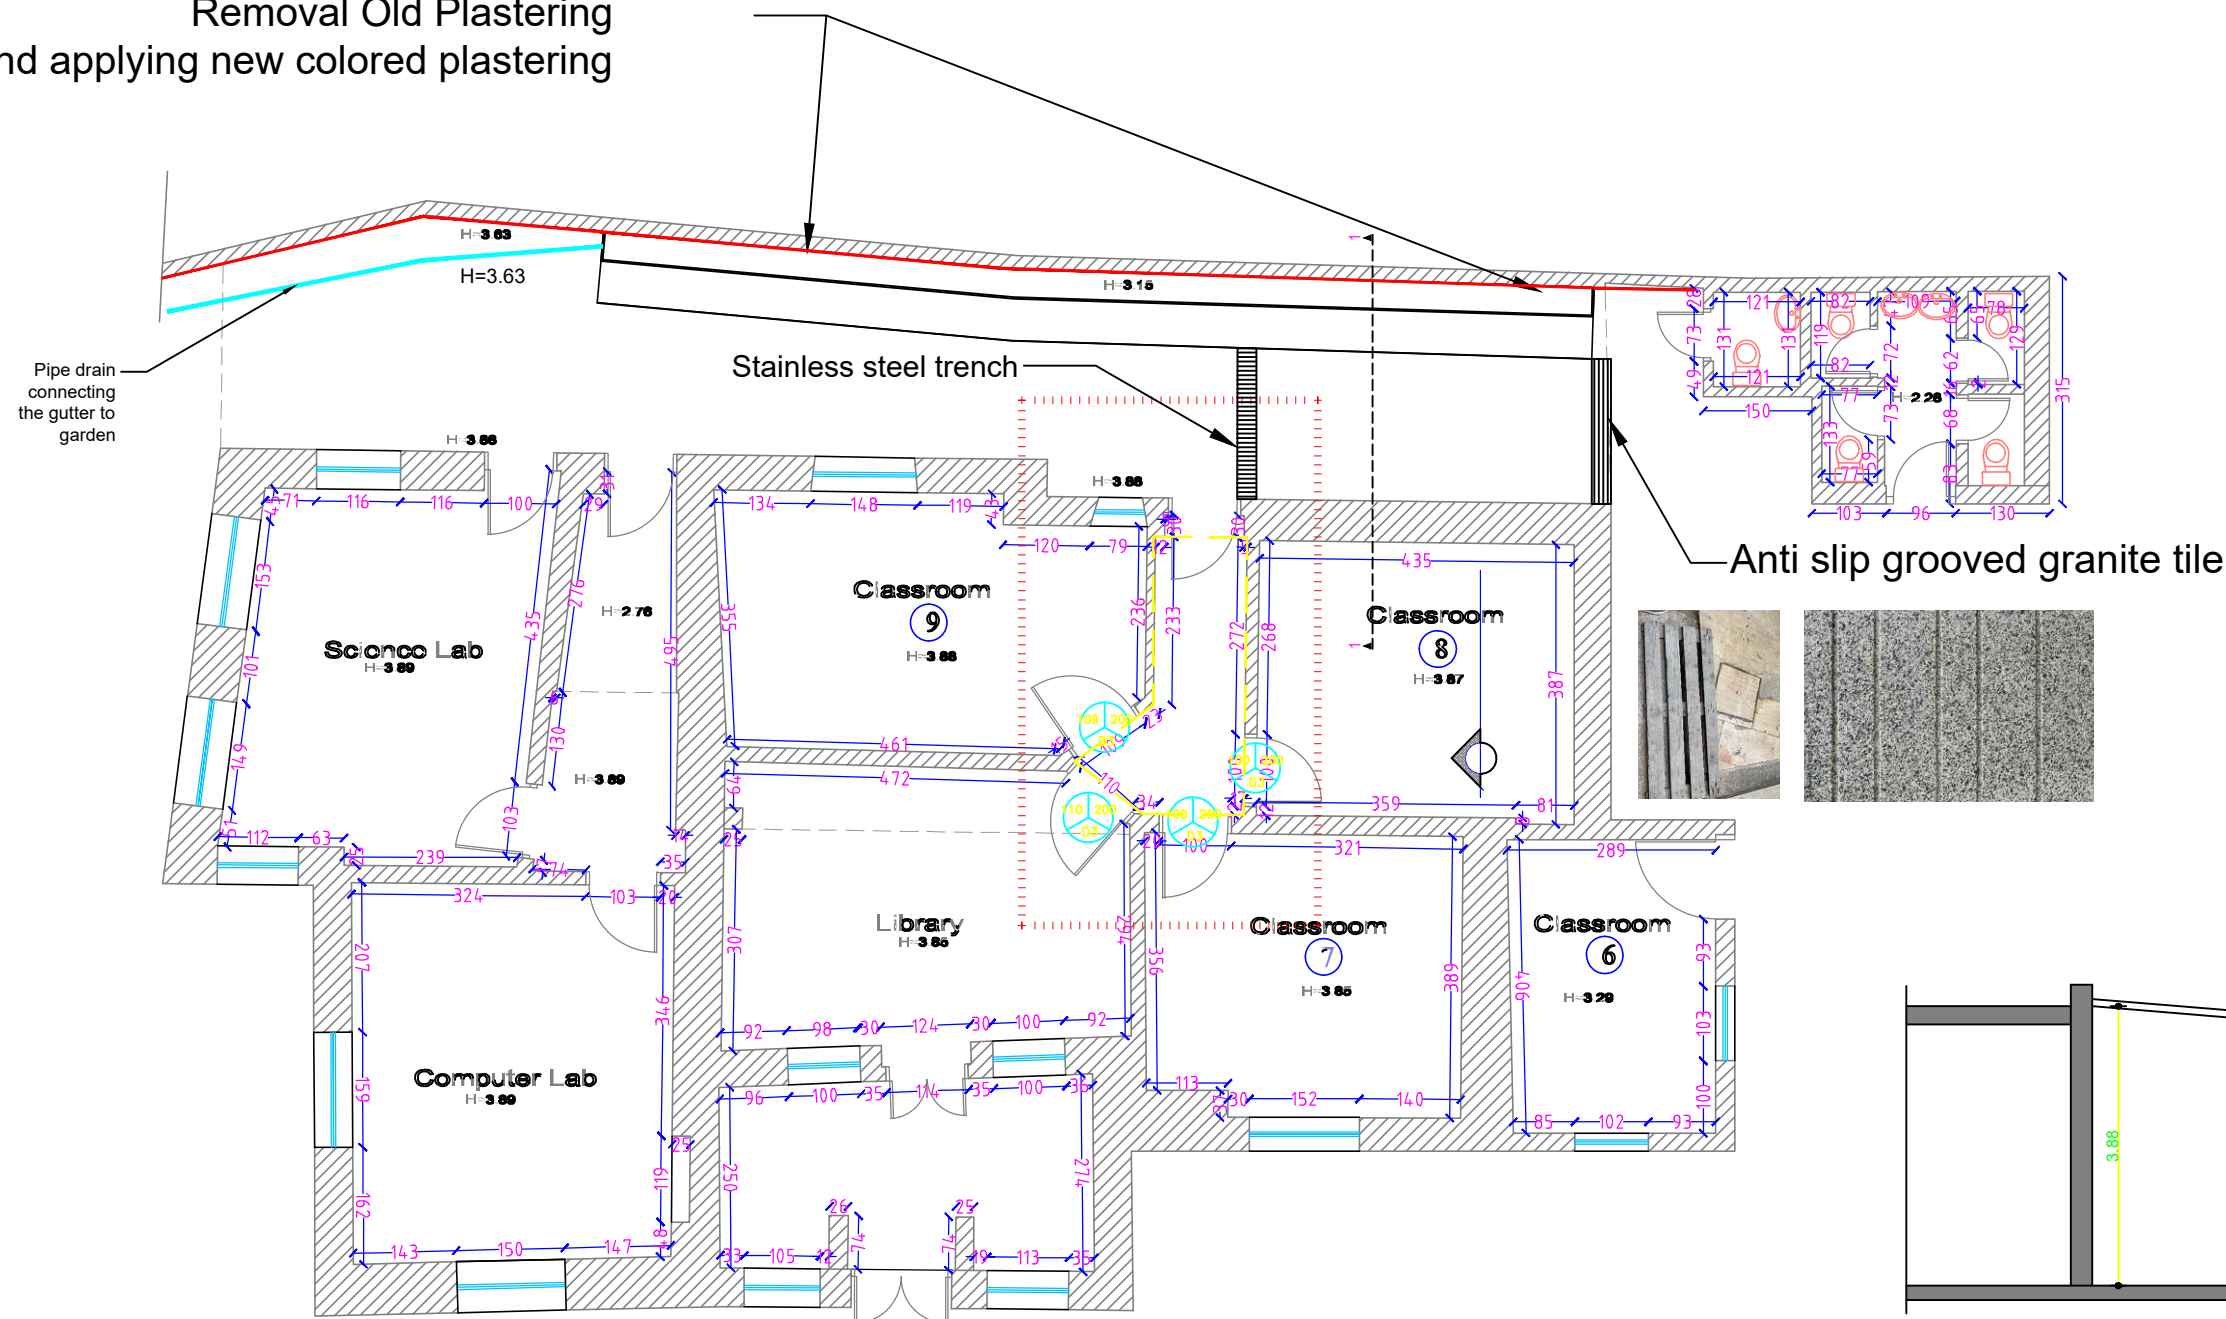

Ground Floor Plan- scale 1:100
Building 3

- Rehabilitation works in Building 3:
-  - Replacing Doors and fixing walls next to the doors in building 3
 -  - Painting Works
 -  - Removal Old Plastering and applying new colored plastering

Notes

- (1) All Dimensions Are In M.
- (2) All Levels Are In Meter
- (3) Any Missing or Unclear Detail And All Fastening Systems For All Elements Shall be Approved by The Supervisor.

Legend:

 SECTION NUMBER
REFERENCE SHEET NUMBER

 REFERENCE DETAIL SHEET NUMBER

 FLOOR FINISH LEVEL (F.F.L.)
REINFORCEMENT CONCRETE LEVEL (R.C.L.)

 LEVEL SIGN IN PLAN

 ROOM CODE
FUNCTION
AREA
ROOM ID

 DOOR NUMBER
REFERENCE DETAIL SHEET NUMBER

 WINDOW NUMBER
REFERENCE DETAIL SHEET NUMBER

 ENTRANCE

 STEEL SHEETS

 RC CONCRETE FOR COLUMNS

 RC CONCRETE FOR WALLS

 CONCRETE

 STONE WALL

 HOLLOW BLOCKS

 CEMENT TILE

 PORCELAIN TILE

 LOCAL MARBLE

 Gypsum partition

 ARTIFICIAL GRASS

 PORCELAIN TILES (PARQUET STYLE)

 DEMOLISHING AND REMOVAL

 NEW INTERVENTION

 R.C.L.:REN. CONCRETE LEVEL

 F.F.L.:FINISH FLOOR LEVEL

 S.L.: SEA LEVEL

REVISIONS		
NO.	DRAWINGS	DATE
(1)		
(2)		
(3)		

Contracting Authority:

Enabel

Funded By:

Belgium
partner in development

Project Title:

“Public Works Contract for the rehabilitation of 5 schools in East Jerusalem”

Reference number: PSE22001-10074

Lot 1: the rehabilitation of Al-Hasan Al-Thany, Al-Shabbat Al-Shameleh, and Al-Fata Al-Laji'a schools in Wadi Al-Joz

Al-Fata Al-Laji'a A Secondary Girls' School


Designed by:

HOSH STUDIO
ARCHITECTURE & TOWN PLANNING


Jerusalem - Sheikh Jarrah- Tobler8
email: mr.wasimhija@gmail.com

Tel. 02-9948344/ 052-8327076
Fax: 02-9948344


Drawing Title	Scope of Intervention in Building 3	Date: 25/3/2025 Scale: 1:100
Designed by:	Arch. Hiba Al Ayoubi	Drawing No:
Checked by:	Arch. Wasim Abu El-Hija	A12
Approved by:		
Coordinate Manager:		

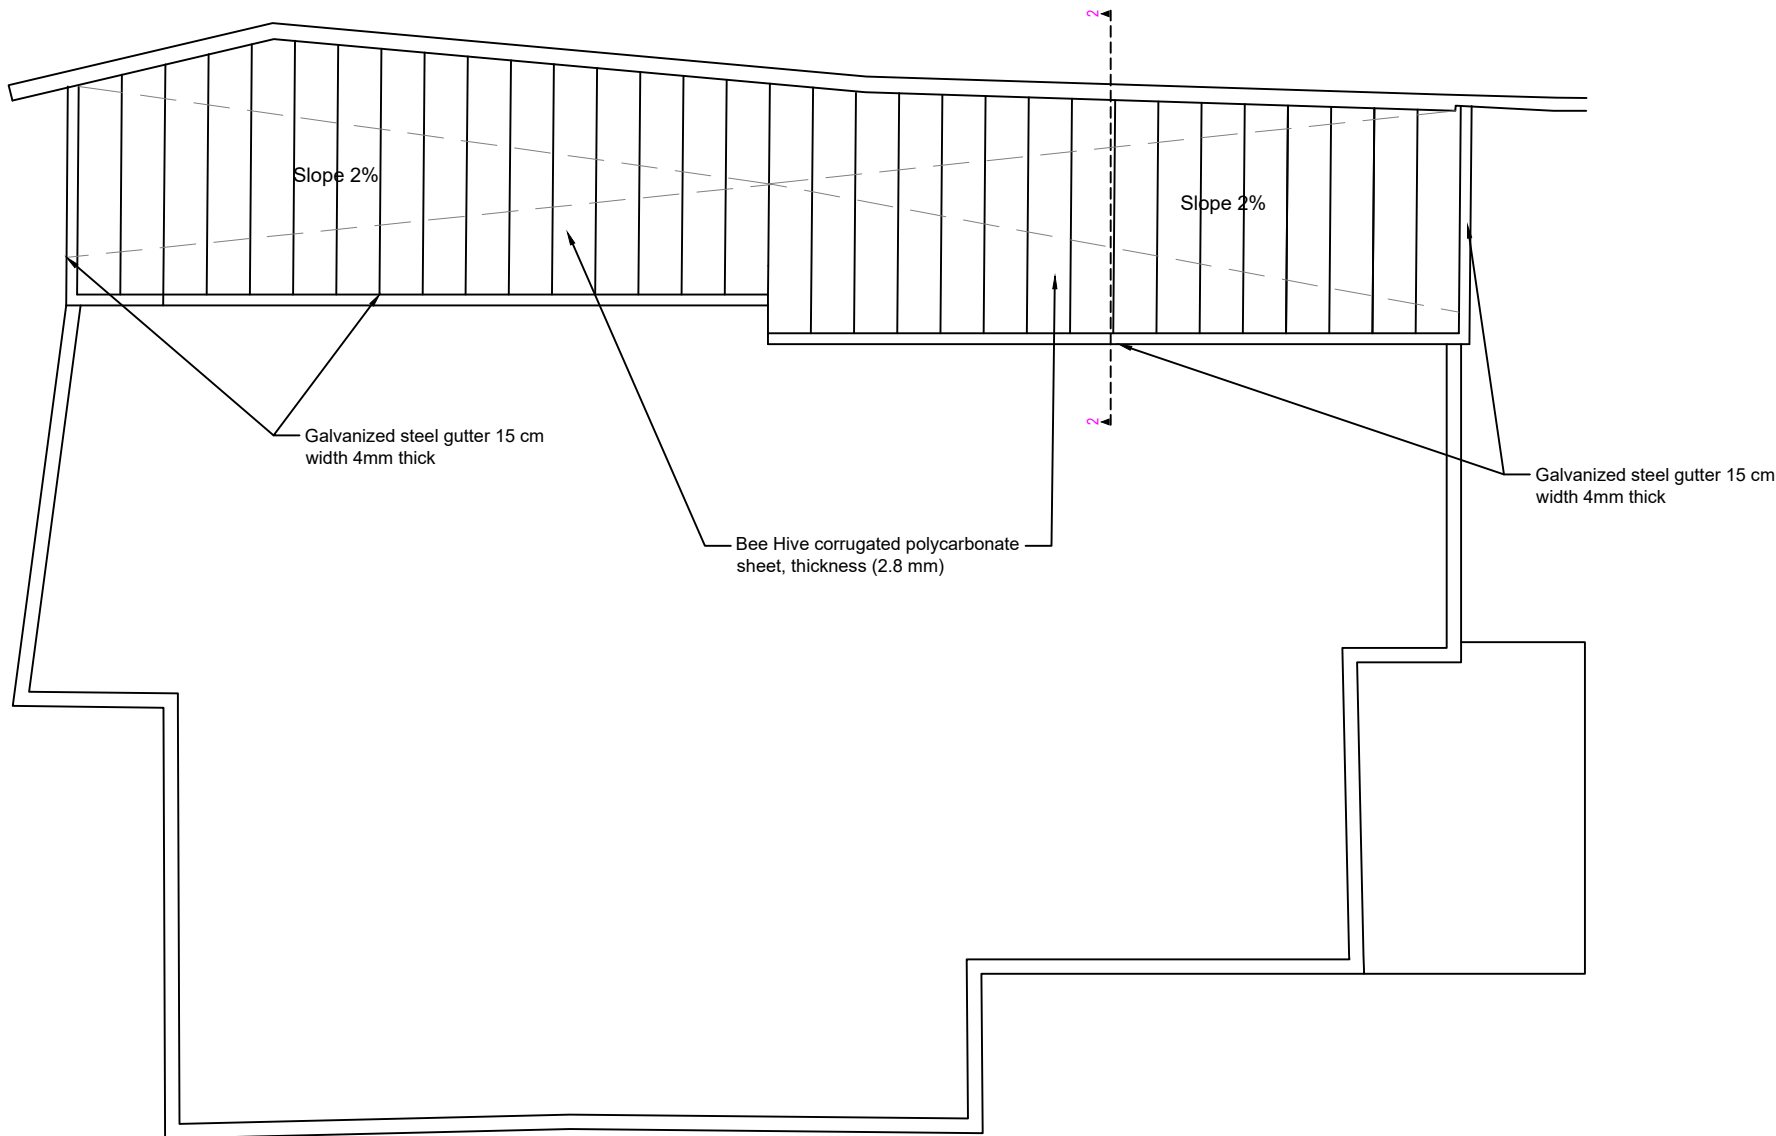


Ground Floor Plan- scale 1:100
Building 3

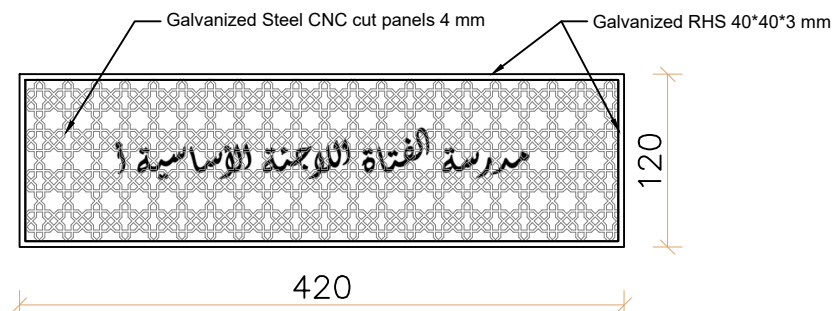

CNC Cut
Scale 1:50

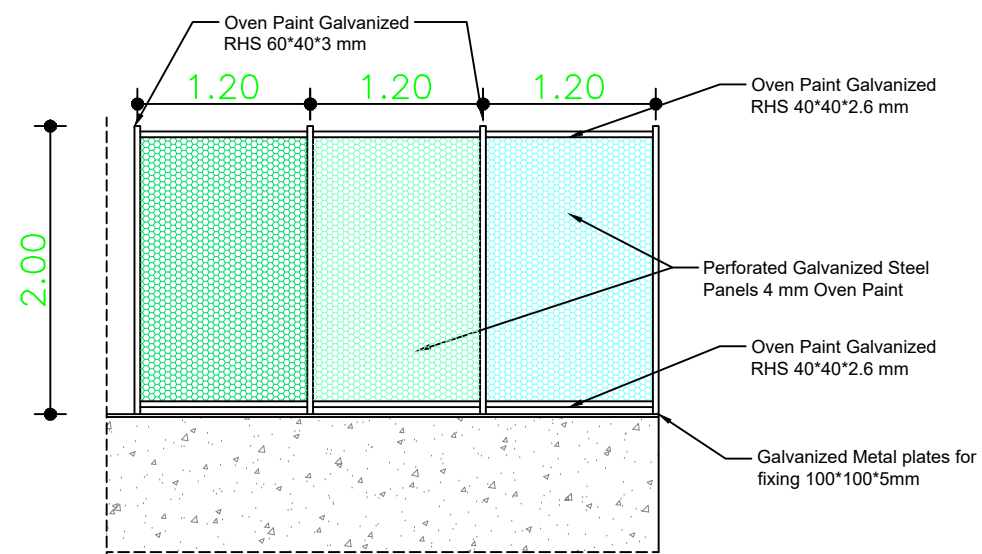

External Fence Detail
Scale 1:50

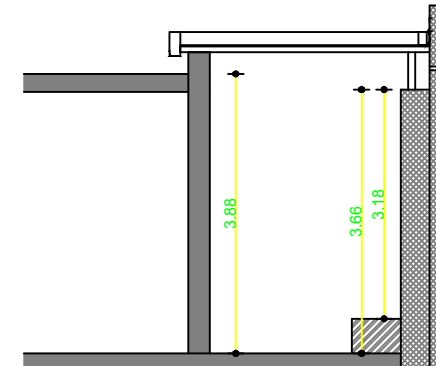


Section 1-1

Notes

- (1) All Dimensions Are In M.
- (2) All Levels Are In Meter
- (3) Any Missing or Unclear Detail And All Fastening Systems For All Elements Shall be Approved by The Supervisor.

Legend:

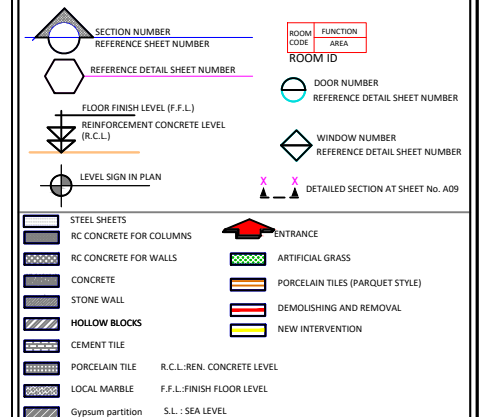

REVISIONS

NO.	DRAWINGS	DATE
(1)		
(2)		
(3)		

Contracting Authority:



Funded By:



Project Title:

“Public Works Contract for the rehabilitation of 5 schools in East Jerusalem”

Reference number: PSE22001-10074

Lot 1: the rehabilitation of Al-Hasan Al-Thany, Al-Shabbat Al-Shameleh, and Al-Fata Al-Laji'a schools in Wadi Al-Joz


Al-Fata Al-Laji'a A Secondary Girls' School

Designed by:




Jerusalem - Sheikh Jarrah- Tobler8
email: mr.wasimhija@gmail.com
Tel. 02-9948344/ 052-8327076
Fax: 02-9948344


Drawing Title	Pergola Design	Date: 25/3/2025 Scale: 1:100
Designed by:	Arch. Hiba Al Ayoubi	Drawing No:
Checked by:	Arch. Wasim Abu El-Hija	A13
Approved by:		
Coordinate Manager:		

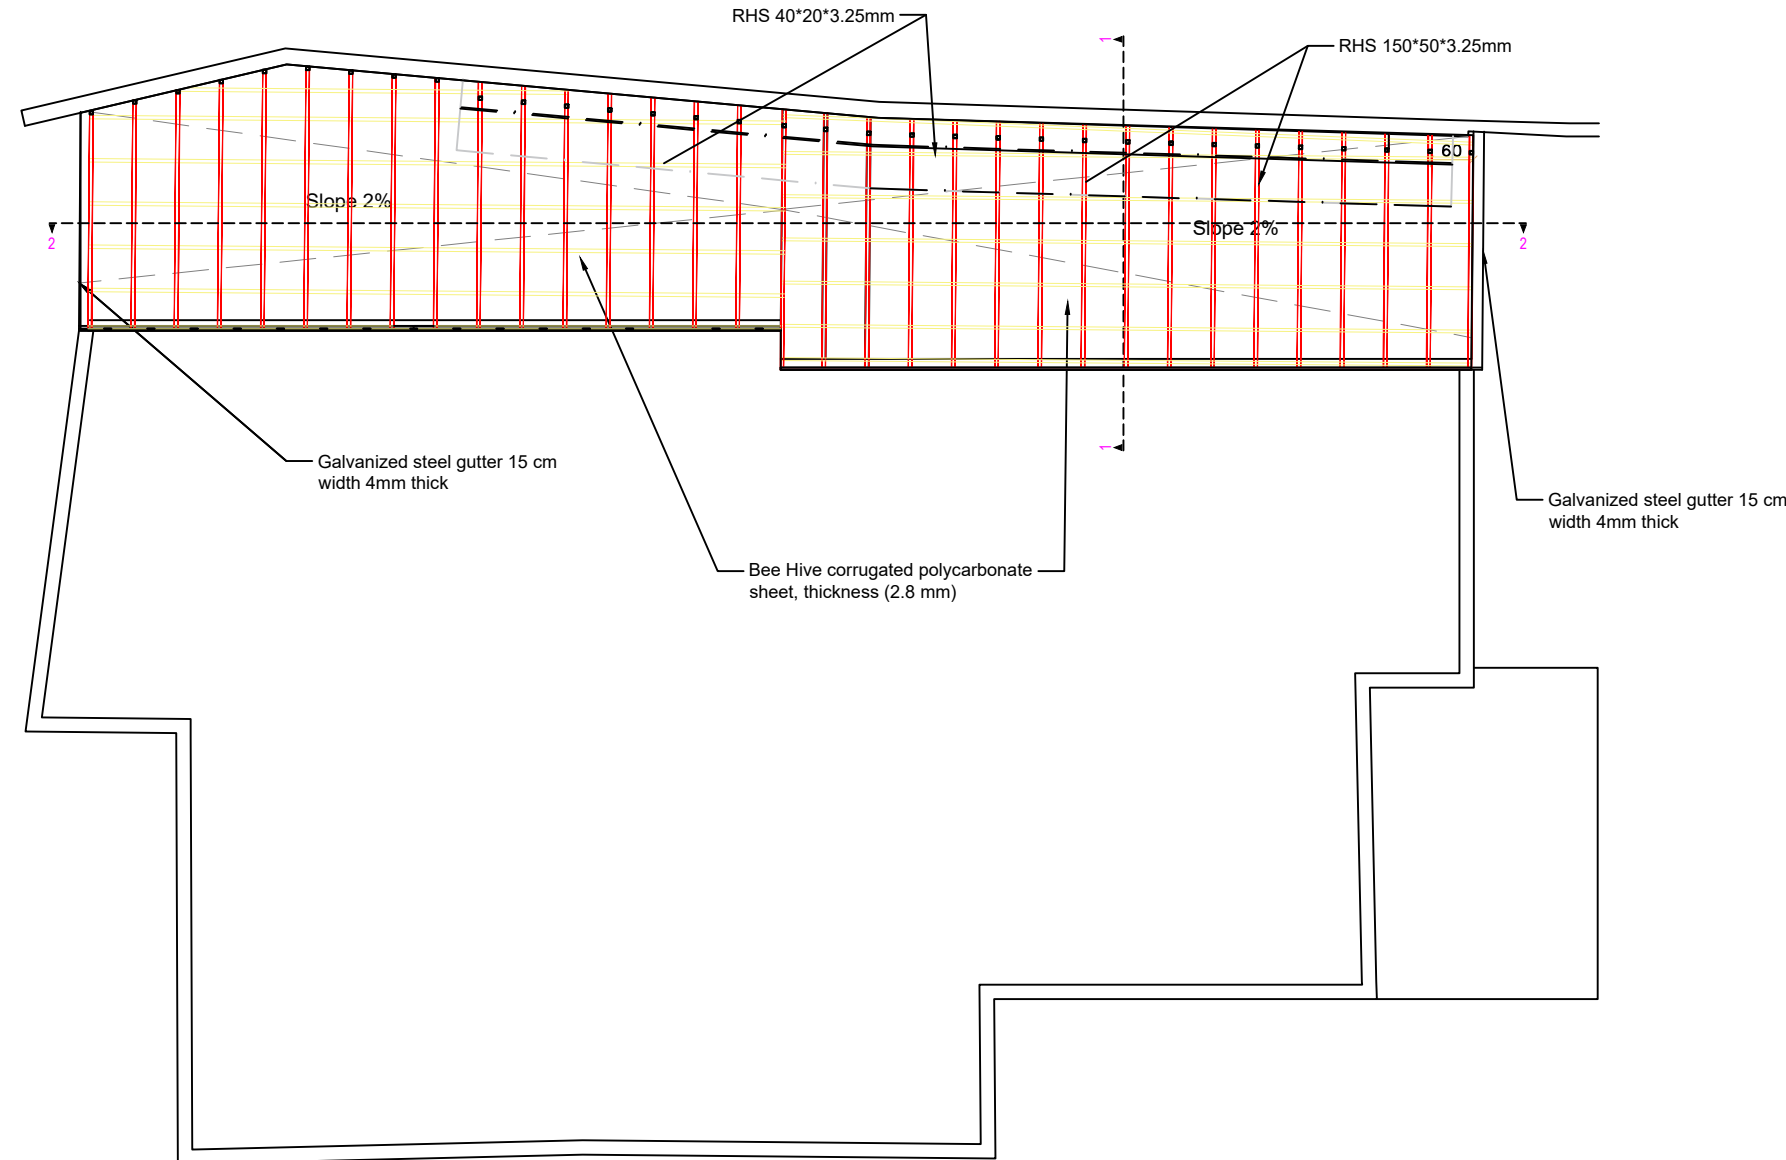


Ground Floor Plan- scale 1:100
Building 3

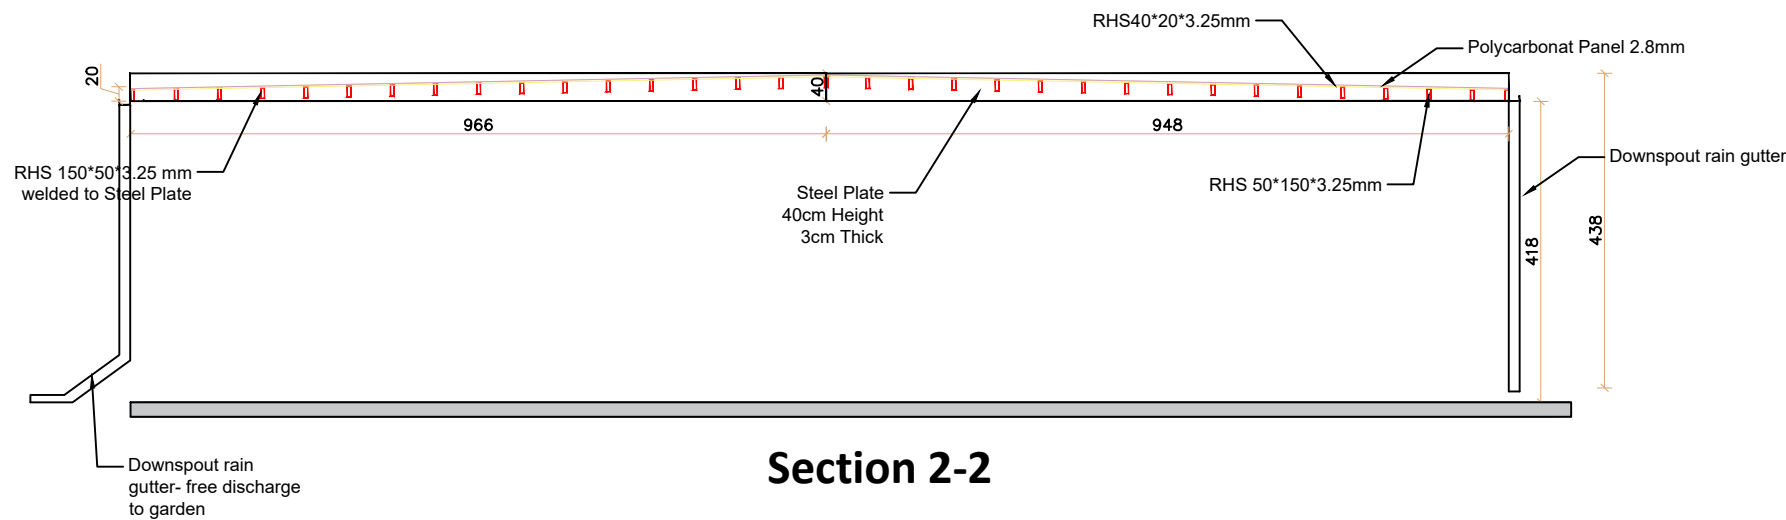

Section 2-2

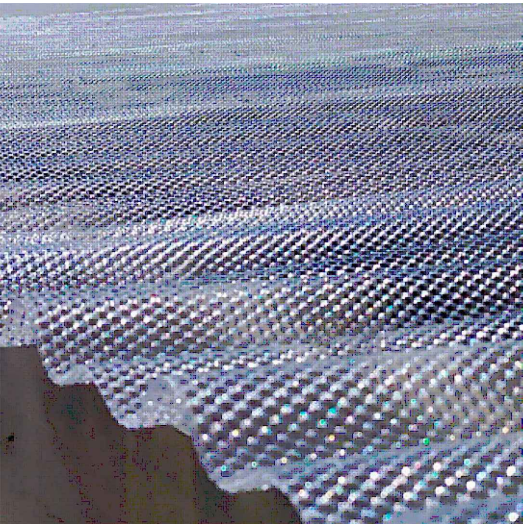

Bee Hive corrugated polycarbonate sheet, thickness (2.8 mm)

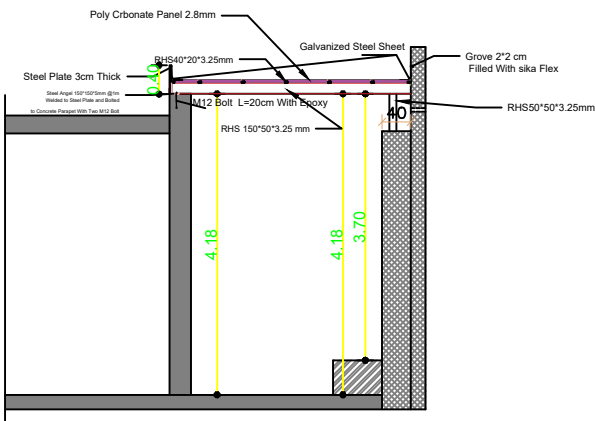

Section 1-1

- Notes**
- (1) All Dimensions Are In M.
 - (2) All Levels Are In Meter
 - (3) Any Missing or Unclear Detail And All Fastening Systems For All Elements Shall be Approved by The Supervisor.

Legend:

SECTION NUMBER
REFERENCE SHEET NUMBER

REFERENCE DETAIL SHEET NUMBER

FLOOR FINISH LEVEL (F.F.L.)
REINFORCEMENT CONCRETE LEVEL (R.C.L.)
LEVEL SIGN IN PLAN

STEEL SHEETS

RC CONCRETE FOR COLUMNS

RC CONCRETE FOR WALLS

CONCRETE

STONE WALL

HOLLOW BLOCKS

CEMENT TILE

PORCELAIN TILE

LOCAL MARBLE

Gypsum partition

ENTRANCE

ARTIFICIAL GRASS

PORCELAIN TILES (PARQUET STYLE)

DEMOLISHING AND REMOVAL

NEW INTERVENTION

DOOR NUMBER
REFERENCE DETAIL SHEET NUMBER

WINDOW NUMBER
REFERENCE DETAIL SHEET NUMBER

DETAILED SECTION AT SHEET No. A09

R.C.L.: REN. CONCRETE LEVEL
F.F.L.: FINISH FLOOR LEVEL
S.L.: SEA LEVEL

REVISIONS		
NO.	DRAWINGS	DATE
(1)		
(2)		
(3)		

Contracting Authority:

Funded By:

Project Title:

“Public Works Contract for the rehabilitation of 5 schools in East Jerusalem”

Reference number: PSE22001-10074

Lot 1: the rehabilitation of Al-Hasan Al-Thany, Al-Shabbat Al-Shameleh, and Al-Fata Al-Laji'a schools in Wadi Al-Joz

Al-Fata Al-Laji'a A Secondary Girls' School

Designed by:

Jerusalem - Sheikh Jarrah- Tobler8
email: mr.wasimhija@gmail.com

Tel. 02-9948344/ 052-8327076
Fax: 02-9948344

Drawing Title	Structural Design for Pergola	Date: 25/3/2025 Scale: 1:100
Designed by:	Saba Ameerah	Drawing No:
Checked by:	Arch. Wasim Abu El-Hija	S02
Approved by:		

SYMBOL			DESCRIPTION		
			LIGHTING FIXTURE & SWITCHES		H= (cm) a.f.f.
	40W WH 40cm, ,6500K				
	EMERGENCY LED LIGHT, 3W		CEILING		
	24W, AQUA LED ,6000K ,IP54				
	50W, NISKD JET LED SMD ,6000K,IP65				
	125X30cm,4x36W,5000K LED light				
	LED TYPE WITH EXIT SIGN AND ARROWS EMERGENCY LIGHTING FIX.				
	48W, SPEED LED WP, 6500K, IP65				
	spot light unit directed to up mounted on wall				
	spot light unit directed down mounted on wall				
	LINEAR LED LINE				
	spot light unit inside glass locker				
	SINGLE POLE ONE GANG SWITCH / W.P.		130		
	SINGLE POLE TWO GANG SWITCH / W.P.		130		
	SINGLE POLE THREE GANG SWITCH / W.P.		130		
	SINGLE POLE FOUR GANG SWITCH / W.P.		130		
	TWO WAY SWITCH / W.P.		130		
	INTERMEDIATE SWITCH		130		
	PUSH BUTTON		130		
			FIRE ALARM SYSTEM		
	PHOTO SMOKE SENSOR		CEILING		
	HEAT DETECTOR		CEILING		
	BREAK GLASS With Cover		150		
	INTERNAL SIREN		220		
	CONTROL MODULE		CEILING		
	EXTERNAL SIREN WITH FALSHER		220		
	Beam Detector-Receiver				
	Beam Detector-Transmitter				
	DETECTOR INDICATION LAMP		CEILING		
	PHOELECTRIC SMOKE DET. ABOVE FAULSECEILING		CEILING		
	FIRE ALARM CONTROL PANEL		180		
	REPEATER PANEL WITH CONTROL		150		

SYMBOL			DESCRIPTION		
			POWER SOCKETS		H= (cm) a.f.f.
	16A 3 PIN SOCKET OUTLET / W.P.				
	16A 3 PIN SOCKET OUTLET CEILING MOUNTED				
	16A 3 PIN TWIN SOCKET OUTLET / W.P.				
	16A 3 PIN TRIPLE SOCKET OUTLET				
	SINGLE PHASE (2POLE) ISOLATOR, Rate As Indicated				
	THREE PHASE (4POLE) ISOLATOR, Rate As Indicated				
	DOUBLE POLE SWITCH WITH INDICATOR LAMP / W.P.				
	JUNCTION BOX				
	EMERGENCY TRIP PUSH BUTTON				
	MDB				
			CEILING		
			L.V. SOCKETS		
	TELEPHONE SOCKET OUTLET		110		
	T.V. SOCKET OUTLET		110		
	INTERCOM SPEAKER		110		
	CONNECTION BOX		110		
	DATA SOCKET OUTLET		110		
	LOW VOLTAGE BOX				
	COMPUTER PATCH PANEL		Top Of Panel		
			CCTV SYSTEM		
	Network Video Recorder		220		
			220		
	DOME IN/OUT DOOR COLORED CAMERA		CEILING		
	FIXED OUTDOOR COLORED CAMERA DAY/NIGHT		300		
	SPLIT SCREEN MONITOR		Table		
	CCTV CENTRAL MONITOR		Table		
	School Bell		220		
SYMBOL			DESCRIPTION		
			SOUND SYSTEM		H= (cm) a.f.f.
	6WATT RECESSED LOUD SPEAKER		CEILING		
	6WATT SURFACE MOUNT LOUD SPEAKER		220		
	25W WALL MOUNTED ADJUSTABLE HORN		220		
	END OF THE LINE		CEILING		
	VOLUME CONTROL		150		
	16 BUTTON CALL STATION		Table		
	PUBLIC ADDRESS AND VOICE ALARM RACK		180		

CONDUIT COLORS & WIRING DETAILS			
DESC.	Color	CONDUIT Size	Cable / Wires
COMPUTER	Yellow	1ø16 CONDUIT	CAT6 SHEILDED CABLE
POWER	Green	1ø16 CONDUIT	3x2.5 mm2 wires or XLPE Cable
UPS	Green	1ø16 CONDUIT	3x2.5 mm2 wires or XLPE Cable
TELEPHONE	Brown	1ø16 CONDUIT	2 pair telephone cable
LIGHTING	Blue	1ø16 CONDUIT	3x1.5 mm2 wires or XLPE Cable
FIRE	Red	1ø16 CONDUIT	4x0.8 mm2 FIRE CABLE(RED)
CAMERA, Access Control	White	1ø16 CONDUIT	CAT6 SHEILDED CABLE
TV,/Sat.	White	1ø16 CONDUIT	RG 59
Public Address Speakers	White	1ø16 CONDUIT	2x1 mm2 multicore speaker cable
Burglar Alarm	White	1ø16 CONDUIT	2 pair telephone cable

List Of Drawing:

Notes
(1) All Dimensions Are In M.
(2) All Levels Are In Meter
(3) Any Missing or Unclear Detail And All Fastening Systems For All Elements Shall be Approved by The Supervisor.

Legend:

REVISIONS		
NO.	DRAWINGS	DATE
(1)		
(2)		
(3)		

Contracting Authority:	
------------------------	---

Funded By:	
------------	---

Project Title:
“Public Works Contract for the rehabilitation of 5 schools in East Jerusalem”
Reference number: PSE22001-10074
Lot 1: the rehabilitation of Al-Hasan Al-Thany, Al-Shabbat Al-Shameleh, and Al-Fata Al-Laji’a schools in Wadi Al-Joz
Al-Fata Al-Laji'a A Secondary Girls' School

Designed by:	
Jerusalem - Sheikh Jarrah- Tobler8 email: mr.wasimhija@gmail.com	
Tel. 02-9948344/ 052-8327076 Fax: 02-9948344	

Drawing Title	Scope of Intervention Electrical Legend	Date: 25/3/2025 Scale: 1:100
Designed by:	Eng. Adli Naser Al-Deen	Drawing No:
Checked by:	Eng. Adli Naser Al-Deen	E00
Approved by:		
Coordinate Manager:		



**Scope of Intervention
Building 1 & 2**

Notes

- (1) All Dimensions Are In M.
- (2) All Levels Are In Meter
- (3) Any Missing or Unclear Detail And All Fastening Systems For All Elements Shall be Approved by The Supervisor.

Legend:

REVISIONS

NO.	DRAWINGS	DATE
(1)		
(2)		
(3)		

Contracting Authority:



Funded By:



Project Title:

**“Public Works Contract for the rehabilitation
of 5 schools in East Jerusalem”**

Reference number: PSE22001-10074

**Lot 1: the rehabilitation of Al-Hasan
Al-Thany, Al-Shabbat Al-Shameleh, and
Al-Fata Al-Laji'a schools in Wadi Al-Joz**


**Al-Fata Al-Laji'a A Secondary
Girls' School**

Designed by:



Jerusalem - Sheikh Jarrah- Tobler8
email: mr.wasimhija@gmail.com
Tel. 02-9948344/ 052-8327076
Fax: 02-9948344

Drawing Title	Fire alarm system	Date: 25/3/2025 Scale: 1:100
Designed by:	Eng. Adli Naser Al-Deen	Drawing No:
Checked by:	Eng. Adli Naser Al-Deen	E01
Approved by:		
Coordinate Manager:		

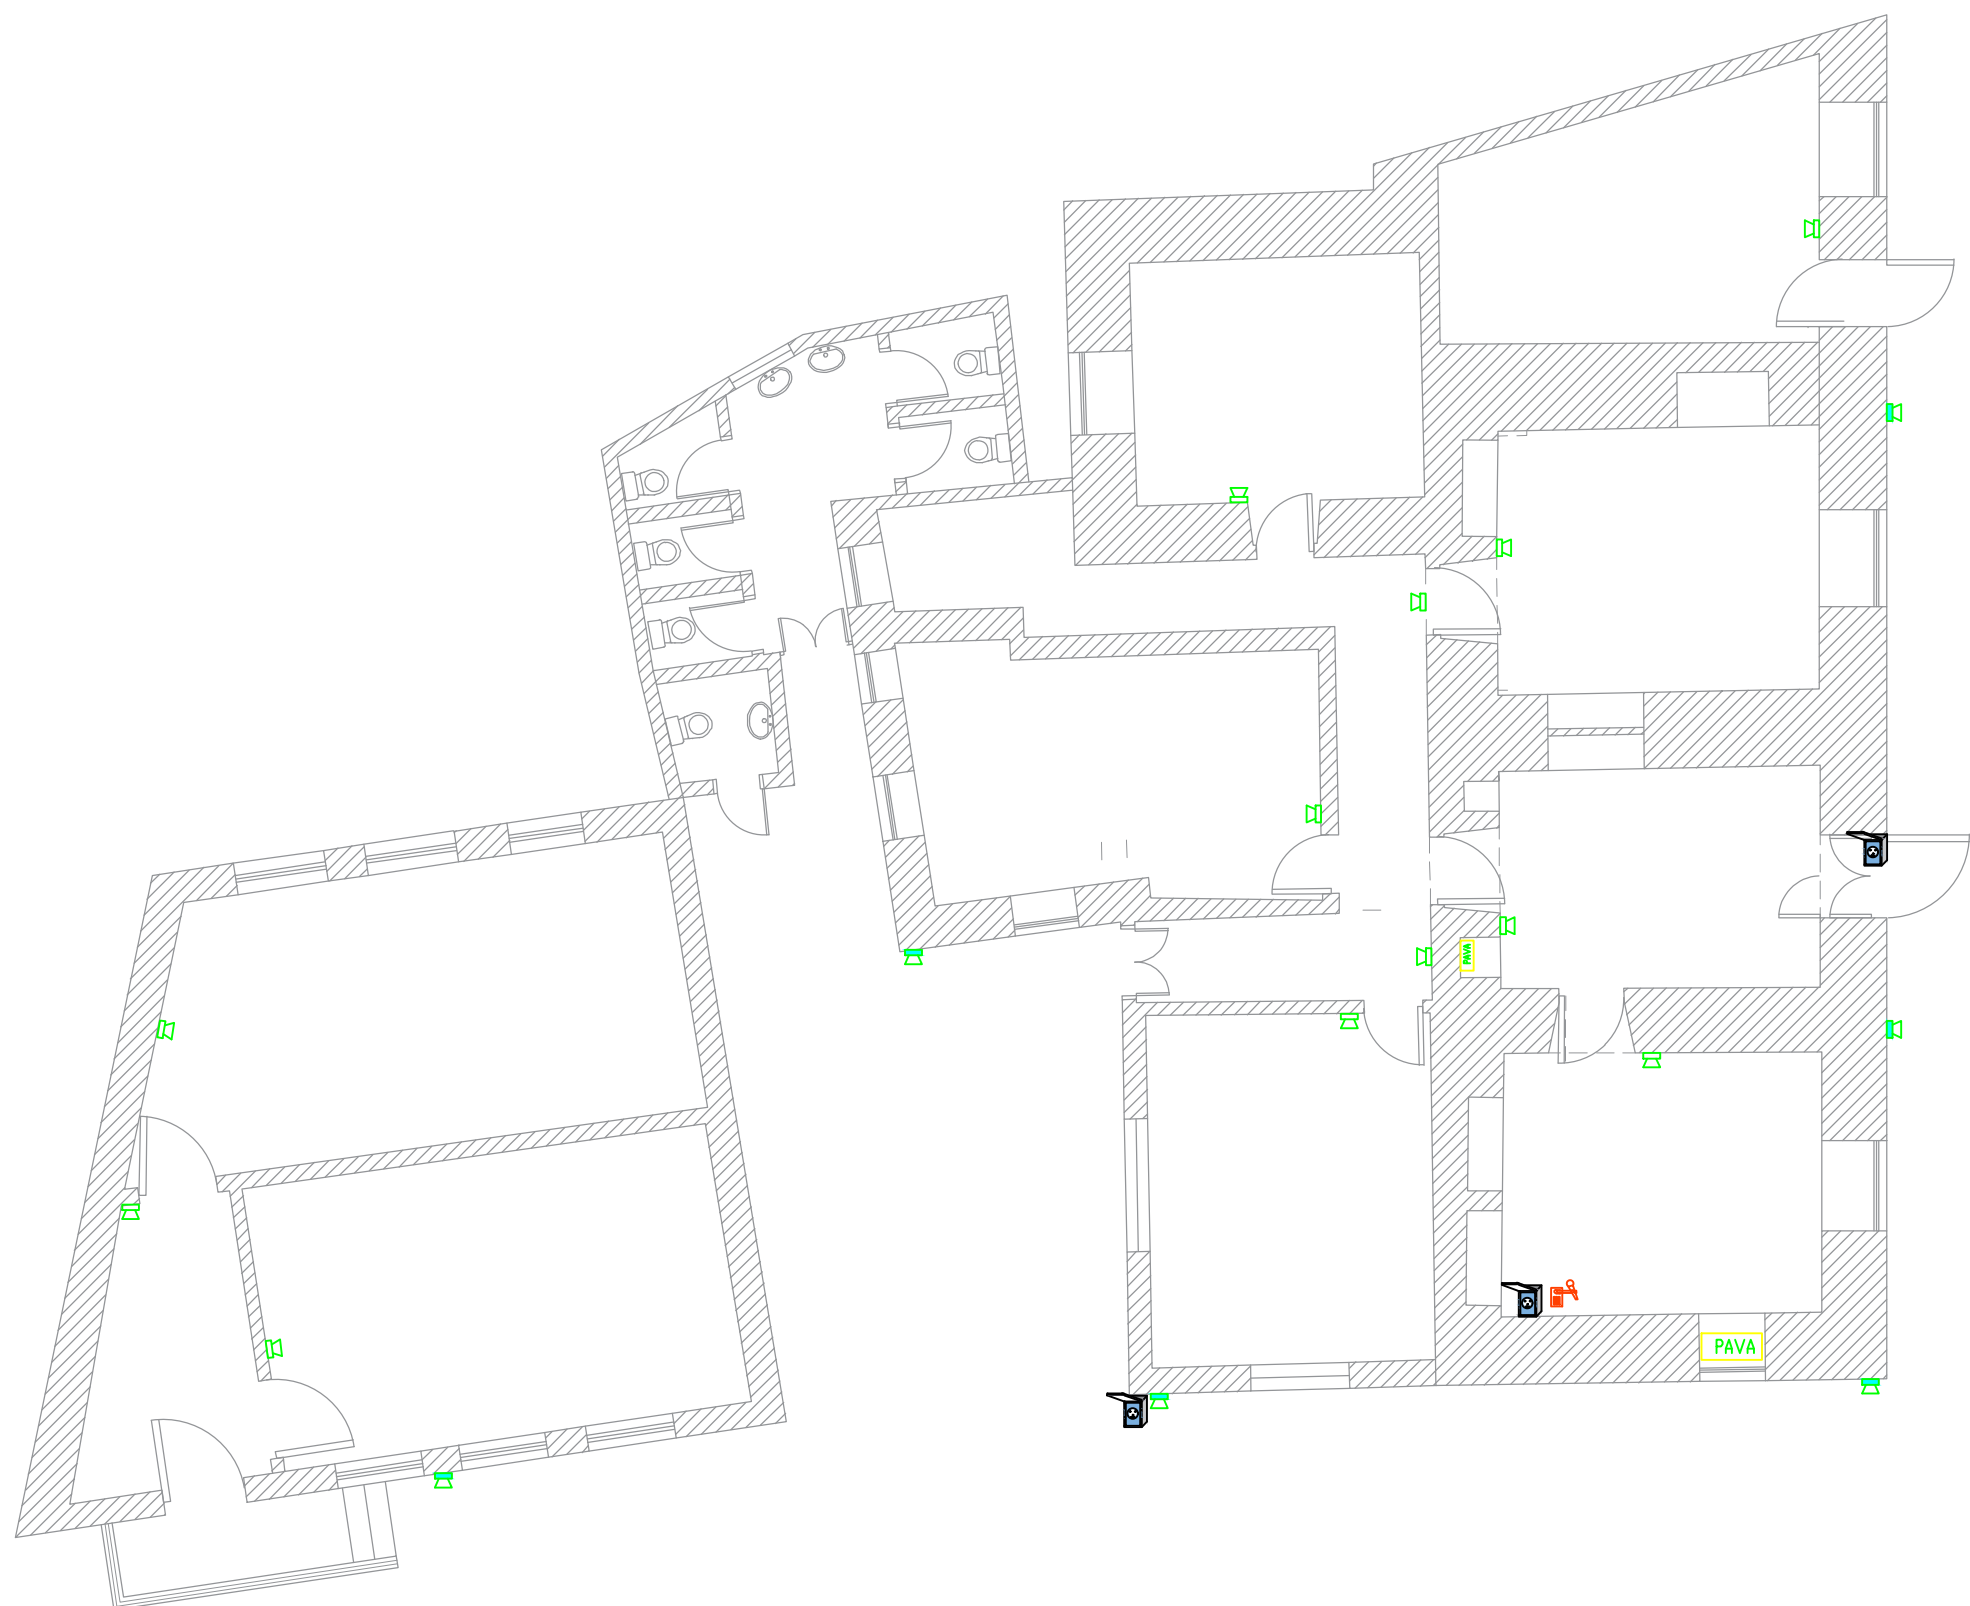

**Scope of Intervention
Building 1 & 2**

Notes

- (1) All Dimensions Are In M.
- (2) All Levels Are In Meter
- (3) Any Missing or Unclear Detail And All Fastening Systems For All Elements Shall be Approved by The Supervisor.

Legend:

REVISIONS

NO.	DRAWINGS	DATE
(1)		
(2)		
(3)		

Contracting Authority:



Funded By:



Project Title:

**“Public Works Contract for the rehabilitation
of 5 schools in East Jerusalem”**

Reference number: PSE22001-10074

**Lot 1: the rehabilitation of Al-Hasan
Al-Thany, Al-Shabbat Al-Shameleh, and
Al-Fata Al-Laji'a schools in Wadi Al-Joz**


**Al-Fata Al-Laji'a A Secondary
Girls' School**

Designed by:



Jerusalem - Sheikh Jarrah- Tobler8
email: mr.wasimhija@gmail.com
Tel. 02-9948344/ 052-8327076
Fax: 02-9948344

Drawing Title	Public address system	Date: 25/3/2025 Scale: 1:100
Designed by:	Eng. Adli Naser Al-Deen	Drawing No:
Checked by:	Eng. Adli Naser Al-Deen	E02
Approved by:		
Coordinate Manager:		

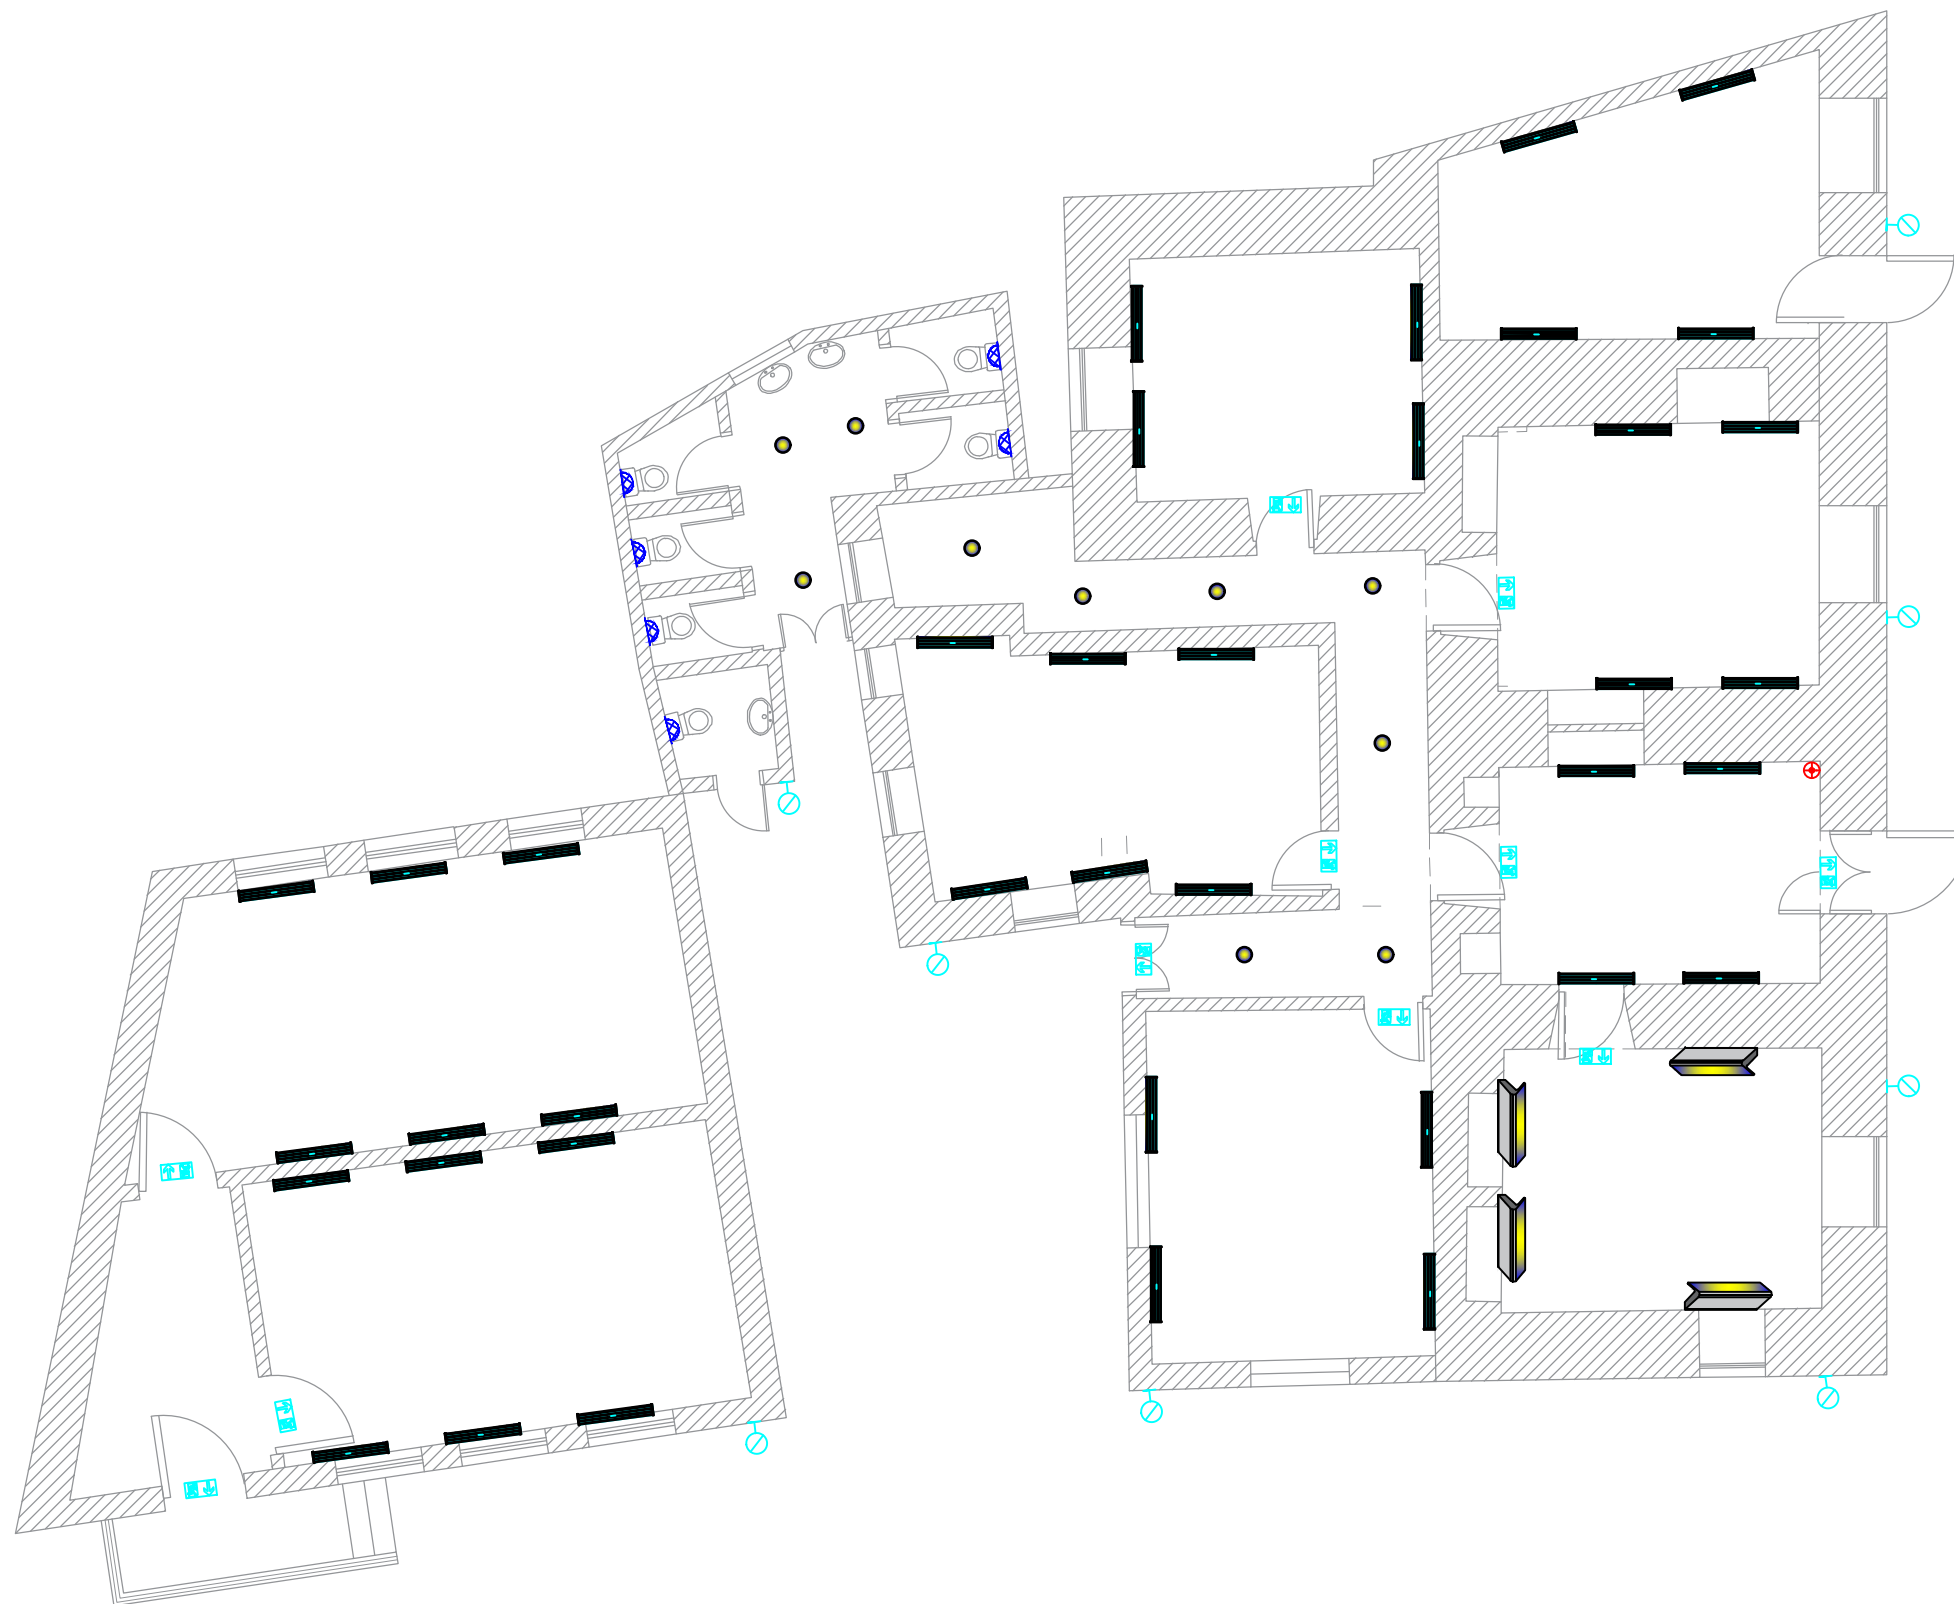

**Scope of Intervention
Building 1 & 2**

Notes

- (1) All Dimensions Are In M.
- (2) All Levels Are In Meter
- (3) Any Missing or Unclear Detail And All Fastening Systems For All Elements Shall be Approved by The Supervisor.

Legend:

REVISIONS		
NO.	DRAWINGS	DATE
(1)		
(2)		
(3)		

Contracting Authority:



Funded By:



Project Title:

**“Public Works Contract for the rehabilitation
of 5 schools in East Jerusalem”**

Reference number: PSE22001-10074

**Lot 1: the rehabilitation of Al-Hasan
Al-Thany, Al-Shabbat Al-Shameleh, and
Al-Fata Al-Laji'a schools in Wadi Al-Joz**


**Al-Fata Al-Laji'a A Secondary
Girls' School**

Designed by:



Jerusalem - Sheikh Jarrah- Tobler8
email: mr.wasimhija@gmail.com
Tel. 02-9948344/ 052-8327076
Fax: 02-9948344

Drawing Title	Lighting system	Date: 25/3/2025 Scale: 1:100
Designed by:	LIGHTING SYSTEM	Drawing No:
Checked by:	Eng. Adli Naser Al-Deen	E03
Approved by:		
Coordinate Manager:		

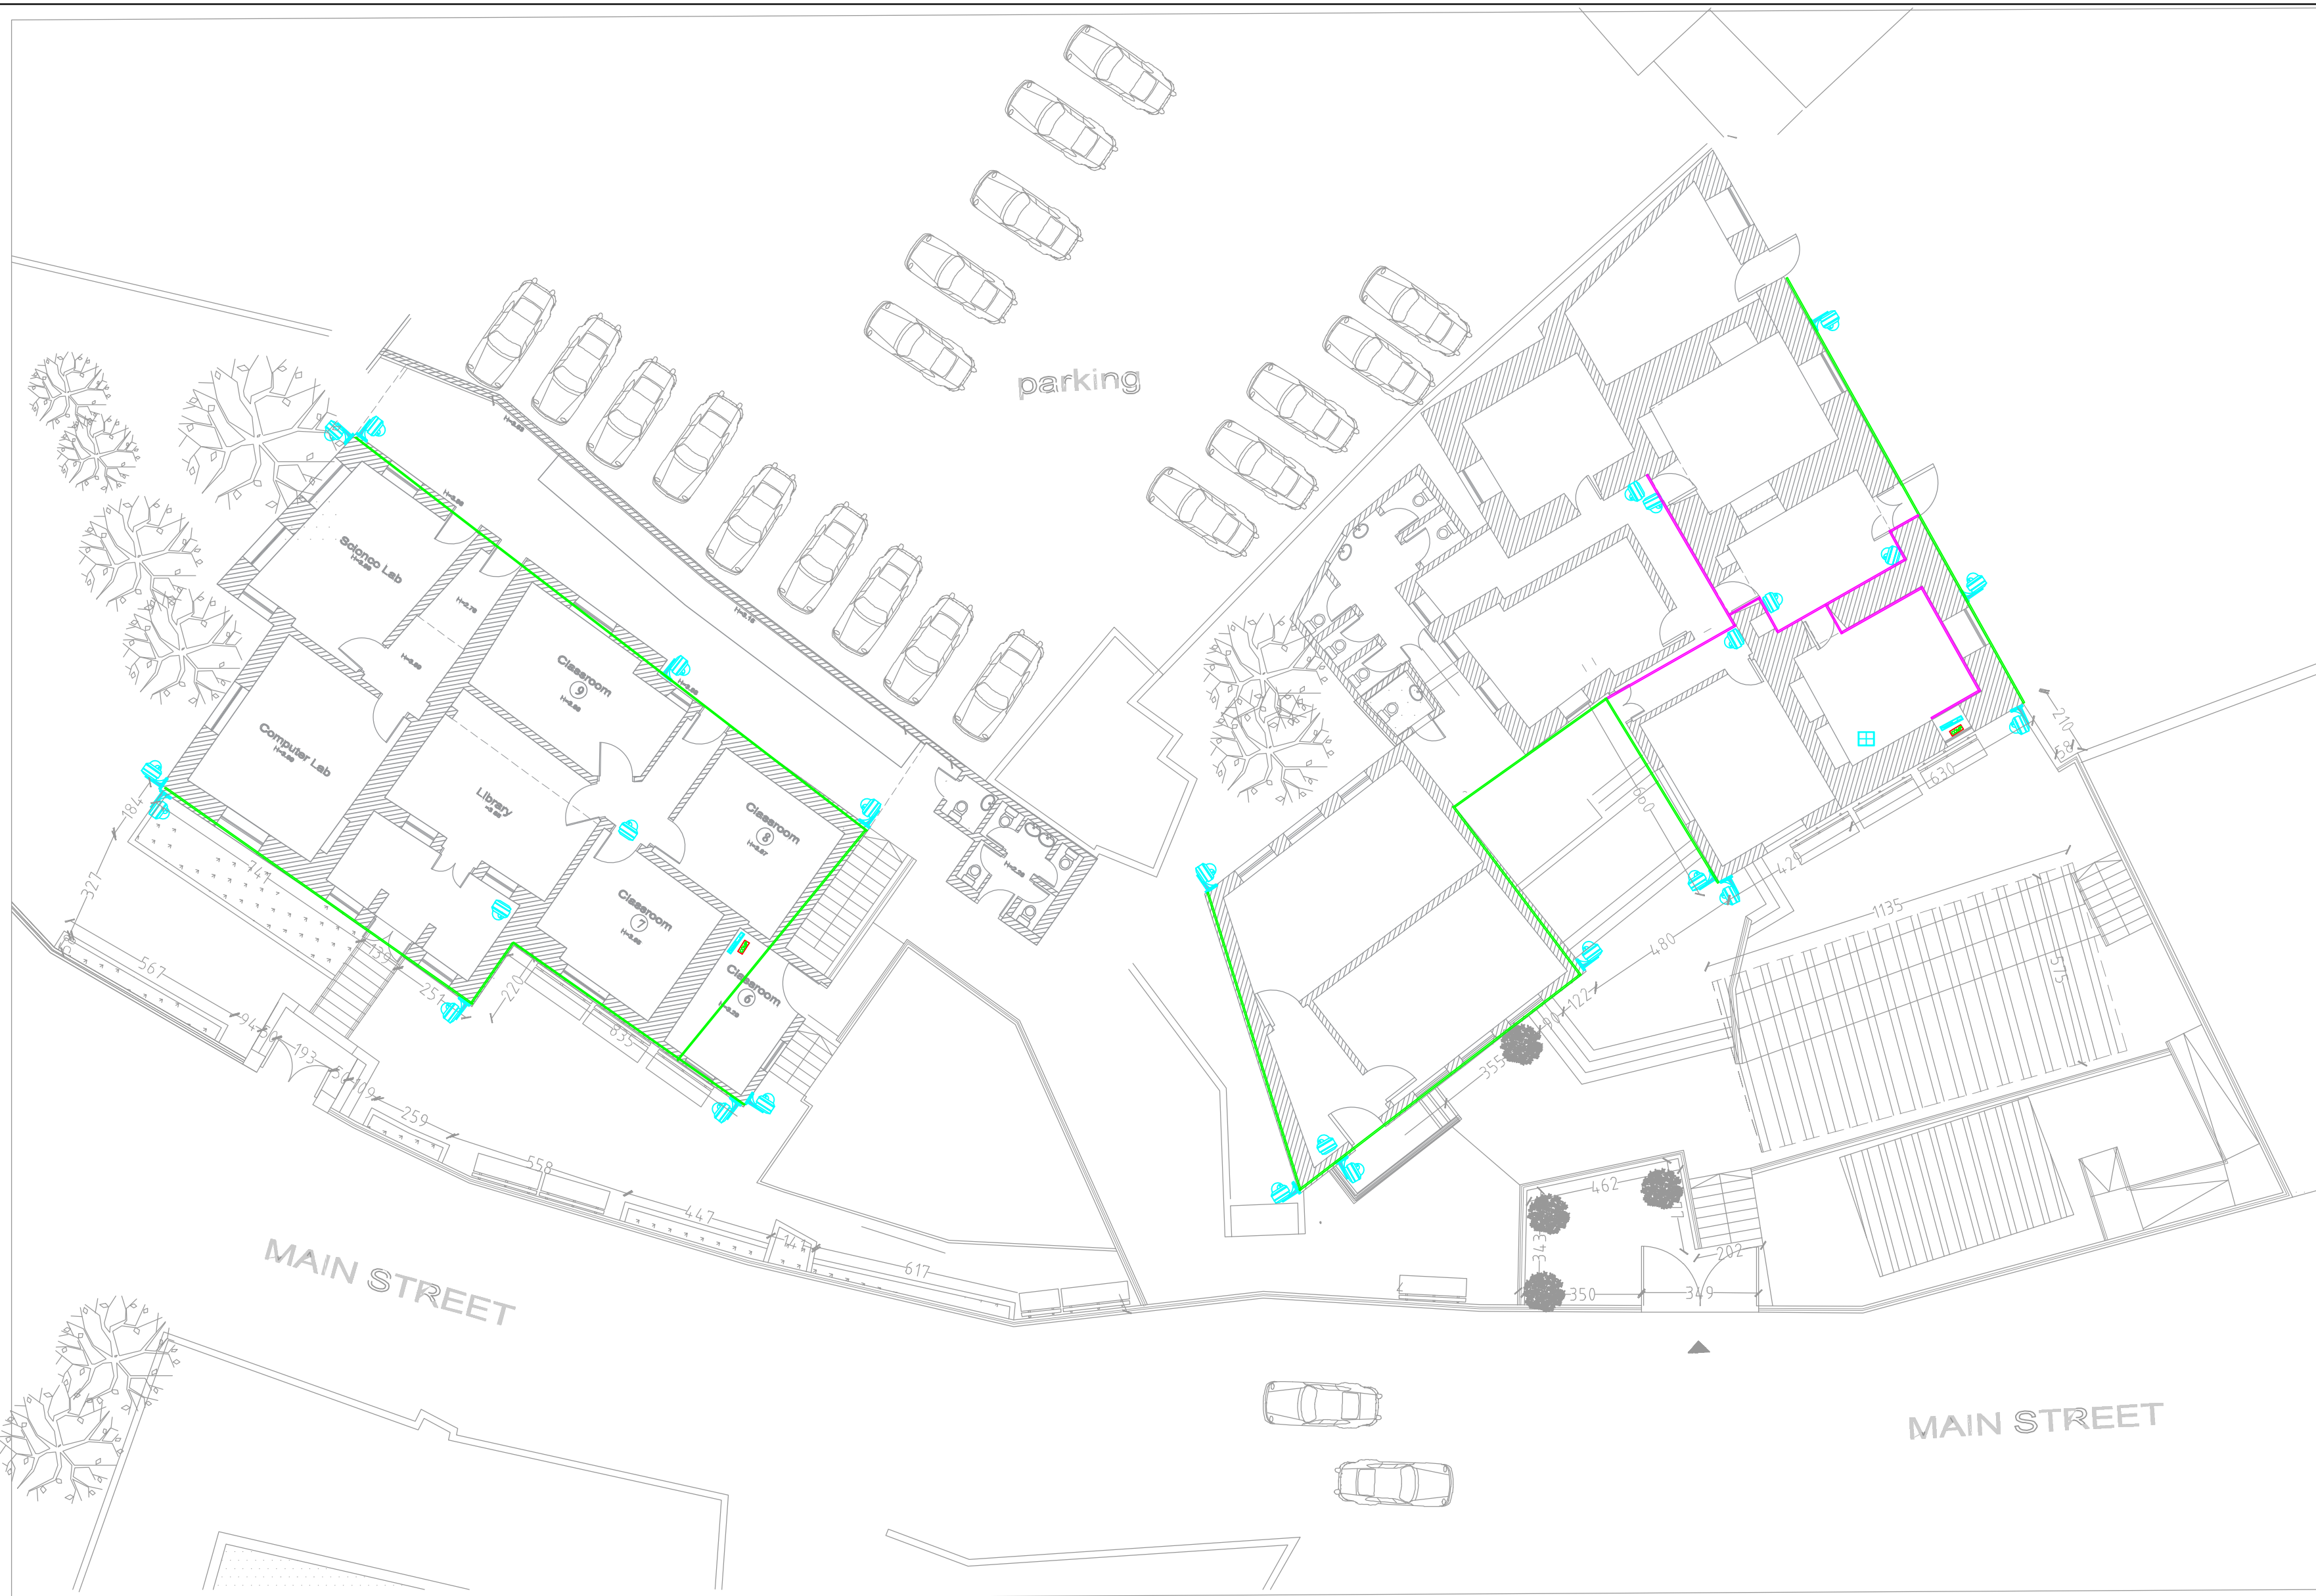

Scope of Intervention Building 1 , 2 & 3

Notes

- (1) All Dimensions Are In M.
- (2) All Levels Are In Meter
- (3) Any Missing or Unclear Detail And All Fastening Systems For All Elements Shall be Approved by The Supervisor.

Legend:

REVISIONS		
NO.	DRAWINGS	DATE
(1)		
(2)		
(3)		

Contracting Authority:



Funded By:



Project Title:

“Public Works Contract for the rehabilitation of 5 schools in East Jerusalem”

Reference number: PSE22001-10074

Lot 1: the rehabilitation of Al-Hasan Al-Thany, Al-Shabbat Al-Shameleh, and Al-Fata Al-Laji'a schools in Wadi Al-Joz




Al-Fata Al-Laji'a A Secondary Girls' School

Designed by:



Jerusalem - Sheikh Jarrah- Tobler8
email: mr.wasimhija@gmail.com
Tel. 02-9948344/ 052-8327076
Fax: 02-9948344

Drawing Title	Scope of Intervention	Date: 25/3/2025 Scale: 1:200
Designed by:	Eng. Adli Naser Al-Deen	Drawing No: E04
Checked by:	Eng. Adli Naser Al-Deen	
Approved by:		
Coordinate Manager:		

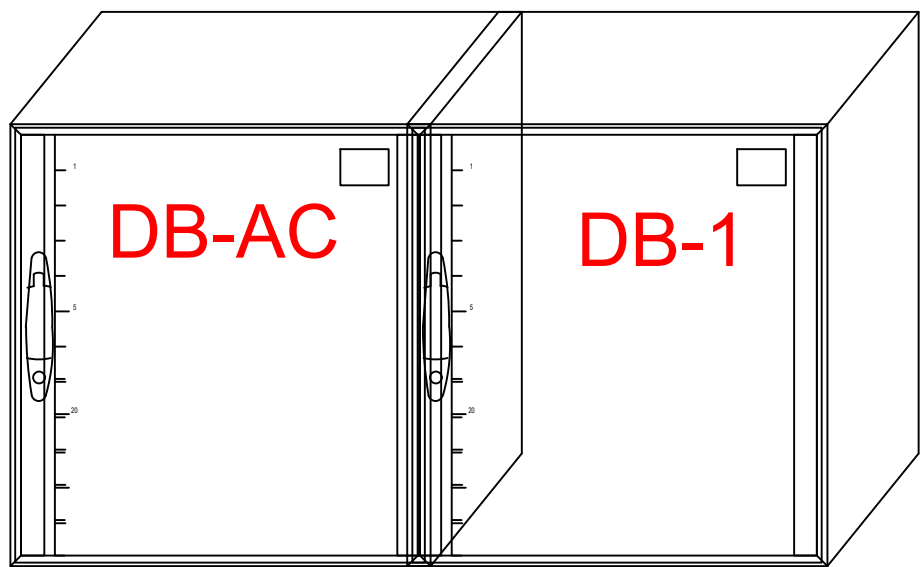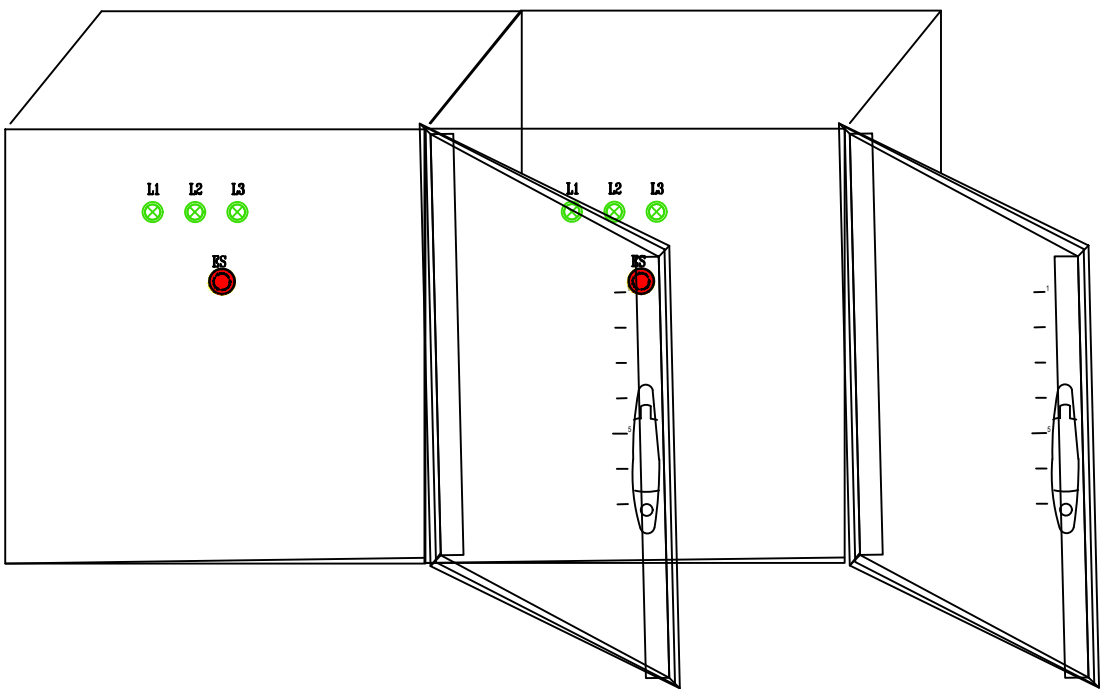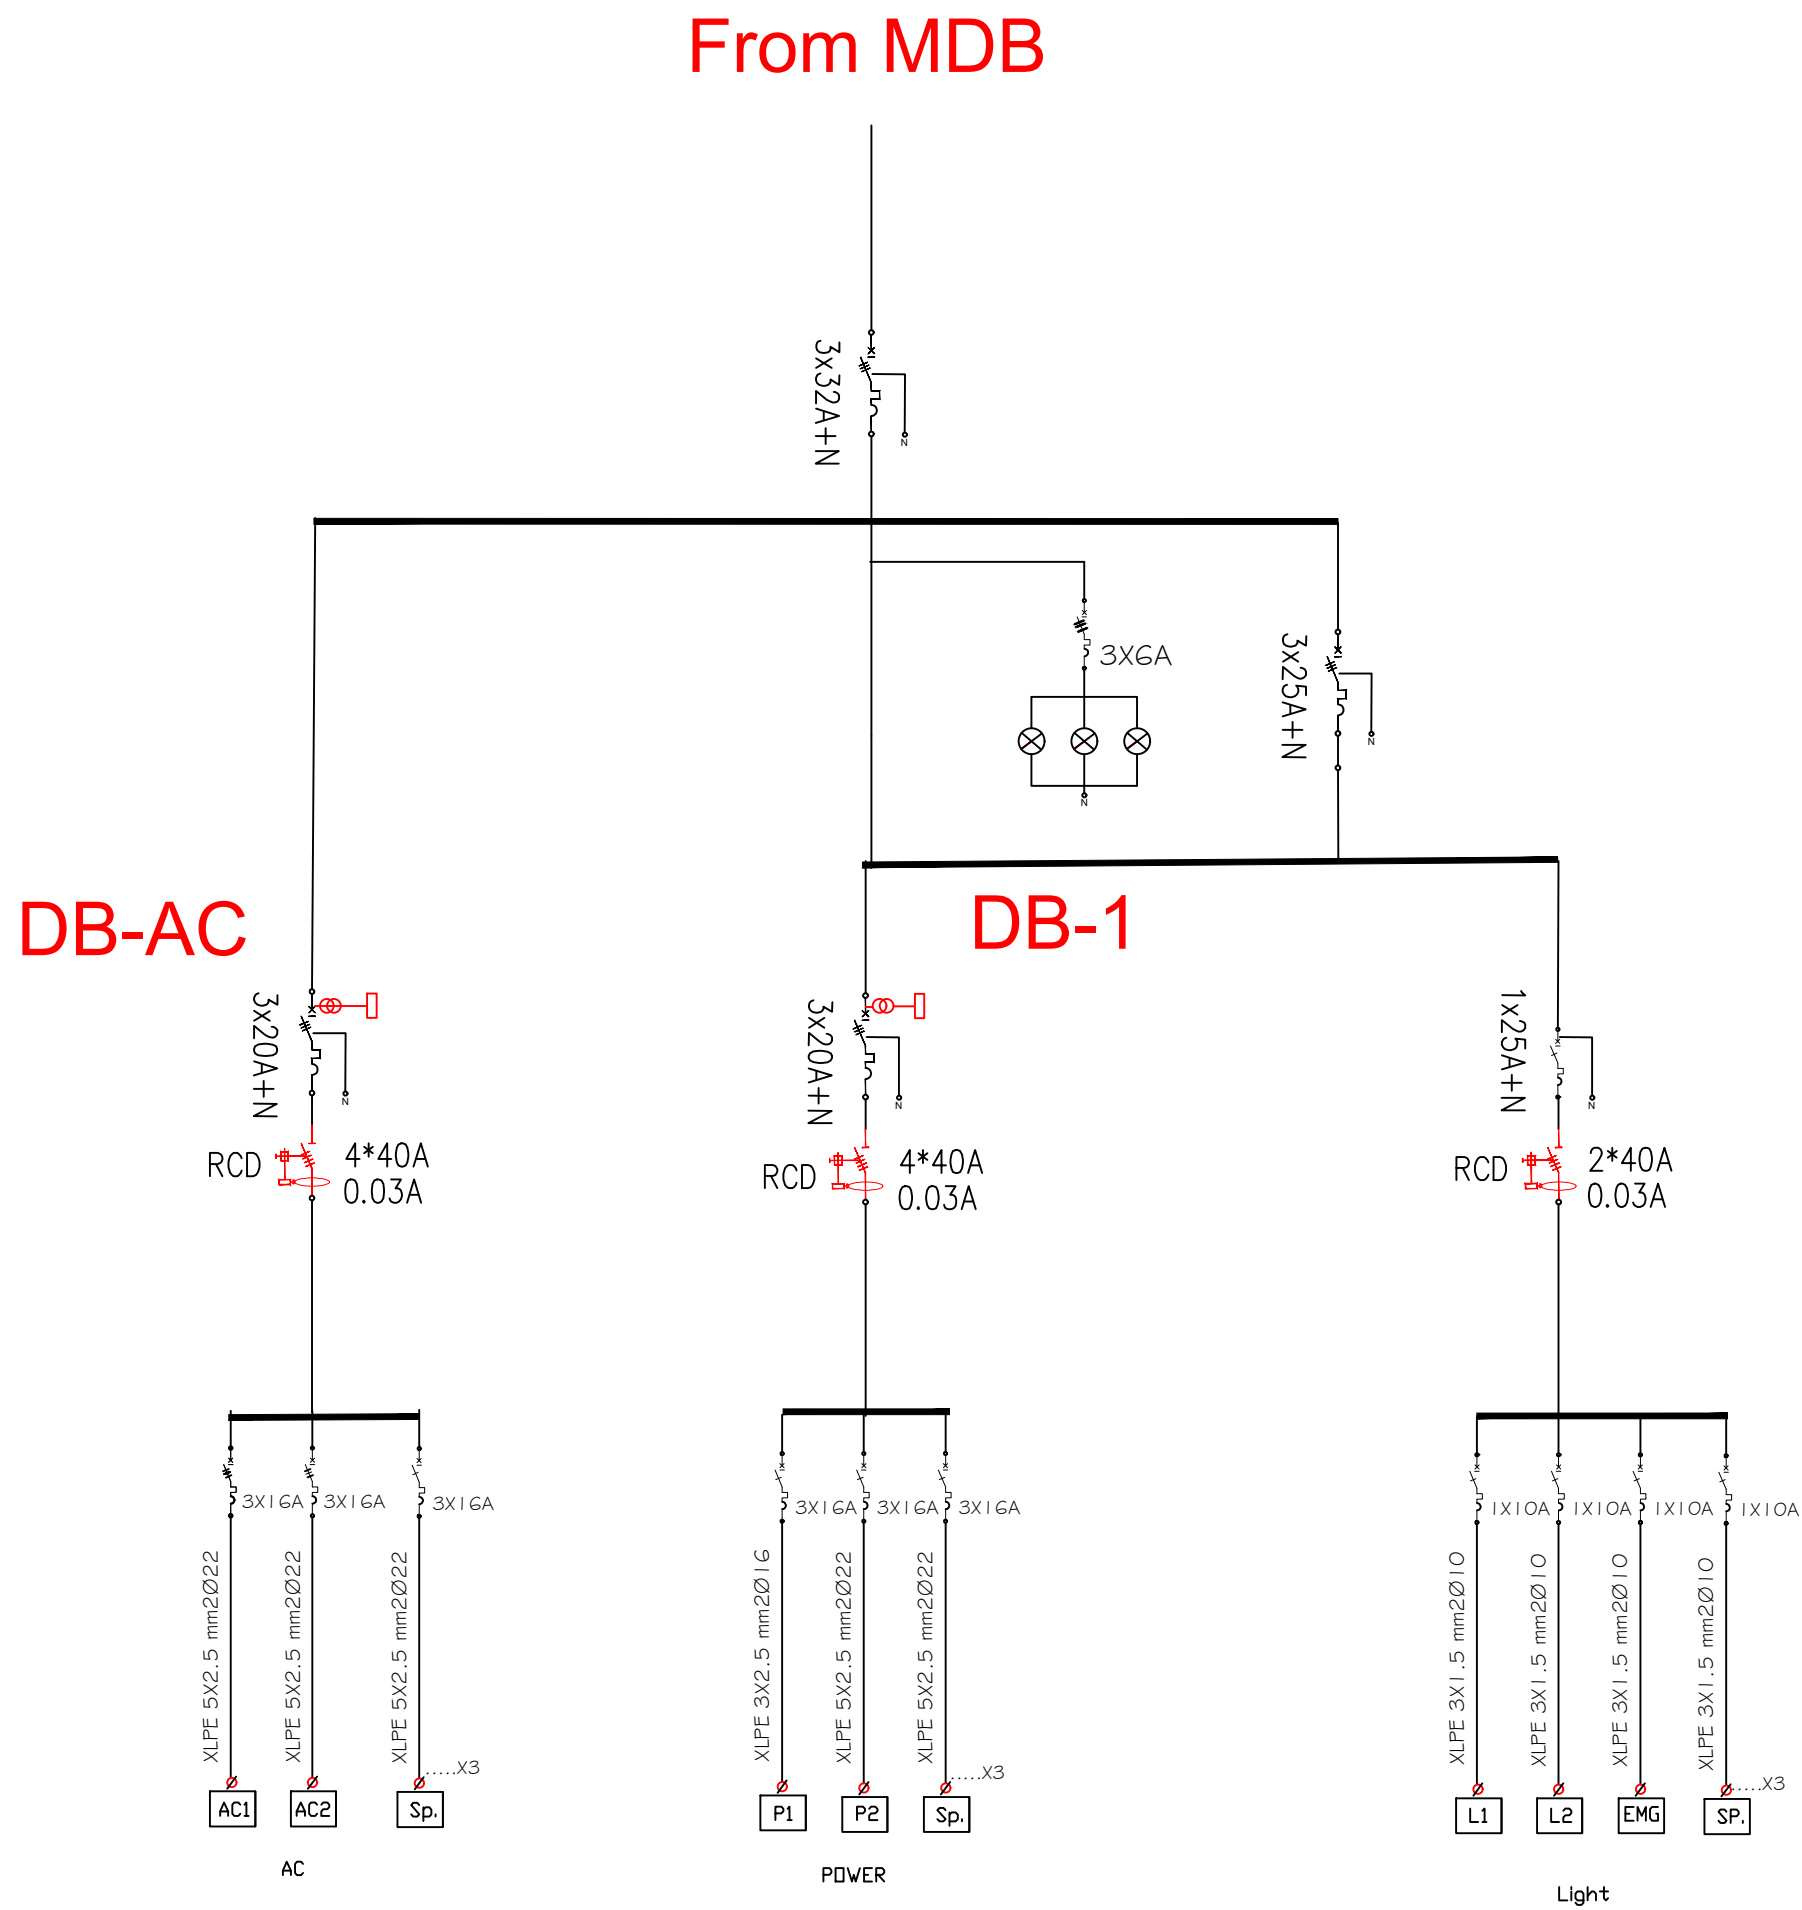

Notes

- (1) All Dimensions Are In M.
- (2) All Levels Are In Meter
- (3) Any Missing or Unclear Detail And All Fastening Systems For All Elements Shall be Approved by The Supervisor.

Legend:

REVISIONS		
NO.	DRAWINGS	DATE
(1)		
(2)		
(3)		

Contracting Authority:



Funded By:



Project Title:

“Public Works Contract for the rehabilitation of 5 schools in East Jerusalem”

Reference number: PSE22001-10074

Lot 1: the rehabilitation of Al-Hasan Al-Thany, Al-Shabbat Al-Shameleh, and Al-Fata Al-Laji’a schools in Wadi Al-Joz

Al-Fata Al-Laji'a A Secondary Girls' School

Designed by:



Jerusalem - Sheikh Jarrah- Tobler8
email: mr.wasimhija@gmail.com

Tel. 02-9948344/ 052-8327076
Fax: 02-9948344

Drawing Title	Scope of Intervention	Date: 25/3/2025
		Scale: 1:100
Designed by:	Eng. Adli Naser Al-Deen	Drawing No: E06
Checked by:	Eng. Adli Naser Al-Deen	
Approved by:		
Coordinate Manager:		